

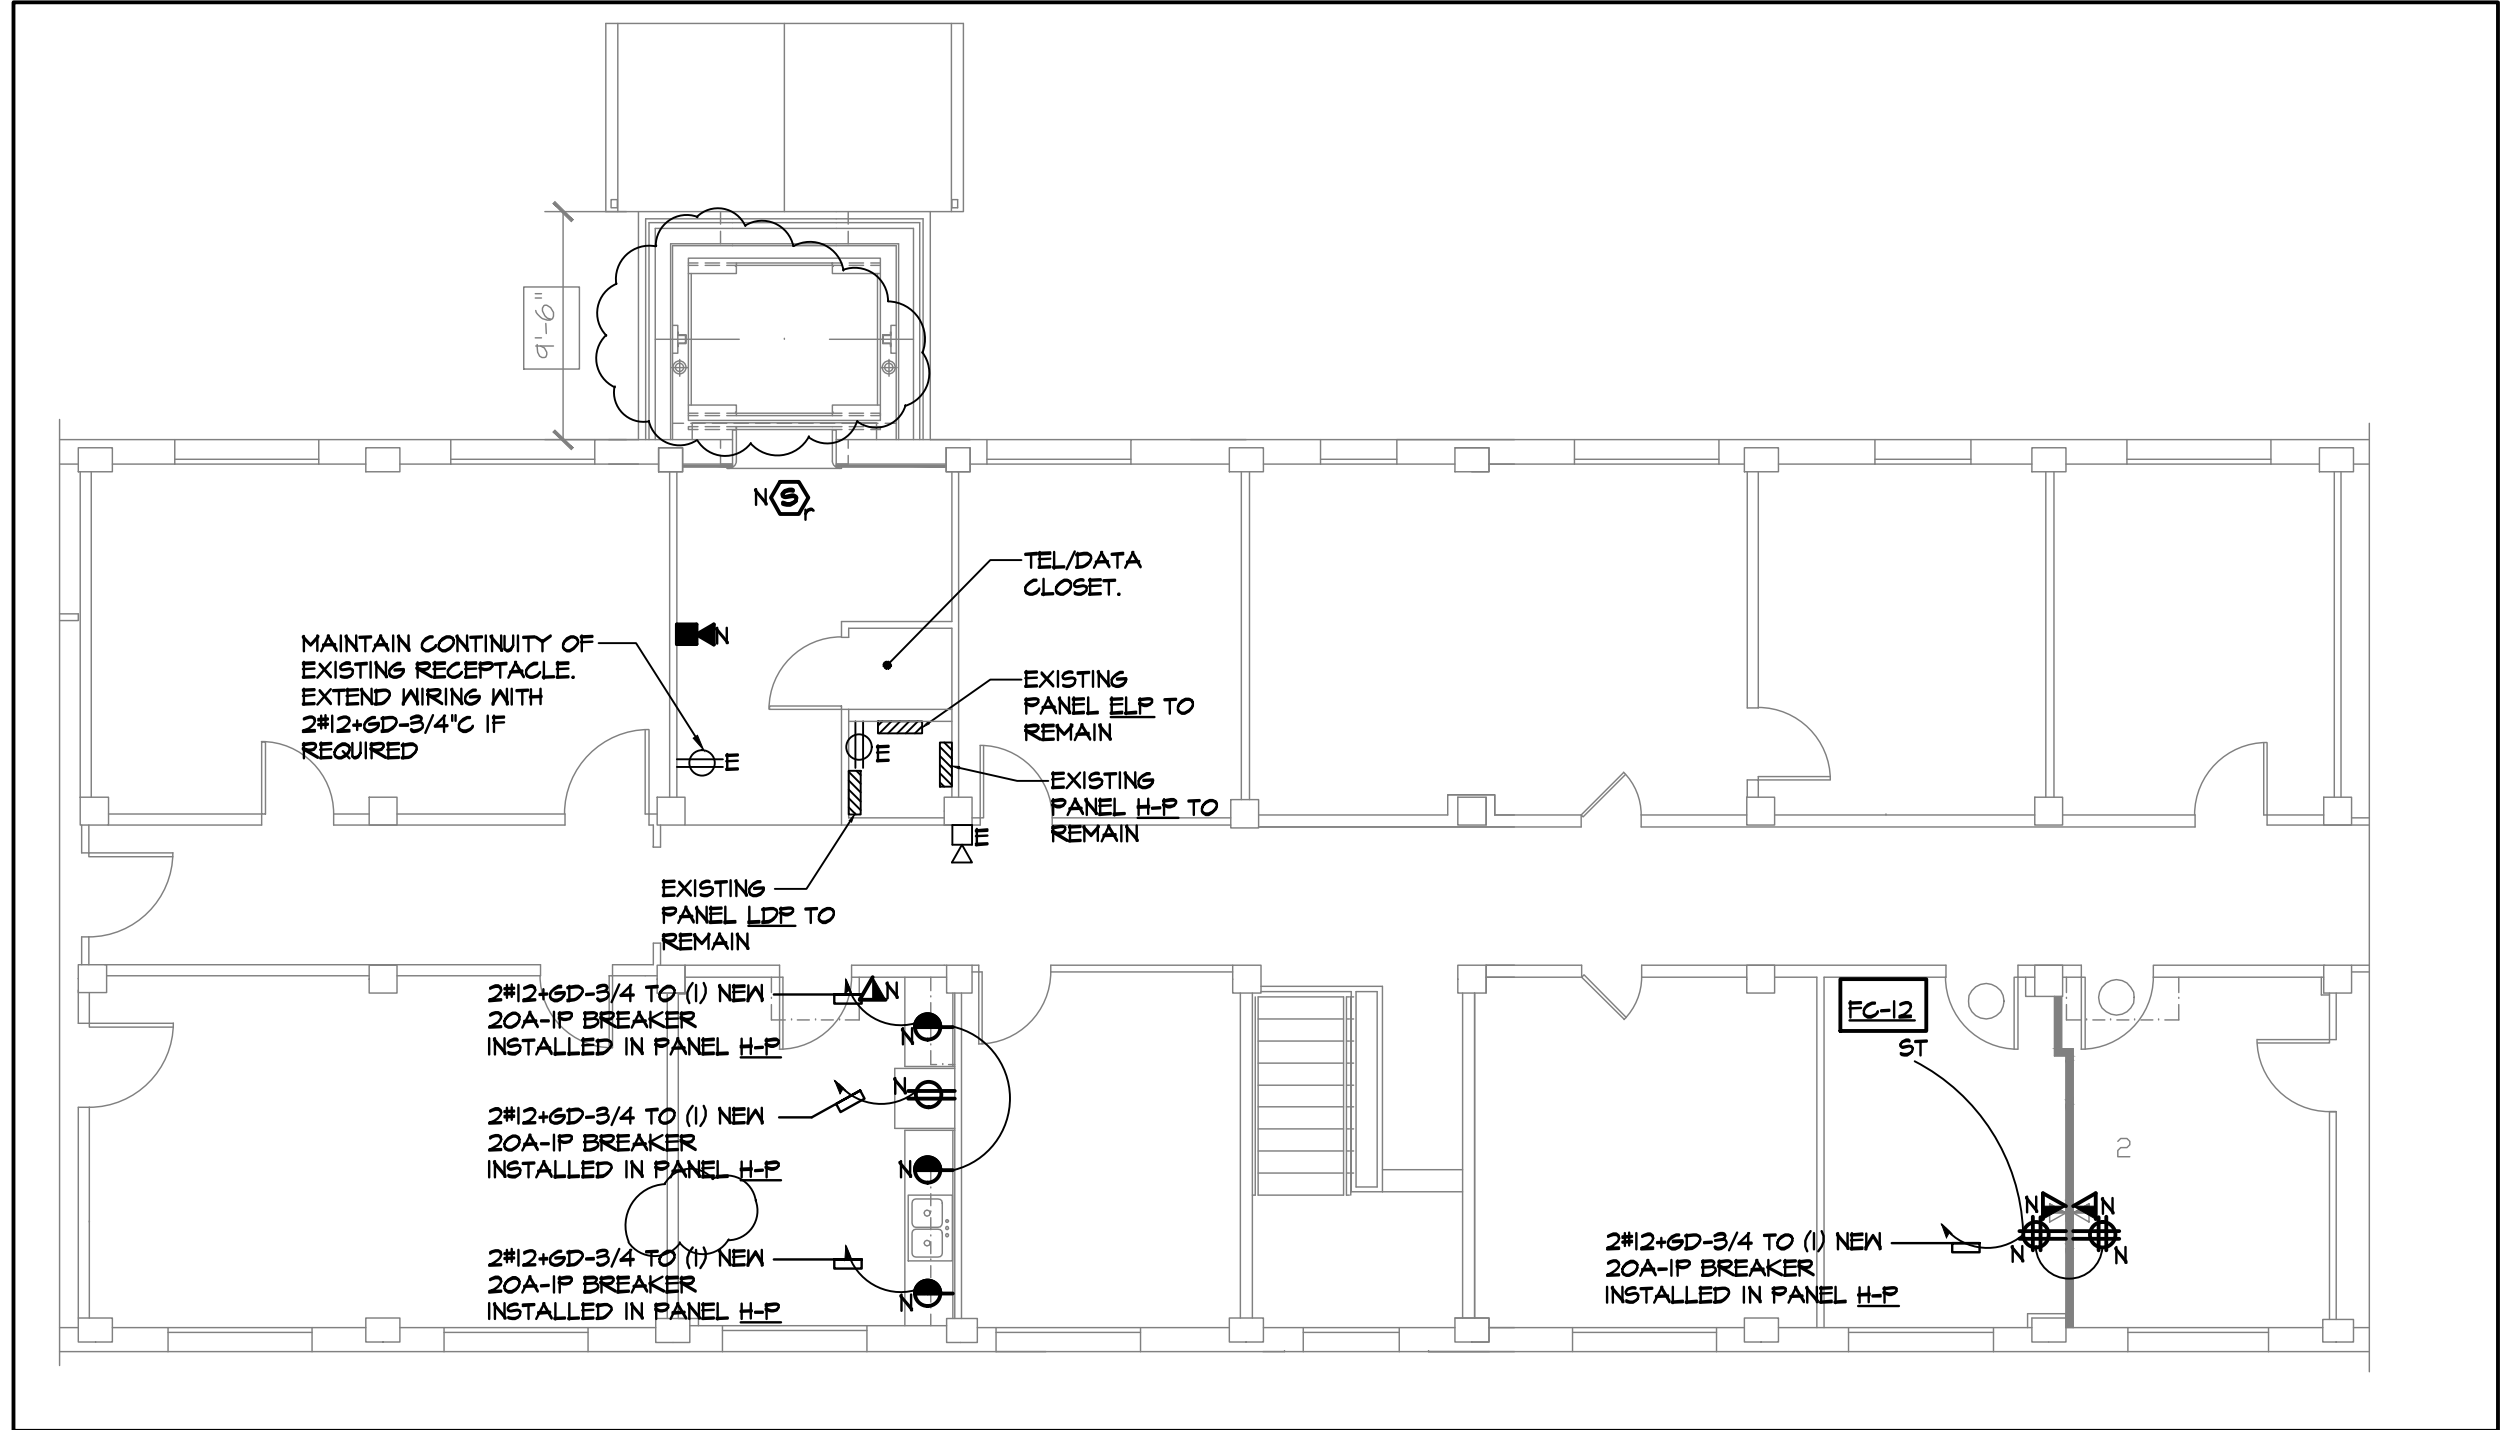
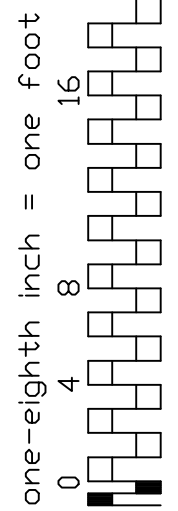
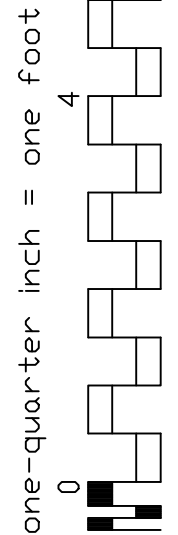
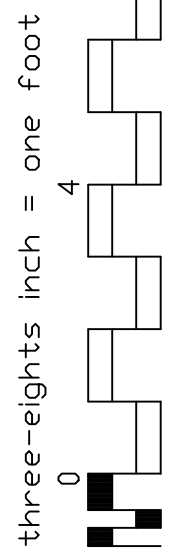
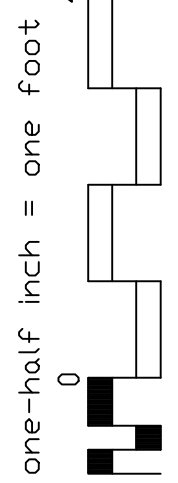
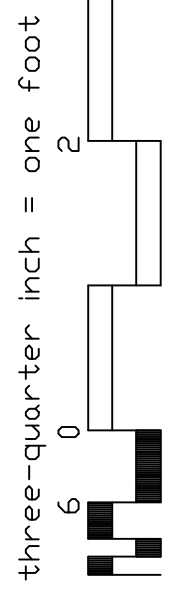



IF THIS SHEET IS NOT 30" x 42"
FULL SIZE, USE GRAPHIC SCALES

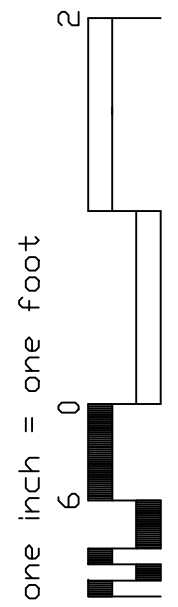


1 SECOND FLOOR ELECTRICAL POWER PLAN
SCALE = 1/8"=1'-0"

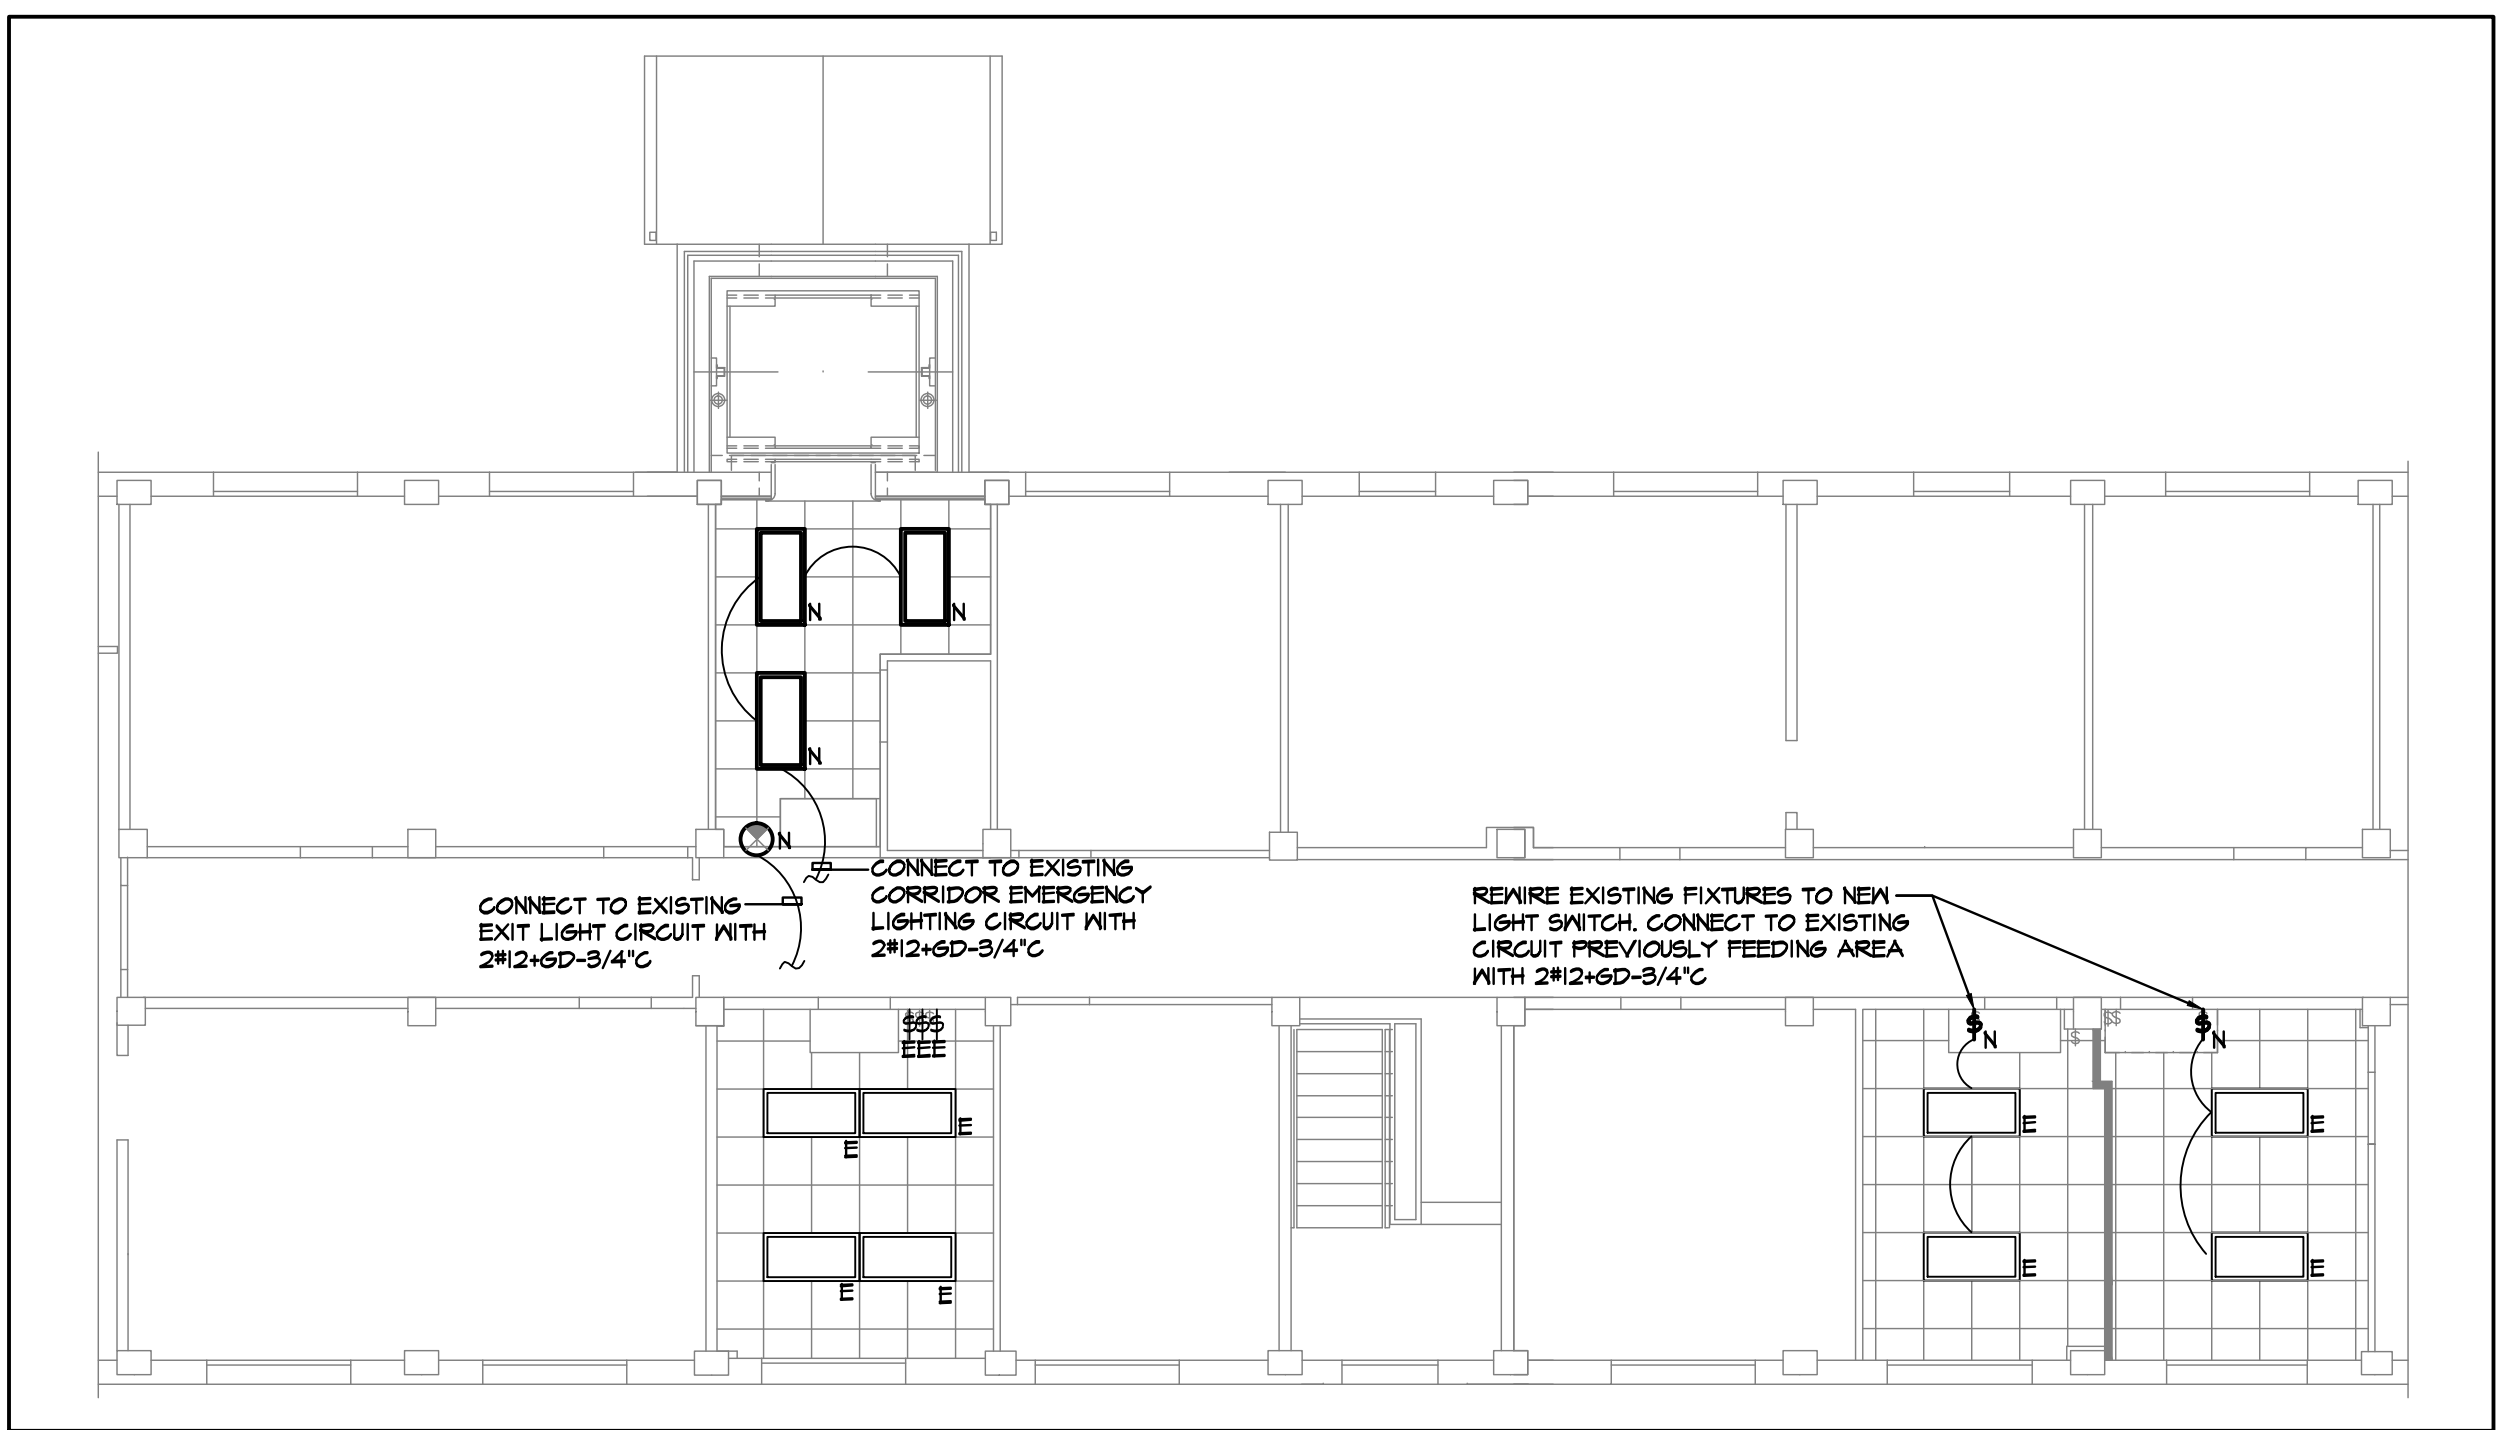


4 SECOND FLOOR ELECTRICAL LIGHTING PLAN
SCALE = 1/8"=1'-0"

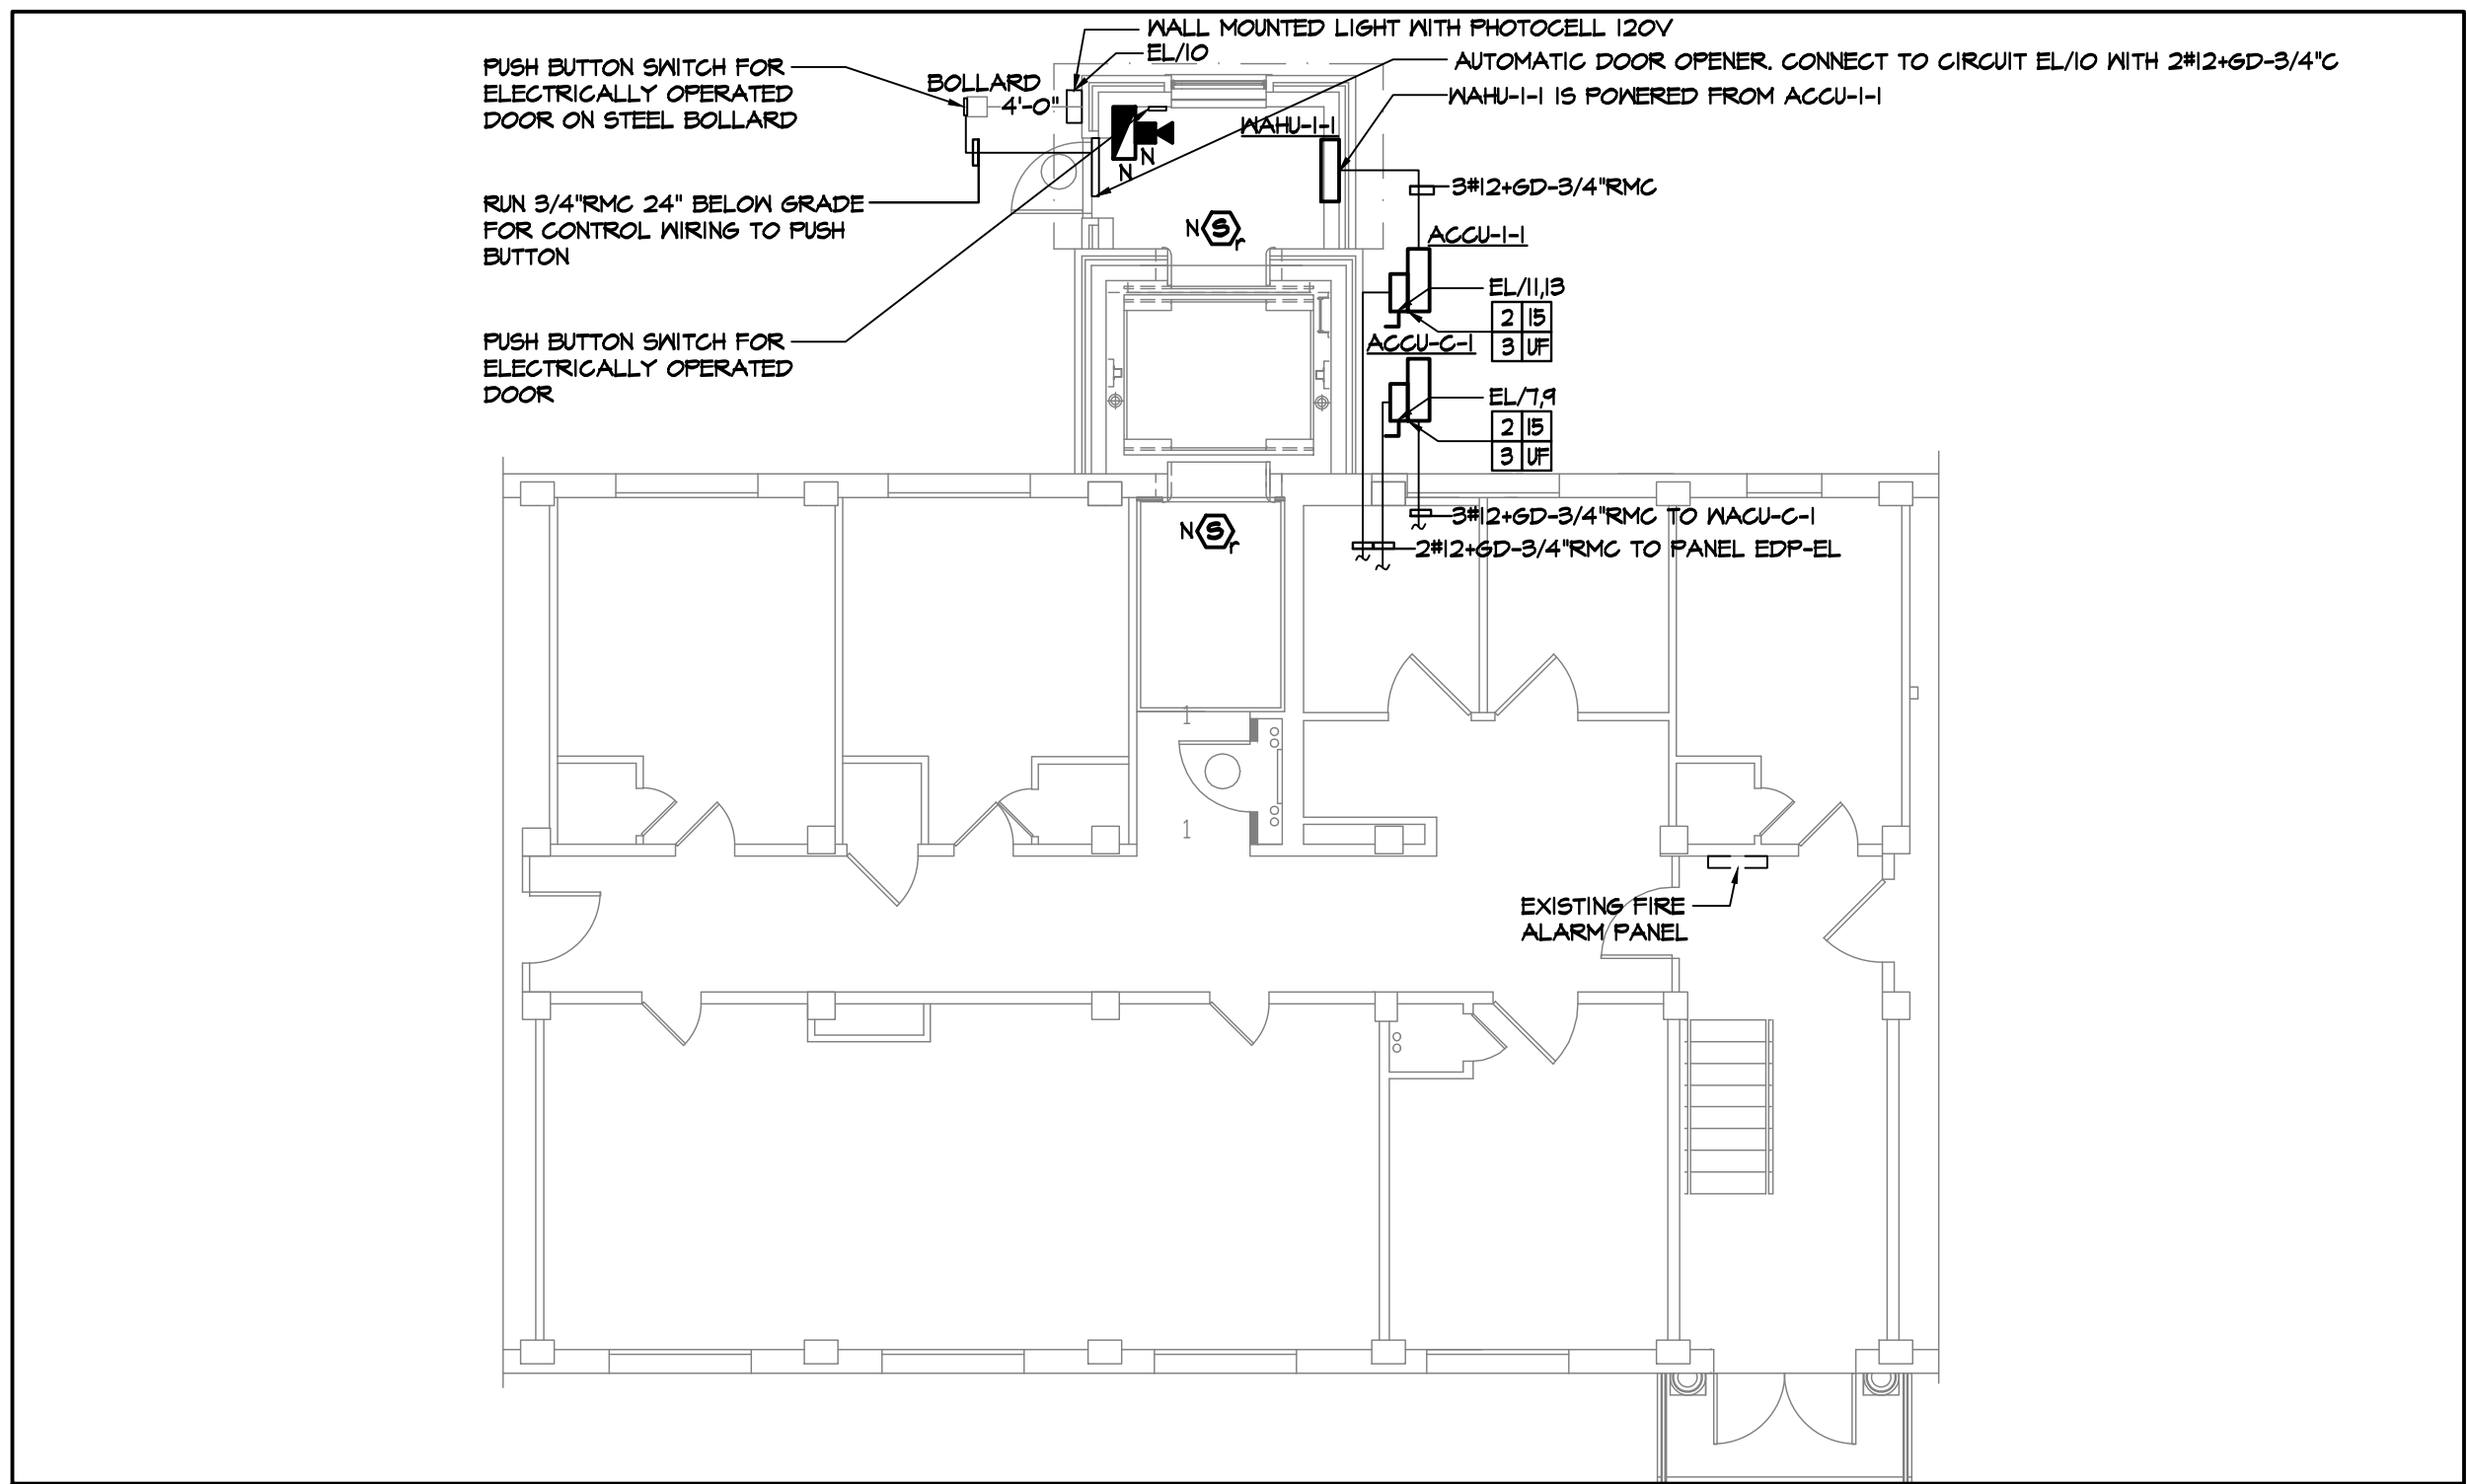


2 FIRST FLOOR ELECTRICAL POWER PLAN
SCALE = 1/8"=1'-0"

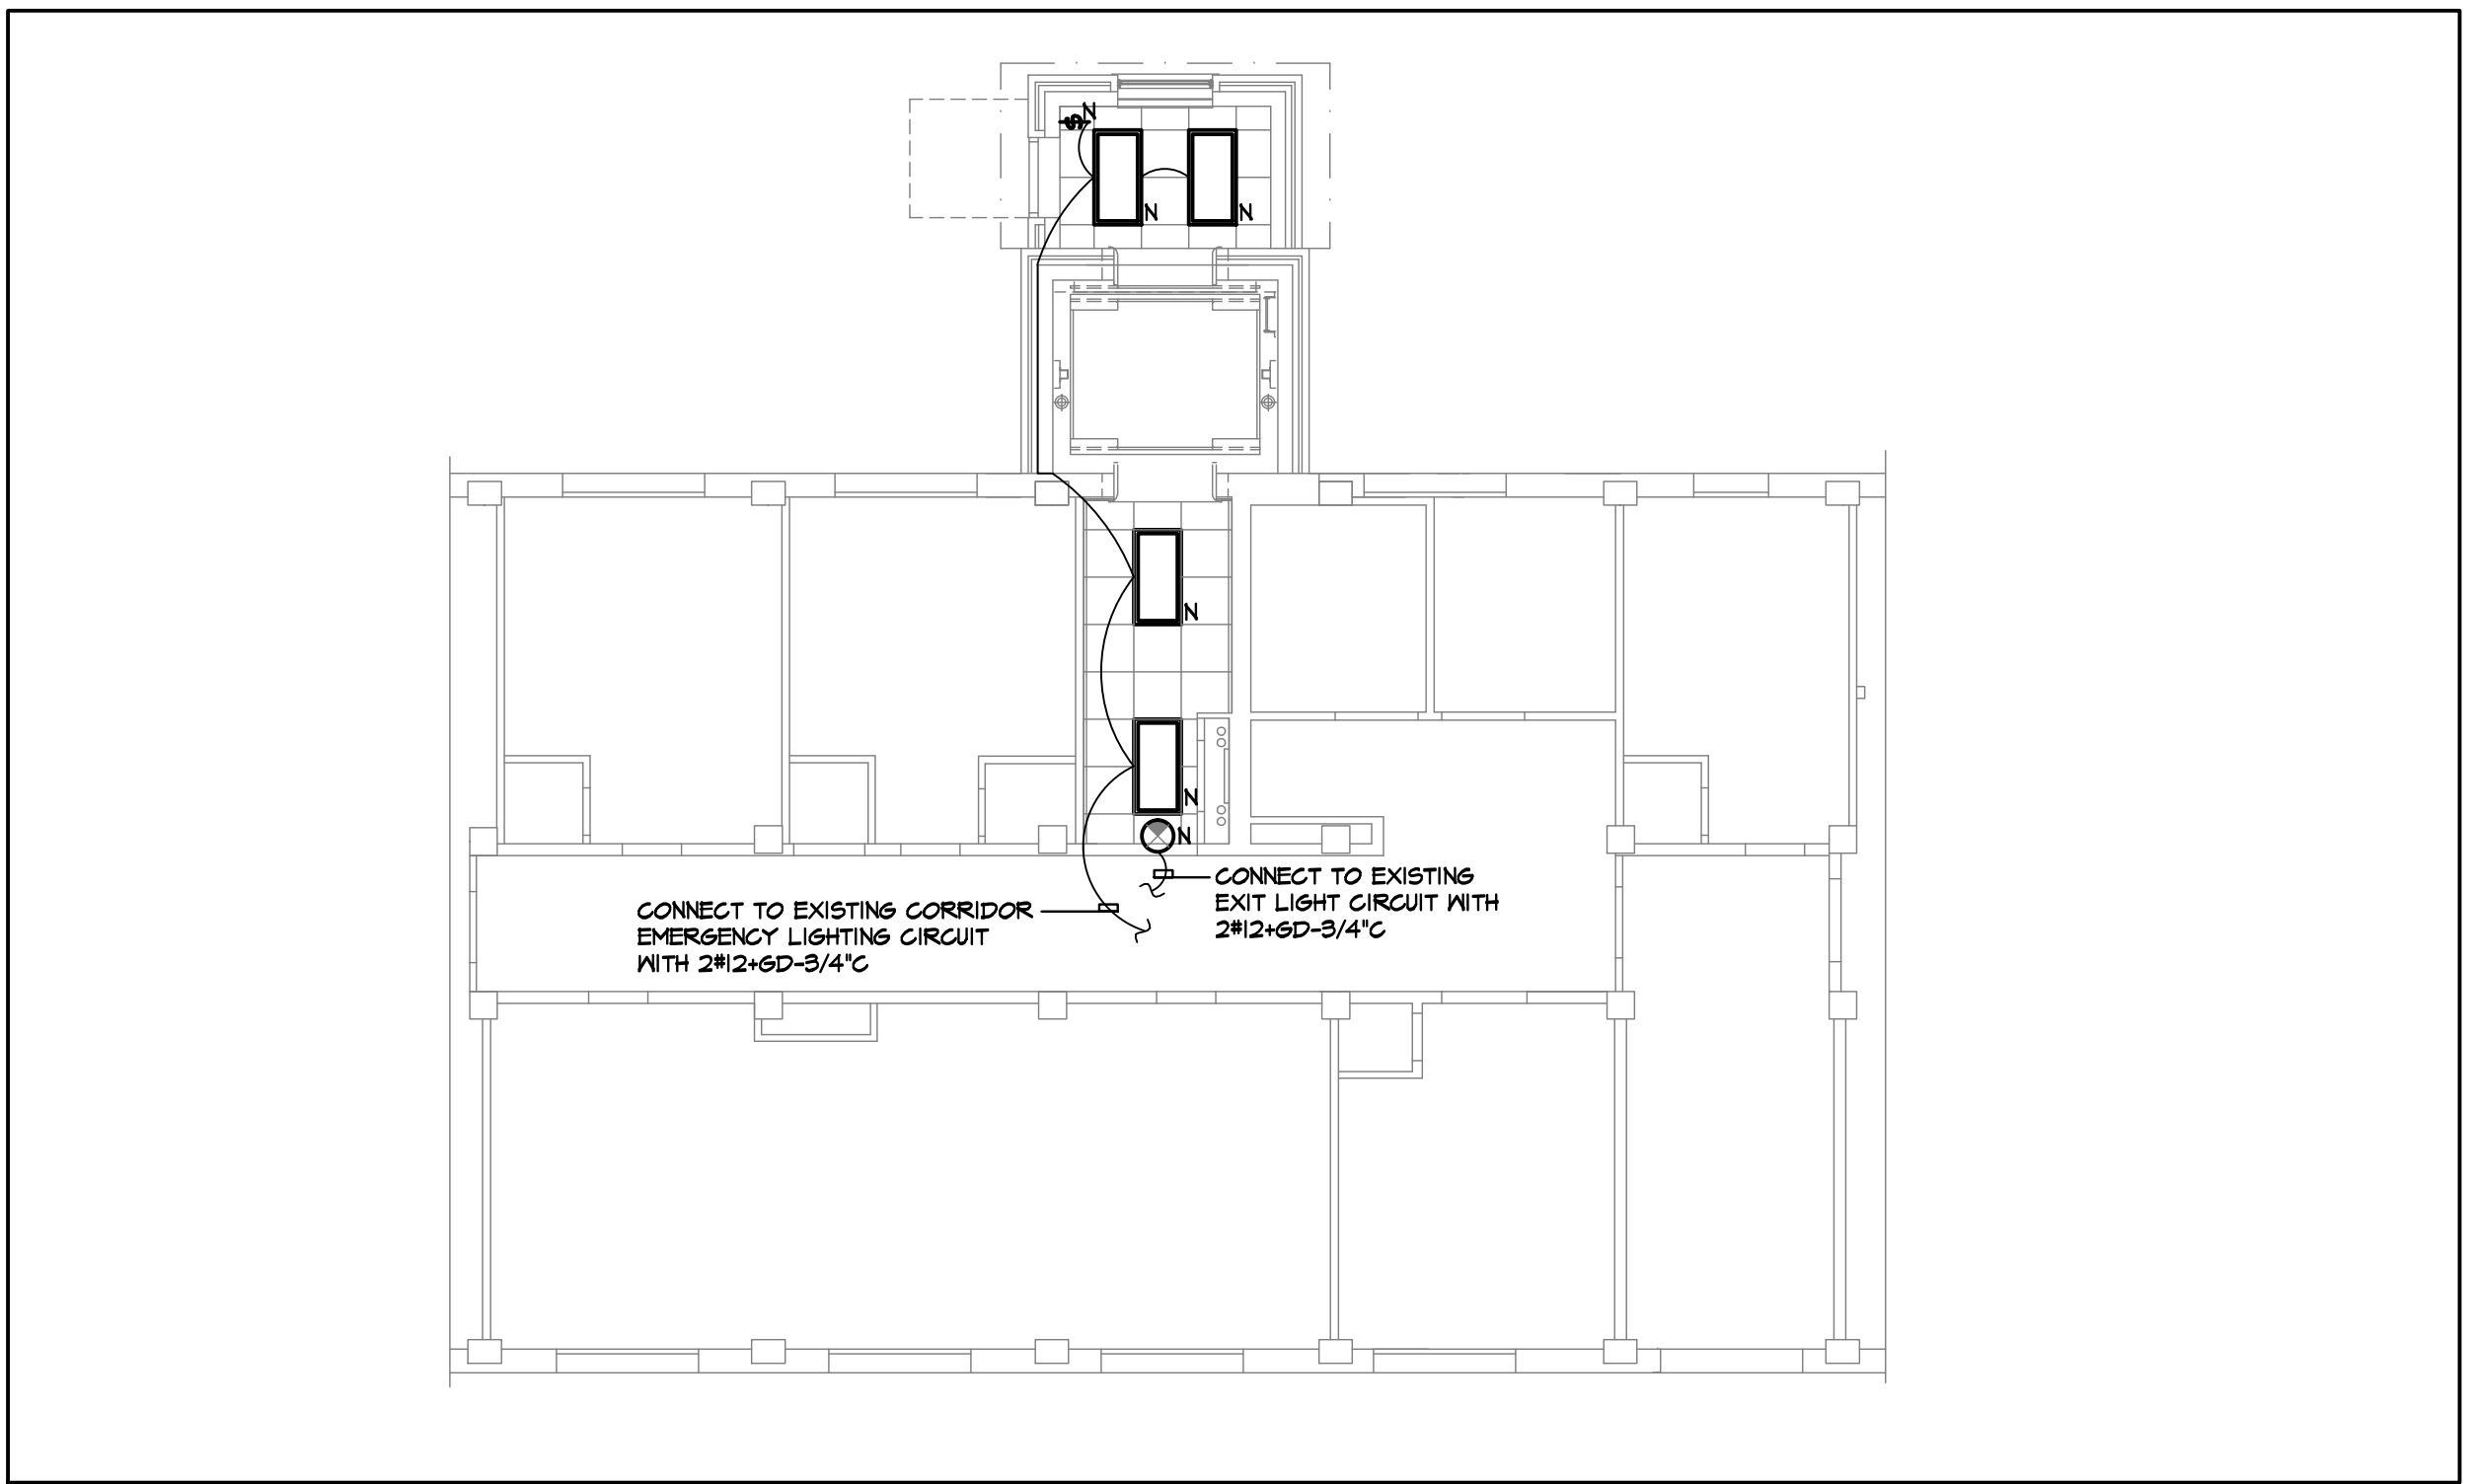

5 FIRST FLOOR ELECTRICAL LIGHTING PLAN
SCALE = 1/8"=1'-0"

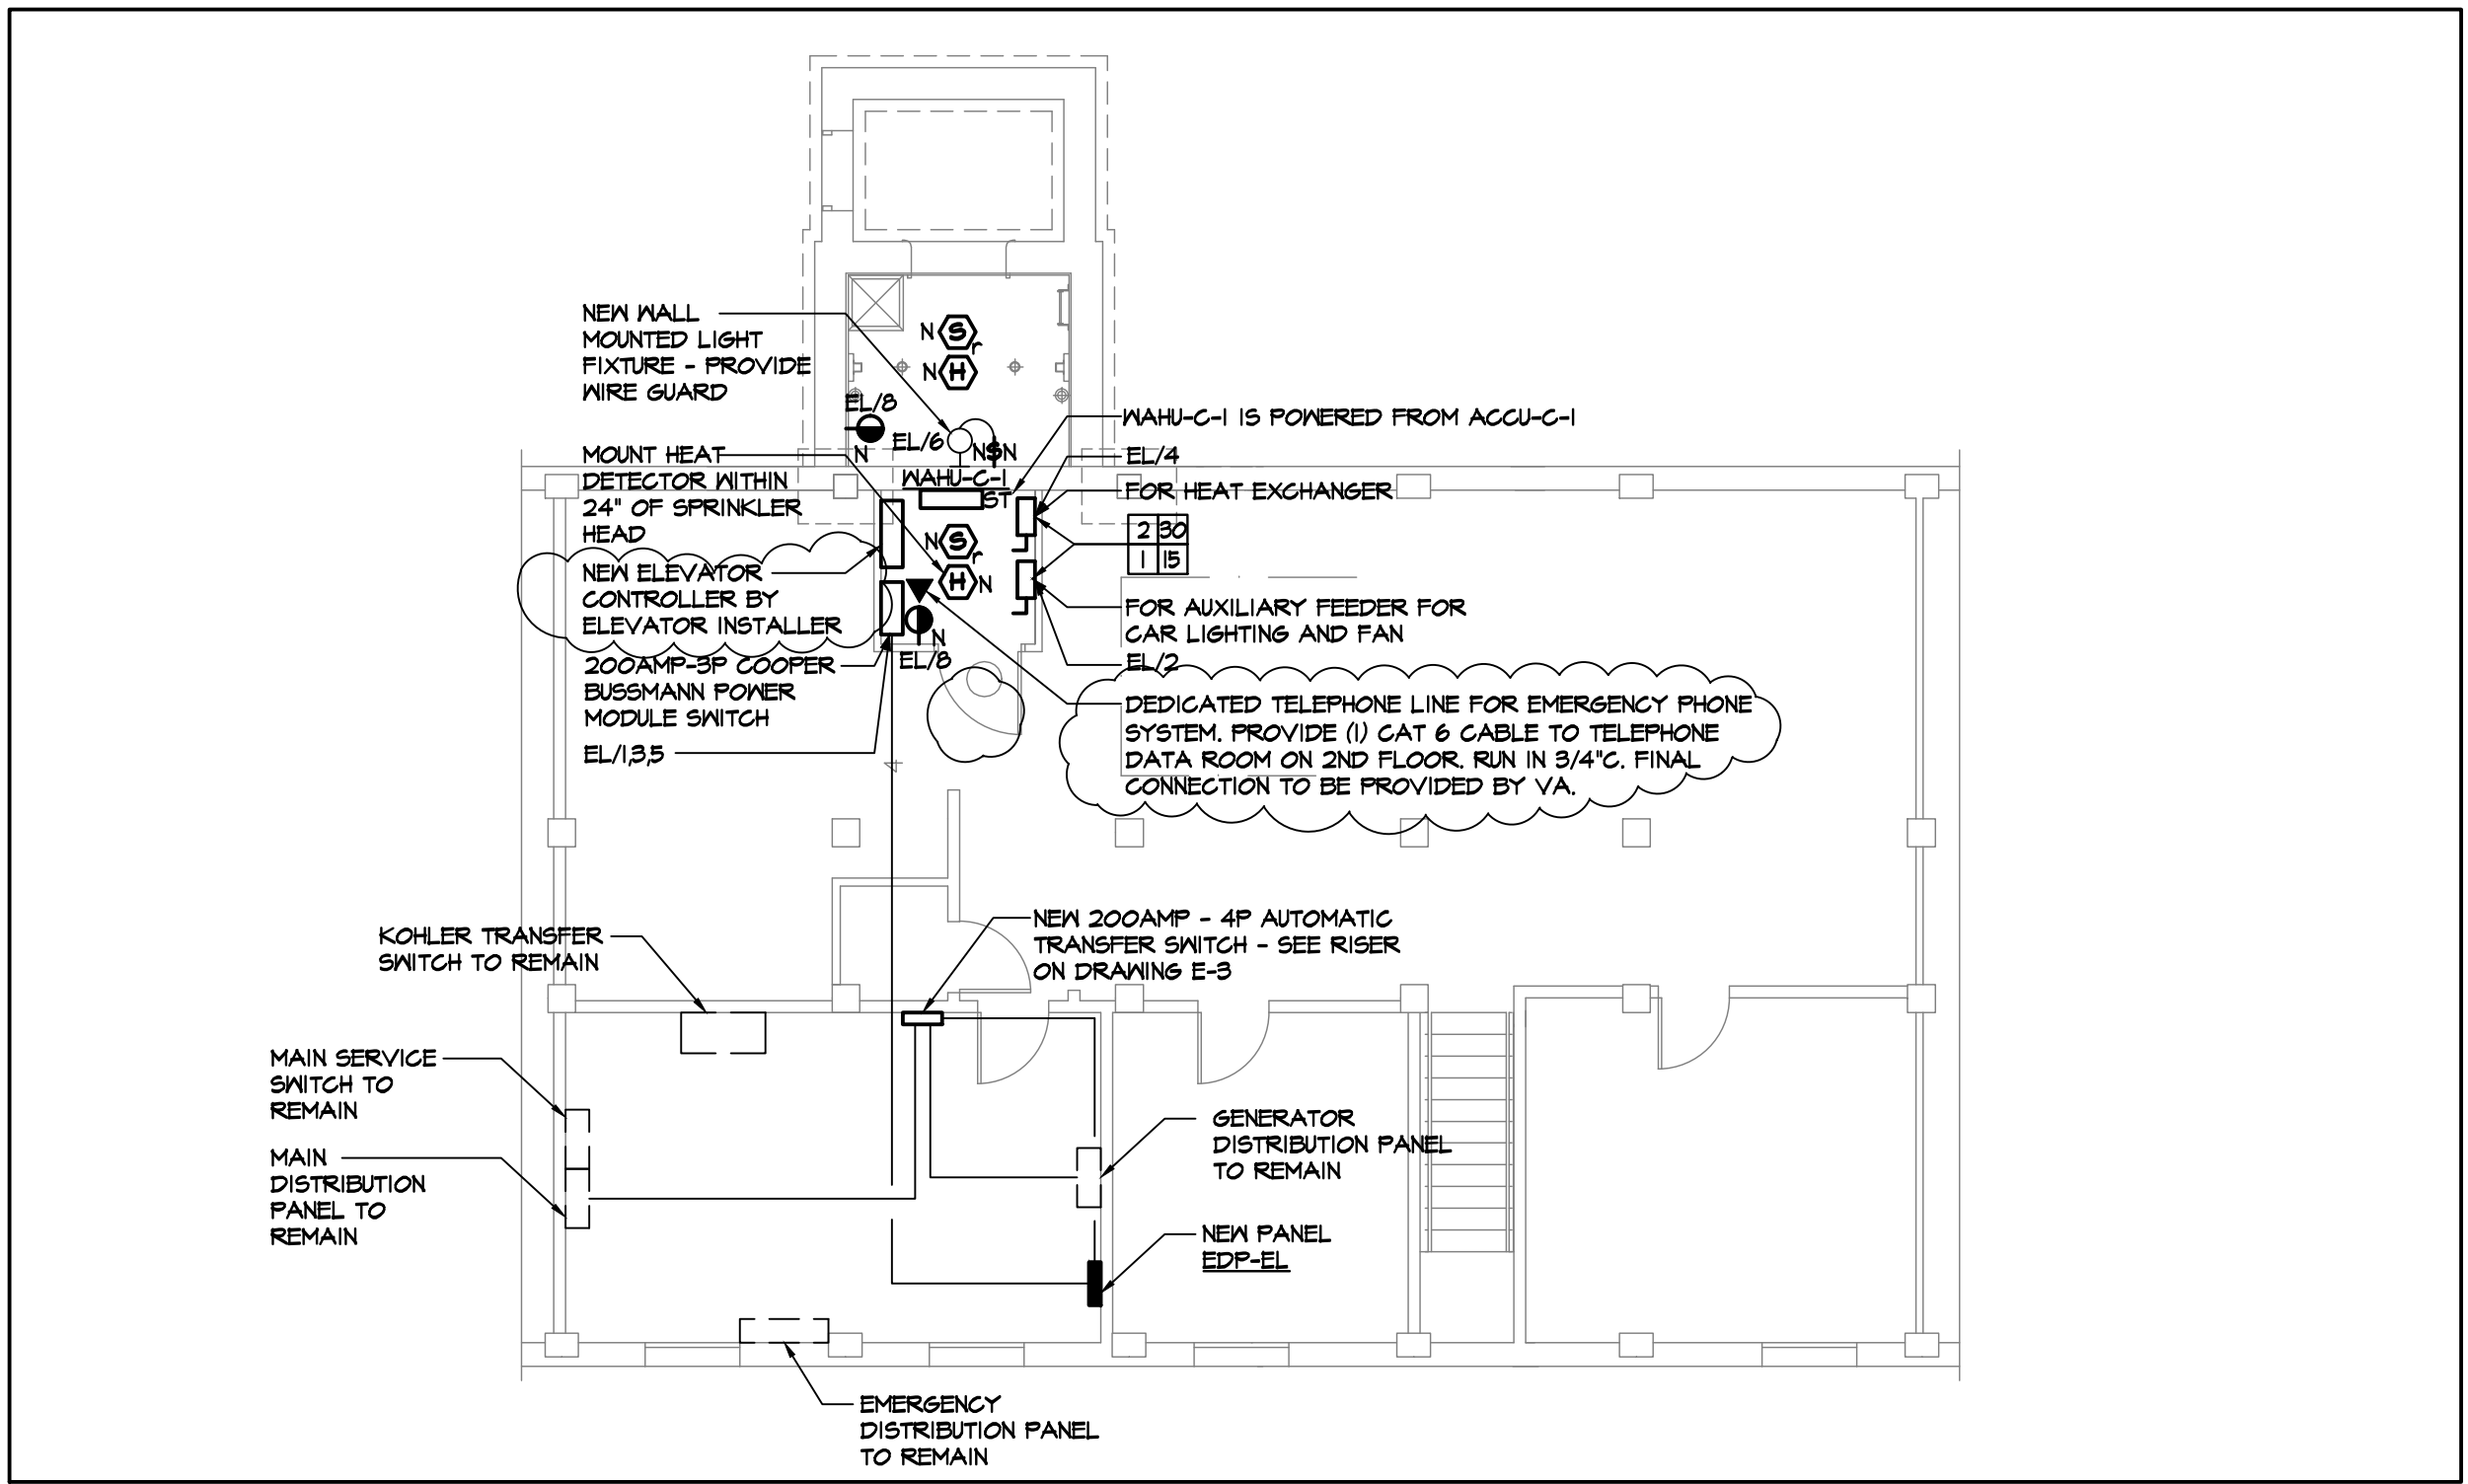

3 BASEMENT ELECTRICAL POWER PLAN
SCALE = 1/8"=1'-0"

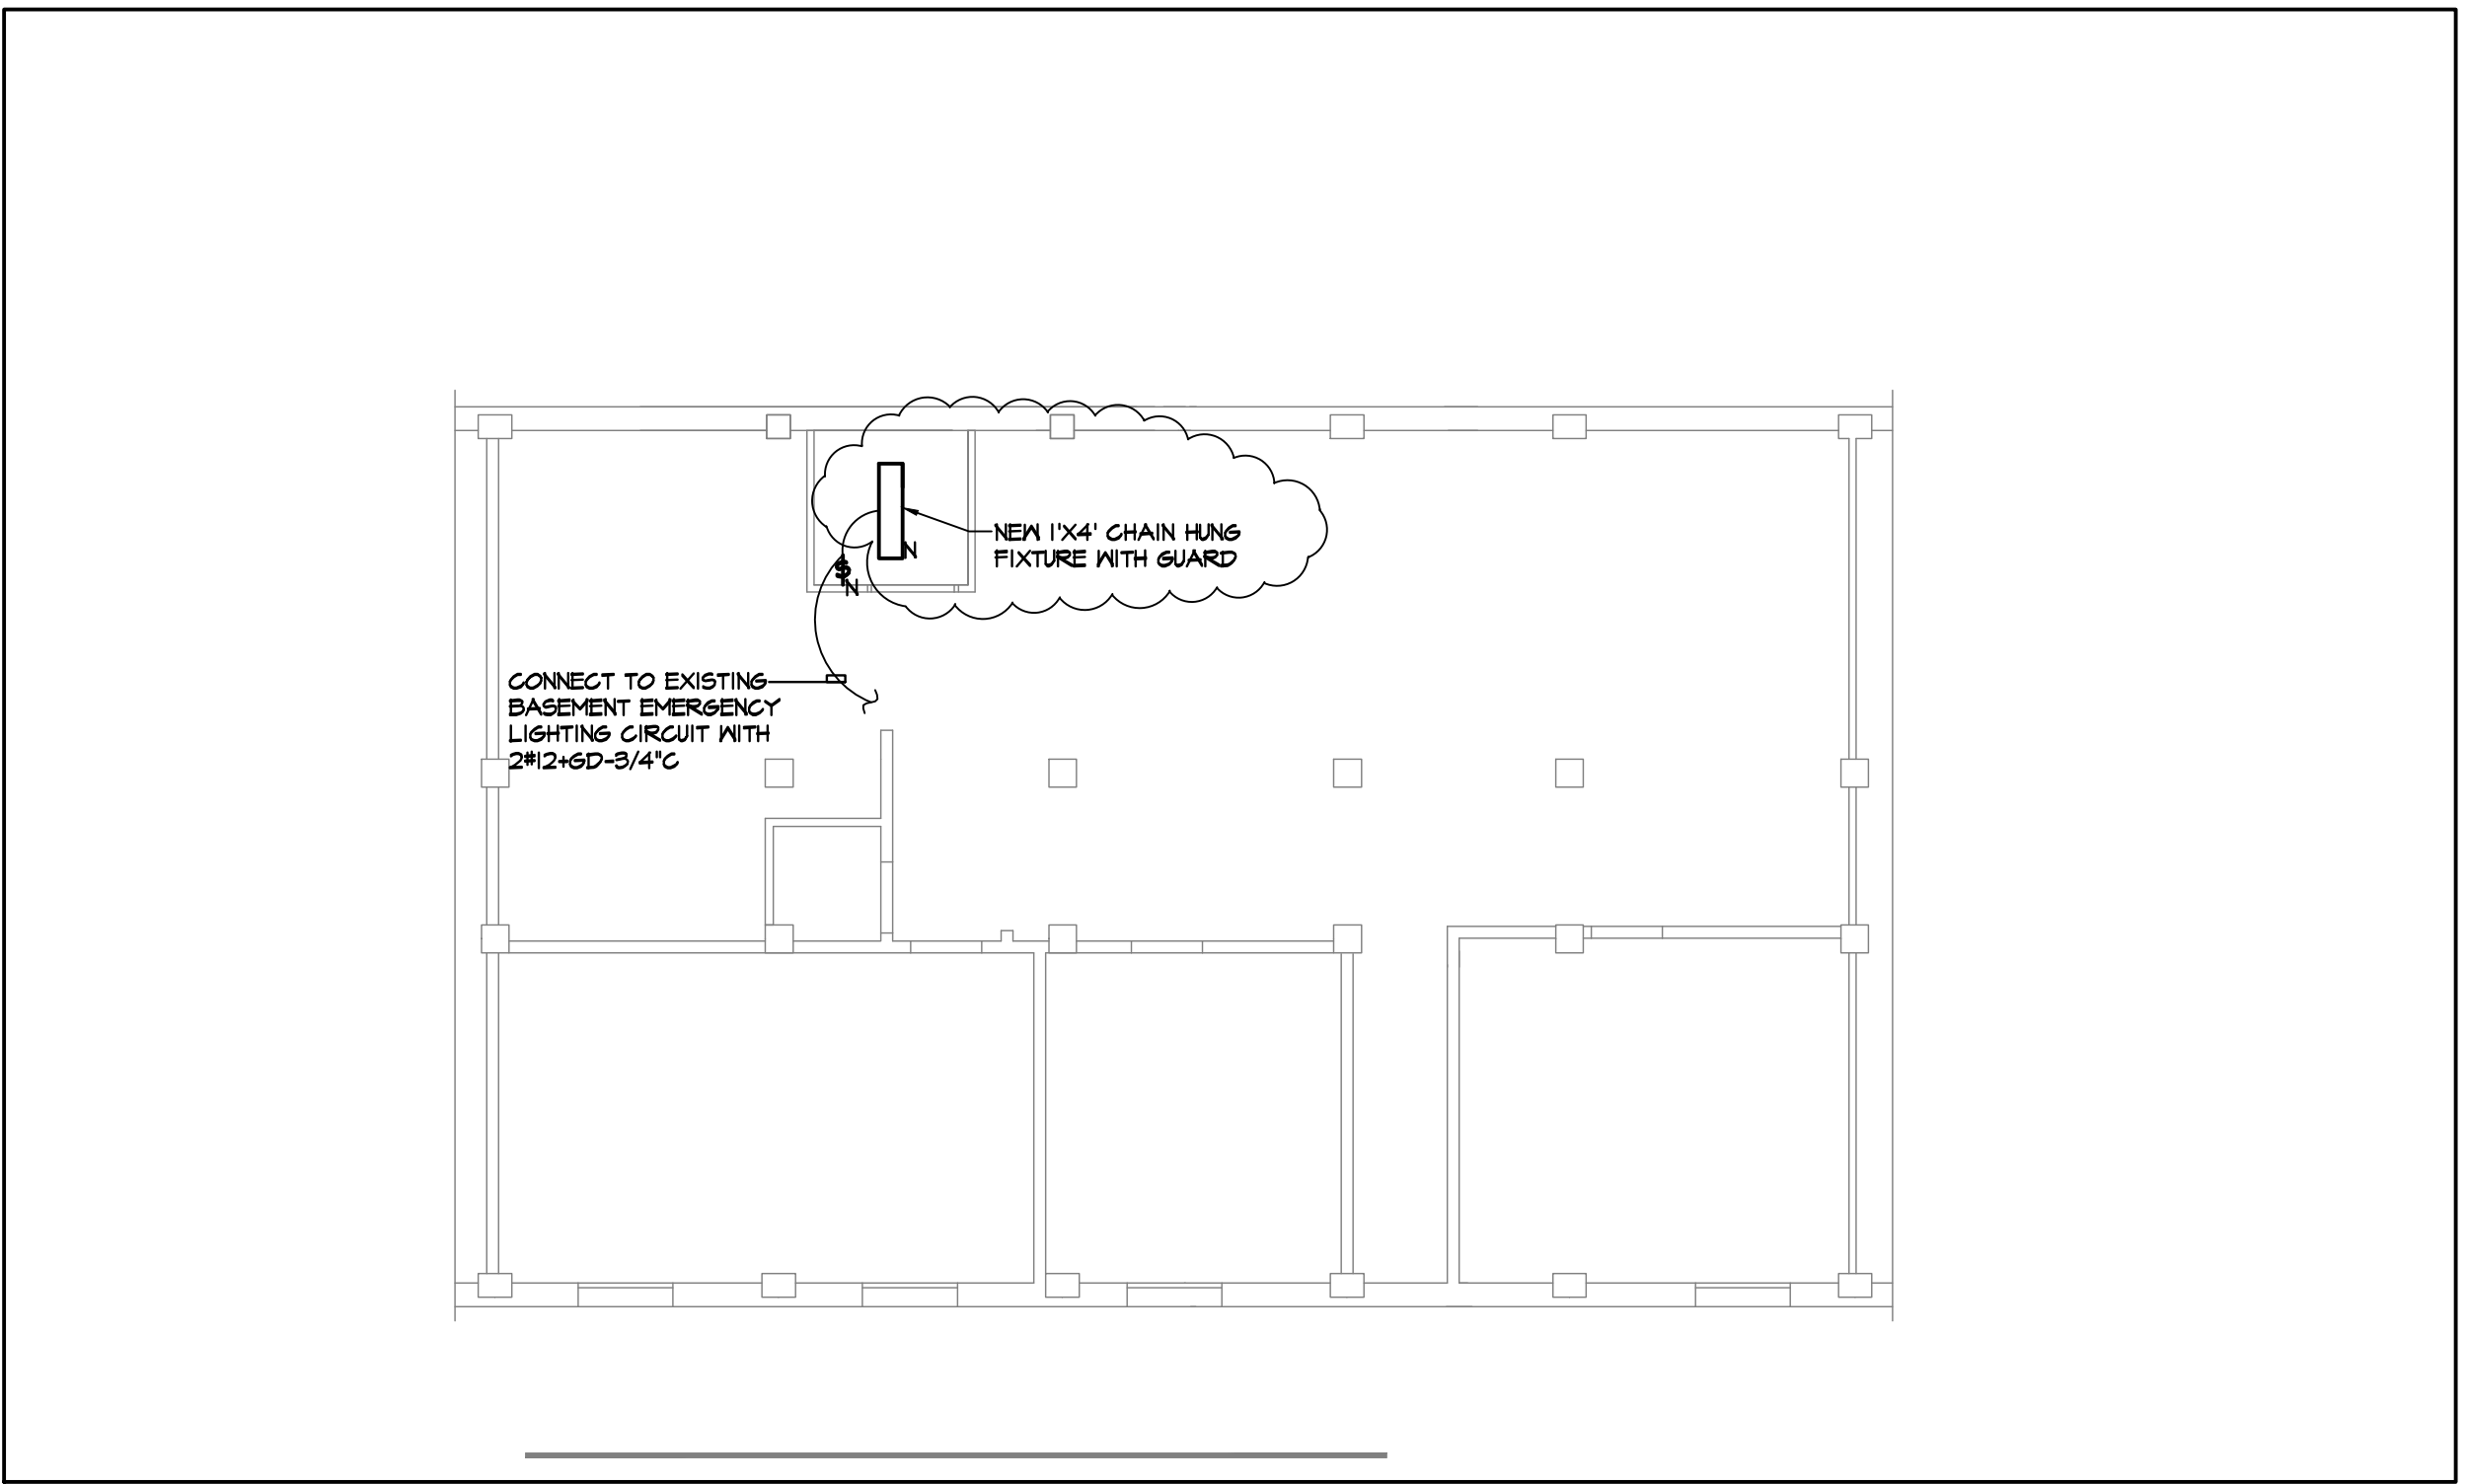

6 BASEMENT ELECTRICAL LIGHTING PLAN
SCALE = 1/8"=1'-0"

SYMBOL LIST	
	MOTOR (INSCRIBED NUMBER INDICATES HORSEPOWER)
	MANUAL MOTOR STARTER 30A-600V
	DATA TELEPHONE OUTLET WITH 1" STUD UP PROVIDE (2) CAT5E CABLES
	KEYED NOTE
	JUNCTION BOX
	DUPLEX RECEPTACLE 20A-2P-125V
	SIMPLEX RECEPTACLE 20A-2P-125V
	DUPLEX RECEPTACLE 20A-1P-125V WITH GROUND FAULT PROTECTION
	DOUBLE DUPLEX RECEPTACLE 20A-125V
	WIRING RUN CONCEALED
	NEW HOMERUN TO PANELBOARD
	PANELBOARD (EXISTING)
	PANELBOARD (NEW)
	MOTOR STARTER
	SWITCH
	EXIT SIGN
	COMBINATION HORN/STROBE MTD. @ 80" A.F.F.
	MANUAL PULLSTATION
	STROBE MTD. @ 80" A.F.F.
	HEAT DETECTOR
	SMOKE DETECTOR - "Y" INDICATES ELEVATOR RECALL
	NEXT TO SYMBOL INDICATES EXISTING TO REMAIN
	NEXT TO SYMBOL INDICATES NEW LOCATION OF EXISTING
	NEXT TO SYMBOL INDICATES NEW
	DISCONNECT SWITCH
	SWITCH SIZE
	FUSE SIZE (NF IF UNFUSED)

NOTE:

- LABEL ALL ELEVATOR RECALL SMOKE DETECTORS "ELEVATOR RECALL SMOKE DETECTORS" LABEL WITH P-TOUCH LABEL OR EQUAL
- LABEL SHUNT HEAT DETECTOR "SHUNT HEAT DETECTOR" LABEL WITH P-TOUCH LABEL OR EQUAL

EMTG
Consulting Engineers
TEL: 212-268-6465 FAX: 212-268-6467
115 WEST 30TH ST. SUITE 202., NEW YORK, NY 10001

Kenneth Irving, Architect P.C.
MEMORIAL PLAZA SUITE 301, PLEASANTVILLE, N.Y. 10570
PHONE: (914) 747-0002 E-MAIL: kirmndrae@kirsch.com FAX: (914) 747-9211

NOTE AND READ CAREFULLY:
The Contractor shall consult and study the requirements of each and every drawing and each specification section of this contract so that he/she may become acquainted with the project as a whole in order to determine how the work of his/hers subcontractor or vendor may affect the work required under this contract.
Written Specifications are part of this contract

Drawing Title
ELECTRICAL POWER AND LIGHTING PLANS

Approved: Division Chief
Approved: Service Director

Project Title
PROVIDE HANDICAP ACCESS BUILDING 10
VANJHCS LYONS CAMPUS
Lyons, NJ. 07939

Building Number
10
Checked
SL
Drawn
DH,WS,VT
Location
Lyons, New Jersey

Date
4/5/2013
Project No.
561A4-10-102
DRAWING NO.
EP102
Dwg. 23 OF 24

