


 
2 WEST ELEVATION
SKE0.4 SCALE: 1/16" = 1'-0"



1 ELECTRICAL SITE PLAN
SKE0.4 SCALE: 1" = 20'-0"

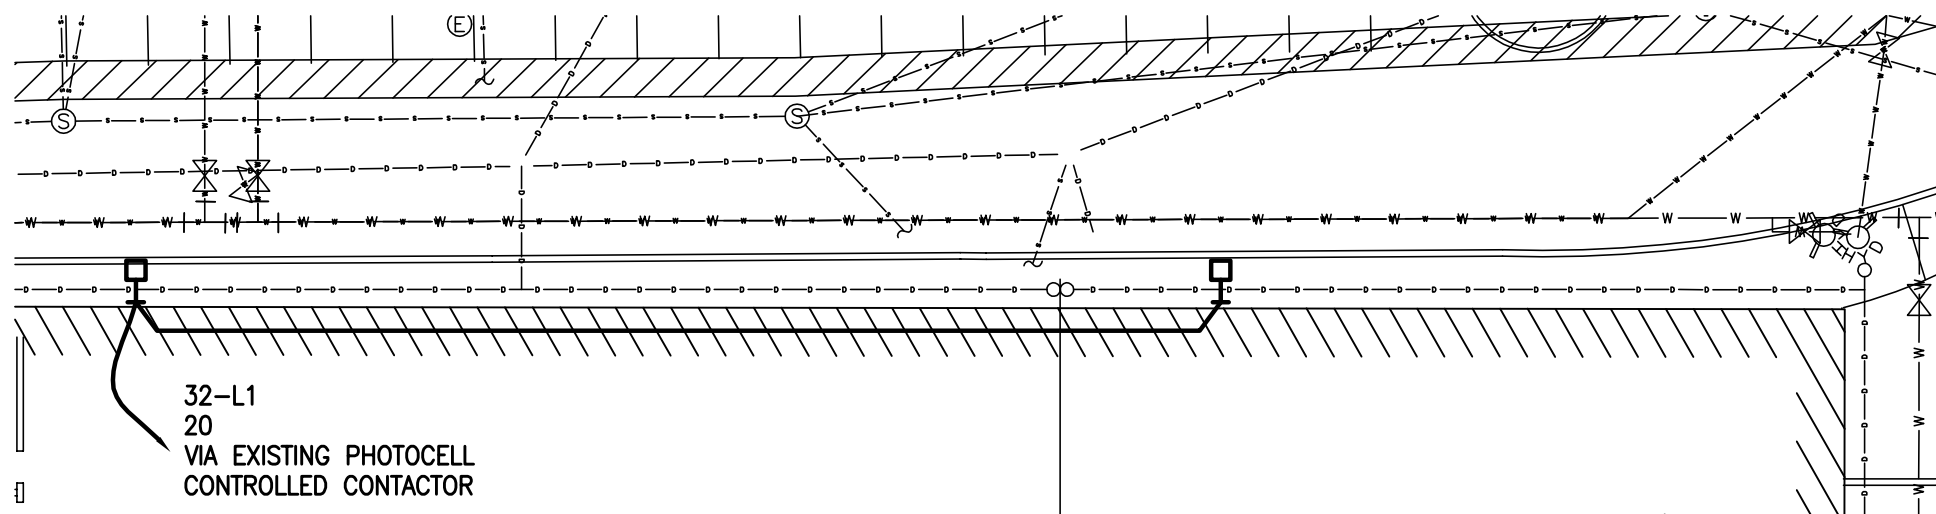

EXTERIOR WALL MOUNTED AREA LUMINAIRE, GARDCO CATALOG #G18-1-2XL-250PSMH-277

<div></div> <div><p>Pennoni Associates Inc. Engineers • Surveyors • Planners Landscape Architects</p><p>One Drexel Plaza 3001 Market Street, Suite 200 • Philadelphia, PA 19104 T 215.222.3000 • F 215.222.3588</p></div>	<p>ALL DOCUMENTS PREPARED BY PENNONI ASSOCIATES ARE INSTRUMENTS OF SERVICE IN RESPECT OF THE PROJECT. THEY ARE NOT INTENDED OR REPRESENTED TO BE SUITABLE FOR REUSE BY OWNER OR OTHERS ON EXTENSIONS OF THE PROJECT OR ON ANY OTHER PROJECT. ANY REUSE WITHOUT WRITTEN VERIFICATION OR ADAPTATION BY PENNONI ASSOCIATES FOR THE SPECIFIC PURPOSE INTENDED WILL BE AT OWNERS SOLE RISK AND WITHOUT LIABILITY OR LEGAL EXPOSURE TO PENNONI ASSOCIATES; AND OWNER SHALL INDEMNIFY AND HOLD HARMLESS PENNONI ASSOCIATES FROM ALL CLAIMS, DAMAGES, LOSSES AND EXPENSES ARISING OUT OF OR RESULTING THEREFROM</p>	DRAWN BY: BA	SCALE: AS NOTED	DATE: 06/25/13
		CHECKED BY: CWT	TAX MAP No.	
		JOB No. THAI0901	SKETCH No.	
		Veterans Affairs Medical Center - Expand Parking Garage Phase II		
WALL MOUNTED LIGHTING			SKE0.4	