

SERVICED BY RTU-1 (LOCATED ON 2ND FLOOR ROOF)


SERVICED BY AHU #13

SERVICED BY AHU #2A (LOCATED IN BASEMENT)

SERVICED BY AHU #3A (LOCATED IN BASEMENT)

SERVICED BY AHU #8A (LOCATED ON 2ND FLOOR)

SERVICED BY AHU #40

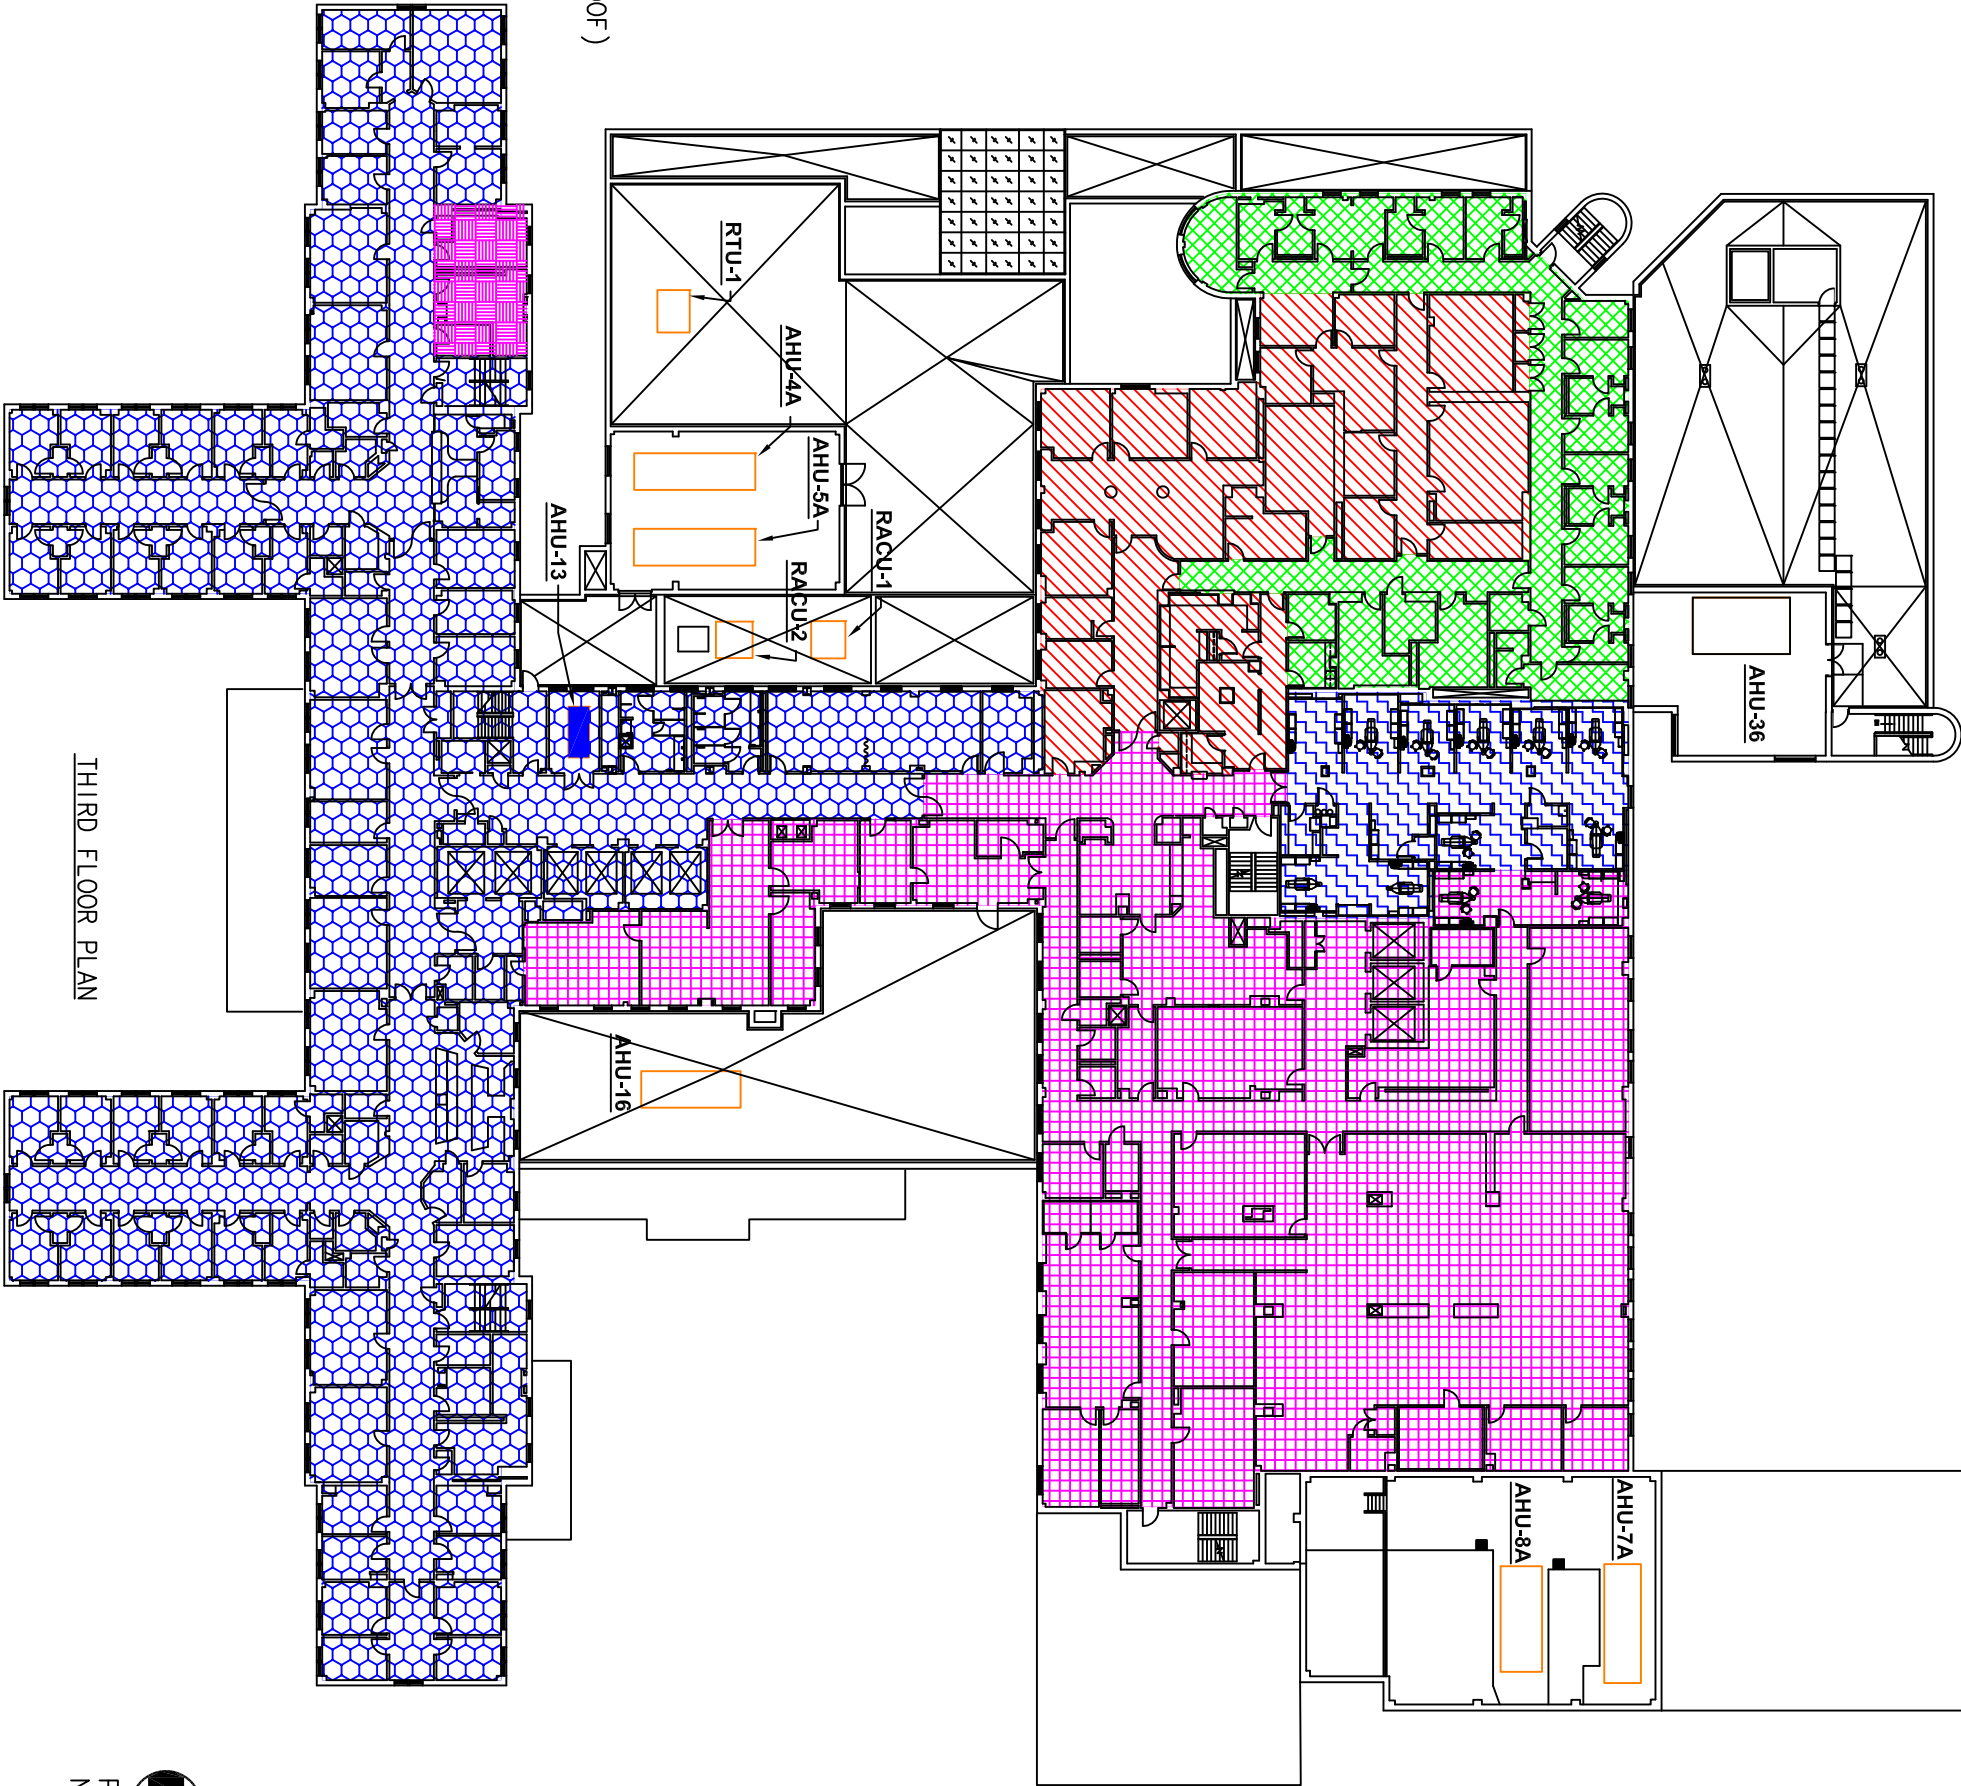

THIRD FLOOR PLAN



PROJECT :	VA MEDICAL CENTER	REVISED DATE :	01-20-12
	LOUISVILLE, KY		
	HVAC & ELECTRICAL STUDY – 3RD FLOOR PLAN		
COMM. #	74340	DATE :	03-25-05
DRAWN BY :	RJT	CHK'D BY :	

DWG. # SK-7

REFERENCE :

[smart design]

Luckett & Farley

© 2008

737 South Third Street, Louisville,
502-585-4181 502-587-0488 Fax

Master Planning | Architecture | Engineering
Design Build | Building Commissioning

1853