


GENERAL NOTES: (APPLY TO THIS SHEET ONLY)

1. ALL LIGHTING FIXTURES SHOWN ON THIS SHEET SHALL BE THE LATEST LISTED EQUIPMENT.

KEYNOTES:

① EXTEND & CONNECT TO TYPE 'L' FIXTURE ON LEVEL BELOW.
② EXTEND & CONNECT TO TYPE 'L' FIXTURE ON LEVEL ABOVE.
③ FIXTURE SHALL BE MOUNTED VERTICALLY.
④ EXTEND & CONNECT TO TYPE 'CZ' FIXTURE ON LEVEL ABOVE.
⑤ FIXTURE SHALL HAVE SLOPED BELING ADAPTER.

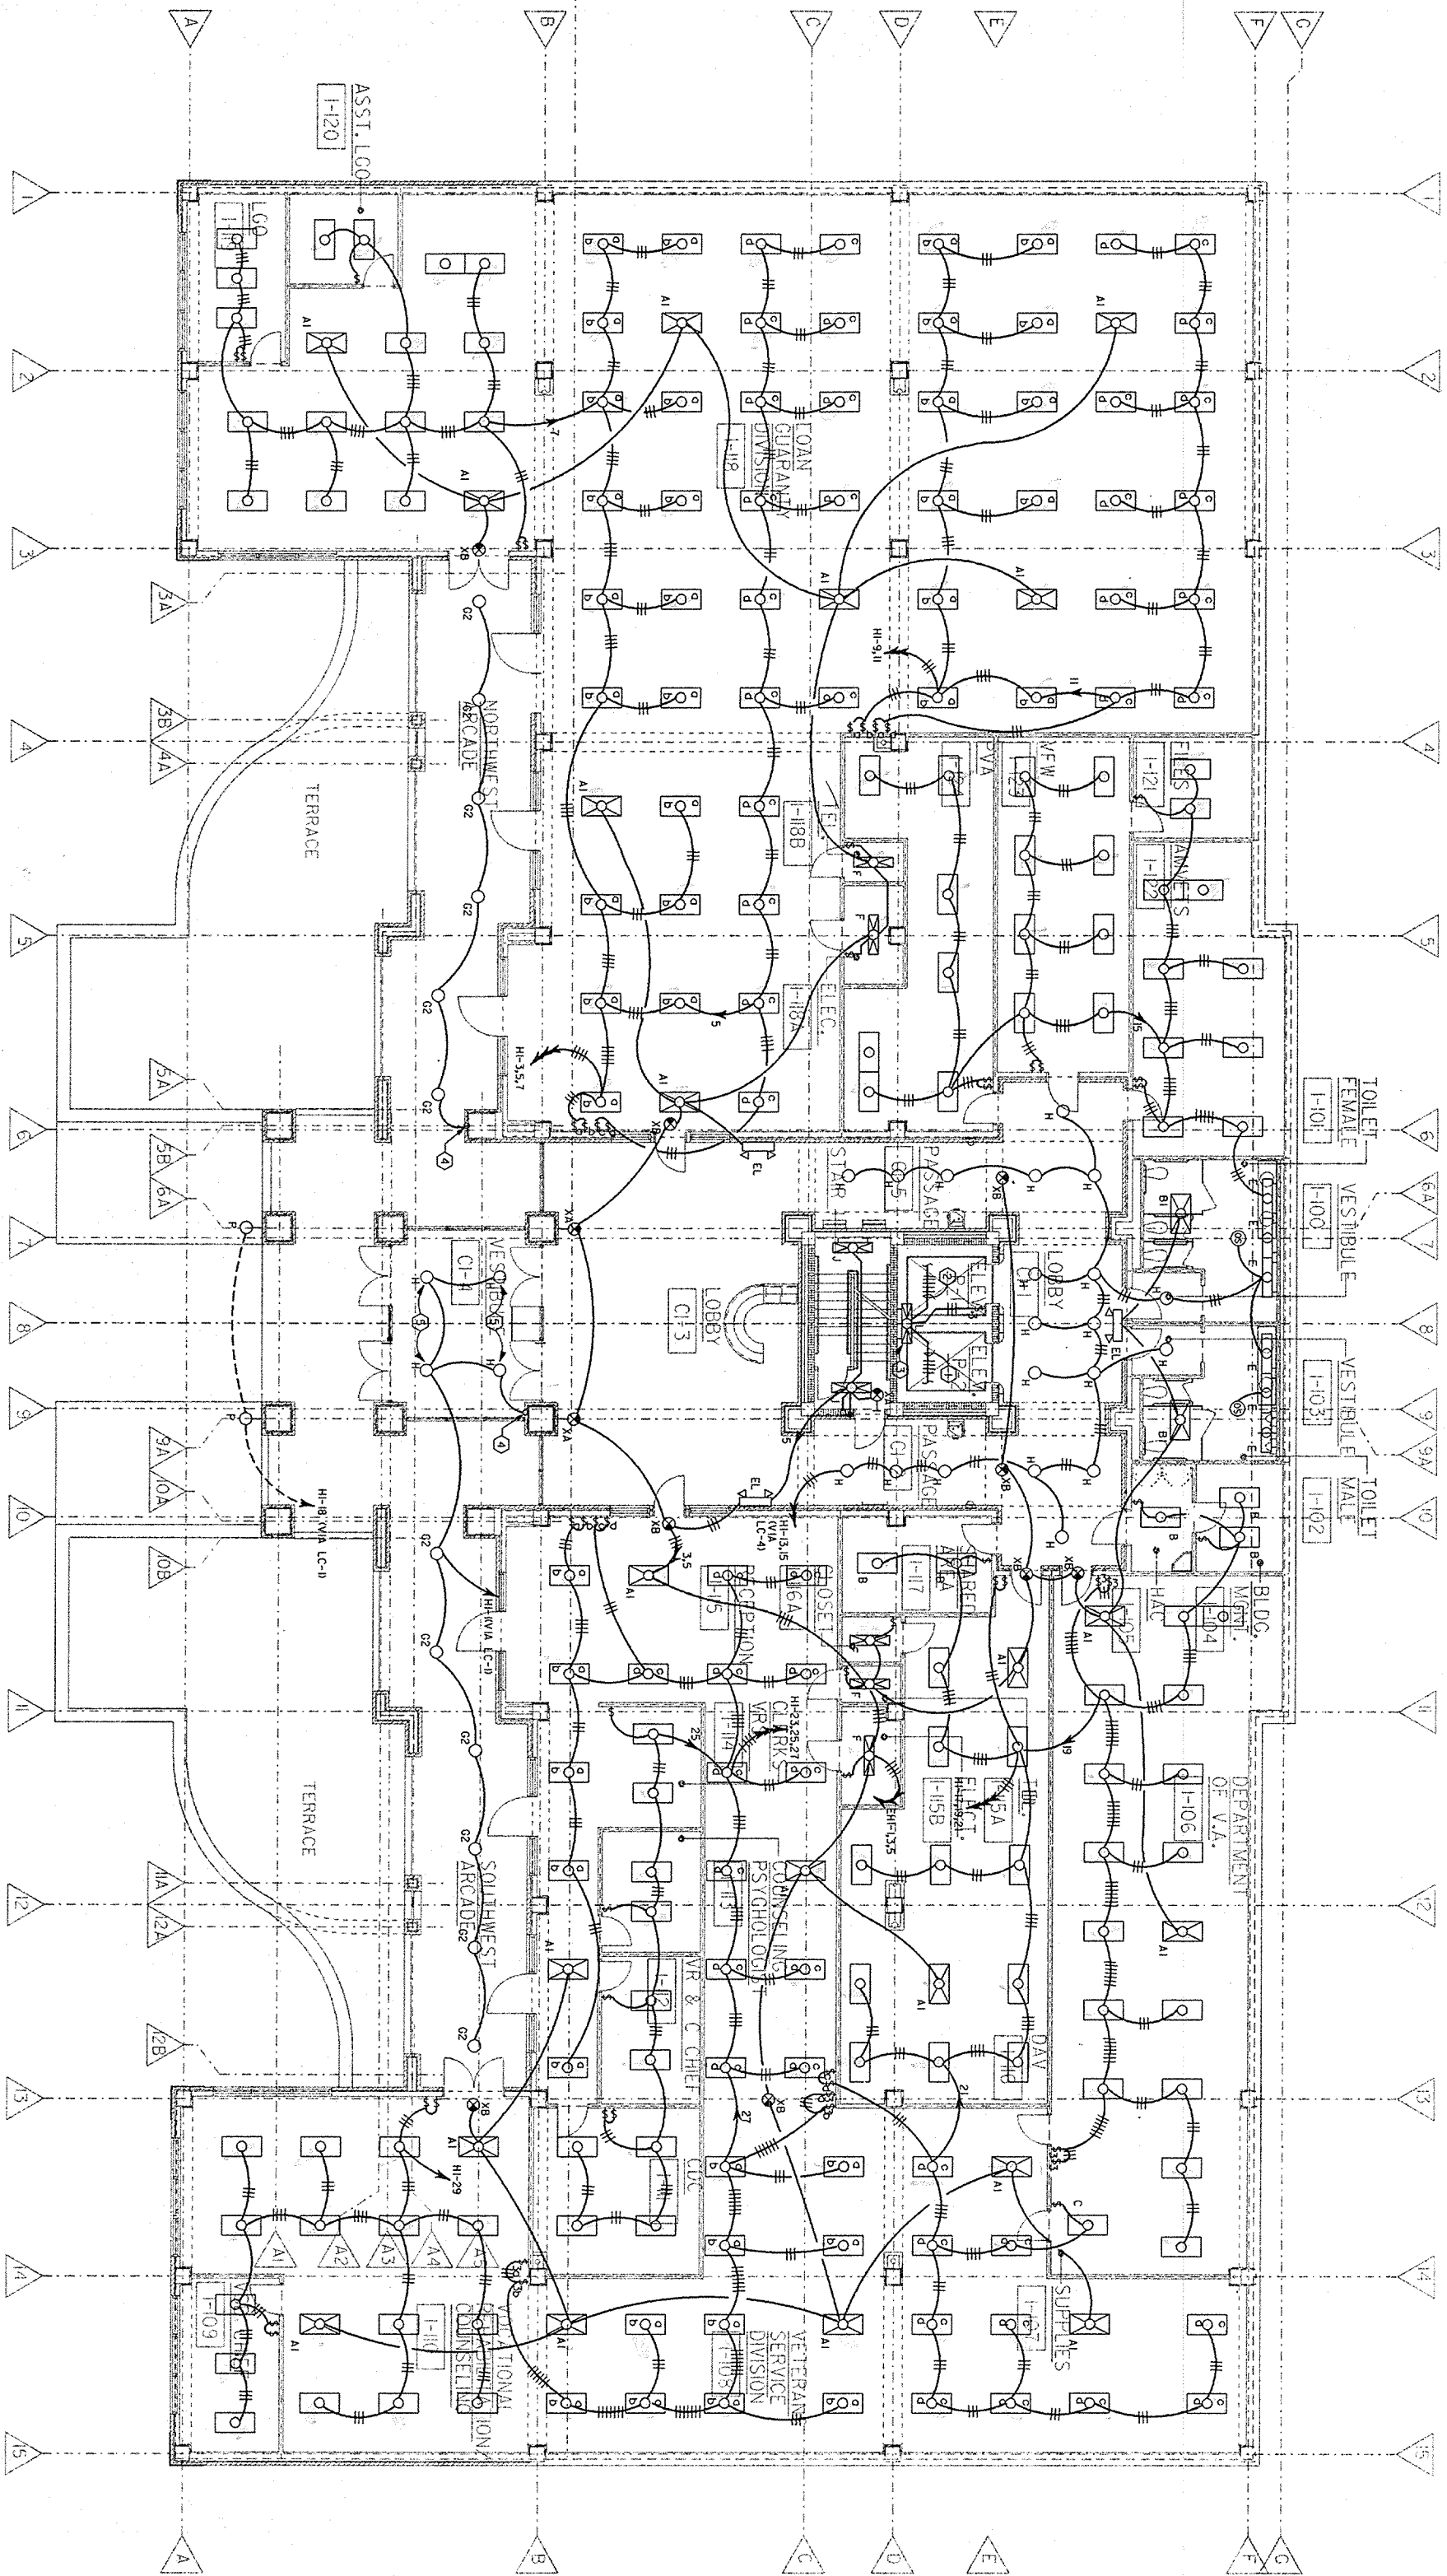


FIRST FLOOR PLAN - LIGHTING

SCALE: 1/8" = 1'-0"

one-eighth inch = one foot

Revisions	Date

WWR
Watson Rutland / Architects Inc.
166 Commerce Street
P.O. Box 4834
Montgomery, Alabama 36104
205/265-6401

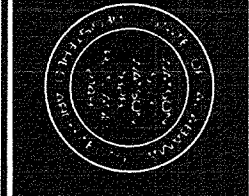

Drawing Title
First Floor Plan Lighting
Approved Area Project Manager
[Signature]

Project Title
Relocate Regional Office to Department Owned Grounds
Building Number **42**
Location **VMAC Montgomery, AL**

Date
27 JANUARY 92
Project No.
322-002
DRAWING NO.
42-E4
Drawing Of 134

