



wasswell
ARCHITECT
334 221 9736

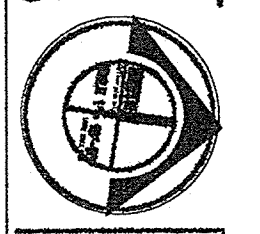

VA REGIONAL OFFICE
345 PERRY HILL ROAD
MONTGOMERY, ALABAMA

REFLECTED CEILING PLAN	PREFABRICATE METAL STORAGE BUILDING	1 Jan 2003 322/63034 A-1.1
------------------------	-------------------------------------	----------------------------------

REFLECTED CEILING PLAN
SCALE: 1"= 10'-0"

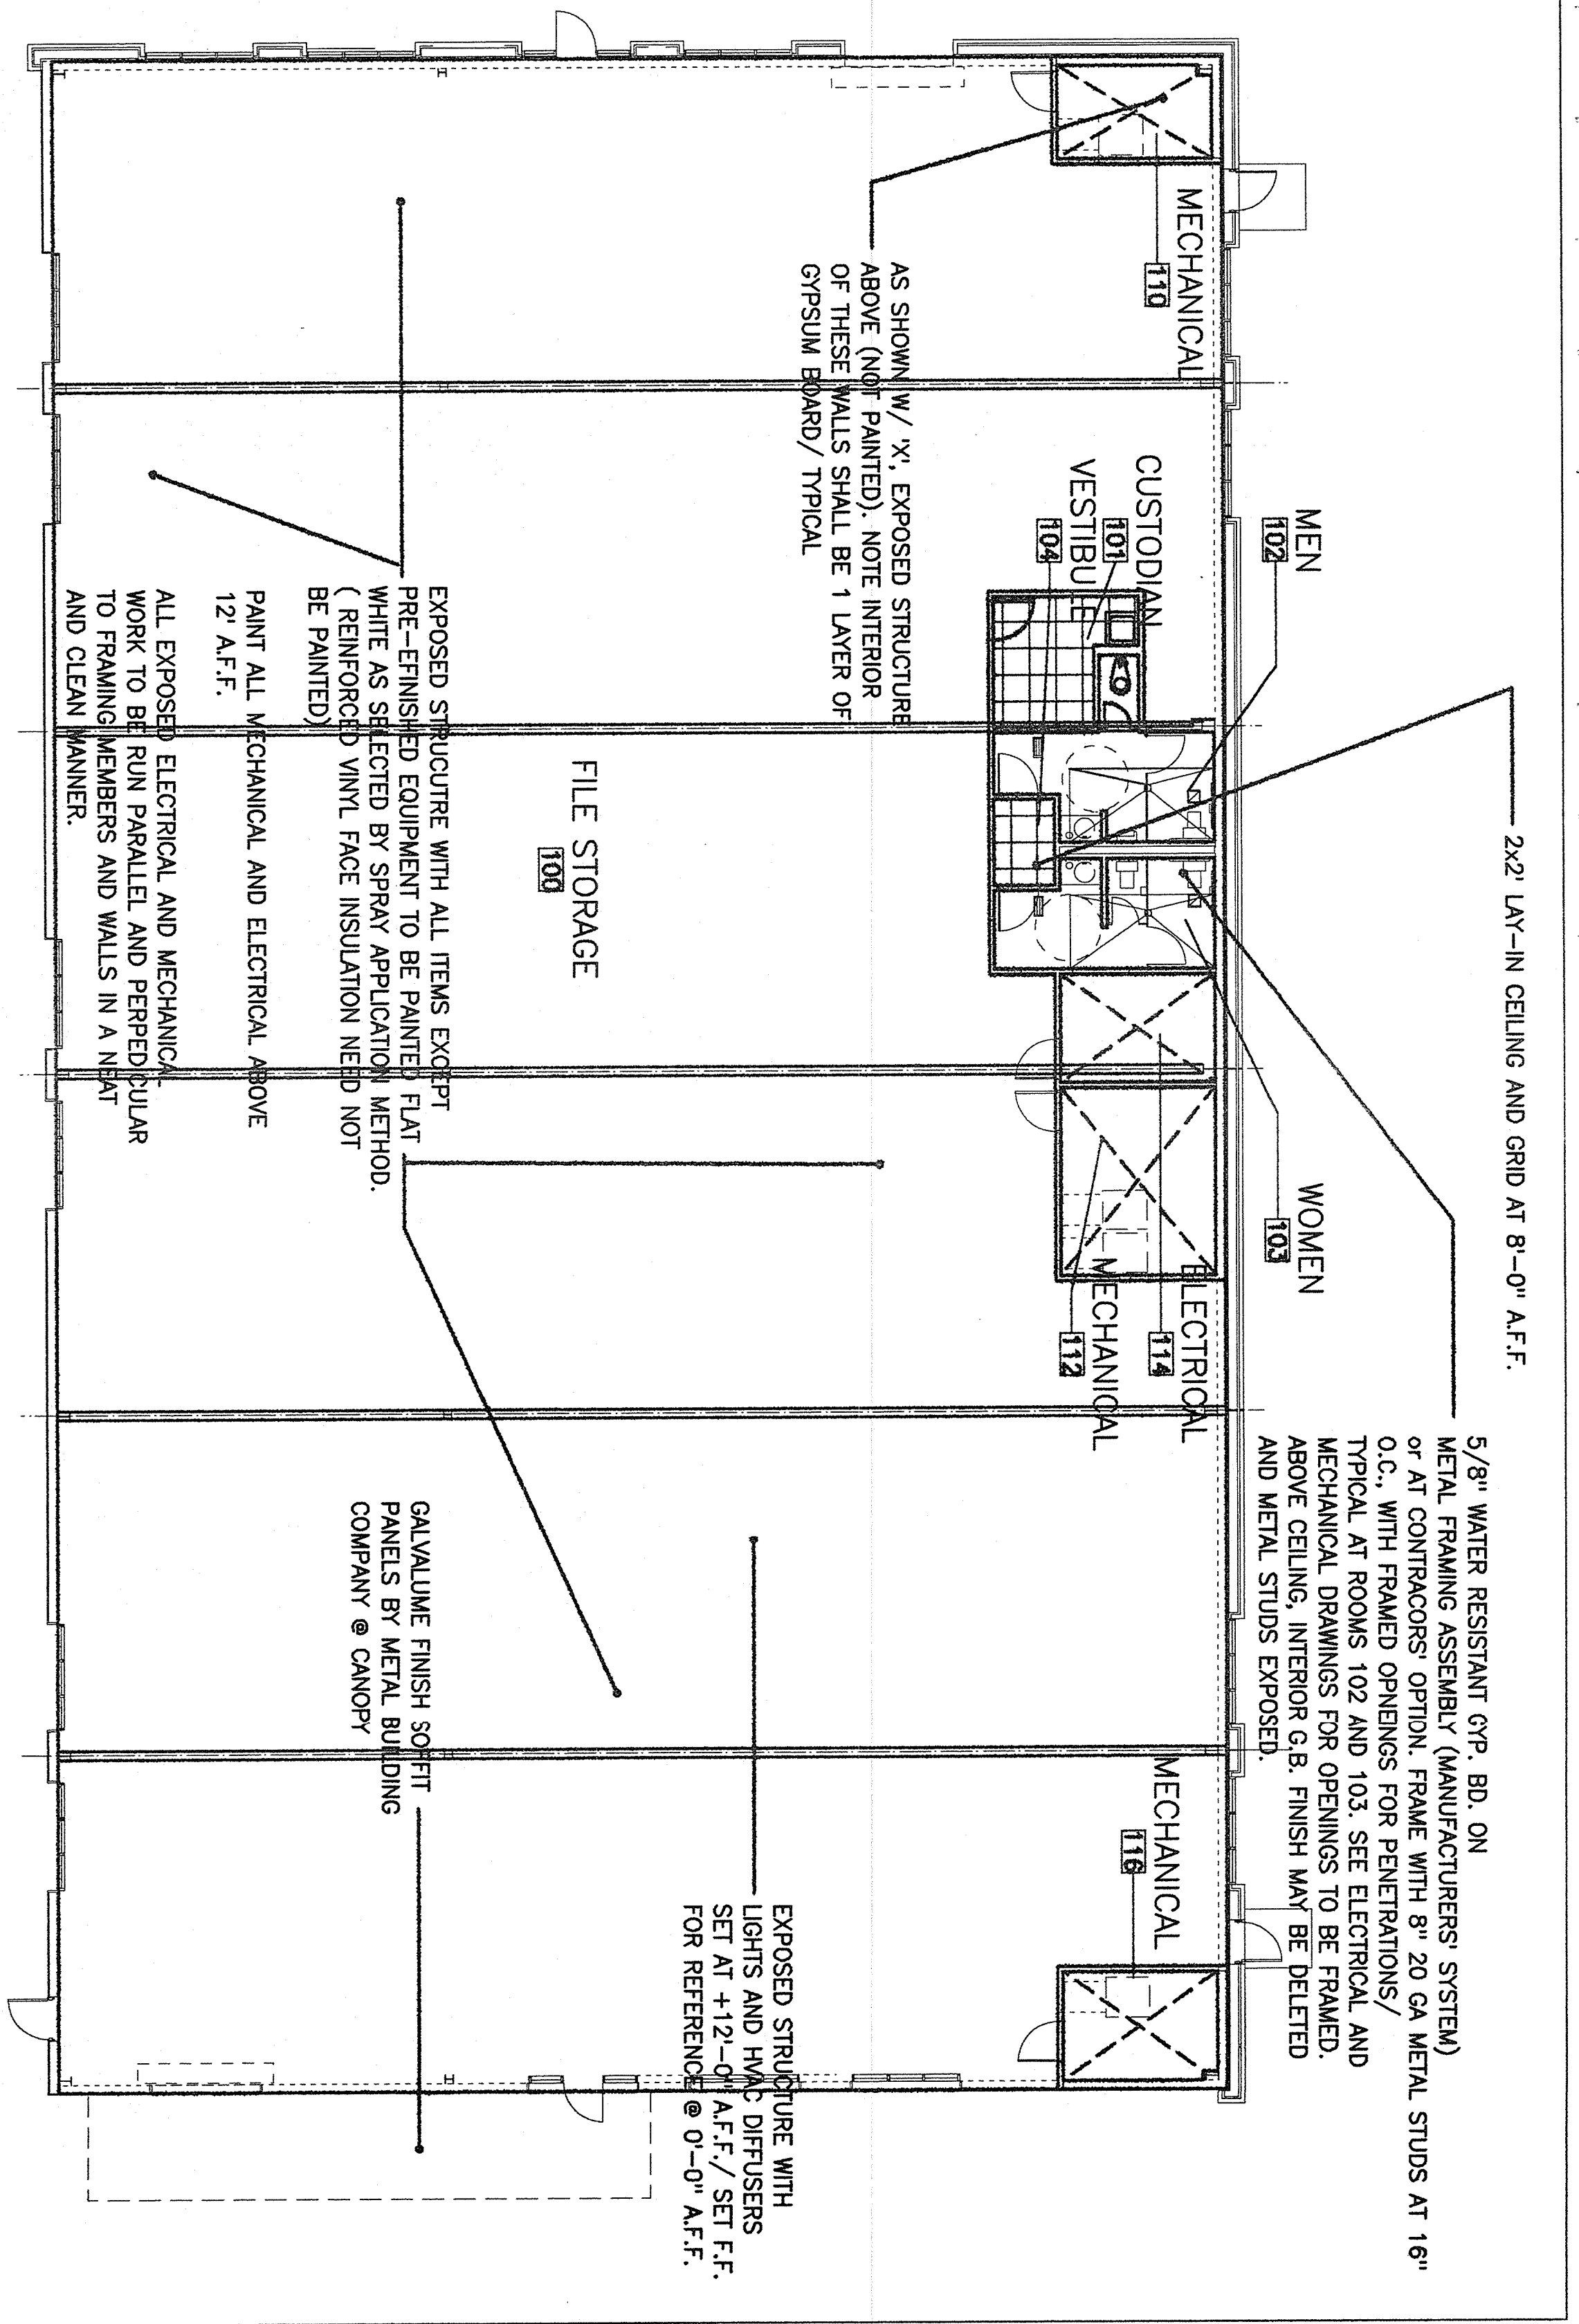

WATER 10'-0" DIA. 10' DIA.