



- NOTE:
1. ALL CEILING MOUNTED J-BOXES WITH CONDUIT AND PULL-WIRE ONLY. DO NOT PULL CONDUCTORS. PROVIDE EMPTY CONDUITS FROM JUNCTION BOXES TO STUB-OUT IN ELECTRICAL ROOM ABOVE LOCATION OF FUTURE PANEL. THREE 20A, 120V CIRCUITS PER J-BOX TO BE ADDED AT A FUTURE DATE.
 2. EF-1 IS LOCATED ON THE ROOF AND IS CONNECTED TO CONTROLLER IN MECHANICAL ROOM 112.

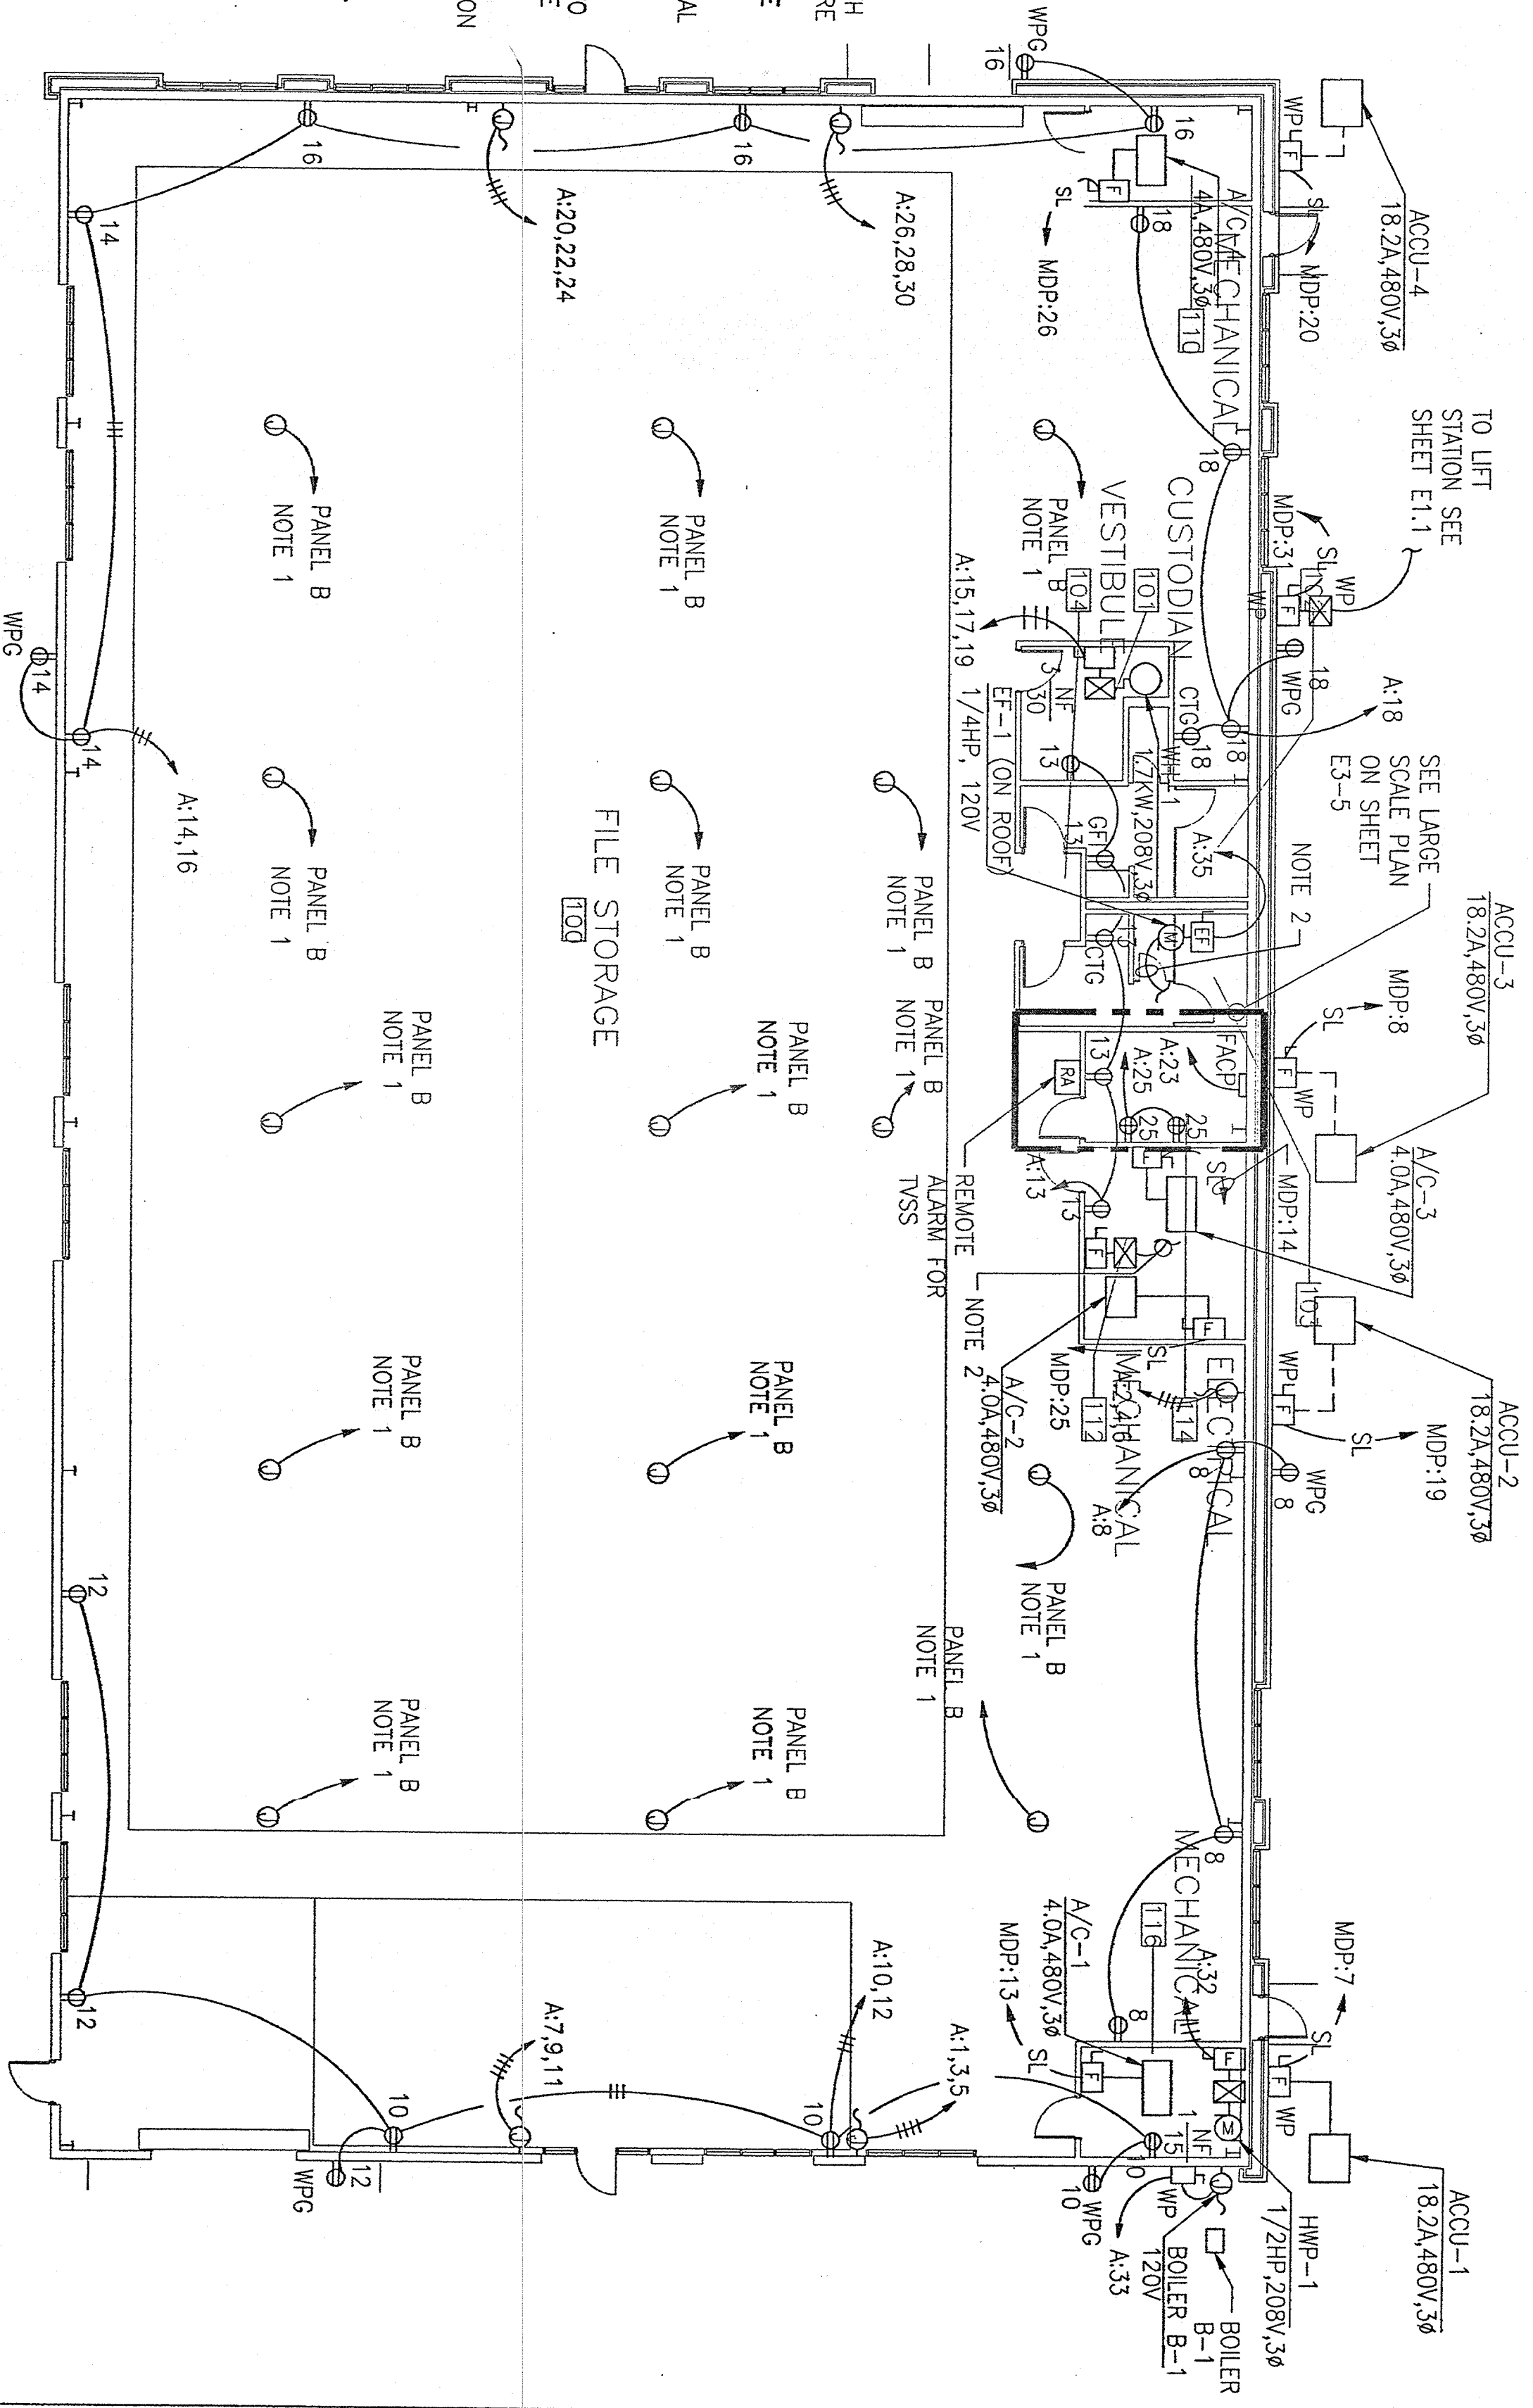

POWER PLAN

SCALE: 1" = 10'-0"

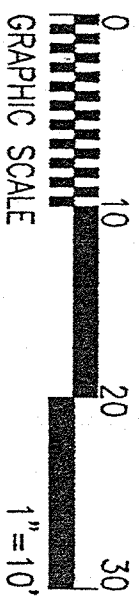

Wassweiler
ARCHITECT
921 36

VA REGIONAL OFFICE
345 PERRY HILL ROAD
MONTGOMERY, ALABAMA

Project No.	POWER PLAN
Client	PREFABRICATE METAL STORAGE BUILDING
Design No.	322VB3034
Drawn By	MGB
Check By	E-3.1
Date	1 Jan 2003