


NOTE: SEE WATER RISER DIAGRAMS FOR LOCATIONS  
OF SHOCK ARRESTERS.



NOTE:  
HANGER SHIELD IS  
TYPICAL FOR  
INSULATED PIPING

Labels: THREADED ROD, LOCK NUT, HANGER, INSULATION, PIPING, INSULATION SHIELD

Dimensions: 6" / 2", 6" / 2", 12"

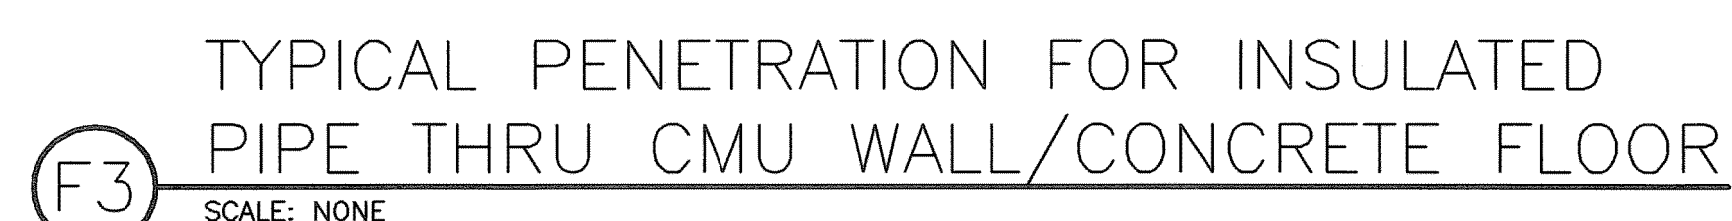

**Harrell,  
Saltrick &  
Hopper**

## 100% CONSTRUCTION DOCUMENTS

	Drawing Title
	PLUMBING DETAILS
	★ BUILDING IS FULLY SPRINKLERED ★

Drawn LDR	Building Number 21	AutoCAD File Name
Checked	Reviewed	Const. Contract No.

DRAWING No.  
PI 502



Veterans  
Affairs