 


SCALE: NONE




SCALE: NONE



SCALE: 3/4" = 1'-0"



LRS #11370

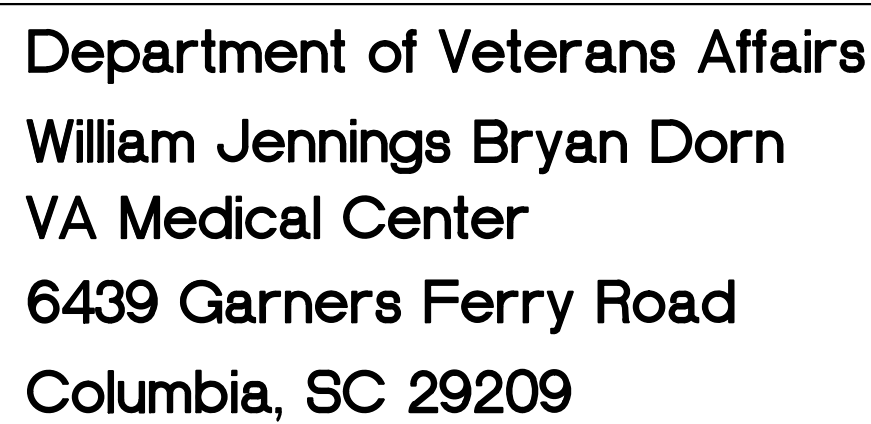

Design & Management Solutions for the Built Environment

8016 TOWER POINT DRIVE
CHARLOTTE, NC 28227

P 704.814.1328
F 704.321.0833

WWW.HSHPC.COM

COPYRIGHT © 2011 HARRELL SALTROCK & HOPPER, PC
NSH PROJECT # 11015

Recommended Approvals:	
1. MEDICAL DIRECTOR	6. OPERATIONS SERVICE LINE MANAGER
2. ASSOCIATE DIRECTOR	7. INFECTION CONTROL MANAGER
3. CHIEF OF STAFF	8. SAFETY MANAGER
4. ASSOC. DIRECTOR	9. GENERAL ENGINEER
5. SERVICE LINE MGRS.	10. COTR

Drawing Title
COLUMN & FOOTING SCHEDULES

*** BUILDING IS FULLY
SPRINKLERED ***

Project Title	REPLACE BOILER PLANT/ COGEN/CHP
---------------	------------------------------------

RJM

Building M
21

AutoCAD File Name

DRAWING No.
GG 100

SS400

Date
APRIL 30, 2012

Project Number
544-11-101



100% CONSTRUCTION DOCUMENTS