
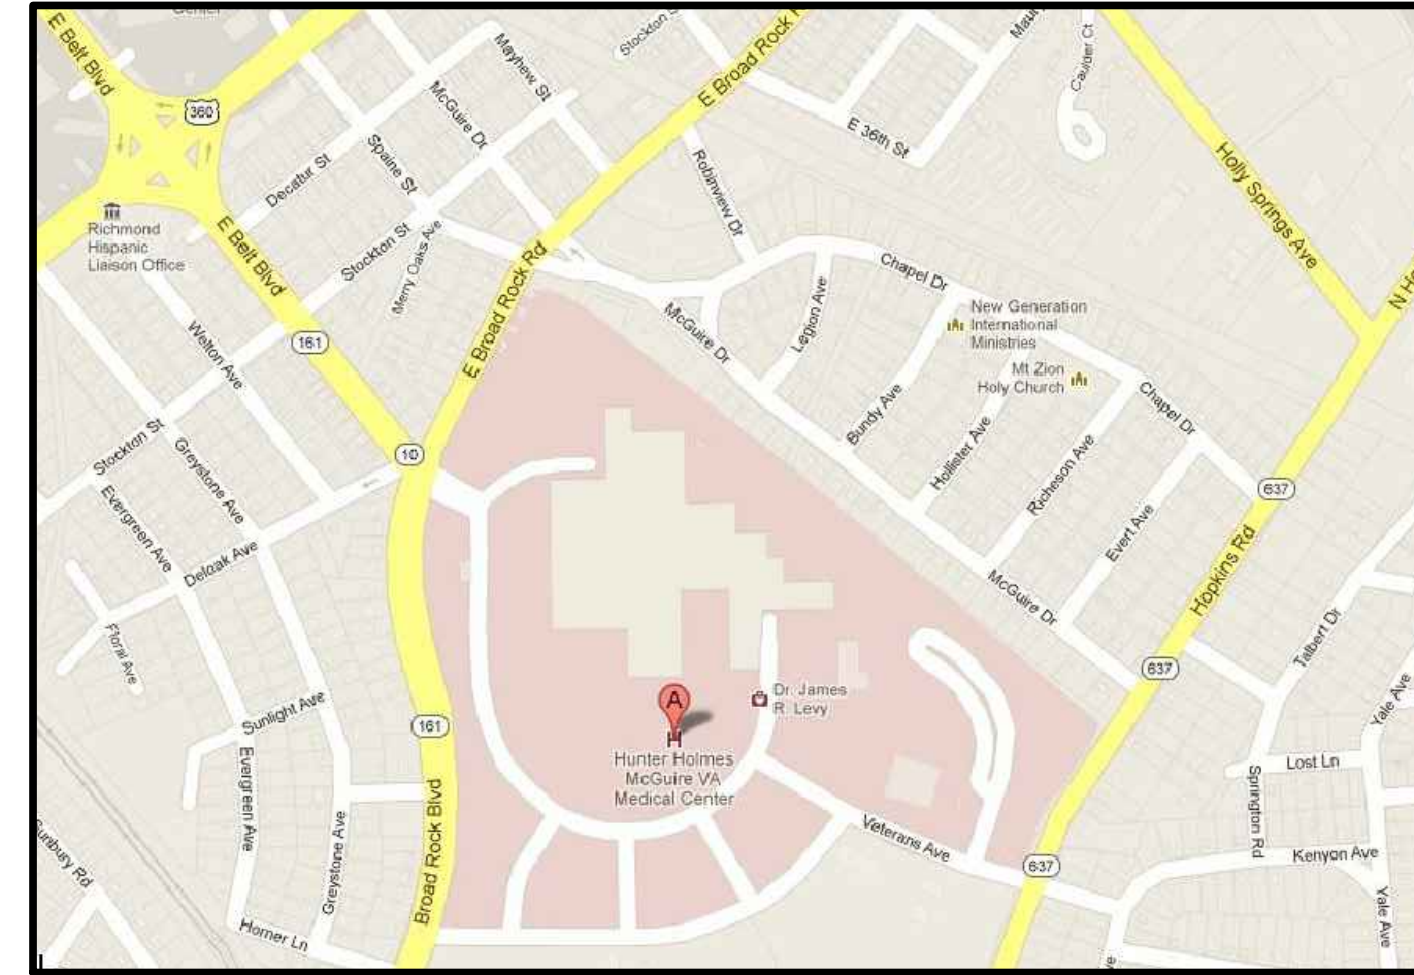


PHYSICAL, MEDICAL AND REHABILITATION - RENOVATION

DEPARTMENT OF VETERANS AFFAIRS
McGUIRE VA MEDICAL CENTER , RICHMOND VIRGINIA
PROJECT NO: 652-12-113

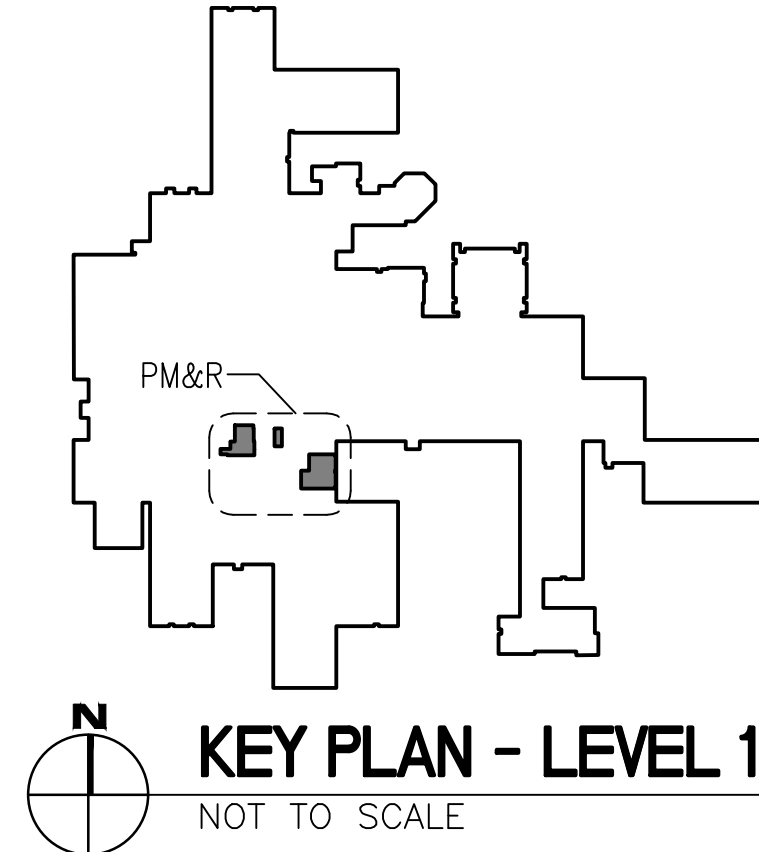

DEPARTMENT OF
VETERANS AFFAIRS

ABBREVIATIONS

| | | | | | | | | | | | |
|--|---|---|--|---|--|--|---|---|--|---|---|
| & < @ # A/C ACT ACOUS. ADJ. ADA ADDL ADMIN AFF AFG AHJ AHU AIA AISC ALUM APPROX ARCH. BD. BLDG. BLKG. BLVD BM BOT BRG CAB. CC CCTV CCW CD CEM. CER. CIP C.J. CLG. CLO. C.M.U. CO COMM COL. CONC. CONF CONSTR CONT. CONTR COR CORR. CG CPM CPT CSG CSI CSMT C.T. CTRL CU FT CURT CYL | AND ANGLE AT CENTERLINE DIAMETER NUMBER OR POUND AIR CONDITIONING ACOUSTICAL ACOUSTICAL CEILING TILE ACOUSTICAL ADJUSTABLE/ADJACENT AIR HANDLING UNIT AMERICAN INSTITUTE OF ARCHITECTS AMERICAN INSTITUTE OF STEEL CONSTRUCTION ALUMINUM APPROXIMATE ARCHITECT/ARCHITECTURAL BOARD BUILDING BLOCKING BOULEVARD BEAM OR BENCHMARK BOTTOM BEARING CABINET CONTRACTOR FURNISHED - CONTRACTOR INSTALLED CLOSED CIRCUIT TELEVISION COUNTERCLOCKWISE CONSTRUCTION DOCUMENTS CEMENT CERAMIC CAST IRON CAST IN PLACE CONTROL JOINT CEILING CLOSET CONCRETE MASONRY UNIT CLEAN OUT, COMPANY COMMUNICATION COLUMN CONCRETE CONFERENCE CONSTRUCTION CONTINUOUS CONTRACTOR CONTRACTING OFFICER'S REPRESENTATIVE CORRIDOR CORNER GUARD CRITICAL PATH METHOD CARPET CASING CONSTRUCTION SPECIFICATIONS INSTITUTE CASEMENT CERAMIC TILE CONTROL CUBIC FEET CURTAIN CYLINDER | D DAT. DB DBL DBL GLZ DC DEMO DEPT DET/DTL DF DIA DIFF DIM DISP DIST D.O. DOC DRN DS DWG(S) EA E.J. EL OR ELEV ELEC EMER ENCL EPS EQ EQUIP. EQUIV. EST. EWS EXH EWC EXP. EX OR EXIST EXT. EXT GR F FA FAB FACIL FCO F.D. F.E. F.E.C. FF FF EL FF&E F.H. FIN FIN. FLR. FIN GR FIXT FL. FLUOR FM FOC FOF FOM FOS FOW FPRF. FRZ | DEPTH DATUM DECIBEL DOUBLE DOUBLE GLAZED DIRECT CURRENT DEMOLISH/DEMOLITION DEPARTMENT DETAIL DRINKING FOUNTAIN DIAMETER DIAGONAL OR DIAGRAM DIFFERENCE OR DIFFUSER DIMENSION DISTANCE DOOR OPENING DOCUMENT DRAIN DOWNSPOUT DRAWING(S) EACH EXPANSION JOINT ELEVATION ELECTRIC OR ELECTRICAL EMERGENCY ENCLOSURE EXPANDED POLYSTYRENE BOARD INSULATION EQUAL EQUIPMENT EQUIVALENT ESTIMATE EYE WASH STATION EXHAUST ELECTRIC WATER COOLER EXPANSION EXISTING EXTERIOR EXTERIOR GRADE FEMALE OR FAHRENHEIT FIRE ALARM FABRIC FACILITY FLOOR CLEANOUT FLOOR DRAIN FIRE EXTINGUISHER FIRE EXTINGUISHER CABINET FINISHED FACE FINISHED FLOOR ELEVATION FURNITURE, FIXTURE AND EQUIPMENT FULL HEIGHT FINISH FINISHED FLOOR FINISHED GRADE FIXTURE FLOOR FLUORESCENT FACTORY MUTUAL FACE OF CONCRETE FACE OF FINISH FACE OF MASONRY FACE OF SLAB FACE OF WALL FIREPROOF(ING) FREEZER | FT FTG FURN FURR GA GAL GALV GALV STL GB GC GDR GEN GFRG GFRG GI GL GL BLK GOVT GR GRAN GRTO GSU GYP GYP BD GYP PLAS GWB H H PLAM HAZ MAT HB HC HCWD HDBD HDR HDW HDWD HEX HF HM HNDRL HO HORIZ HOSP HQ HS HT HVAC HVR HW HYD HYDR IAQ IBC ILLUM INCL IND INFO INSUL INT INTERCOM INTL INH | FOOT OR FEET FOOTING FURNITURE FURRING GAUGE GALLON GALVANIZED GALVANIZED STEEL GRAB BAR GENERAL CONTRACTOR GUARD RAIL GENERAL OR GENERATOR GLASS FIBER REINFORCED CONCRETE GLASS FIBER REINFORCED GYPSUM GLASS FIBER REINFORCED PLASTIC GALVANIZED IRON GLASS GLASS BLOCK GOVERNMENT GROUT GRANITE GRATING GLAZED STRUCTURAL UNIT GYPSUM GYPSUM BOARD GYPSUM PLASTER GYPSUM WALLBOARD HIGH HIGH PRESSURE PLASTIC LAMINATE HAZARDOUS MATERIAL HOSE BIBB HOLLOW CORE HOLLOW CORE WOOD DOOR HARDBOARD HEADER HARDWARE HARDWOOD HEXAGON HIGH FREQUENCY HOLLOW METAL HANDRAIL HOLD OPEN HORIZONTAL HOSPITAL HEADQUARTERS HEAT STRENGTHENED HEIGHT HEAT, VENTILATING AND AIR CONDITIONING HEAVY HOT WATER HYGIENIC WALL COVERING HYDRANT HYDRAULIC INDOOR AIR QUALITY INTERNATIONAL BUILDING CODE IDENTIFICATION, INSIDE DIAMETER OR INTERIOR DESIGN ILLUMINATION INCLUDING INDEPENDENT OR INDUSTRIAL INFORMATION INSULATION INTERIOR INTERCOMMUNICATION INTERNATIONAL INSTANTANEOUS WATER HEATER | JAN J-BOX KD KIT KO KPL LAB LAD LAM LAM GL LAU LAV LBR LBS LCKR LD BRG LDR LED LF LH LHR LKR LL LS MACH MAINT MATL MAX MECH MED MFR MGT MH MIL STD MIN MIRR MTD MTG MTL MULL MW NA NAT NATL NEC NFC NIC NO NOM NRC O/O OA OC OD OF/CI OFD OFF OF/OI OH OPNG | JANITOR JUNCTION BOX KILN DRIED OR KNOCKED DOWN KITCHEN KNOCKOUT KICKPLATE ANGLE LABORATORY LADDER LAMINATE LAMINATED GLASS LAUNDRY LAVATORY LUMBER POUND LOCKER LOAD-BEARING LEADER LIGHT EMITTING DIODE RETURN AIR RESILIENT BASE RUBBER REFLECTED CEILING PLAN ROAD OR ROOF DRAIN RECESSED REFERENCE OR REFRIGERATOR RESILIENT FLOORING RESINOUS FLOORING RAIN LEADER SUPPLY AIR SPLASH BLOCK SOLID CORE SCHEDULE SOLID CORE WOOD DOOR SMOKE DETECTOR OR SHOP DRAWINGS SECTION SQUARE FEET SIMILAR SOLID SURFACE SUSTAINABLE SURFACE SPECIFICATION SPEAKER SQUARE SERVICE SINK STAINLESS STEEL SOUND TRANSMISSION CLASS STANDARD STORAGE STRUCTURAL SUSPENDED SHEET VINYL SWITCH SYMBOL OR SYMMETRICAL SYNTHETIC TREAD TONGUE & GROOVE TILE COUNCIL OF AMERICA TOWEL DISPENSER TOILET PARTITION | OPP OPH PAR PL PLAM PLAS PLYWD PRELIM PROJ PT PTN QA QC QT QTY R RA RB RBR RCP RD REC REF REL RES RL SA SB SC SCHD SCWD SD SECT SF SIM SU SUR SU SUR SPEC SPKLR SPKR SQ SS SST STC STD STOR STRUCT SUSP SV SW SYM SYNTH T T & G TCA TD TP | OPPOSITE OPPOSITE HAND PARALLEL OR PARAPET PLATE PLASTIC LAMINATE PLASTER OR PLASTIC PLYWOOD PRELIMINARY PROJECT PAINT, PNEUMATIC TUBE OR PRESSURE TREATED PARTITION QUALITY ASSURANCE QUARRY TILE QUANTITY RADIUS OR RISER RETURN AIR RESILIENT BASE RUBBER REFLECTED CEILING PLAN ROAD OR ROOF DRAIN RECESSED REFERENCE OR REFRIGERATOR RESILIENT FLOORING RESINOUS FLOORING RAIN LEADER SUPPLY AIR SPLASH BLOCK SOLID CORE SCHEDULE SOLID CORE WOOD DOOR SMOKE DETECTOR OR SHOP DRAWINGS SECTION SQUARE FEET SIMILAR SOLID SURFACE SUSTAINABLE SURFACE SPECIFICATION SPEAKER SQUARE SERVICE SINK STAINLESS STEEL SOUND TRANSMISSION CLASS STANDARD STORAGE STRUCTURAL SUSPENDED SHEET VINYL SWITCH SYMBOL OR SYMMETRICAL SYNTHETIC TREAD TONGUE & GROOVE TILE COUNCIL OF AMERICA TOWEL DISPENSER TOILET PARTITION | TECH TEL TEMP TERR THRU THK T.O. TOB TOM TOP TOS TR TYP U UC UGND UL UNFIN UON UPS SUPPLY UR UTIL V VAR VC VCT VENT VERT VEST VID VNR VR VTR VV VWC W/ W/O WARR WBLK WC WCHR WH WHSE WLD WP WPM WR WS WSF WSC X-BRACE XPS YD YR | TECHNICAL TELEPHONE TEMPERATURE TERRAZZO THROUGH THICK TOP OF TOP OF BASE TOP OF MASONRY TOP OF PARAPET TOP OF SLAB TOWEL RACK TYPICAL HEAT TRANSFER COEFFICIENT UNDERCUT UNDERGROUND UNDERWRITERS LABORATORIES UNFINISHED UNLESS OTHERWISE NOTED UNINTERRUPTIBLE POWER SUPPLY URINAL UTILITY VOLT VARIES VA FURNISHED - CONTRACTOR INSTALLED VINYL COMPOSITION TILE VENTILATION VERTICAL VESTIBULE VIDEO VENEER VAPOR RETARDER VENT THROUGH ROOF VA FURNISHED - VA INSTALLED VINYL WALLCOVERING WITH WITHOUT WARRANTY WOOD BLOCKING WATER CLOSET WHEELCHAIR WATER HEATER WAREHOUSE WELED WATERPROOFING WATERPROOF MEMRANE WEATHER RESISTANT WEATHERSTRIP SLIP RESISTANT FLOORING WAINSCOT CROSS BRACE EXTRUDED POLYSTYRENE BOARD INSULATION YARD YEAR |
|--|---|---|--|---|--|--|---|---|--|---|---|

INDEX OF DRAWINGS

| SHT. NO. | DWG. NO. | DESCRIPTION | SHT. NO. | DWG. NO. | DESCRIPTION |
|--------------------------------------|-----------|--|----------------------------------|-----------|---|
| GENERAL INFORMATION DRAWINGS: | | | MECHANICAL DRAWINGS: | | |
| 1 | 500-GI-01 | TITLE SHEET, INDEX OF DRAWINGS, ABBREVIATIONS, AND SYMBOLS | 21 | 500-MH-01 | MECHANICAL GENERAL NOTES |
| 2 | 500-GI-02 | LIFE SAFETY PLAN, CODE DATA, AND GENERAL NOTES | 22 | 500-MH-02 | MECHANICAL FIRST FLOOR DEMOLITION PLAN |
| 3 | 500-GI-03 | PHASING PLAN, NOTES, AND STATEMENT OF BID ITEMS | 23 | 500-MH-03 | MECHANICAL FIRST FLOOR INTERSTITIAL DEMOLITION PLAN |
| | | | 24 | 500-MH-04 | MECHANICAL FIRST FLOOR NEW WORK PLAN |
| | | | 25 | 500-MH-05 | MECHANICAL FIRST FLOOR INTERSTITIAL NEW WORK PLAN |
| | | | 26 | 500-MH-06 | MECHANICAL DETAILS |
| | | | 27 | 500-MH-07 | MECHANICAL SCHEDULES |
| ARCHITECTURAL DRAWINGS: | | | ELECTRICAL DRAWINGS: | | |
| 4 | 500-AS-01 | DEMOLITION PLANS, NOTES, AND SCHEDULE | | | |
| 5 | 500-AS-02 | REFLECTED CEILING DEMOLITION PLAN AND PHOTOS | | | |
| 6 | 500-AS-03 | FLOOR PLANS - NEW WORK | 28 | 500-ES-01 | ELECTRICAL LEGEND, NOTES, AND ABBREVIATIONS |
| 7 | 500-AS-04 | REFLECTED CEILING PLANS - NEW WORK | 29 | 500-ES-02 | ELECTRICAL FIRST FLOOR DEMOLITION PLANS |
| 8 | 500-AS-05 | INTERIOR ELEVATIONS | 30 | 500-ES-03 | ELECTRICAL LOWER LEVEL DEMOLITION PLAN |
| 9 | 500-AS-06 | WALL TYPES AND UL DESIGNATIONS | 31 | 500-ES-04 | ELECTRICAL LIGHTING FIRST FLOOR NEW WORK PLANS |
| 10 | 500-AS-07 | EQUIPMENT PLANS, EQUIPMENT LIST, AND DETAILS | | | |
| 11 | 500-AS-08 | FLOOR FINISH PLANS, NOTES, AND DETAILS | 32 | 500-ES-05 | ELECTRICAL POWER AND SPECIAL SYSTEMS FIRST FLOOR NEW WORK PLANS |
| 12 | 500-AS-09 | DOOR SCHEDULE, FINISH SCHEDULE, AND DETAILS | 33 | 500-ES-06 | ELECTRICAL LOWER LEVEL NEW WORK PLAN |
| | | | 34 | 500-ES-07 | ELECTRICAL DETAILS |
| | | | 35 | 500-ES-08 | ELECTRICAL LIGHTING DETAILS |
| PLUMBING DRAWINGS: | | | FIRE PROTECTION DRAWINGS: | | |
| 13 | 500-PL-01 | PLUMBING GENERAL NOTES, LEGENDS & ABBREVIATIONS | | | |
| 14 | 500-PL-02 | PLUMBING FIXTURE PLATES | 36 | 500-FA-1 | FIRST FLOOR PLAN - FIRE ALARM DEMOLITION PLAN |
| 15 | 500-PL-03 | PLUMBING LOWER LEVEL DEMOLITION PLAN | 37 | 500-FA-2 | FIRST FLOOR PLAN - FIRE SUPPRESSION DEMOLITION PLAN |
| 16 | 500-PL-04 | PLUMBING FIRST FLOOR DEMOLITION PLAN | 38 | 500-FA-3 | FIRE ALARM GENERAL NOTES |
| 17 | 500-PL-05 | PLUMBING FIRST FLOOR INTERSTITIAL DEMOLITION PLAN | 39 | 500-FA-4 | FIRST FLOOR PLAN - FIRE ALARM PLAN |
| 18 | 500-PL-06 | PLUMBING LOWER LEVEL NEW WORK PLAN | 40 | 500-FA-5 | FIRE SUPPRESSION GENERAL NOTES |
| 19 | 500-PL-07 | PLUMBING FIRST FLOOR NEW WORK PLAN | 41 | 500-FA-6 | FIRST FLOOR PLAN - FIRE SUPPRESSION PLAN |
| 20 | 500-PL-08 | PLUMBING FIRST FLOOR NEW WORK PLAN | | | |

DRAWING SYMBOL LEGEND

| | | | | | |
|-----------------------------------|----------------------------------|--------------------------------------|---|---|--|
| SECTION CUT INDICATOR: | DETAIL INDICATOR: | EXTERIOR ELEVATION INDICATOR: | INTERIOR ELEVATION INDICATOR FOR MULTIPLE VIEWS: | DRAWING BLOCK TITLES: | DETAIL |
| SECTION CALLOUT SHEET DRAWN ON | DETAIL CALLOUT SHEET DRAWN ON | ELEVATION CALLOUT SHEET DRAWN ON | ELEVATION CALLOUT SHEET DRAWN ON | SINGLE VIEW INTERIOR ELEVATION OR PHOTO VIEW INDICATOR COLUMN GRID LINE/CALLOUT PARTITION/WALL TYPE CORNER GUARD FIRE EXTINGUISHER CABINET SHEETS CUT FROM | 1 HOUR FIRE RATED 2 HOUR FIRE RATED 1 HOUR FIRE RATED/ SMOKE BARRIER 2 HOUR FIRE RATED/ SMOKE BARRIER CONTRACT LIMIT LINE DOOR OPENING IDENTIFIER/LABEL WINDOW OPENING IDENTIFIER/LABEL ROOM/SPACE IDENTIFIER |

| | | | | | | | | | | | |
|--------------|--|----------------------|--|---|--|---|--|-----------------|--|--|--|
| CONSULTANTS: | | ARCHITECT/ENGINEERS: | | Drawing Title | | Project Title | | Project Number | | Office of Construction and Facilities Management Department of Veterans Affairs | |
| | | | | TITLE SHEET, INDEX OF DRAWINGS, ABBREVIATIONS AND SYMBOLS | | PM&R AREA RENOVATION | | 652-12-113 | | | |
| | | | | Approved Project Director | | Location | | Building Number | | | |
| | | | | | | 1201 BROAD ROCK BLVD., RICHMOND, VA 23249 | | 500 | | | |
| | | | | | | Date | | Drawing Number | | | |
| | | | | | | 11/4/2013 | | 500-GI-01 | | | |
| | | | | | | Checked | | Dwg. 1 of 41 | | | |
| | | | | | | CFM | | | | | |
| | | | | | | Drawn | | | | | |
| | | | | | | KDL | | | | | |