


V.A. SOUTHERN OREGON REHABILITATION CENTER  
E85 FUELING CENTER  
PROJECT NO. 692-342 VA701-13-J-0090(WC)

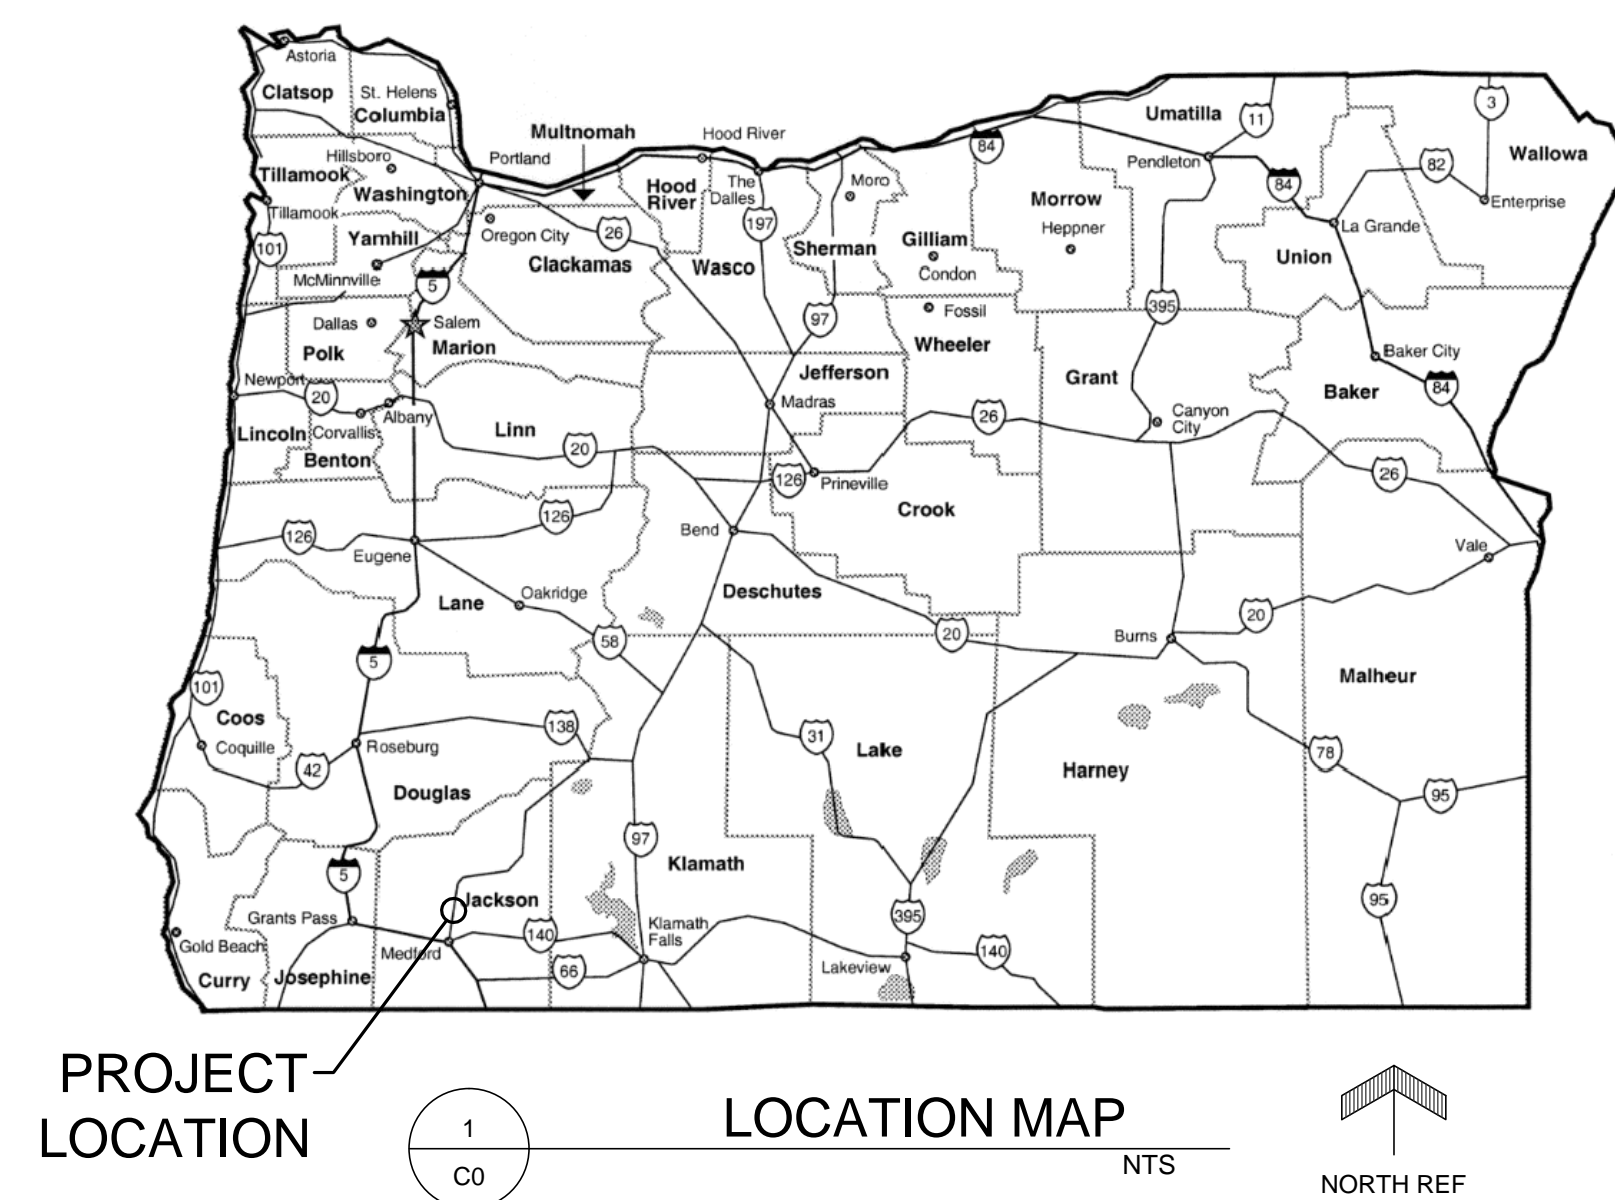

SHEET INDEX

- C0 COVER SHEET
- C1 EXISTING SITE OVERVIEW
- C2 SITE PLAN
- C3 FUEL TANK FOUNDATION PLAN
- C4 GRADING PLAN
- C5 CIVIL DETAILS & ABOVE GROUND FUEL SYSTEM DETAIL
- C6 STRUCTURAL DETAILS
- E1 ELECTRICAL SITE PLAN
- E2 ELECTRICAL SCHEDULES, DETAILS, & DIAGRAMS



VA SORCC DIRECTOR \_\_\_\_\_ DATE \_\_\_\_\_

ASSOCIATE DIRECTOR \_\_\_\_\_ DATE \_\_\_\_\_

CHIEF FACILITIES AND ENGINEERING \_\_\_\_\_ DATE \_\_\_\_\_

CHIEF OF STAFF \_\_\_\_\_ DATE \_\_\_\_\_

INFECTION CONTROL \_\_\_\_\_ DATE \_\_\_\_\_

AFGE \_\_\_\_\_ DATE \_\_\_\_\_

SAFETY MANAGER \_\_\_\_\_ DATE \_\_\_\_\_

CHIEF OF ITOS \_\_\_\_\_ DATE \_\_\_\_\_

\_\_\_\_\_ DATE \_\_\_\_\_

REVISIONS:	DATE:
CAD FILE NAME: WCVAC0.dwg	

**CTA**  
121 SOUTH MAIN STREET  
LIVINGSTON, MONTANA  
P:406-222-0104/F:406-222-1007  
WWW.CTAGROUP.COM



DEPARTMENT OF VETERANS AFFAIRS  
VA SOUTHERN OREGON REHABILITATION CENTER  
8495 CRATER LAKE HIGHWAY  
WHITE CITY, OR. 97503  
(541) 826-2111

PROJECT TITLE: E85 FUELING CENTER	DRAWING TITLE: COVER SHEET	PROJECT NO: 692-342 VA701-13-J-0090(WC)
RECOMMENDED BY: FMS MANAGER	REVIEWED BY: COTR	DATE: 10/24/2013
APPROVED BY: DIRECTOR	LOCATION: WHITE CITY, OR	SHEET NO: C0

