
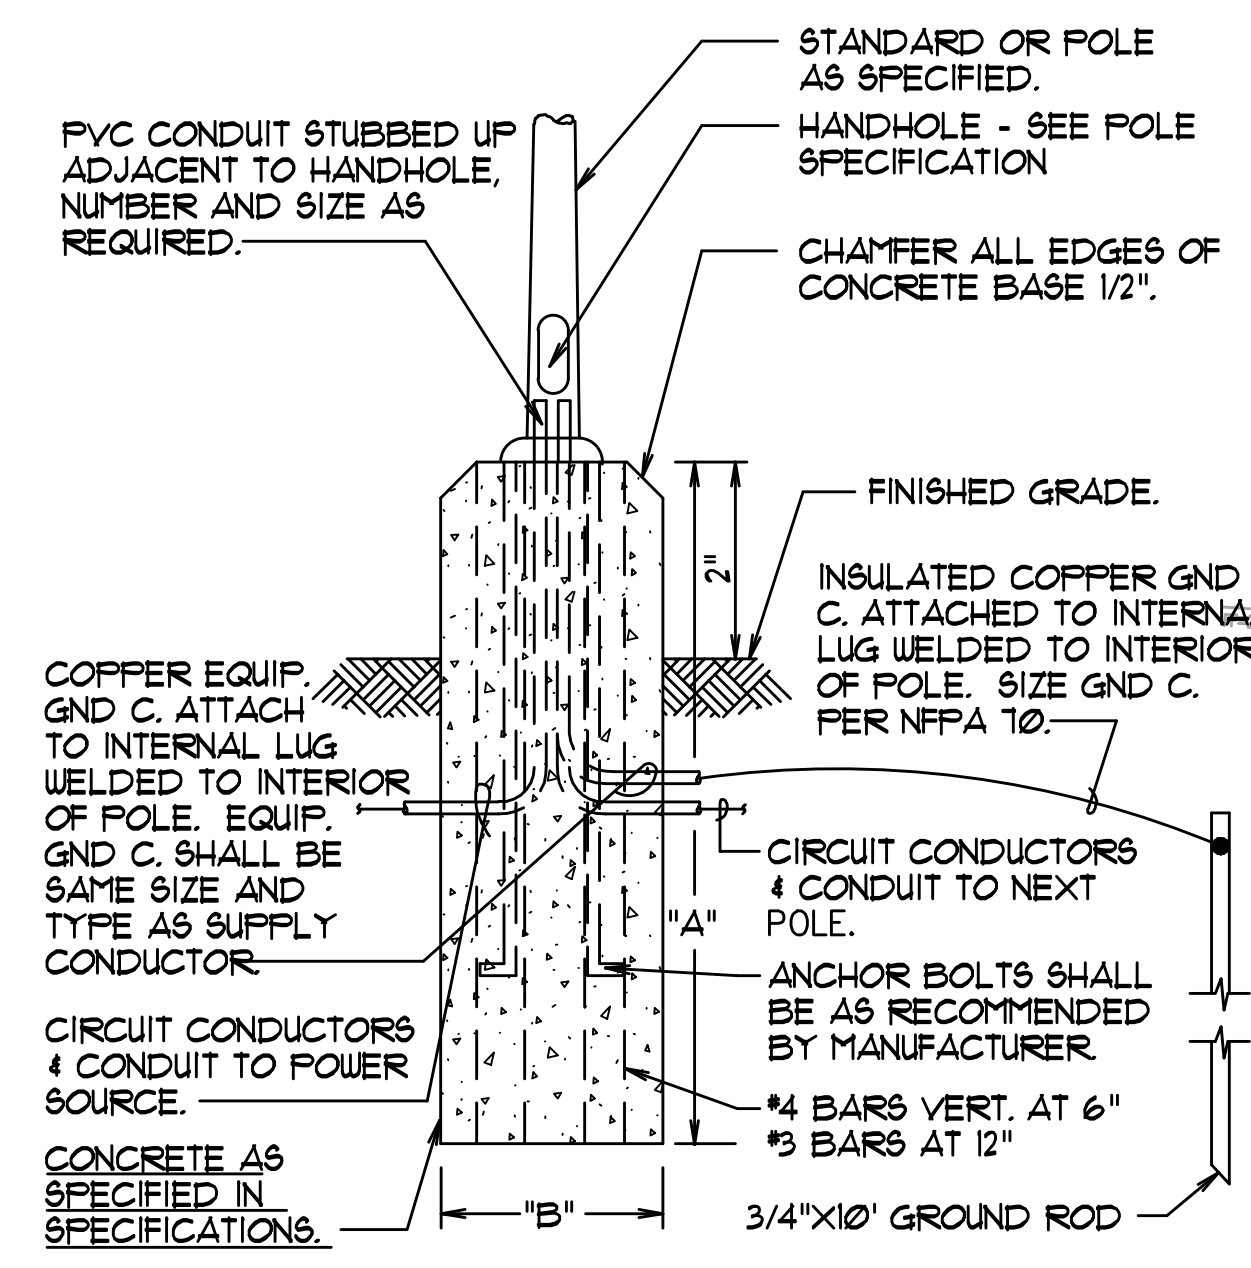



**GENERAL NOTES:**  
 1. RELOCATE EXISTING POLE MOUNTED LIGHTS AS INDICATED ON CIVIL SITE PLAN. MATCH EXISTING CIRCUITS. EXTEND TO NEW LOCATION AND MAKE CONNECTION.

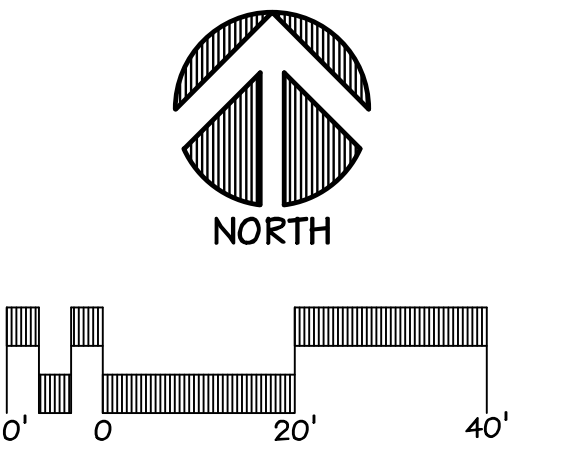

POLE HT.	A	B
8' - 20'	66"	24"
21' - 30'	96"	24"
31' - 40'	102"	30"

**LEGEND**  
 GND C. - GROUNDING CONDUCTOR

**1 BOLT-DOWN POLE FOUNDATION**  
 SCALE: NONE

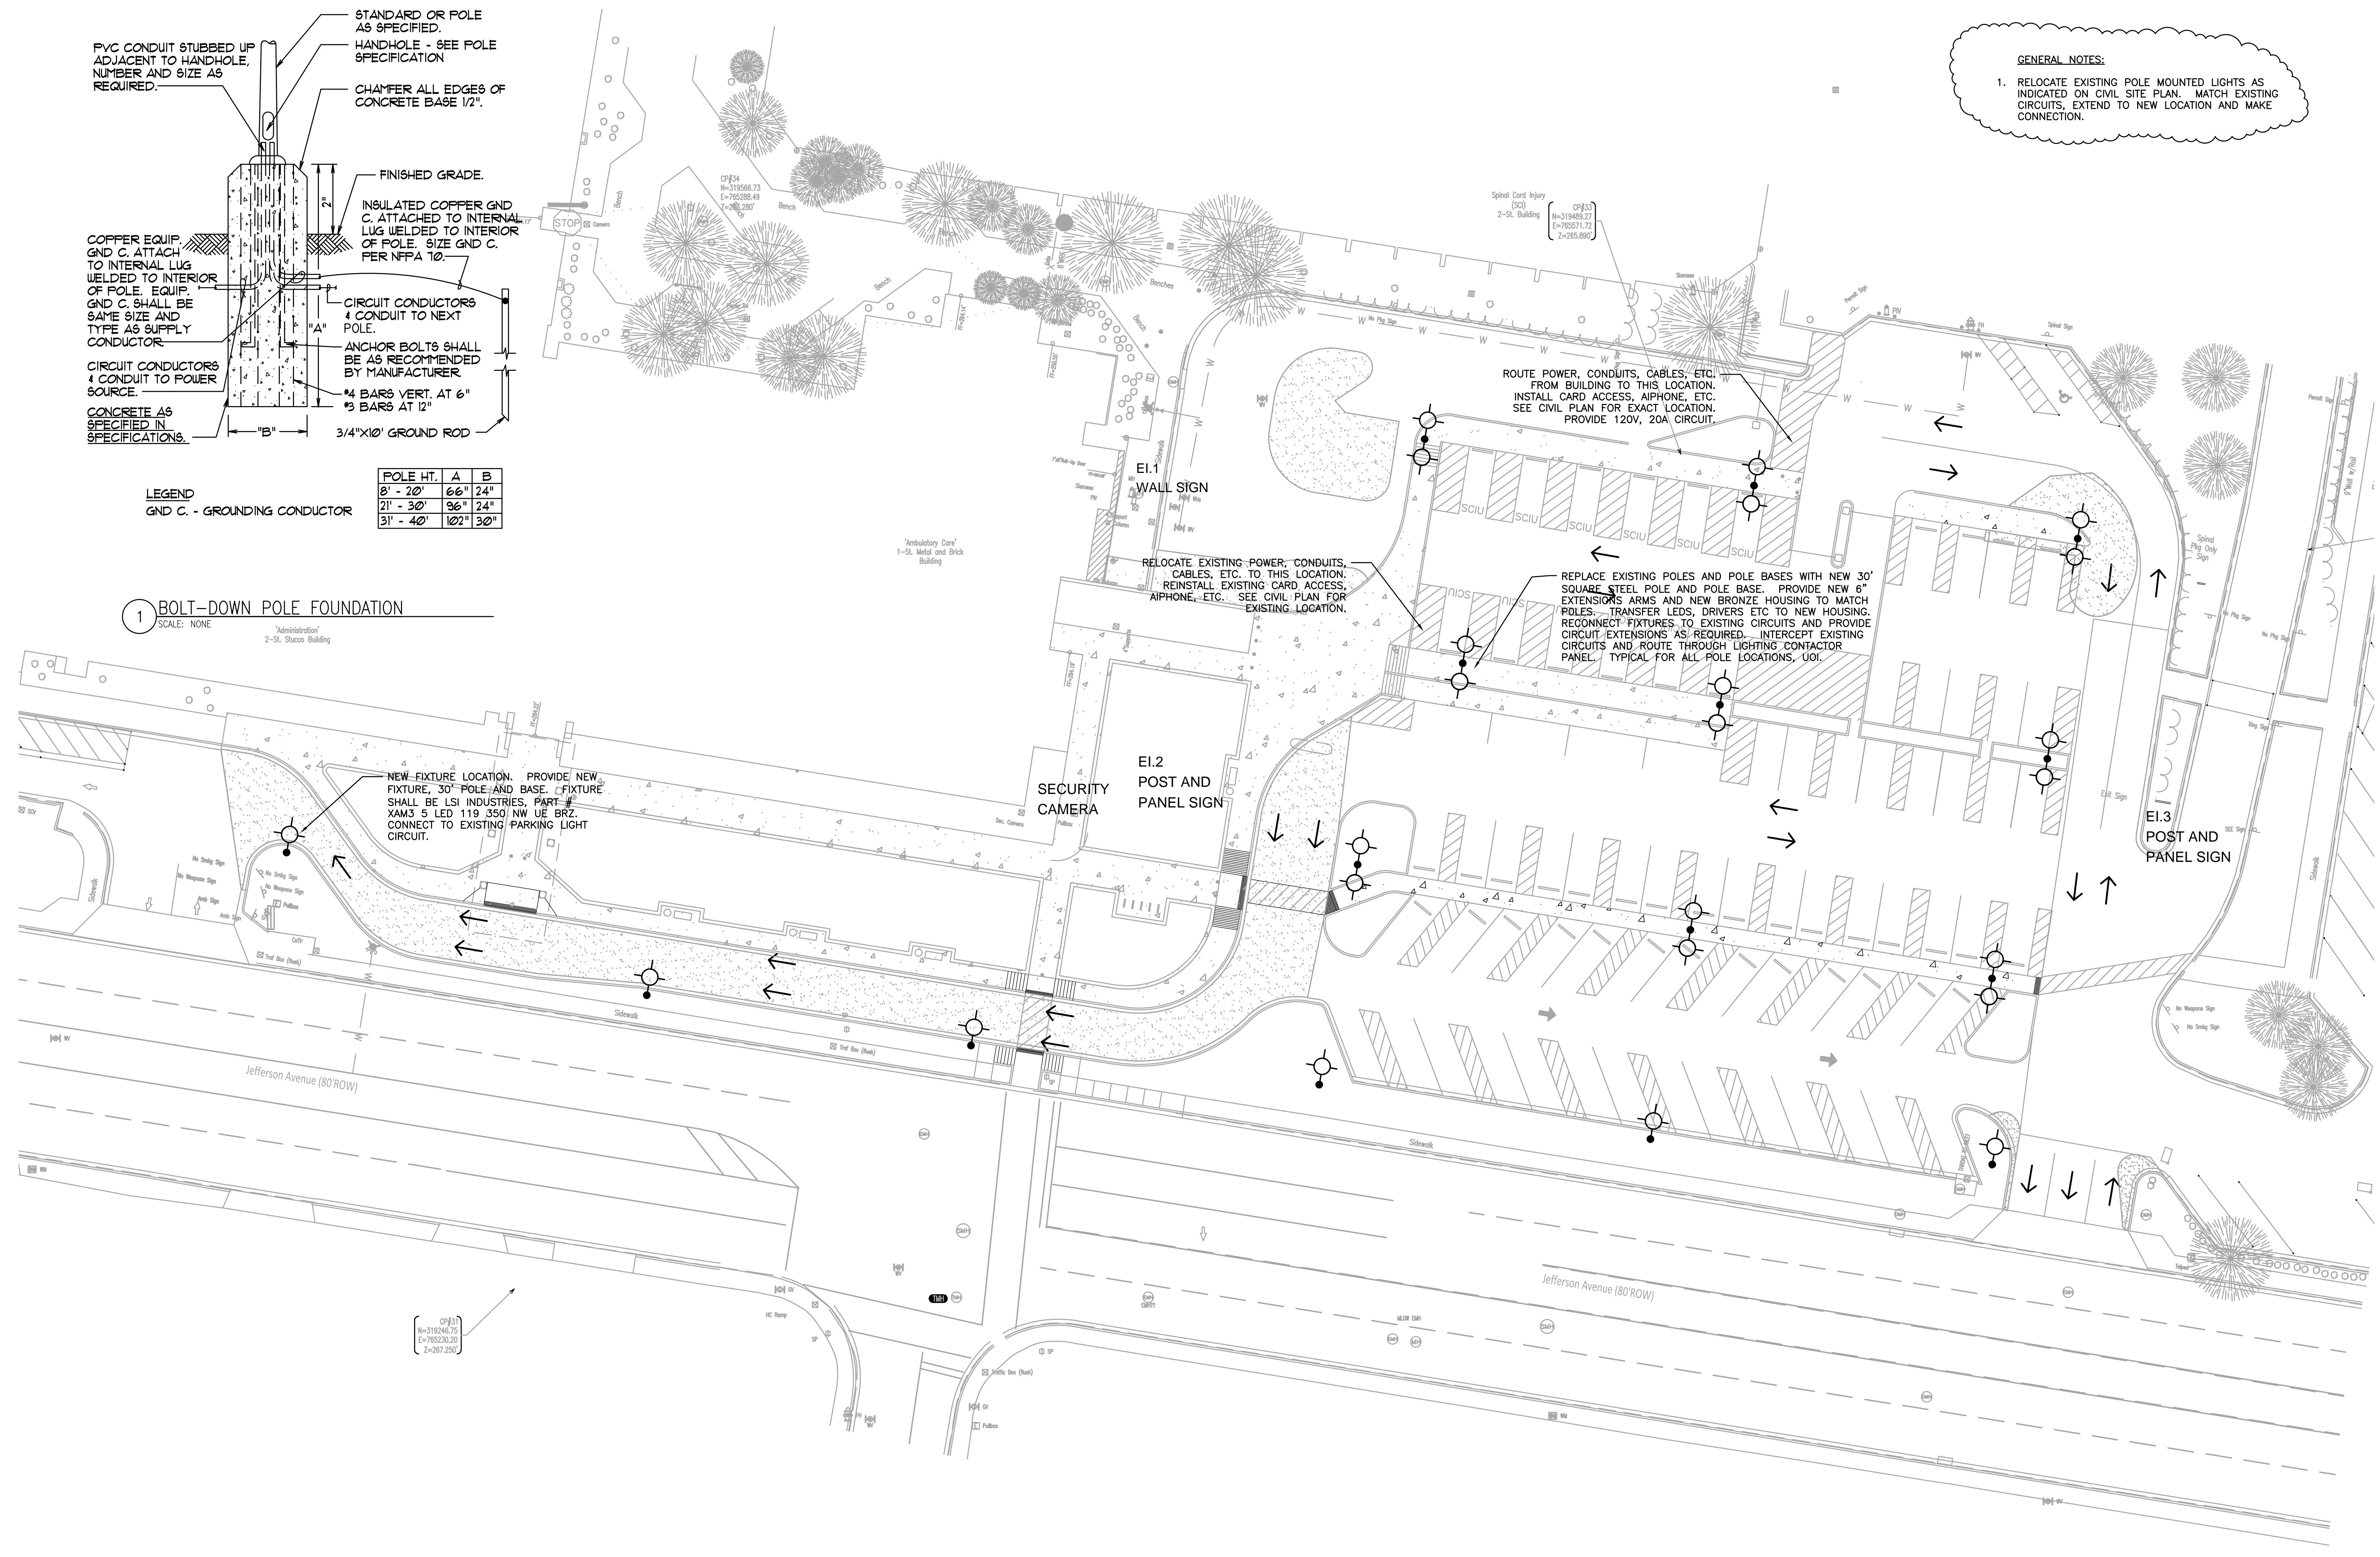

three inches = one foot  
 one and one half inches = one foot  
 one quarter inch = one foot  
 one half inch = one foot  
 three eighths inch = one foot  
 one eighth inch = one foot


FULLY SPRINKLERED

REVISIONS:	DATE:
1	11/22/2013
2	
3	
4	
100	

**CONSULTANTS:**

**Allen & Hoshall**  
 since 1915  
 ENGINEERS

1661 INTERNATIONAL DRIVE  
 Memphis, Tennessee 38120  
 t 901.820.0820  
 f 901.683.10017  
 www.allenhoshall.com

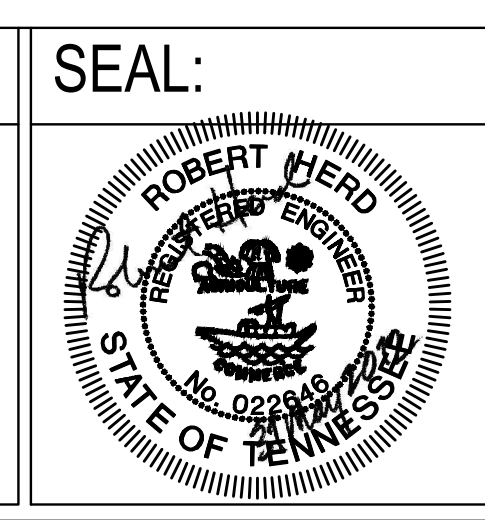

**ARCHITECT/ENGINEERS:**

**brg3s architects**

11 W. Huling Avenue  
 Memphis, Tennessee 38103  
 t 901.260.9600  
 f 301.531.8042  
 w brg3s.com

**DRAWING TITLE:**  
 SITE PLAN - ELECTRICAL (SUPPLEMENTAL)

SCALE: 1"=20'

APPROVED PROJECT DIRECTOR:

**PROJECT TITLE:**  
 EXPAND EMERGENCY ROOM

**PROJECT NUMBER:**  
 61804

**BUILDING NUMBER:**  
 1A

**LOCATION:**  
 VAMC, Memphis, Tennessee

**DATE:**  
 May 31, 2012

**CHECKED:**  
 RTH

**DRAWN:**  
 MEB

**DRAWING NUMBER:**  
 ES101.1

DWG. OF