


AS-BUILTS

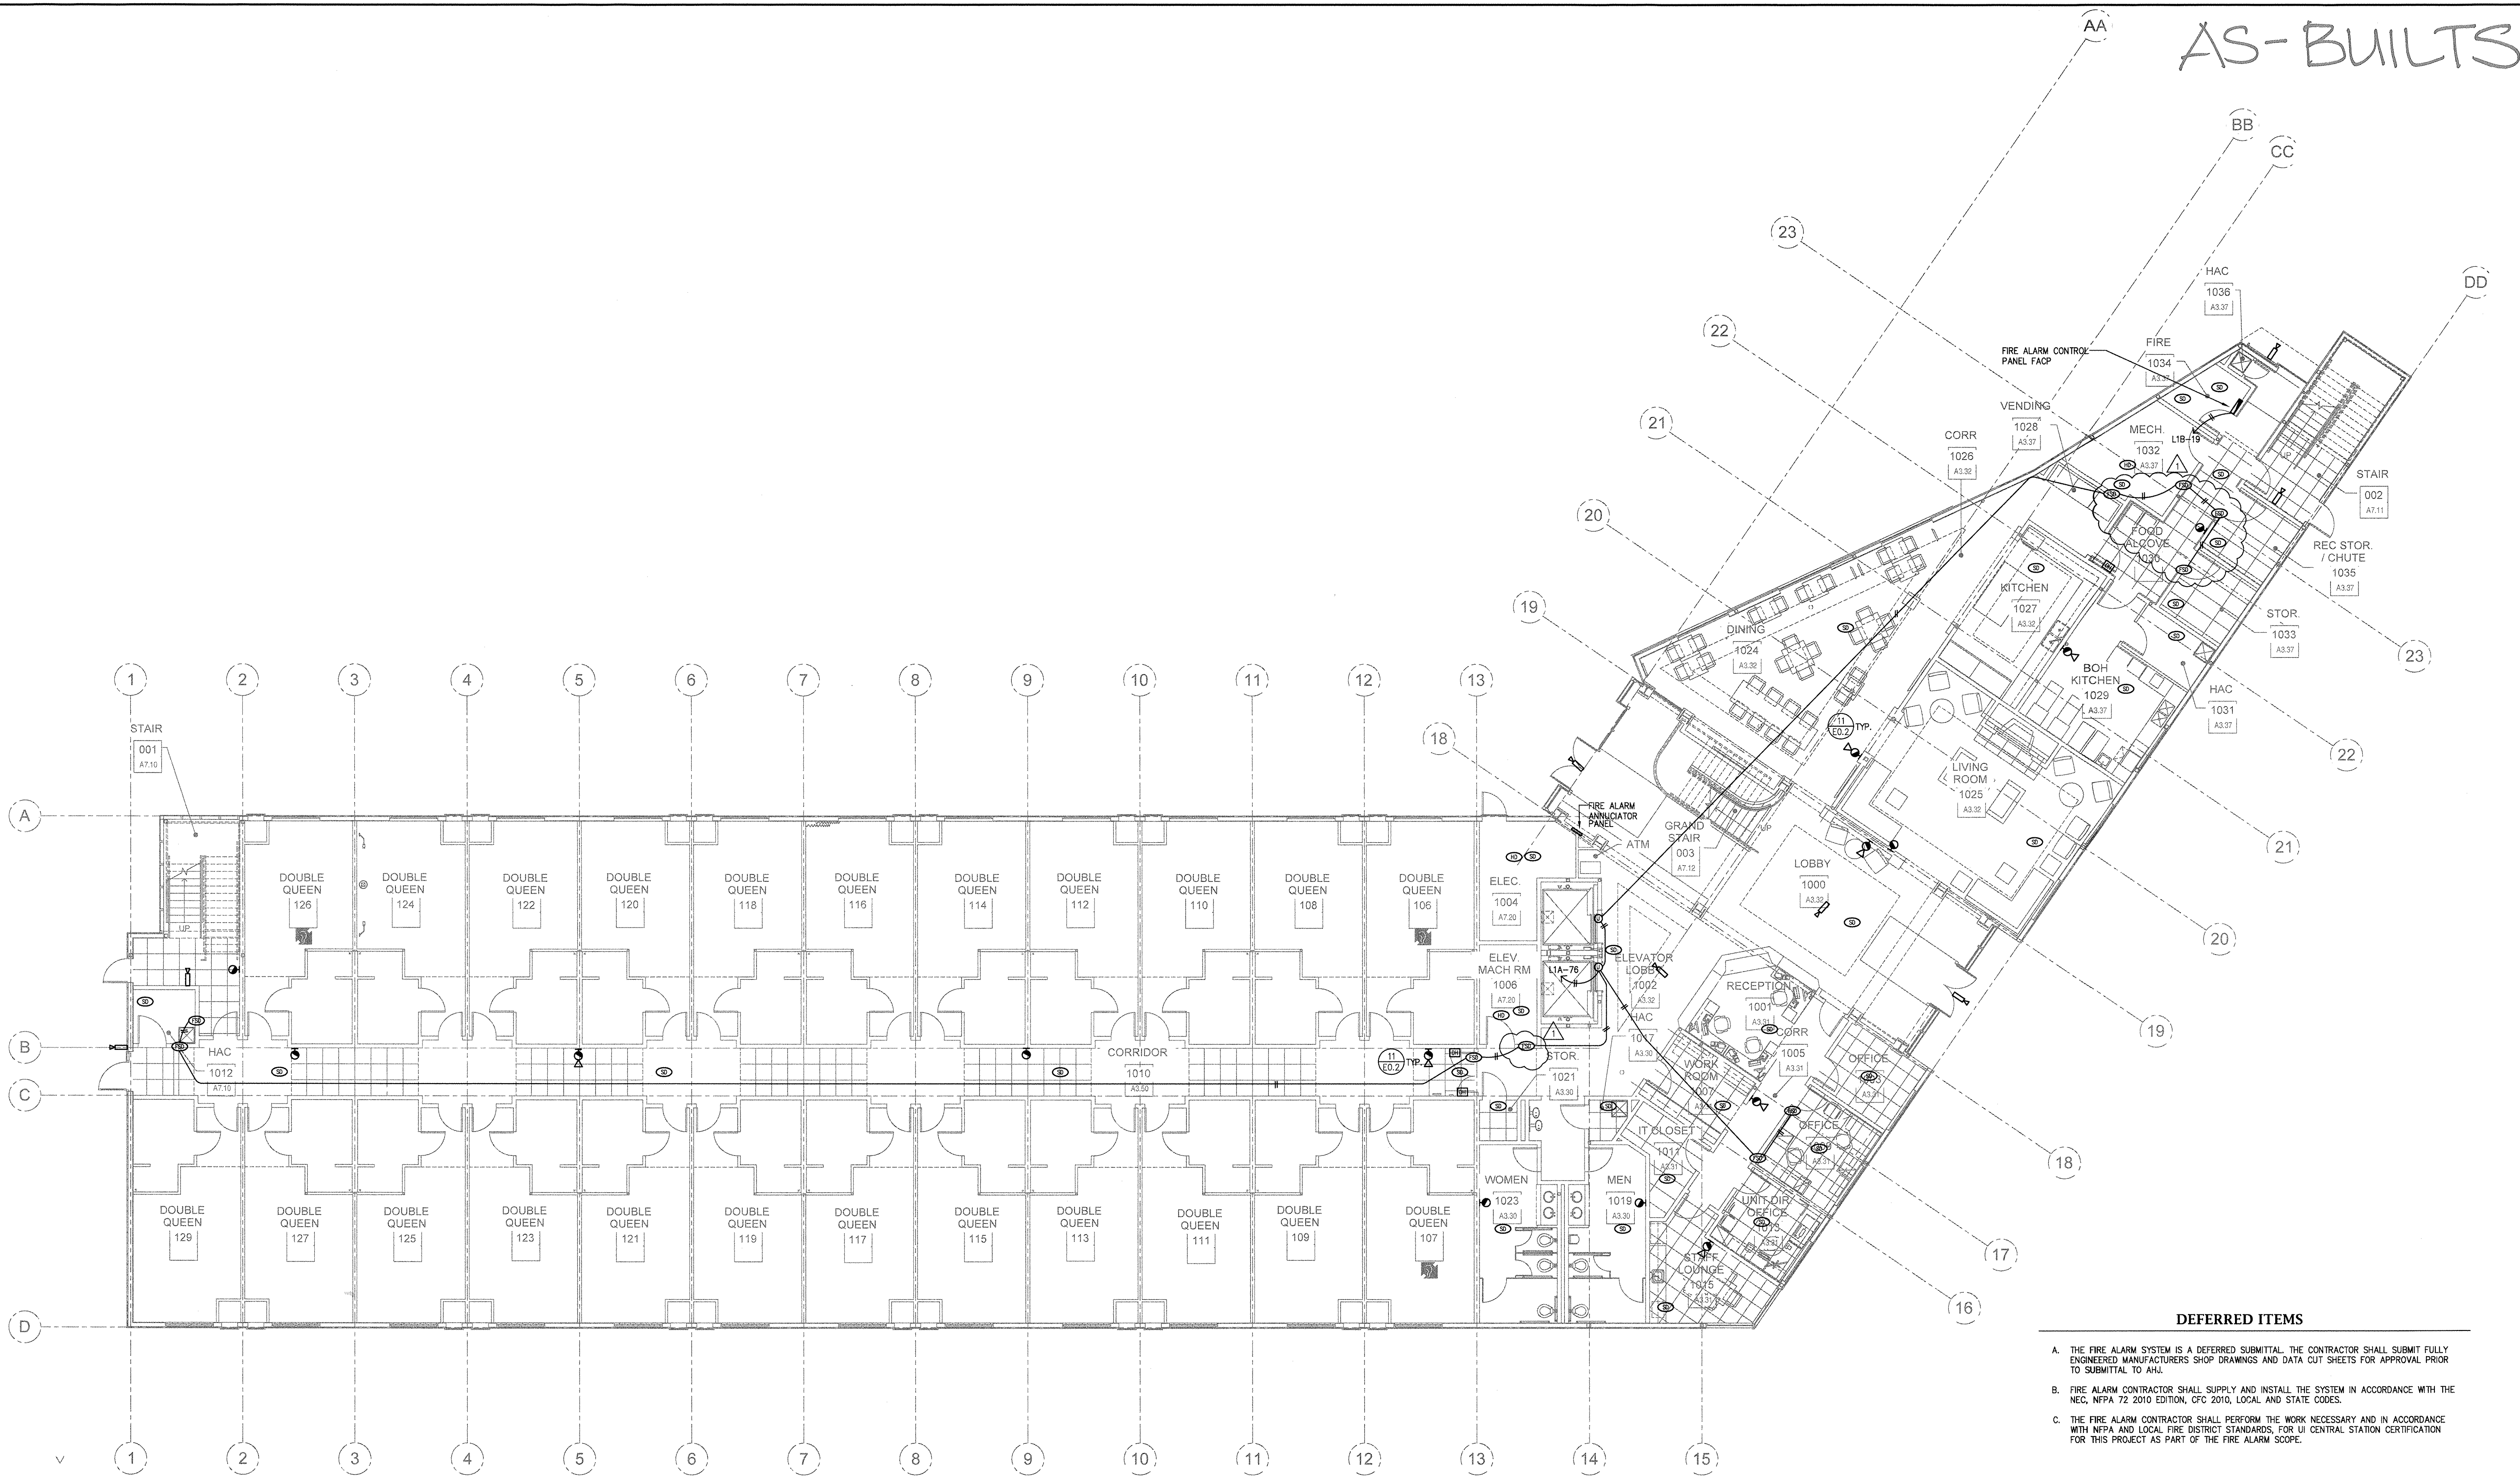

1 FIRST FLOOR SIGNAL PLAN  
1/8" = 1'-0"


DEFERRED ITEMS

- A. THE FIRE ALARM SYSTEM IS A DEFERRED SUBMITTAL. THE CONTRACTOR SHALL SUBMIT FULLY ENGINEERED MANUFACTURERS SHOP DRAWINGS AND DATA CUT SHEETS FOR APPROVAL PRIOR TO SUBMITTAL TO A.H.J.
- B. FIRE ALARM CONTRACTOR SHALL SUPPLY AND INSTALL THE SYSTEM IN ACCORDANCE WITH THE NEC, NFPA 72 2010 EDITION, CFC 2010, LOCAL AND STATE CODES.
- C. THE FIRE ALARM CONTRACTOR SHALL PERFORM THE WORK NECESSARY AND IN ACCORDANCE WITH NFPA AND LOCAL FIRE DISTRICT STANDARDS, FOR UL CENTRAL STATION CERTIFICATION FOR THIS PROJECT AS PART OF THE FIRE ALARM SCOPE.

100% DESIGN DEVELOPMENT	07-07-11
50% CONSTRUCTION DOCUMENTS	10-08-11
PLAN CHECK SUBMITTAL	09-23-12
CONSTRUCTION SET	08-14-12
Revisions	Date

**CONSULTANTS:**

**JRA**  
Electrical Engineers, Inc.  
851 Napa Valley Corporate Way, Suite D  
Napa, CA 94558  
707-226-8580 Fax: 707-226-8581  
1039 Serpentine Lane, Suite F  
Pleasanton, CA 94566  
925-249-0300 Fax: 925-249-0800

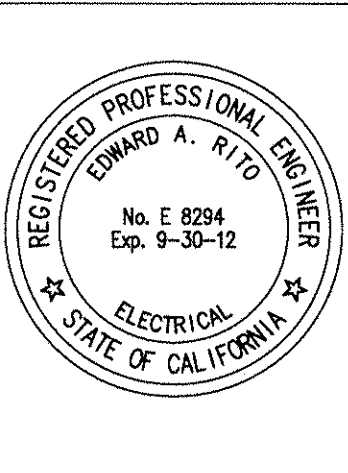

**ARCHITECT:**

**RYS**  
RYS ARCHITECTS  
INCORPORATED  
10 MONTEREY BOULEVARD  
SAN FRANCISCO, CALIFORNIA 94131  
TEL. 415-841-8090 FAX 415-841-8089

**DEVELOPER:**

**Gilbane**  
Gilbane Development Company

**OWNER:**

**PenFed Foundation**  
Because Military Heroes need heroes too

Drawing Title  
**FIRST FLOOR  
SIGNAL PLAN**

Approved: Project Director

Project Title  
**DEFENDERS  
LODGE**

Location  
**PALO ALTO, CA**

Date  
08-14-2012

Checked  
FJ

Drawn  
DB

Project Number  
**11105, JRA#11031**

Building Number

Drawing Number  
**E4.1**  
Dwg. SHT of XXX

Office of  
Construction  
and Facilities  
Management

Department of  
Veterans Affairs