

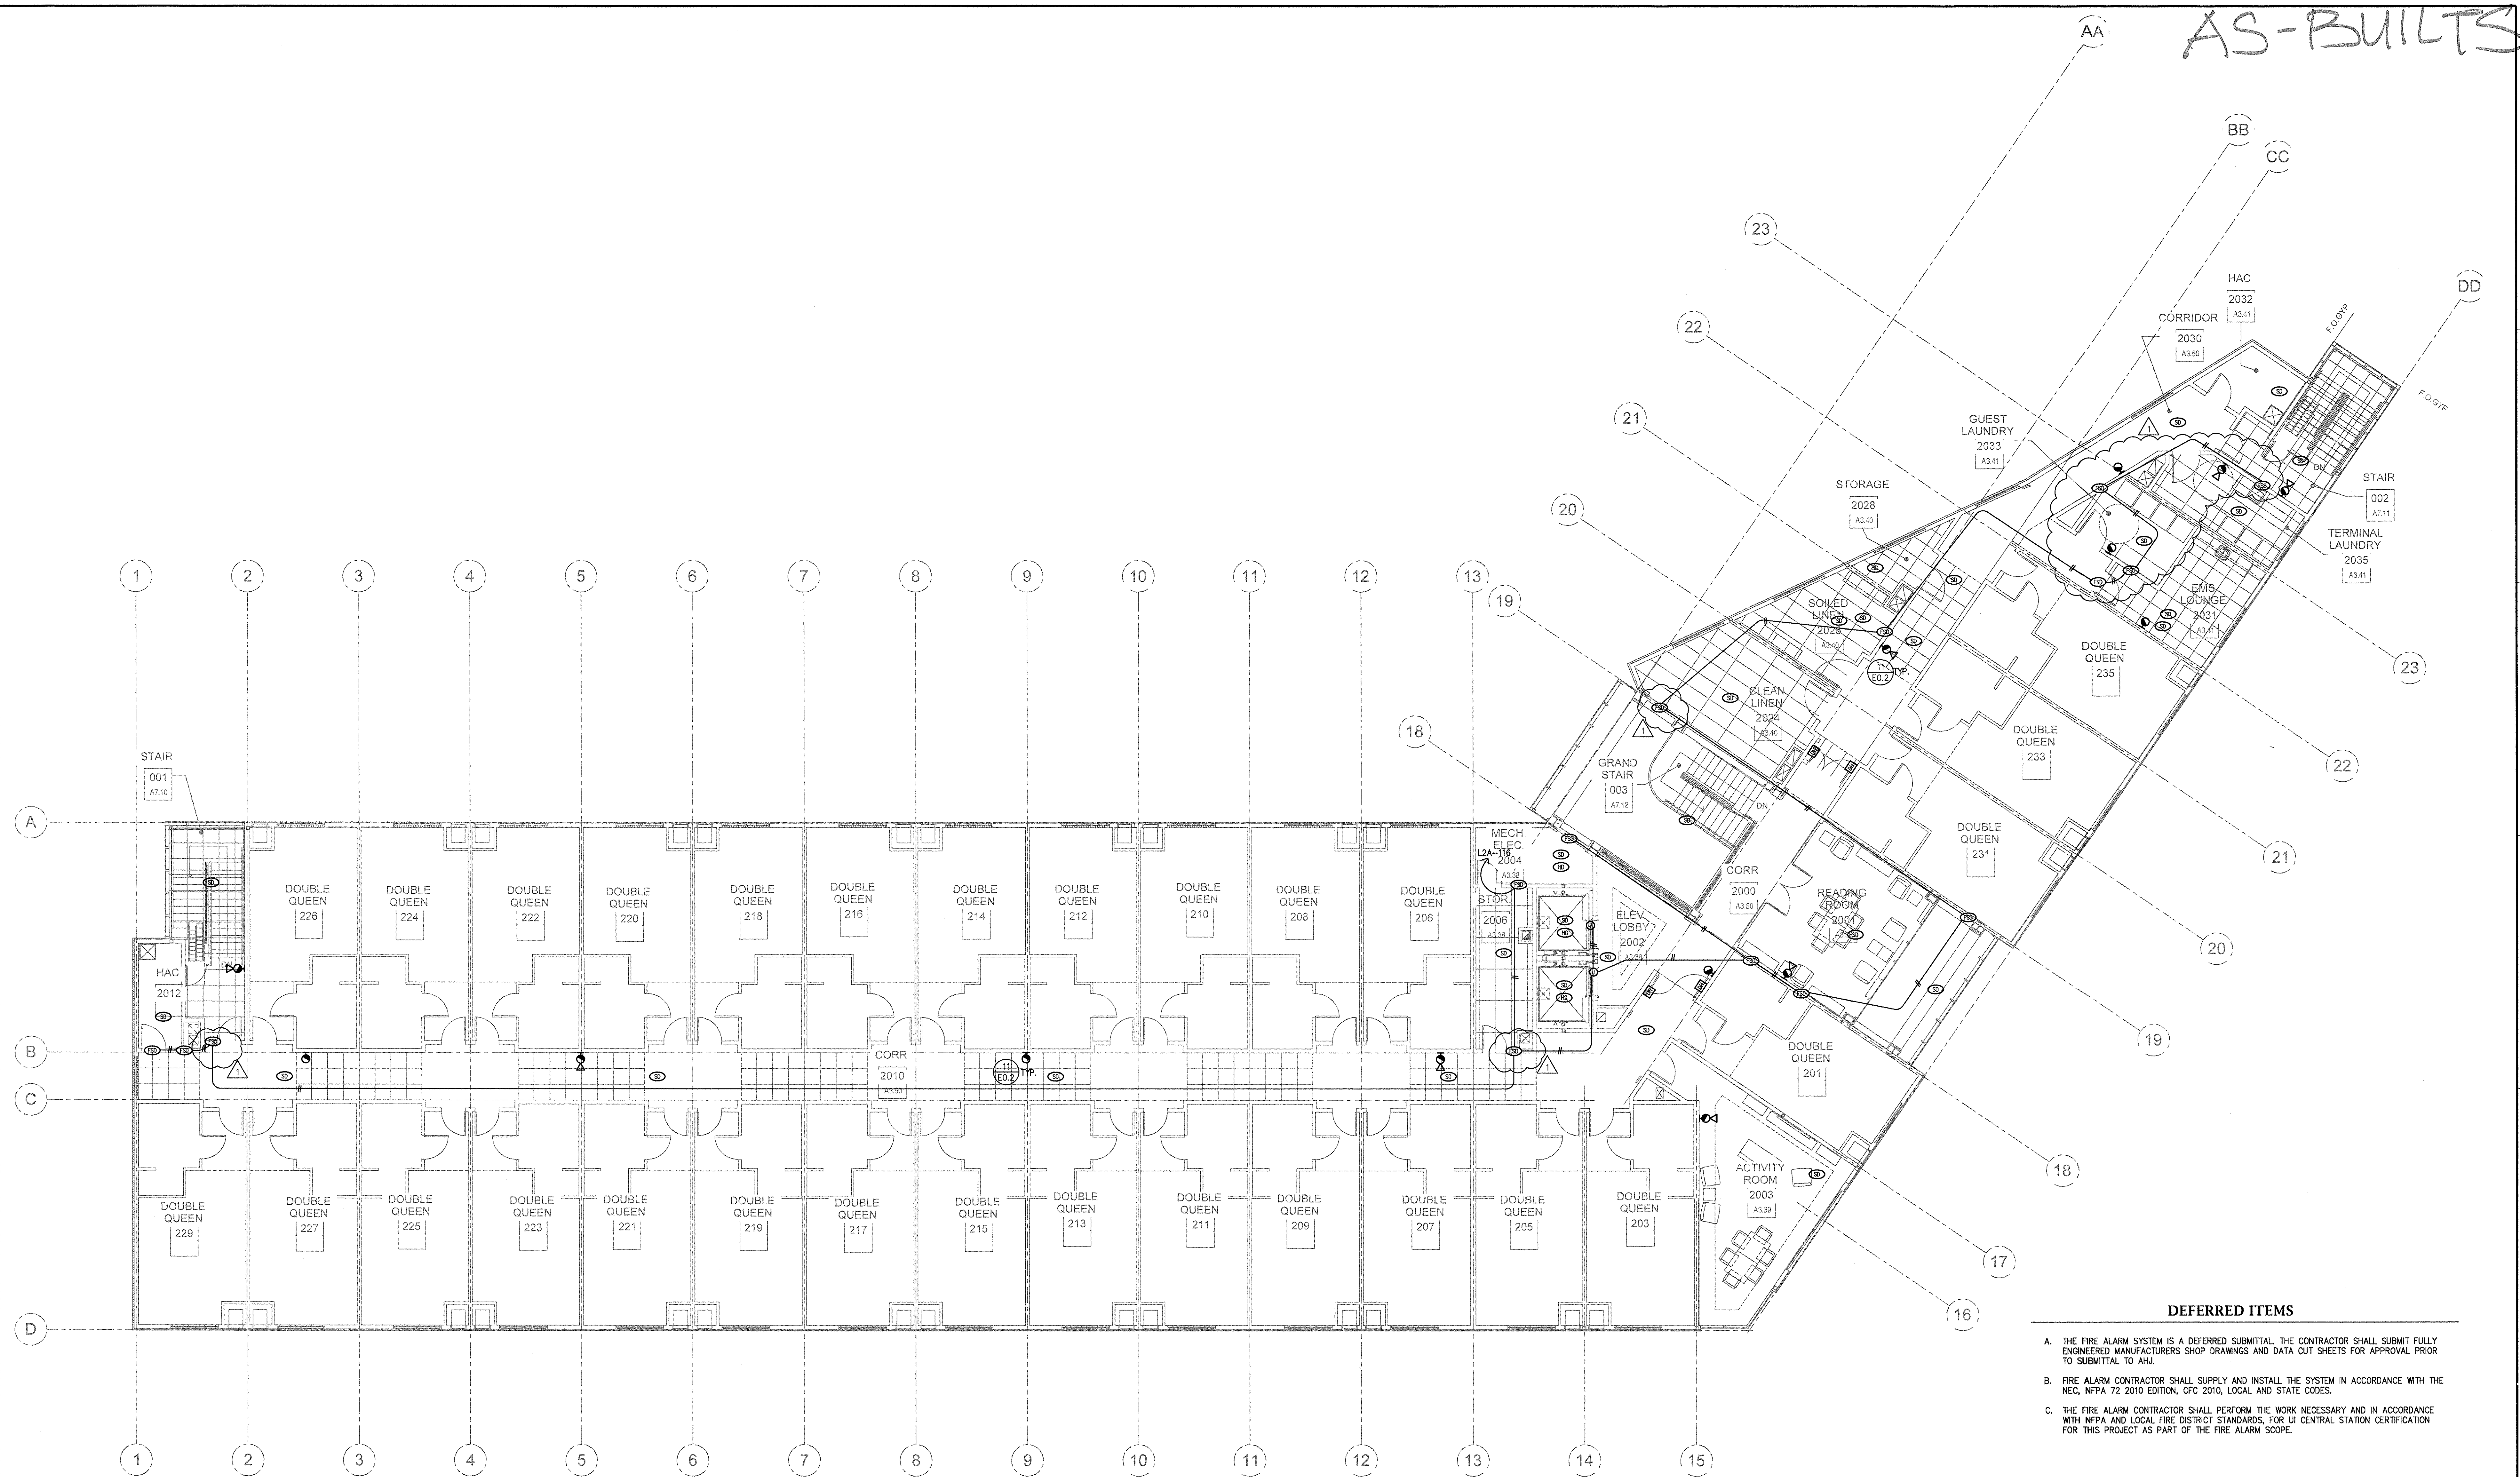


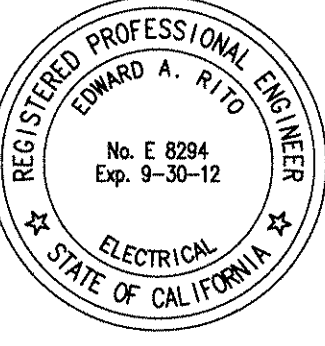

AS-BUILTS

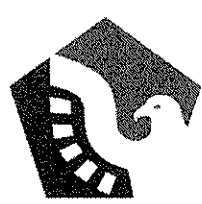

- DEFERRED ITEMS**
- A. THE FIRE ALARM SYSTEM IS A DEFERRED SUBMITTAL. THE CONTRACTOR SHALL SUBMIT FULLY ENGINEERED MANUFACTURERS SHOP DRAWINGS AND DATA CUT SHEETS FOR APPROVAL PRIOR TO SUBMITTAL TO AHJ.
 - B. FIRE ALARM CONTRACTOR SHALL SUPPLY AND INSTALL THE SYSTEM IN ACCORDANCE WITH THE NEC, NFPA 72 2010 EDITION, CFC 2010, LOCAL AND STATE CODES.
 - C. THE FIRE ALARM CONTRACTOR SHALL PERFORM THE WORK NECESSARY AND IN ACCORDANCE WITH NFPA AND LOCAL FIRE DISTRICT STANDARDS, FOR UL CENTRAL STATION CERTIFICATION FOR THIS PROJECT AS PART OF THE FIRE ALARM SCOPE.

1 SECOND FLOOR SIGNAL PLAN
1/8"=1'-0"

100% DESIGN DEVELOPMENT 07-07-11 50% CONSTRUCTION DOCUMENTS 10-08-11 PLAN CHECK SUBMITTAL 09-23-12 CONSTRUCTION SET 09-14-12	CONSULTANTS: JRA Electrical Engineers, Inc. 551 Napa Valley Corporate Way, Suite D Napa, CA 94558 707-226-8580 Fax: 707-226-8581 1039 Serpentine Lane, Suite F Pleasanton, CA 94566 925-249-0300 Fax: 925-249-0800	 ARCHITECT: RYS RYS ARCHITECTS INCORPORATED 10 MONTEREY BOULEVARD SAN FRANCISCO, CALIFORNIA 94131 TEL 415-841-9090 FAX 415-841-9099	DEVELOPER: Gilbane Gilbane Development Company	OWNER:  PenFed Foundation Because Military Heroes need heroes too	Drawing Title SECOND FLOOR SIGNAL PLAN Approved Project Director	Project Title  Location PALO ALTO, CA Date 08-14-2012 Checked PJ Drawn DB	Project Number 11105, JRA#11031 Building Number Drawing Number E4.2 Dwg. GHT of XXX	Office of Construction and Facilities Management  Department of Veterans Affairs
---	--	--	--	---	---	--	--	---