



V.A. ROSEBURG MEDICAL CENTER
E85 FUELING CENTER
PROJECT NO. 653-327, VA701-13-J-0087 (Rb)

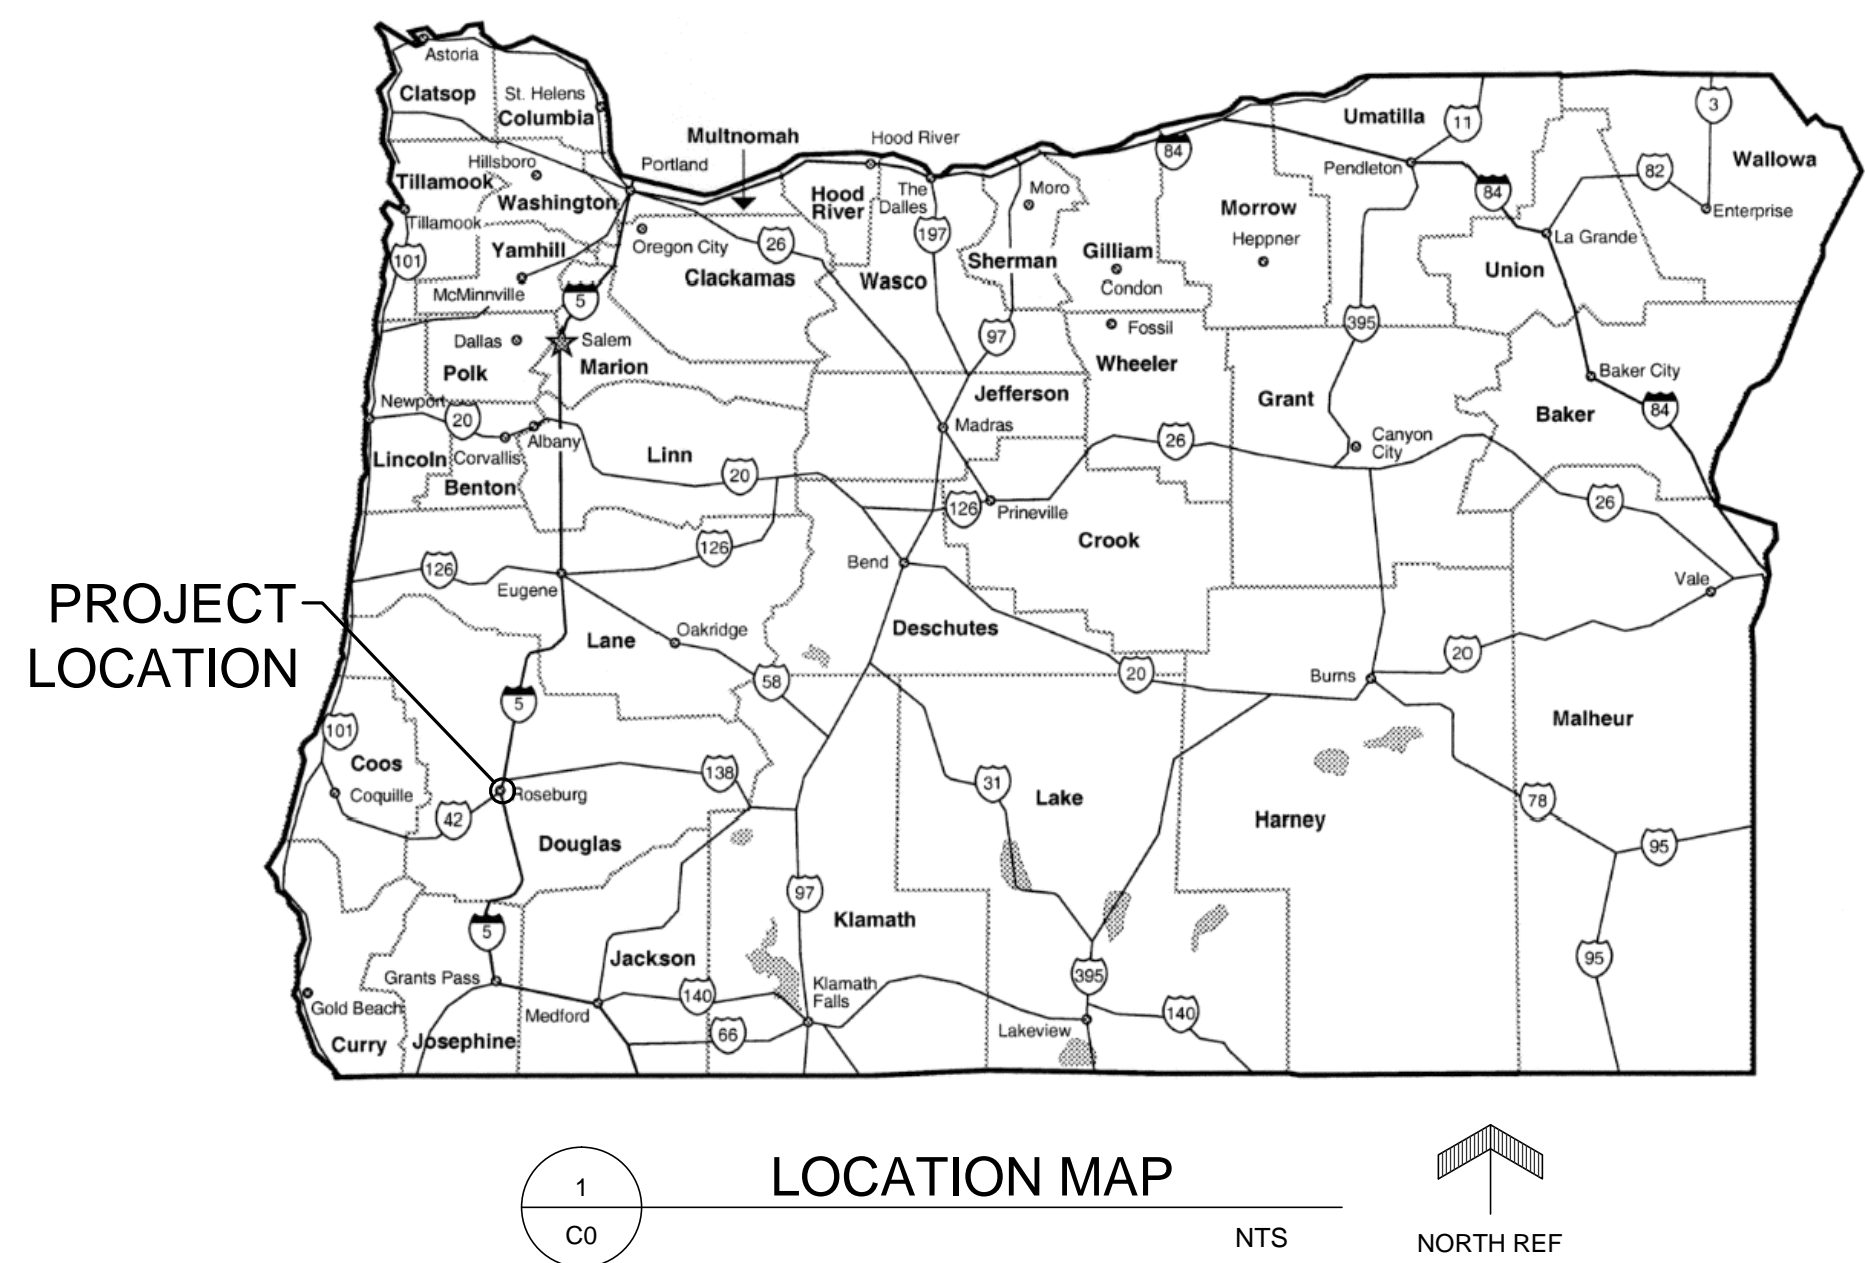

SHEET INDEX

- C0 COVER SHEET
C1 EXISTING SITE OVERVIEW
C2 SITE PLAN
C3 FUEL TANK FOUNDATION PLAN & GRADING PLAN
C4 CIVIL DETAILS & ABOVE GROUND FUEL SYSTEM DETAIL
C5 STRUCTURAL DETAILS
E1 ELECTRICAL SITE PLAN
E2 ELECTRICAL SCHEDULES, DETAILS, & DIAGRAMS

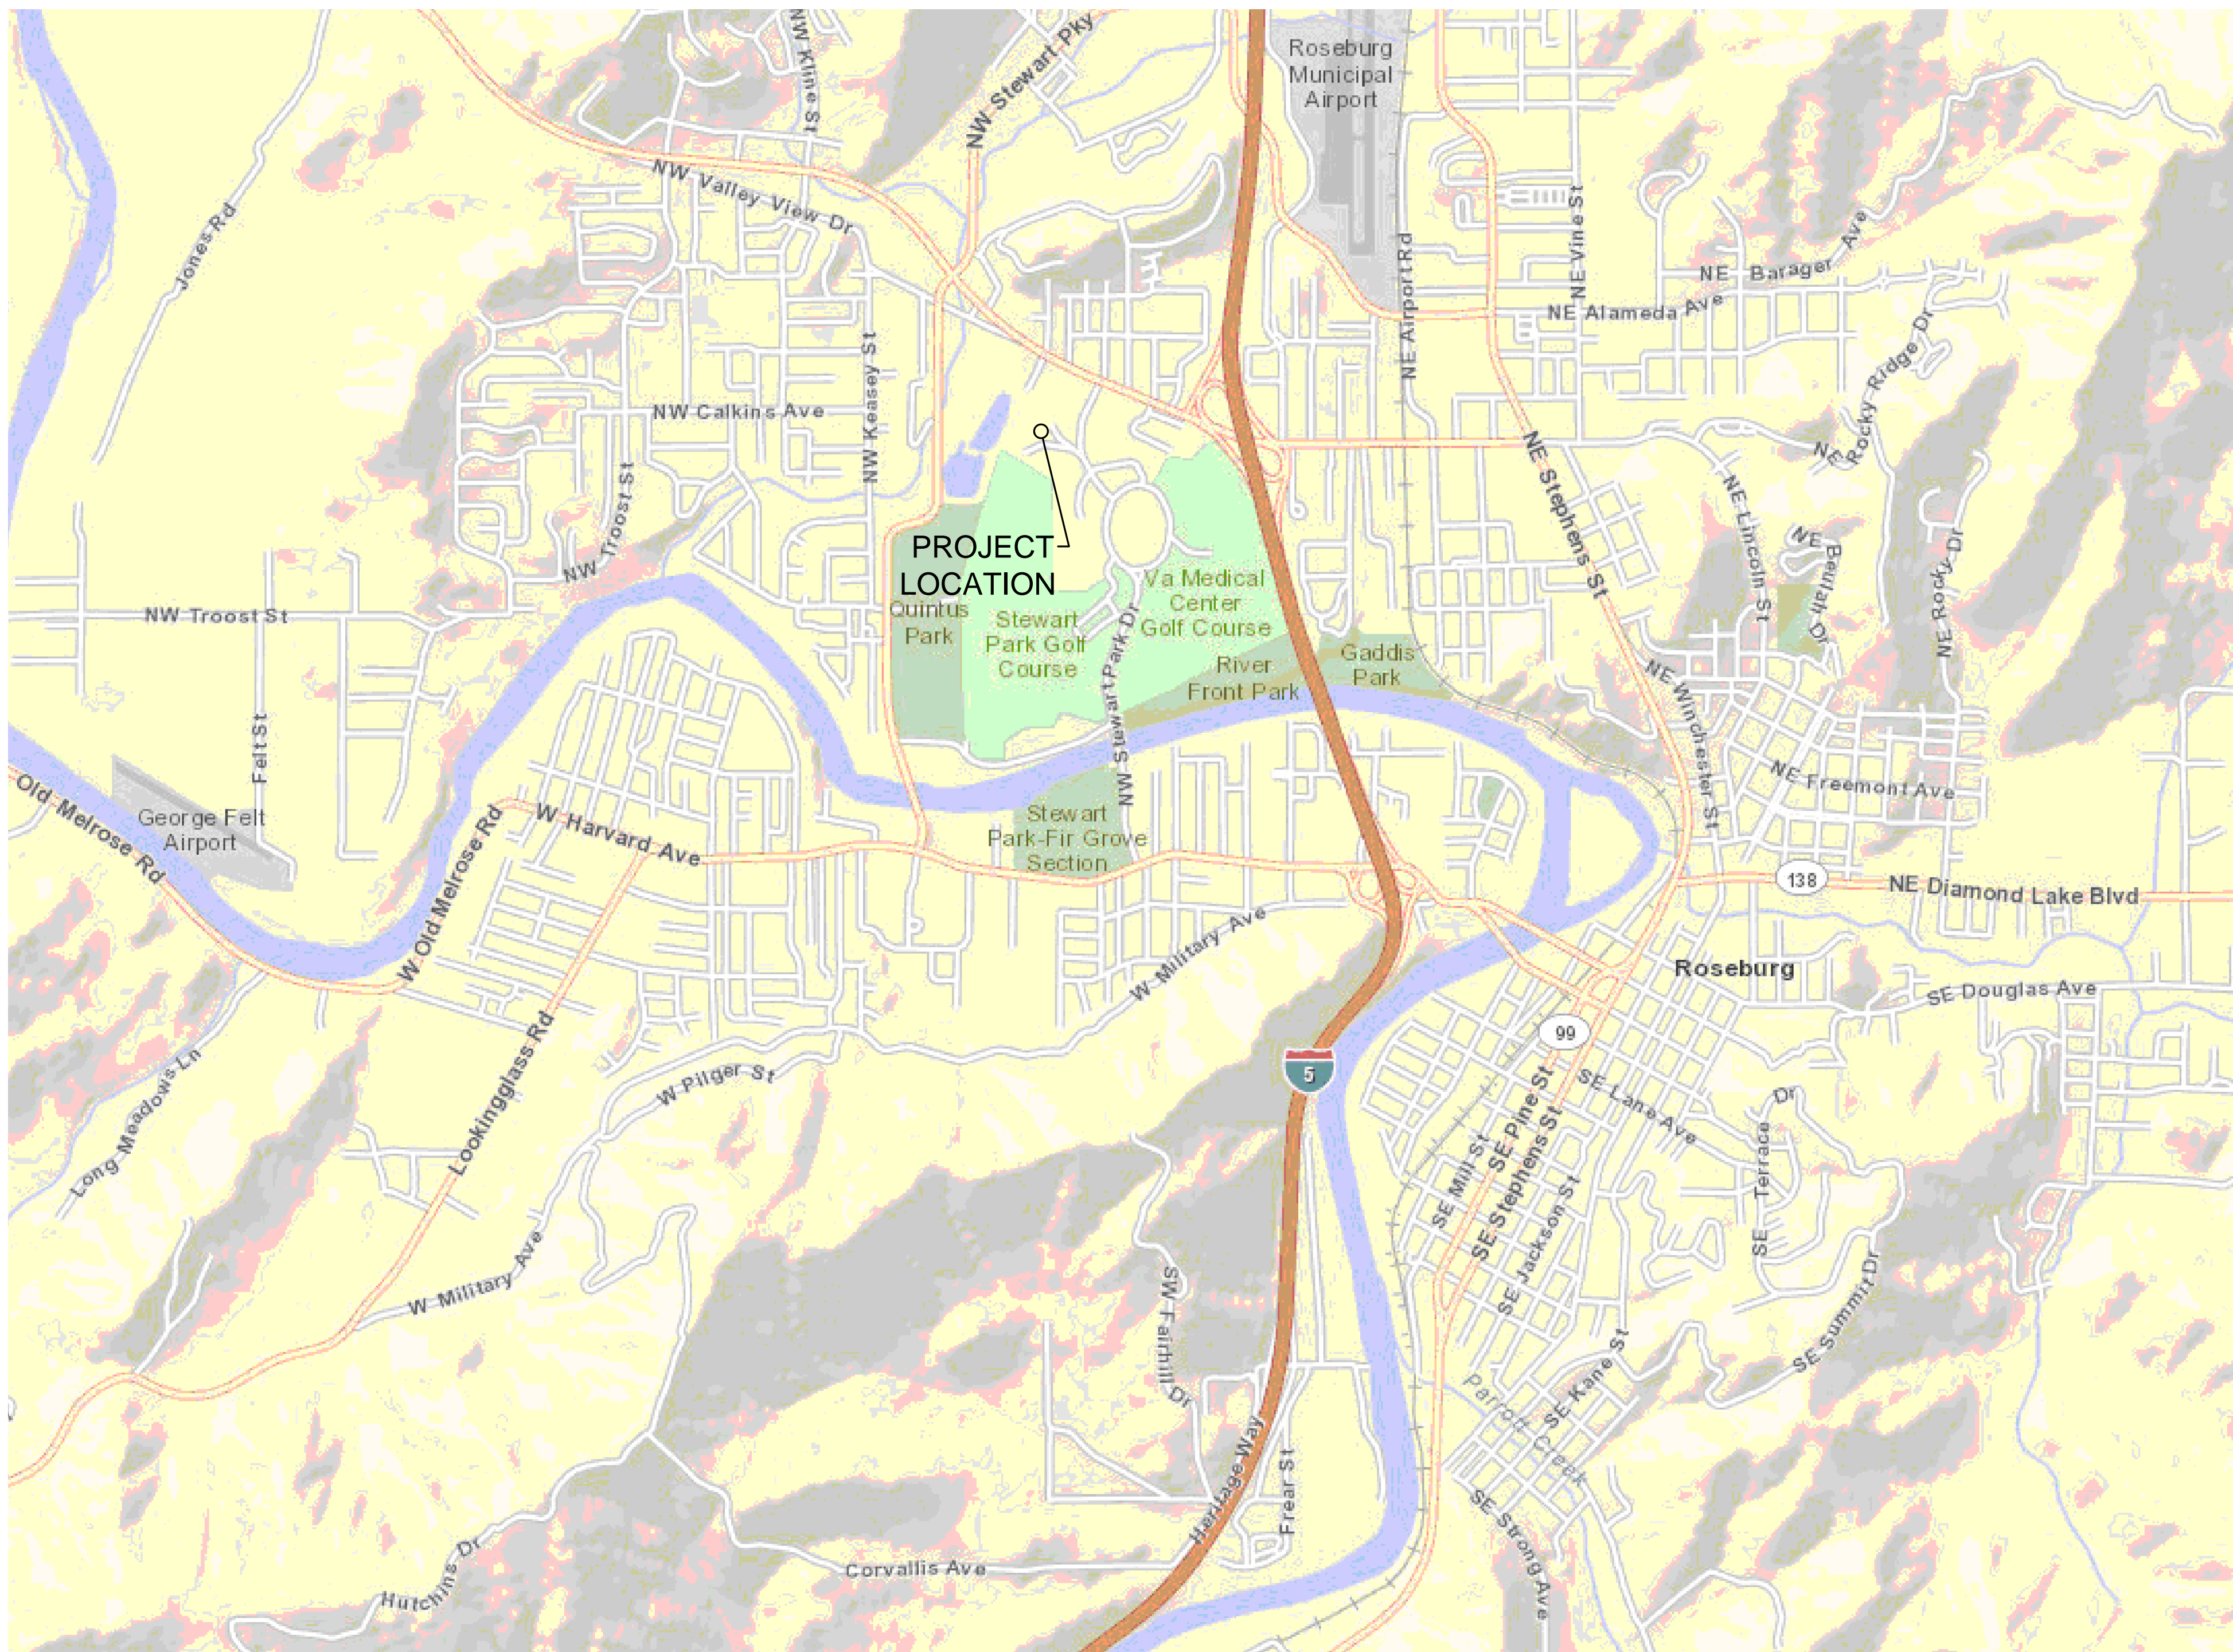

VA VHAROS DIRECTOR _____ DATE _____

ASSOCIATE DIRECTOR _____ DATE _____

CHIEF FACILITIES AND ENGINEERING _____ DATE _____

CHIEF OF STAFF _____ DATE _____

INFECTION CONTROL _____ DATE _____

AFGE _____ DATE _____

SAFETY MANAGER _____ DATE _____

CHIEF OF ITOS _____ DATE _____

_____ DATE _____

REVISIONS:	DATE:
---	---
CAD FILE NAME: RVACO	



DEPARTMENT OF VETERANS AFFAIRS
VA ROSEBURG MEDICAL CENTER
913 NW GARDEN VALLEY BLVD.
ROSEBURG, OR. 97471
(541) 440-1000

PROJECT TITLE: E85 FUELING CENTER		DRAWING TITLE: COVER SHEET		PROJECT NO: 653-327, VA701-13-J-0087 (Rb)	
RECOMMENDED BY: FMS MANAGER		REVIEWED BY: COTR		DATE: 10/24/2013	
APPROVED BY: DIRECTOR		LOCATION: ROSEBURG, OR		SHEET NO: C0	

