


three inches = one foot  
one and one-half inches = one foot  
one inch = one foot  
three-quarters inch = one foot  
one-half inch = one foot  
three-eighths inch = one foot  
one-quarter inch = one foot  
one-eighth inch = one foot



DRAWING NOTES:  
A. NO WORK REQUIRED THIS AREA. SHEET INCLUDED FOR COMPLETENESS OF RECORD DRAWINGS.

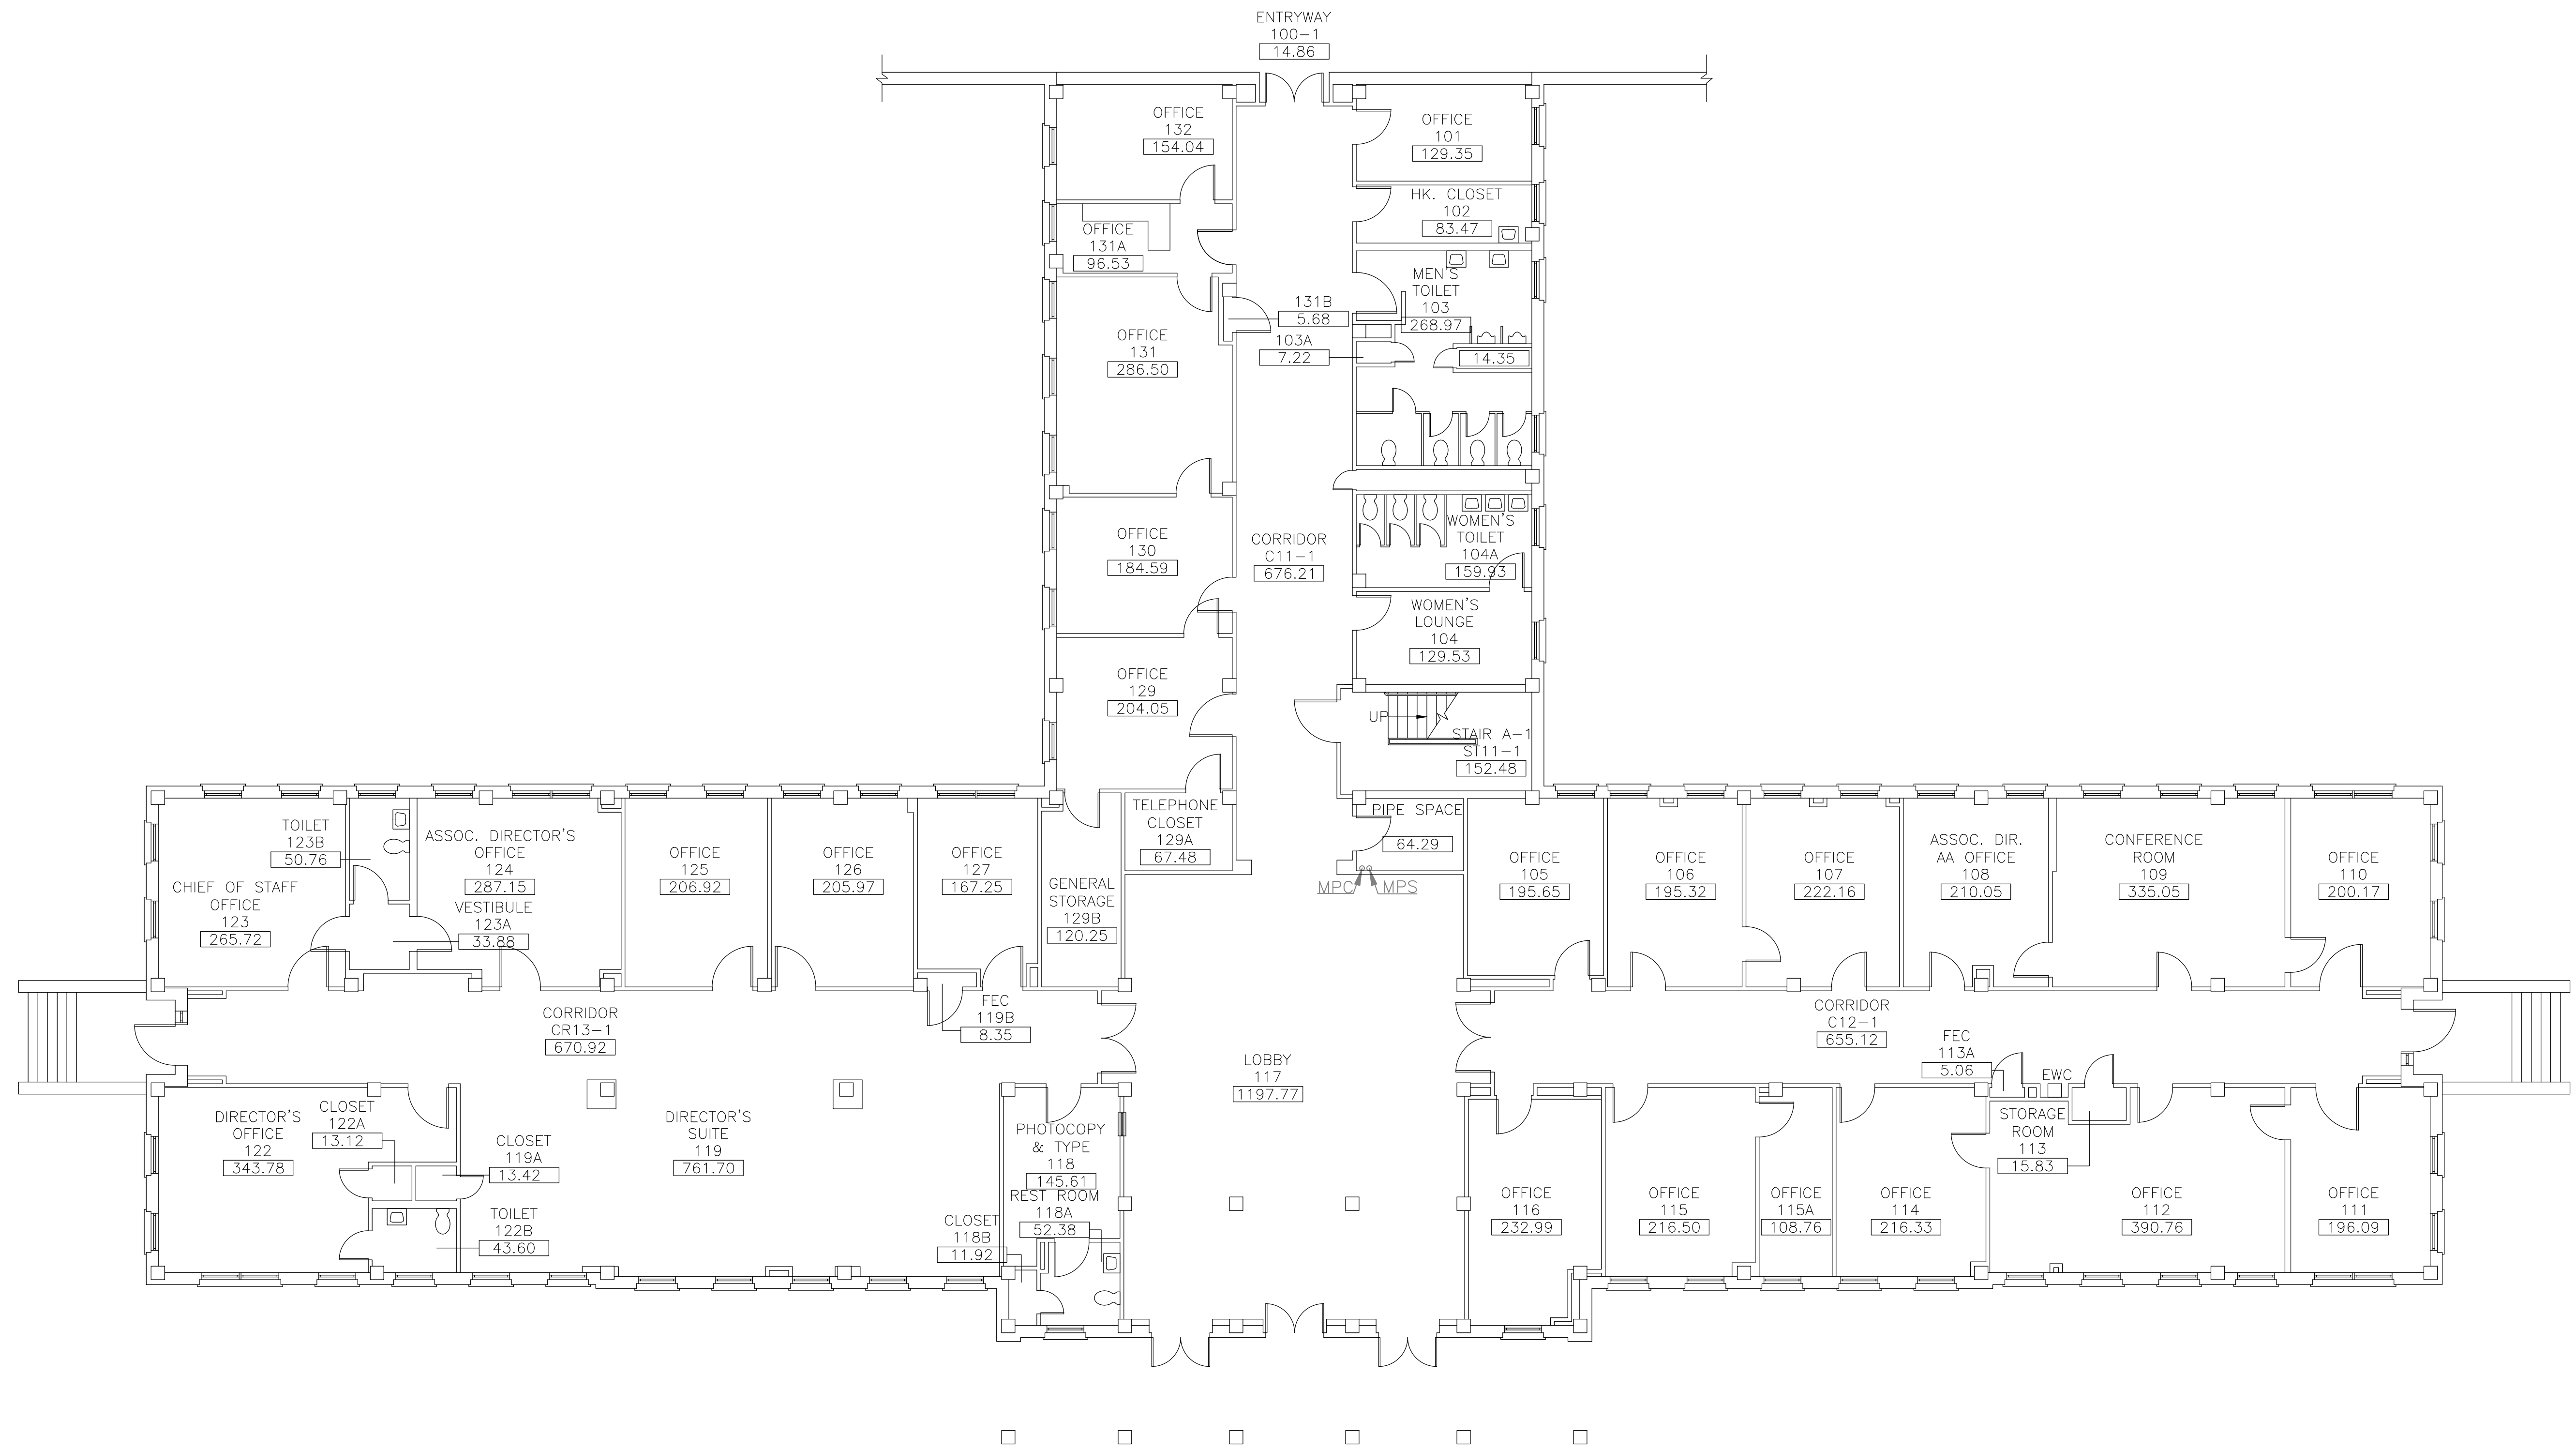

Revisions	Date

**AES**  
APPLIED ENGINEERING  
SOLUTIONS  
440 Martin Luther King, Jr. Blvd., Suite 401  
Macon, Georgia 31201  
(478) 314-1270  
www.aes-pe.com

KEY PLAN  
SCALE: NONE

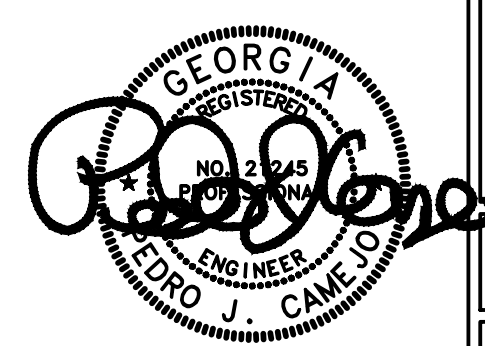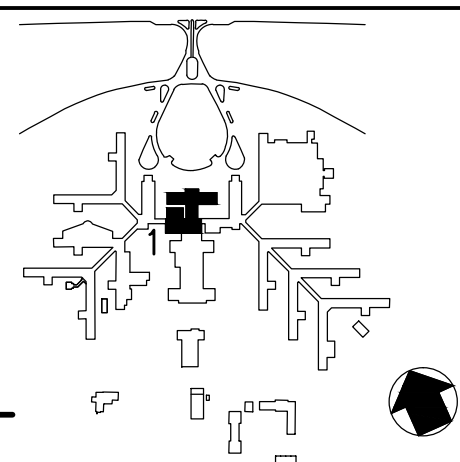

Drawing Title FIRST FLOOR PLAN		Project Title STEAM AND CONDENSATE PIPING SYSTEM STUDY		Date JUNE 22, 2012
Building Number 1		Checked PJC	Drawn JSW	Project No. 557-10-109
Location CARL VINSON VA MEDICAL CENTER DUBLIN, GEORGIA		Drawing No. 01-G-101		Dwg. 8 Of 87
FINAL SUBMITTAL		Veterans Administration		