



A. NO WORK REQUIRED THIS AREA. SHEET INCLUDED FOR COMPLETENESS OF RECORD DRAWINGS.

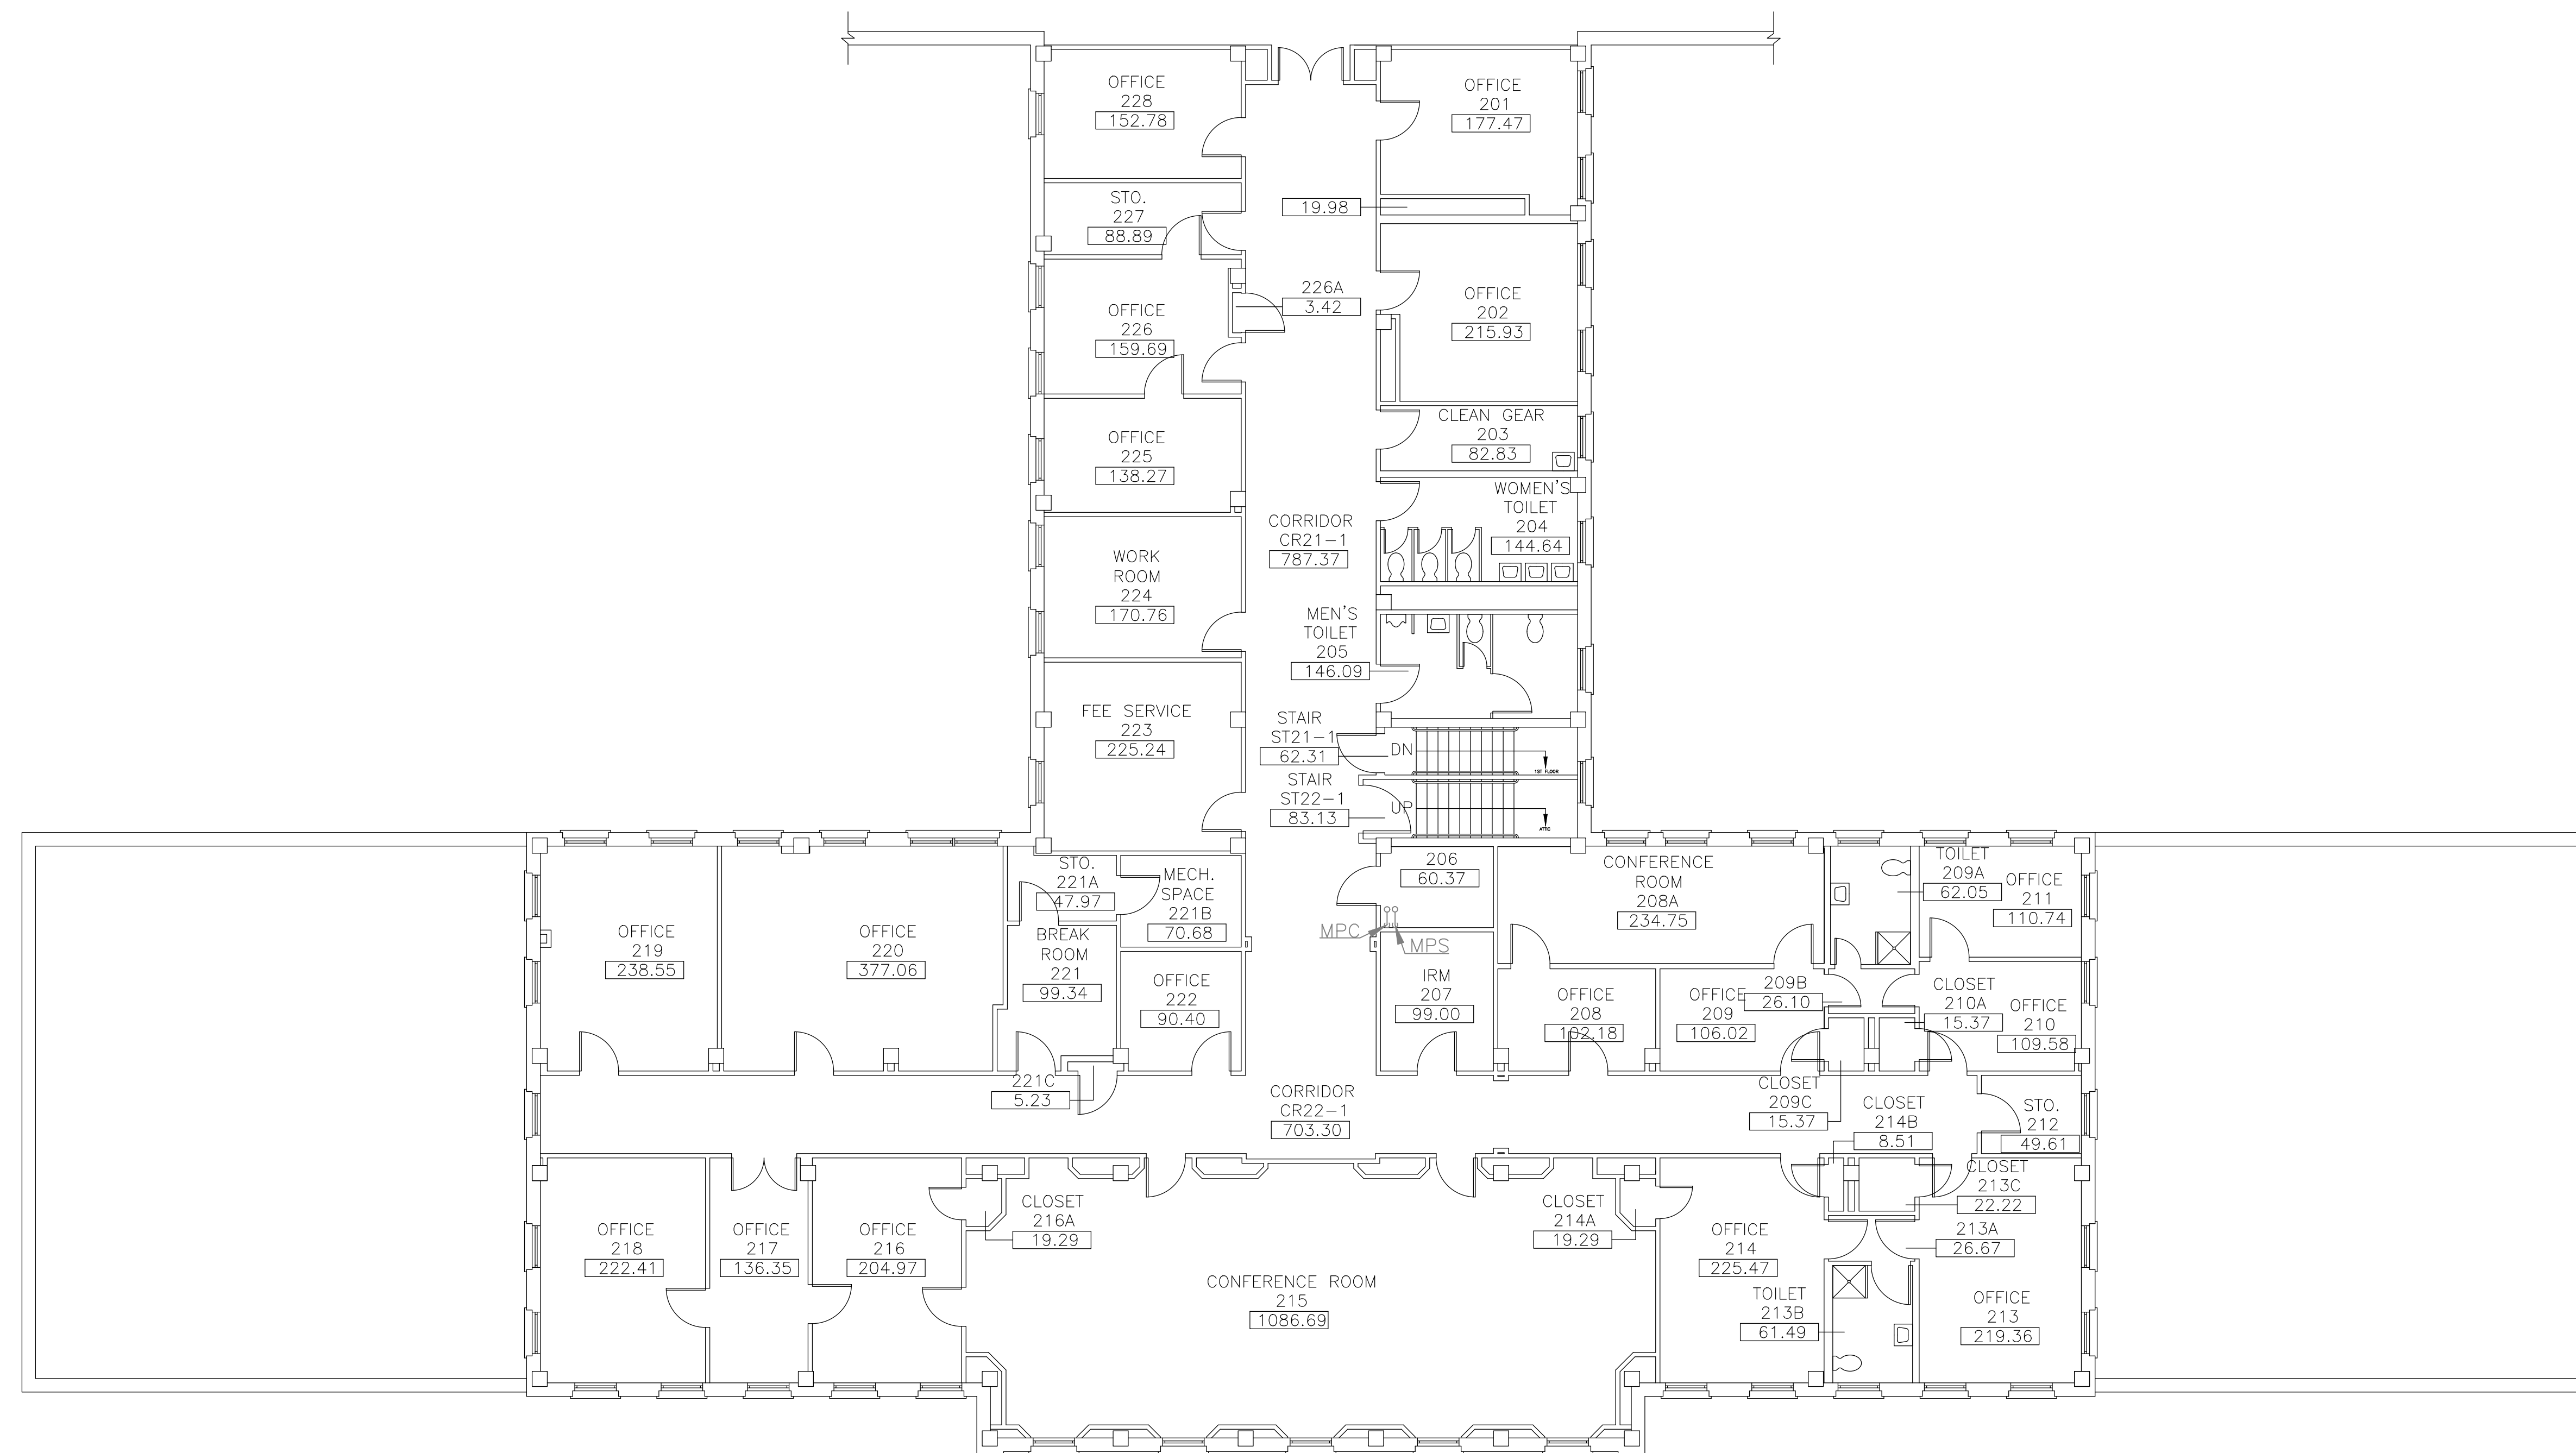


 **SECOND FLOOR PLAN**  
SCALE: 1/8" = 1'-0" 

[illegible]

440 Martin Luther King, Jr. Blvd., Suite 401  
Macon, Georgia 31201  
(478) 314-1270  
[www.aes-pe.com](http://www.aes-pe.com)

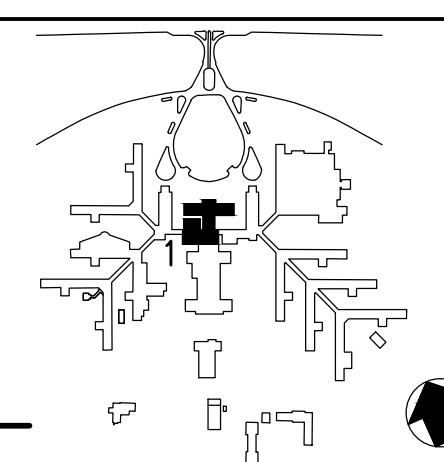

KEY PLAN  
SCALE: NONE

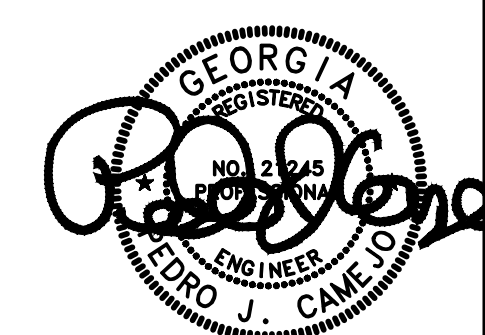

SECOND FLOOR PLAN

FINAL SUBMITTAL

STEAM AND CONDENSATE  
PIPING SYSTEM STUDY

Building Number	1
-----------------	---

Checked	PJC
---------	-----

Drawn  
JSW

Location	CARL VINSON VA MEDICAL CENTER DUBLIN, GEORGIA
----------	--

Date	JUNE 22, 2012
------	---------------

Project No.

	DRAWING NO.

01-G-20

Dwg. 9 Of 87

Veterans Administration