


three inches = one foot
one and one-half inches = one foot
one inch = one foot
three-quarters inch = one foot
one-half inch = one foot
one-third inch = one foot
three-eighths inch = one foot
one-quarter inch = one foot
one-eighth inch = one foot

A
B
C
D
E
F
G

NOTES:
(THIS SHEET ONLY)
① REMOVE AND HAUL AWAY IN ITS ENTIRETY HPS HEATING STEAM PIPING. TURN OVER TO VA COTR ALL VALVES AND STEAM TRAP TAGS THAT ARE NOT REUSED.

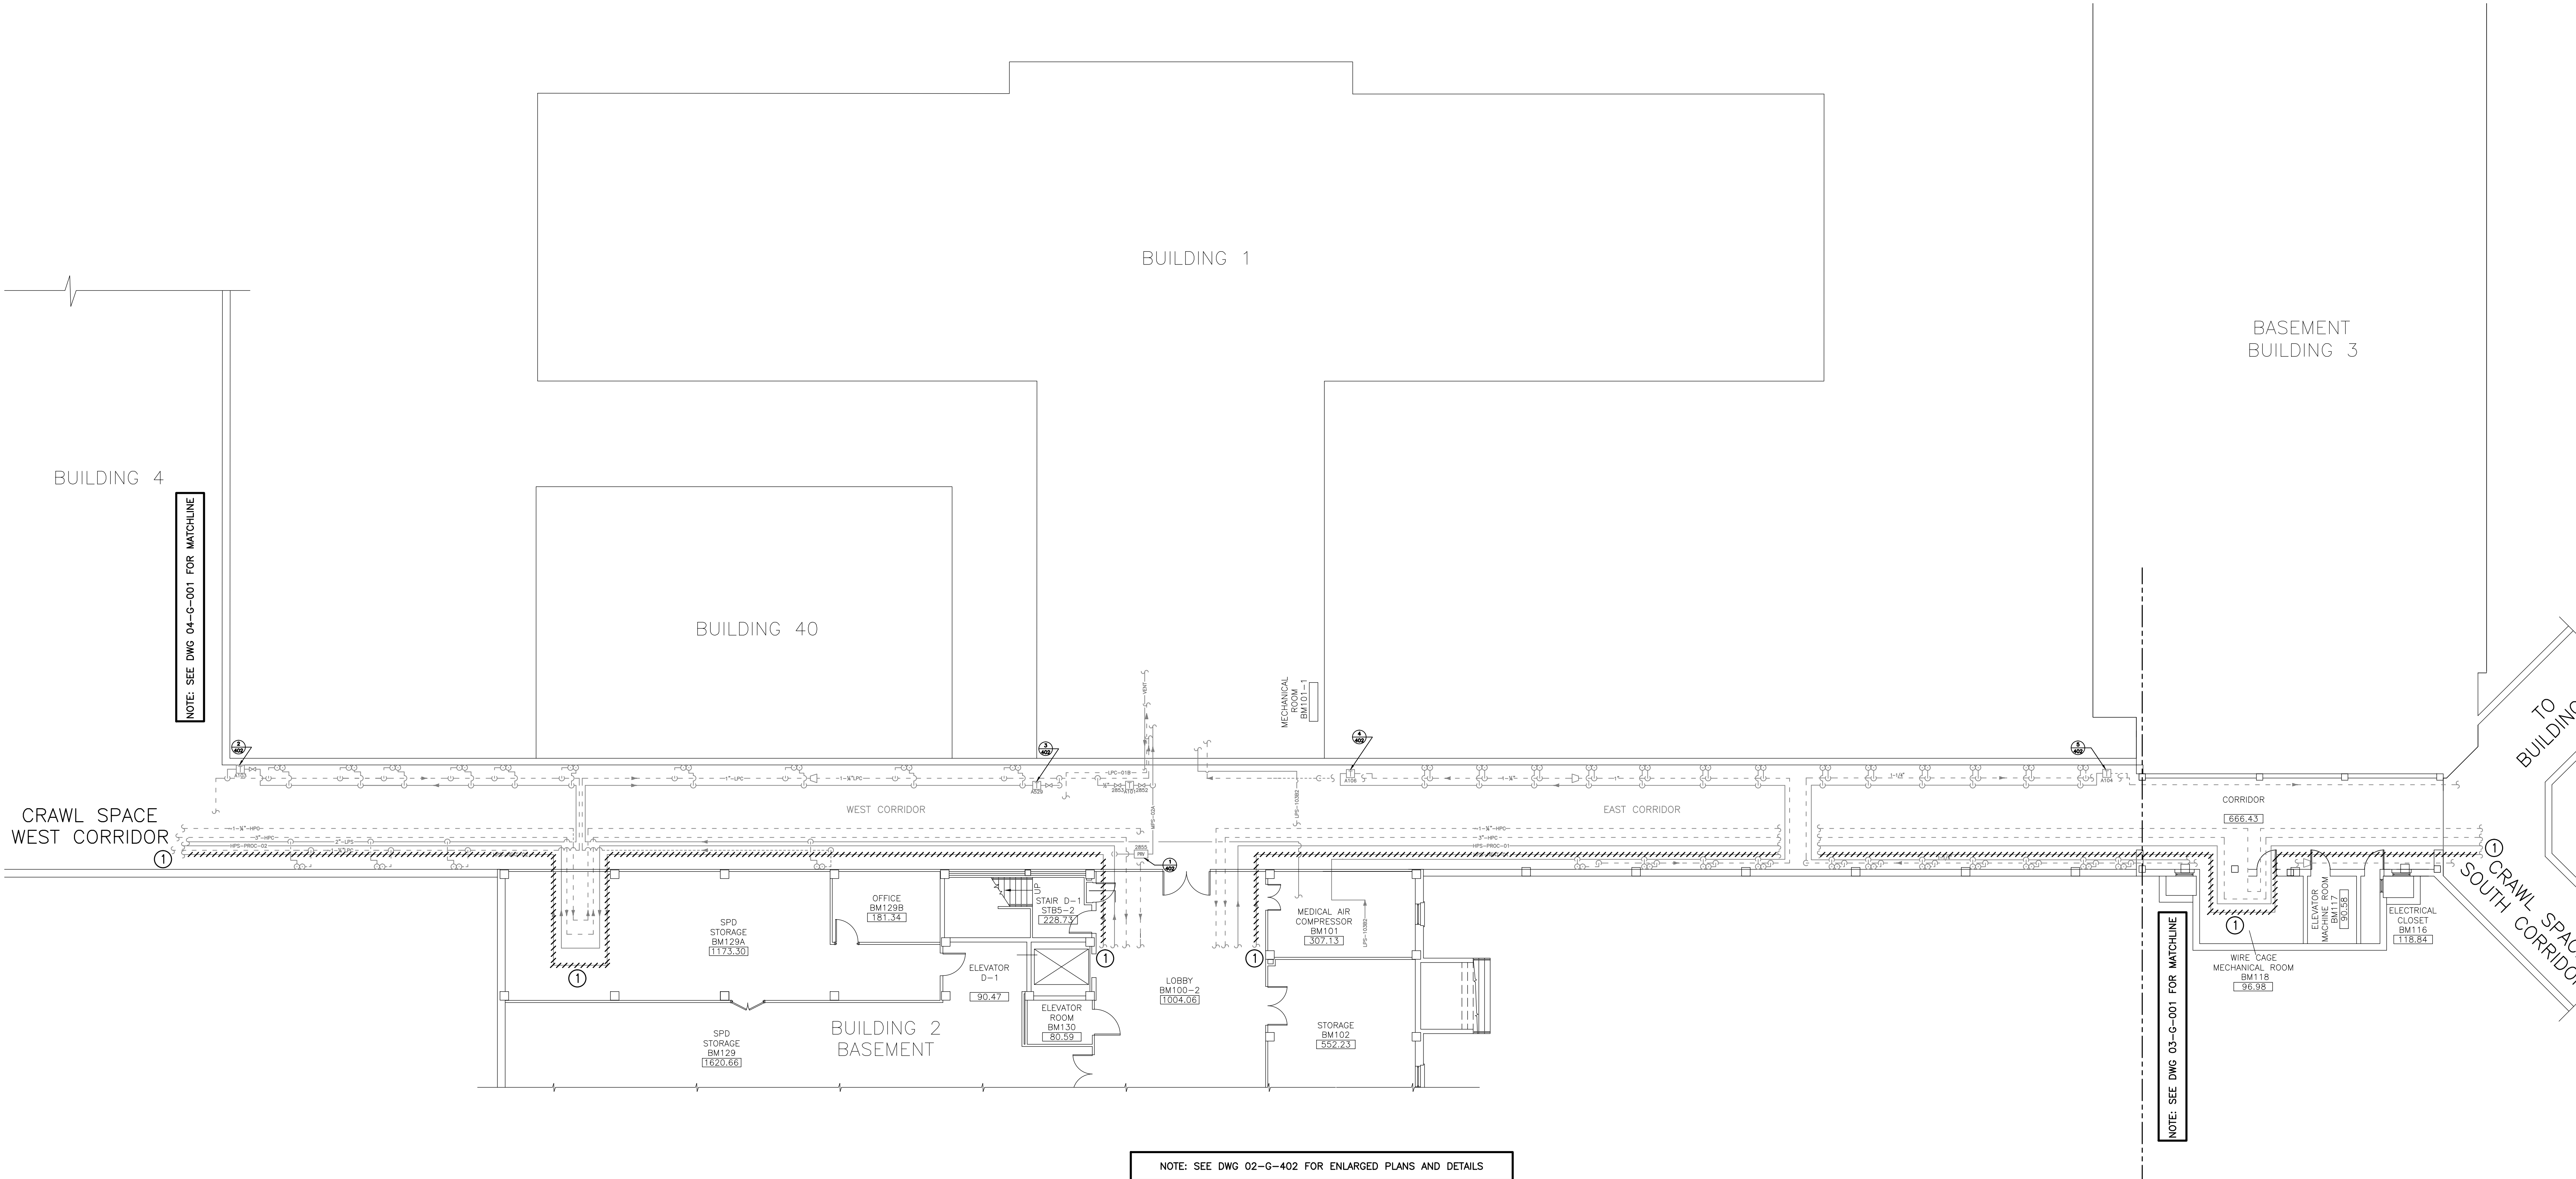

BASEMENT FLOOR PLAN
SCALE: 3/32" = 1'-0"
0 6' 12' 24'

Revisions	Date

AES
APPLIED ENGINEERING SOLUTIONS
440 Martin Luther King, Jr. Blvd., Suite 401
Macon, Georgia 31201
(478) 314-1270
www.aes-pe.com

KEY PLAN
SCALE: NONE

GEORGIA
REGISTERED PROFESSIONAL ENGINEER
EDWARD J. CANEJO

Drawing Title
BASEMENT FLOOR PLAN

Project Title
STEAM AND CONDENSATE PIPING SYSTEM STUDY

Date
JUNE 22, 2012
Project No.
557-10-109
Building Number
2
Checked
PJC
Drawn
JSW
Drawing No.
02-G-401
Dwg. 18 of 87

Location
CARL VINSON VA MEDICAL CENTER
DUBLIN, GEORGIA

Veterans Administration