
 


three inches = one foot
one and one-half inches = one foot
one inch = one foot
three-quarters inch = one foot
one-half inch = one foot
three-eighths inch = one foot
one-quarter inch = one foot
one-eighth inch = one foot


DRAWING NOTES:
A. NO WORK REQUIRED THIS AREA. SHEET INCLUDED FOR COMPLETENESS OF RECORD DRAWINGS.

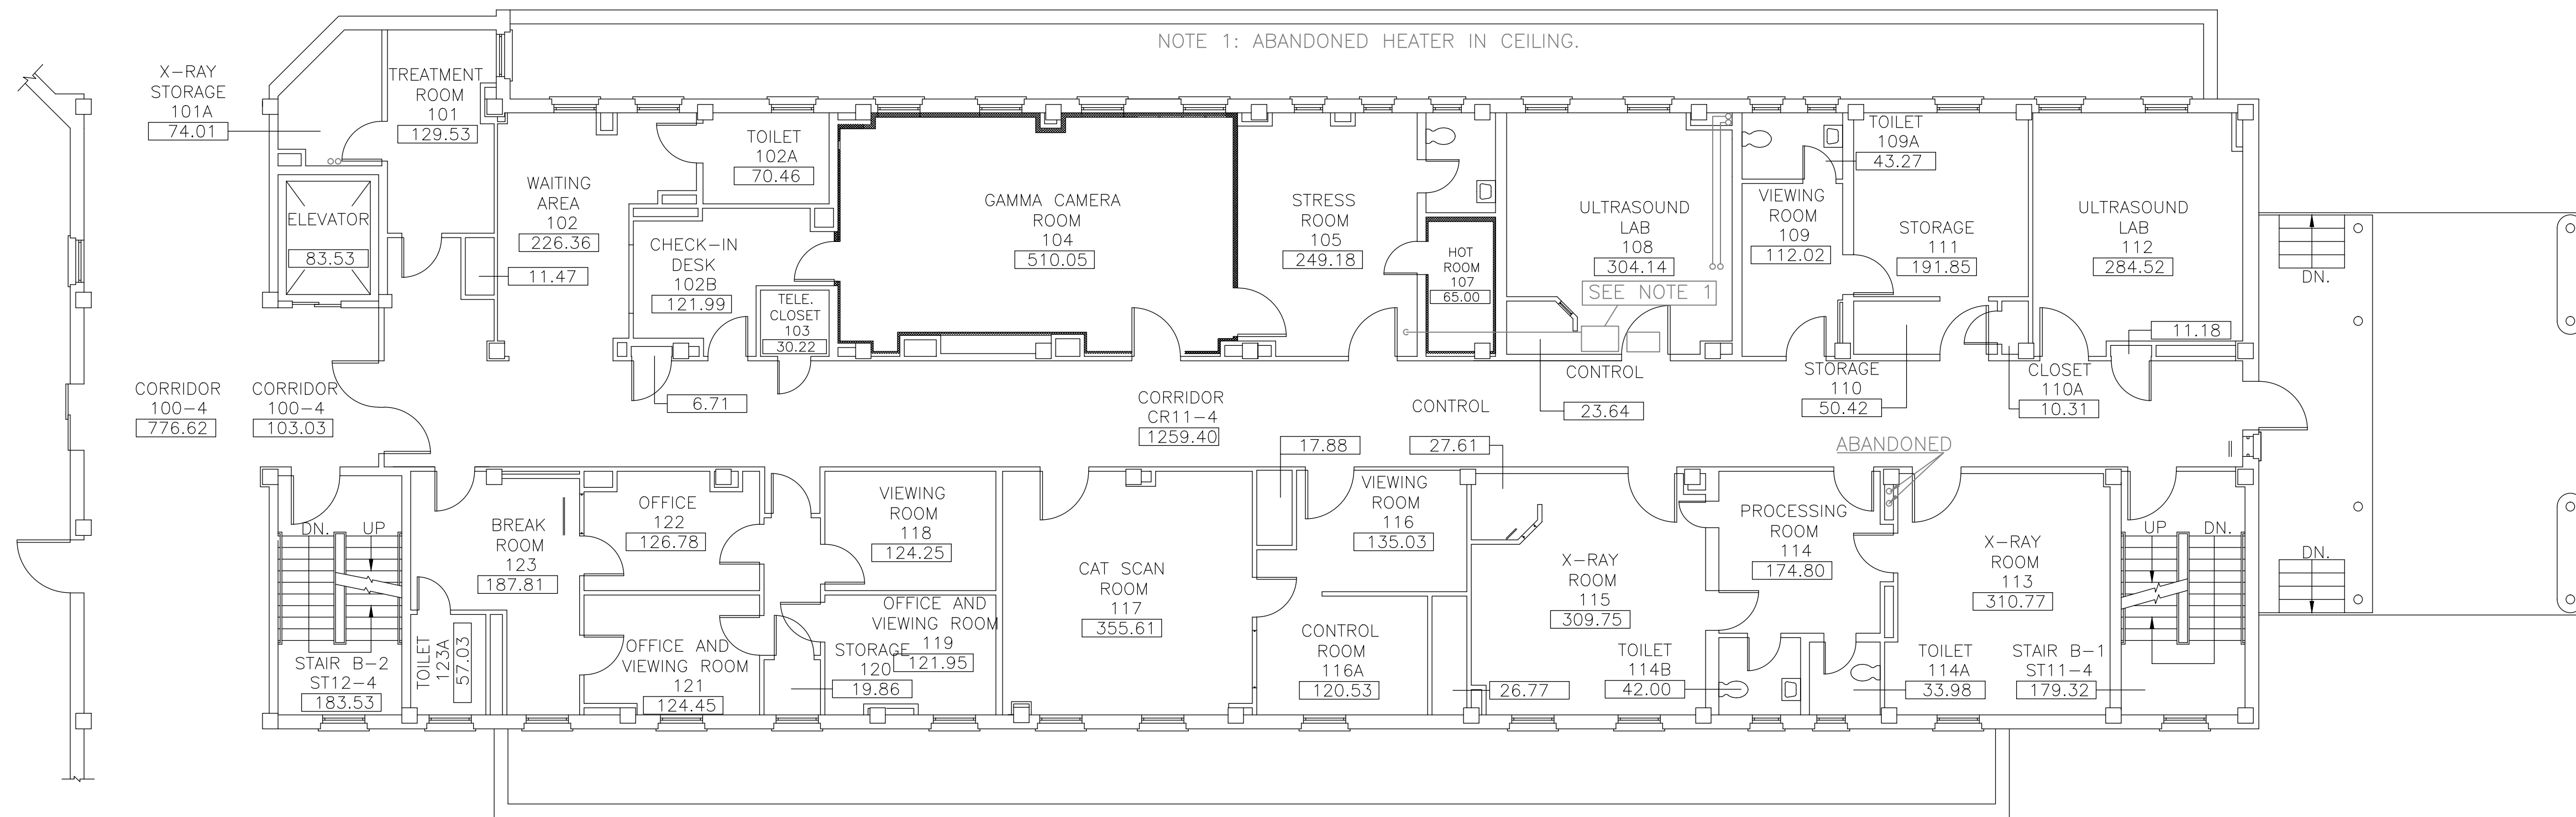

FIRST FLOOR PLAN
SCALE: 1/8" = 1'-0"



KEY PLAN
SCALE: NONE

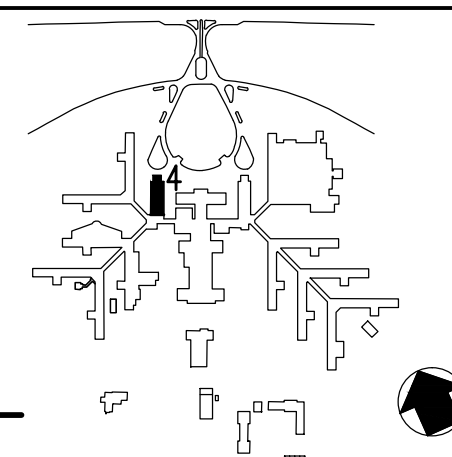

Revisions	Date

AES
APPLIED ENGINEERING
SOLUTIONS
440 Martin Luther King, Jr. Blvd., Suite 401
Macon, Georgia 31201
(478) 314-1270
www.aes-pe.com

Drawing Title		Project Title		Date
FIRST FLOOR PLAN		STEAM AND CONDENSATE PIPING SYSTEM STUDY		JUNE 22, 2012
FINAL SUBMITTAL		Building Number 4	Checked PJC	Drawn JSW
Location		CARL VINSON VA MEDICAL CENTER DUBLIN, GEORGIA		Drawing No. 04-G-101
				Dwg. 29 Of 87

Veterans
Administration