




DRAWING NOTES:
A. NO WORK REQUIRED THIS AREA. SHEET INCLUDED FOR COMPLETENESS OF RECORD DRAWINGS.



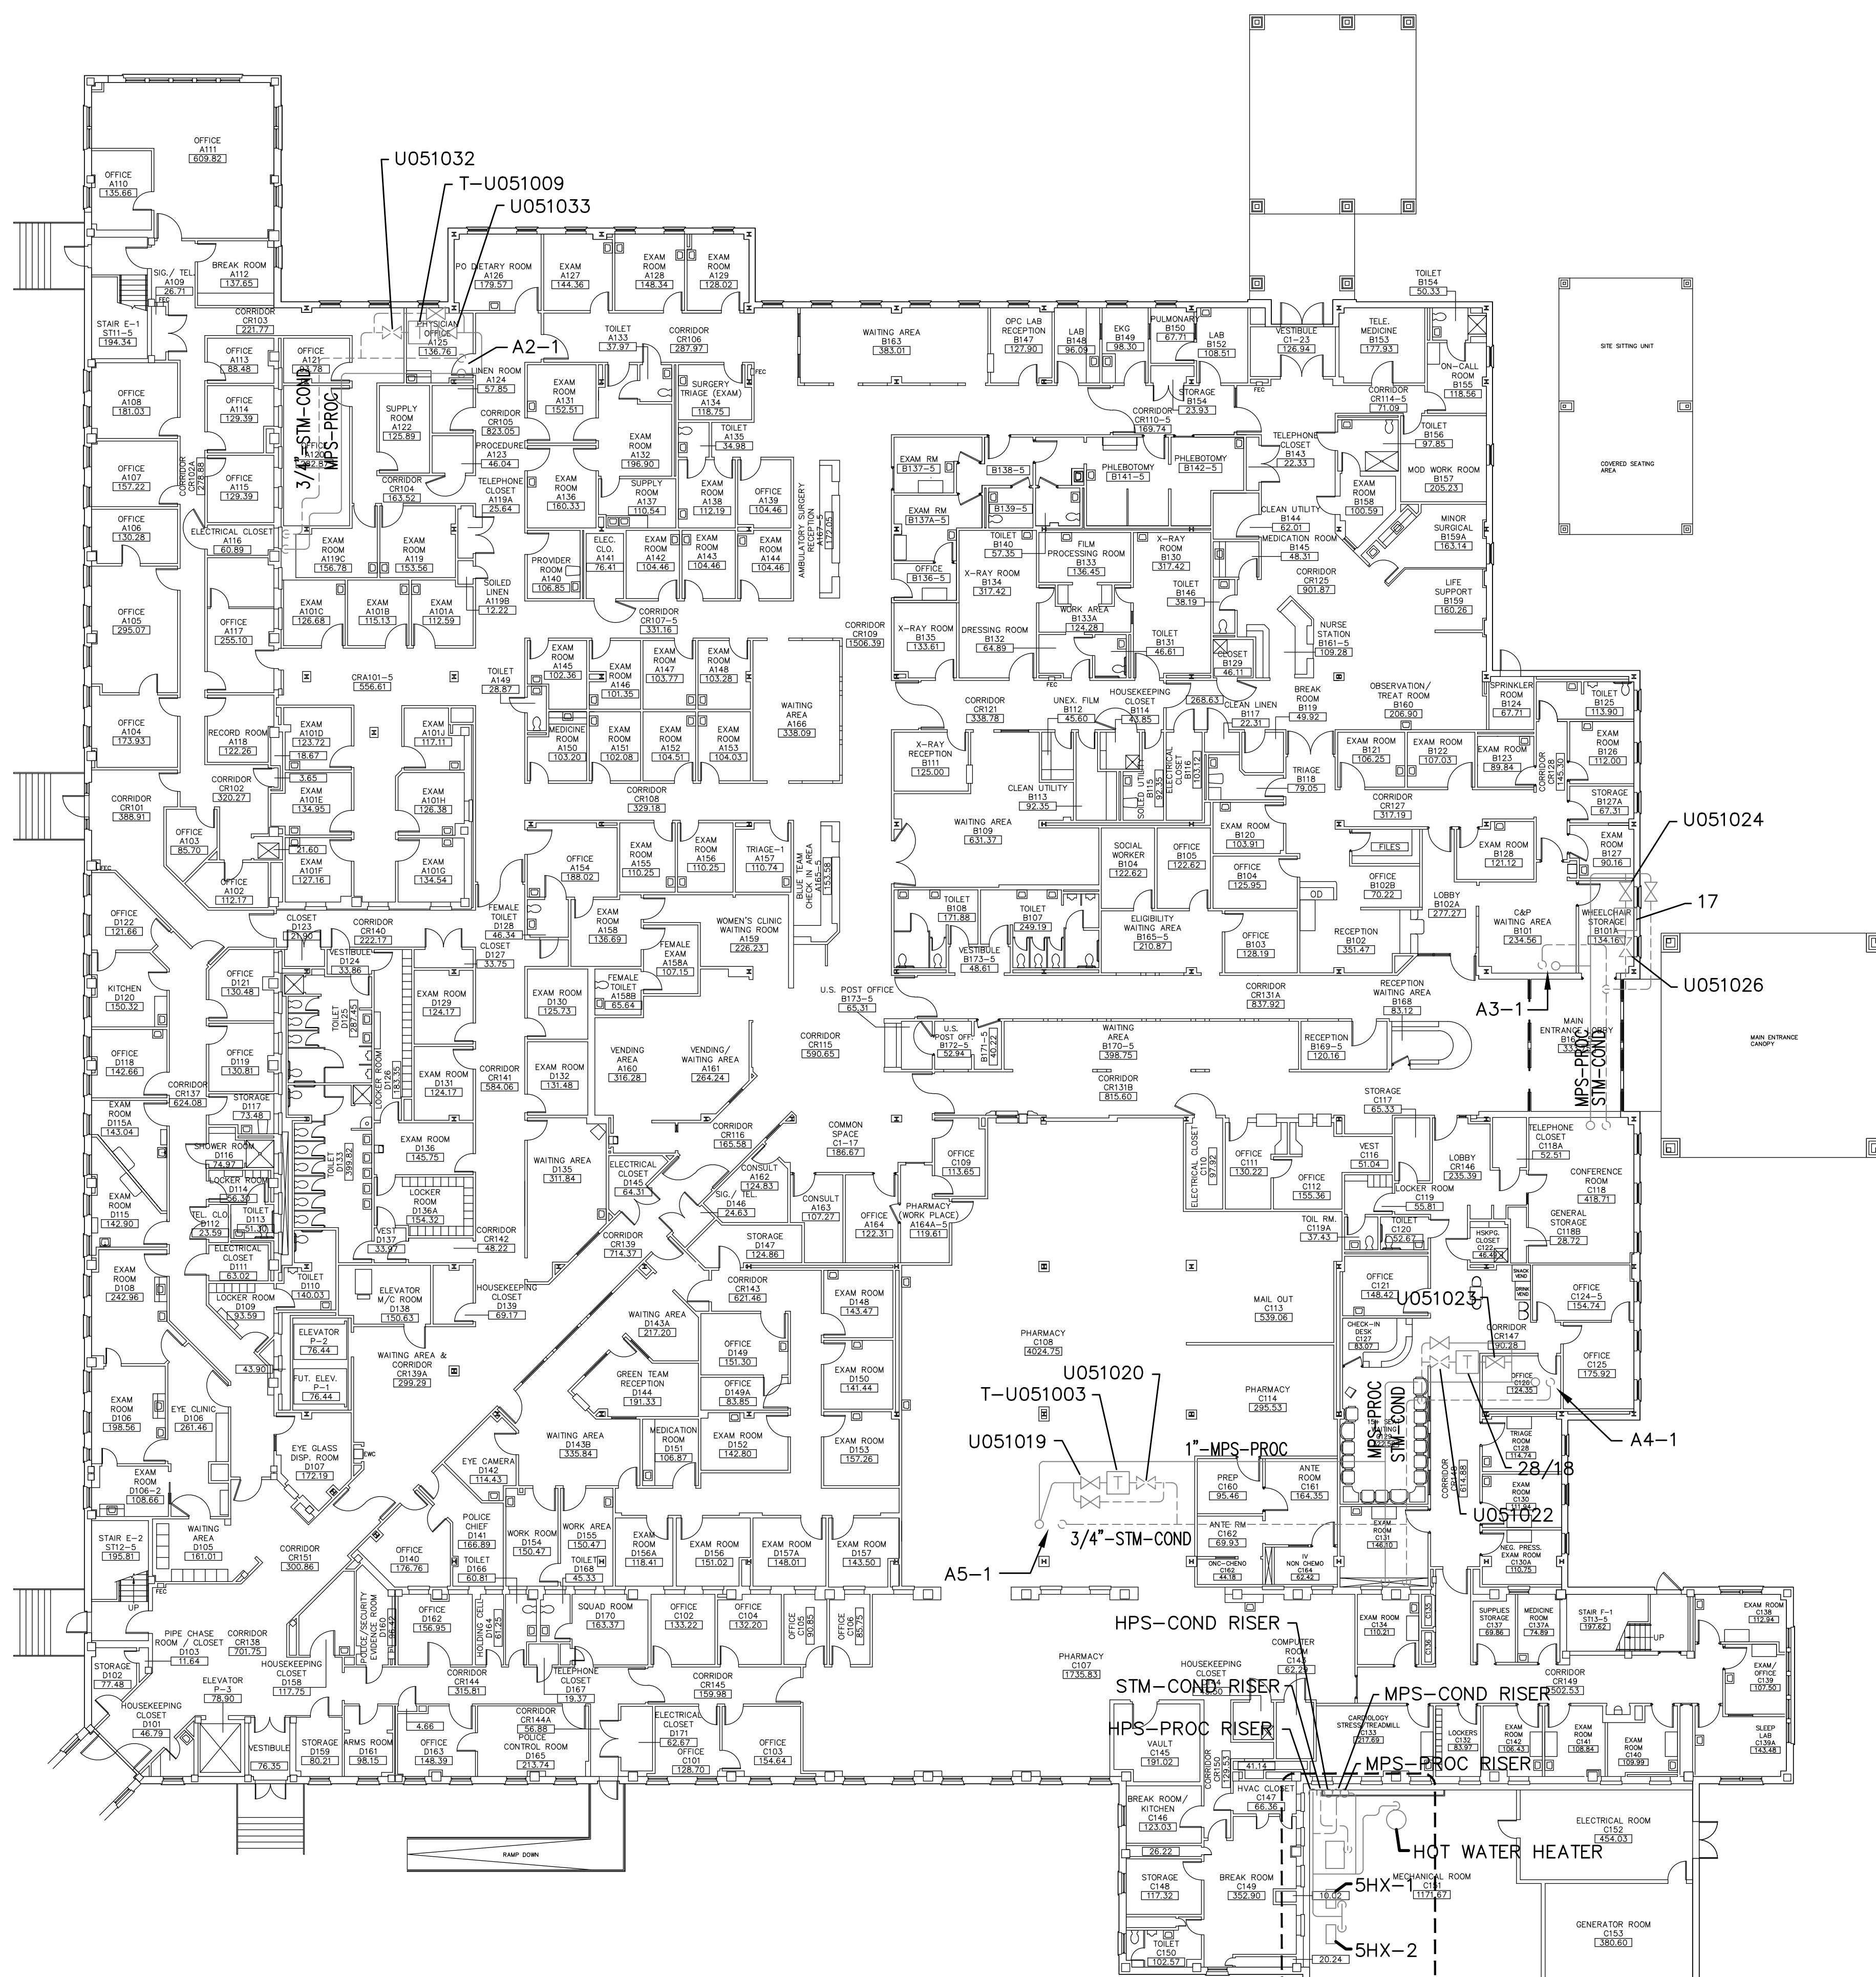


**BUILDING 5
FIRST FLOOR PLAN**
SCALE: 1/16" = 1'-0"

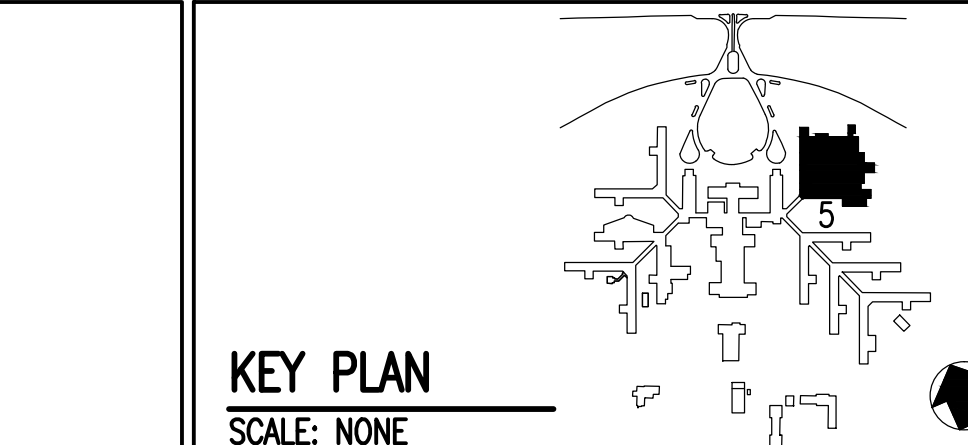

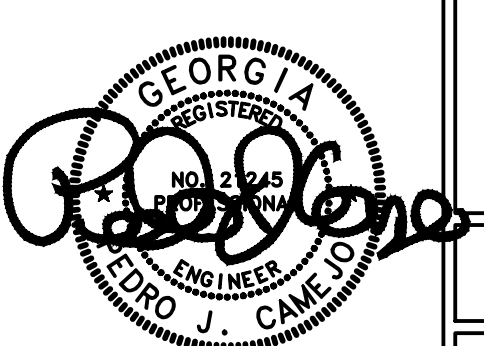KEY PLAN
SCALE: NONE



		<div>APPLIED ENGINEERING SOLUTIONS 440 Martin Luther King, Jr. Blvd., Suite 401 Macon, Georgia 31201 (478) 314-1270 www.aes-pe.com</div>	<div> KEY PLAN SCALE: NONE</div>	<div></div>	Drawing Title		Project Title		Date	
FIRST FLOOR PLAN					STEAM AND CONDENSATE PIPING SYSTEM STUDY		JUNE 22, 2012			
					Building Number 5		Checked PJC	Drawn JSW	Project No. 557-10-109	
FINAL SUBMITTAL					Location CARL VINSON VA MEDICAL CENTER DUBLIN, GEORGIA		DRAWING NO. 05-G-101		Dwg. 34 Of 87	
Revisions		Date	Veterans Administration							