



DRAWING NOTES:
A. NO WORK REQUIRED THIS AREA. SHEET INCLUDED FOR COMPLETENESS OF RECORD DRAWINGS.

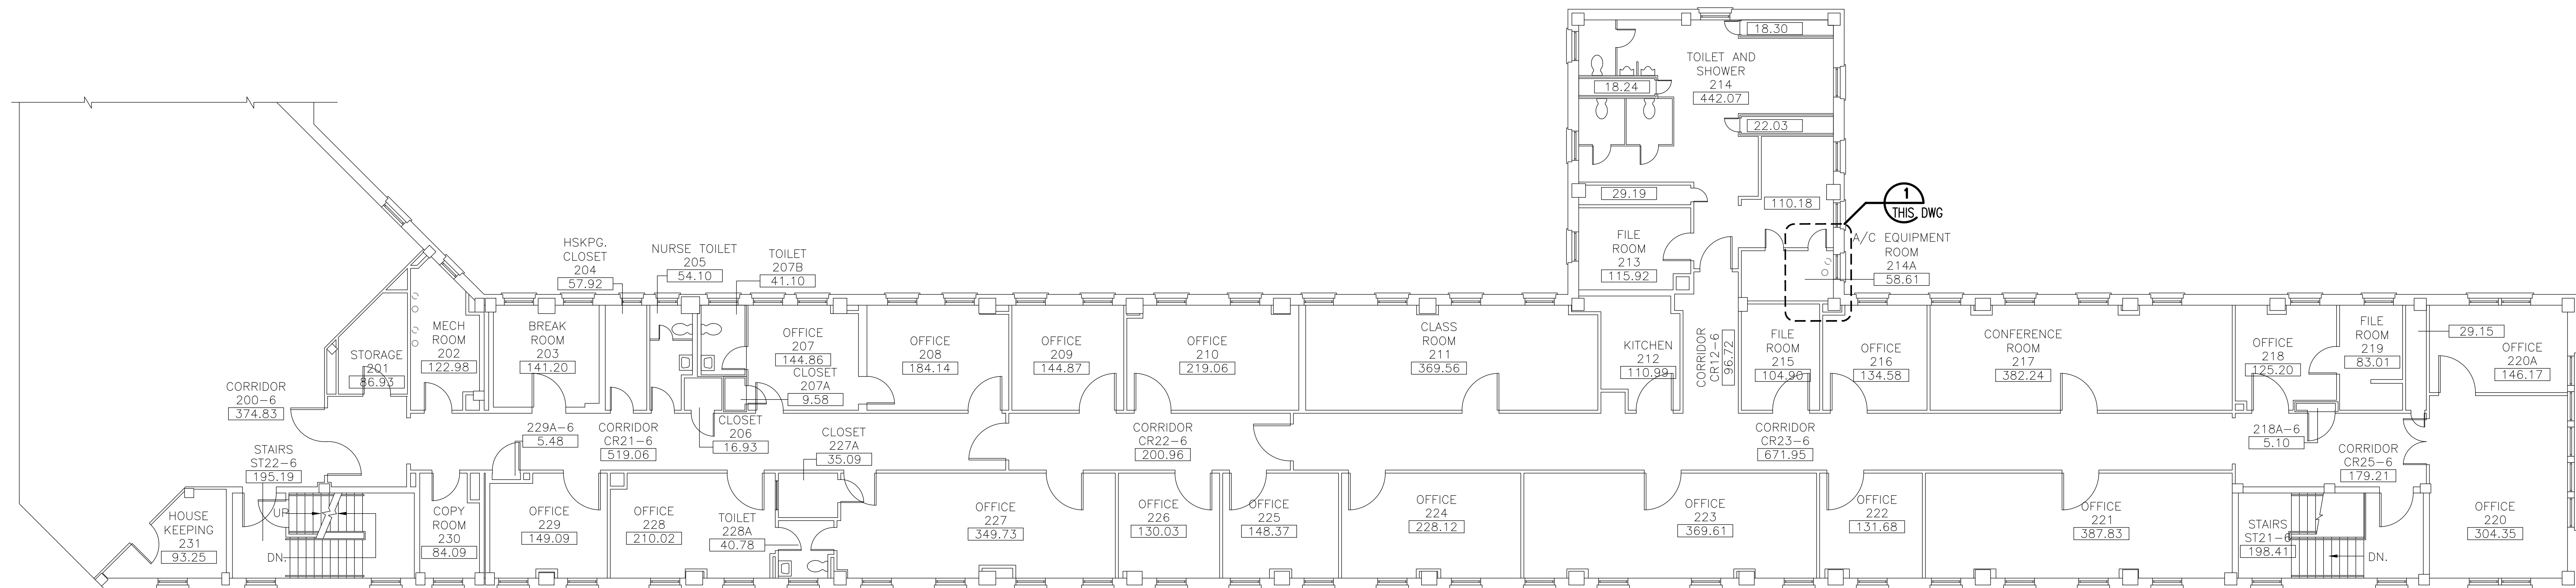

BUILDING 6
SECOND FLOOR PLAN
SCALE: 1/8" = 1'-0"

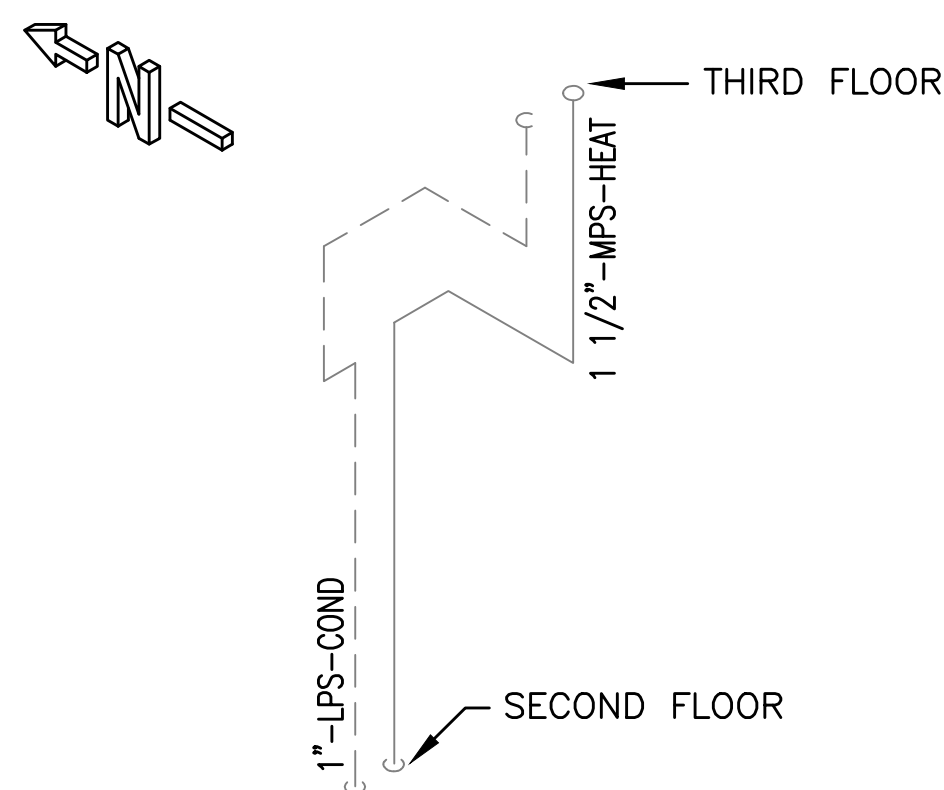


DETAIL 1 ISO
SCALE: NONE

Revisions	Date

AES
APPLIED ENGINEERING SOLUTIONS
440 Martin Luther King, Jr. Blvd., Suite 401
Macon, Georgia 31201
(478) 314-1270
www.aes-pe.com

KEY PLAN
SCALE: NONE

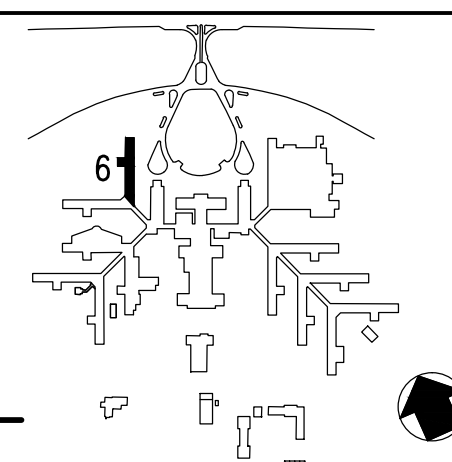

Drawing Title		Project Title		Date
SECOND FLOOR PLAN AND DETAIL		STEAM AND CONDENSATE PIPING SYSTEM STUDY		JUNE 22, 2012
Building Number		Checked	Drawn	Project No.
6		PJC	JSW	557-10-109
Location		Dwgs. 42 Of 87		Drawing No.
CARL VINSON VA MEDICAL CENTER DUBLIN, GEORGIA		06-G-201		
FINAL SUBMITTAL				

Veterans Administration