




DRAWING NOTES:
A. NO WORK REQUIRED THIS AREA. SHEET INCLUDED FOR COMPLETENESS OF RECORD DRAWINGS.

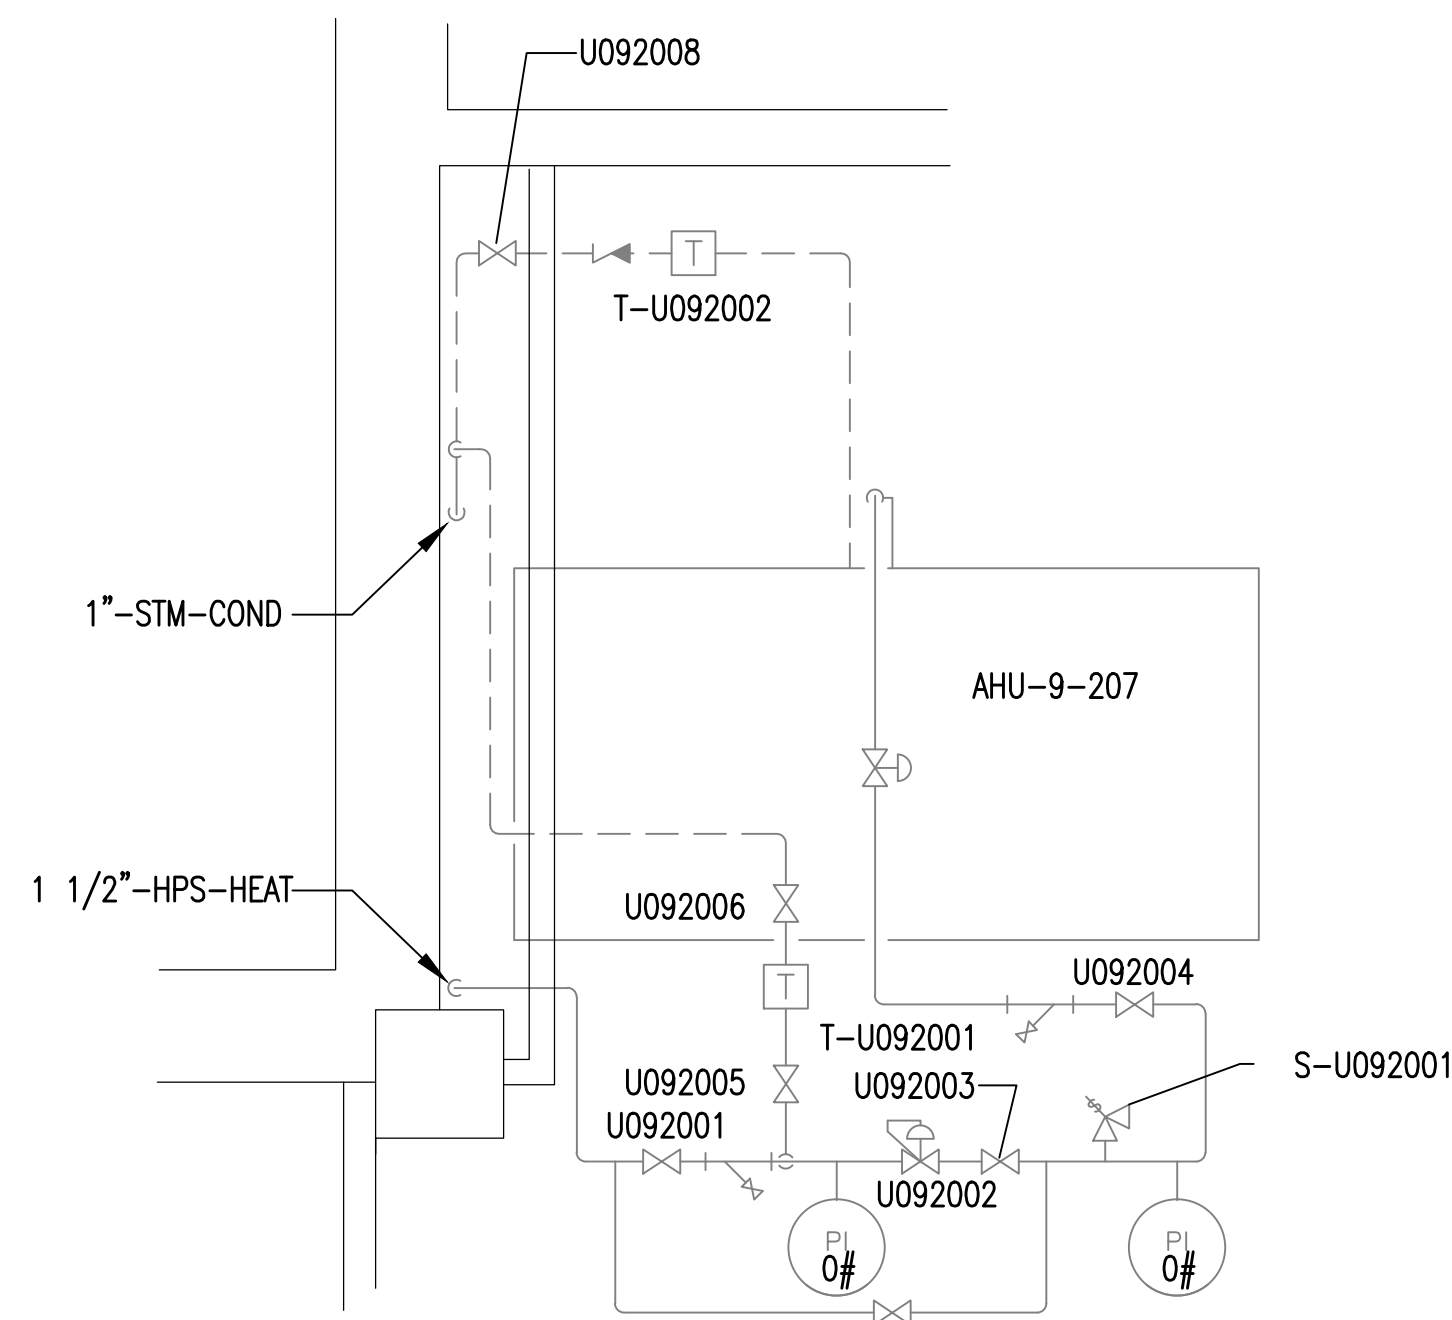

Revisions	Date

AES
APPLIED ENGINEERING SOLUTIONS
440 Martin Luther King, Jr. Blvd., Suite 401
Macon, Georgia 31201
(478) 314-1270
www.aes-pe.com

KEY PLAN
SCALE: NONE

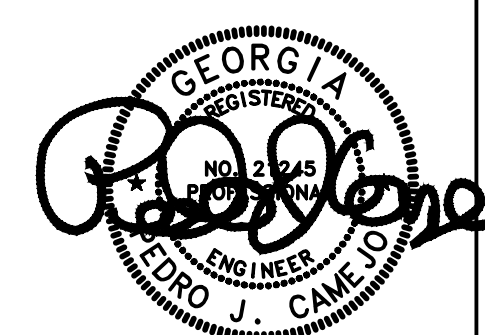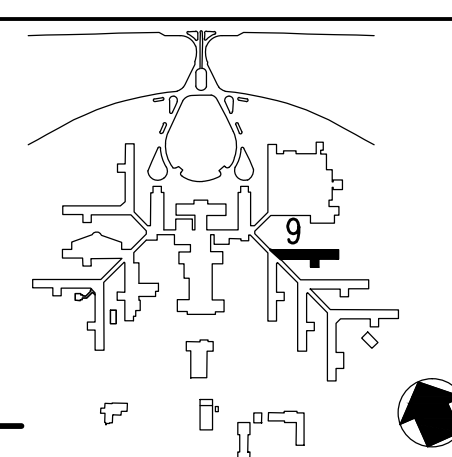

<div>Drawing Title</div> <div>SECOND FLOOR PLAN AND DETAIL</div>	<div>Project Title</div> <div>STEAM AND CONDENSATE PIPING SYSTEM STUDY</div>			<div>Date</div> <div>JUNE 22, 2012</div>		
	<div>Building Number</div> <div>9</div>			<div>Checked</div> <div>PJC</div>	<div>Drawn</div> <div>JSW</div>	<div>Project No.</div> <div>557-10-109</div>
	<div>FINAL SUBMITTAL</div>			<div>Location</div> <div>CARL VINSON VA MEDICAL CENTER DUBLIN, GEORGIA</div>		

Veterans Administration