


FIRST FLOOR PLAN
SCALE: 1/8" = 1'-0"

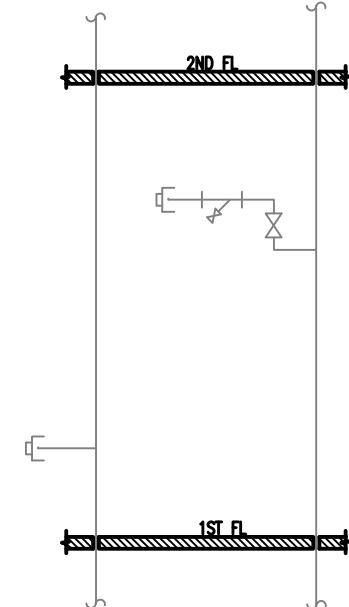



DETAIL #1
SCALE: NONE

DRAWING NOTES:
A. NO WORK REQUIRED THIS AREA. SHEET INCLUDED FOR COMPLETENESS OF RECORD DRAWINGS.

Revisions	Date

AES
APPLIED ENGINEERING SOLUTIONS
440 Martin Luther King, Jr. Blvd., Suite 401
Macon, Georgia 31201
(478) 314-1270
www.aes-pe.com

KEY PLAN
SCALE: NONE

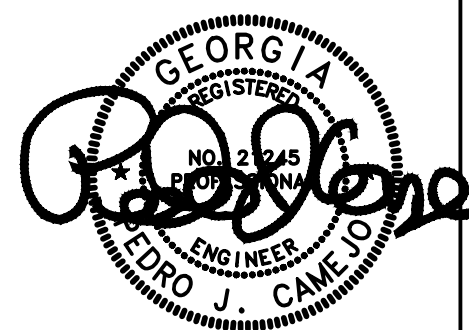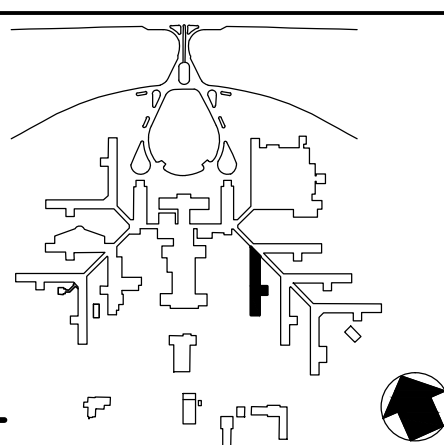

Drawing Title FIRST FLOOR PLAN AND DETAIL	Project Title STEAM AND CONDENSATE PIPING SYSTEM STUDY			Date JUNE 22, 2012
	Building Number 11	Checked PJC	Drawn JSW	Project No. 557-10-109
FINAL SUBMITTAL		Location CARL VINSON VA MEDICAL CENTER DUBLIN, GEORGIA		Drawing No. 11-G-101 Dwg. 57 Of 87

Veterans Administration