

 



**DETAIL #1**  
SCALE: NONE

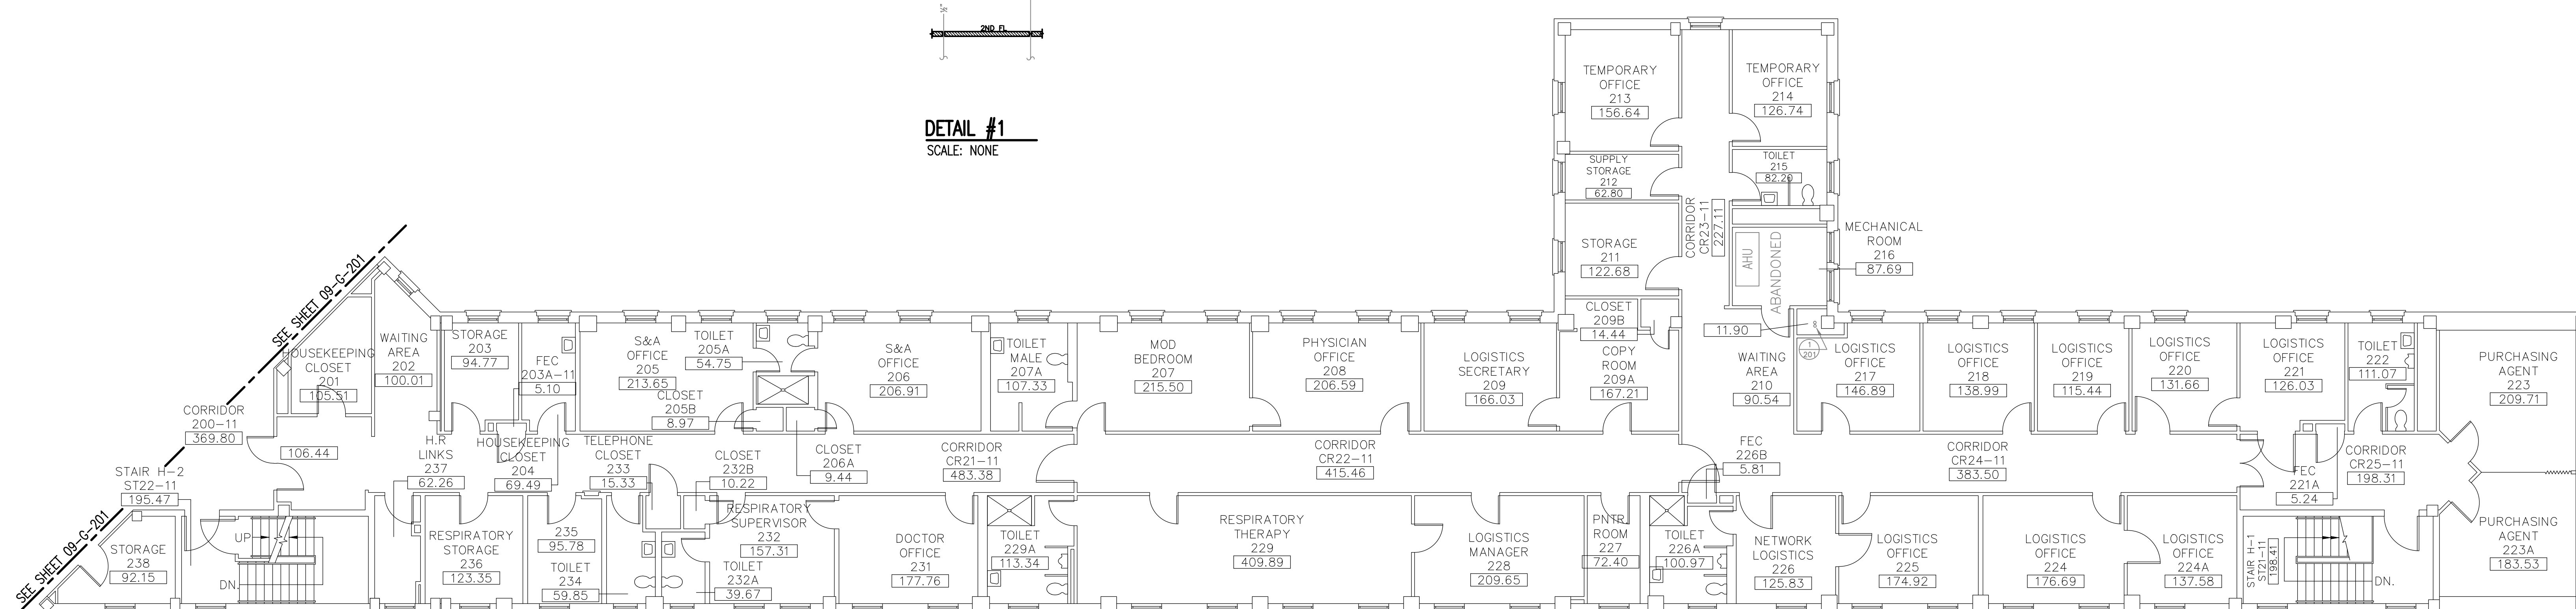


 **SECOND FLOOR PLAN**  
SCALE: 1/8" = 1'-0"

[illegible]

**APPLIED ENGINEERING  
SOLUTIONS**  
440 Martin Luther King, Jr. Blvd., Suite 401  
Macon, Georgia 31201  
(478) 314-1270  
[www.aes-pe.com](http://www.aes-pe.com)

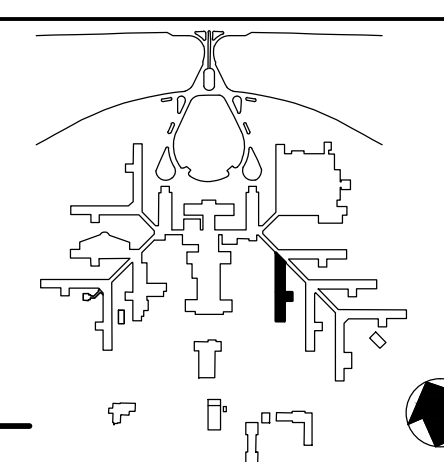

KEY PLAN  
SCALE: NONE

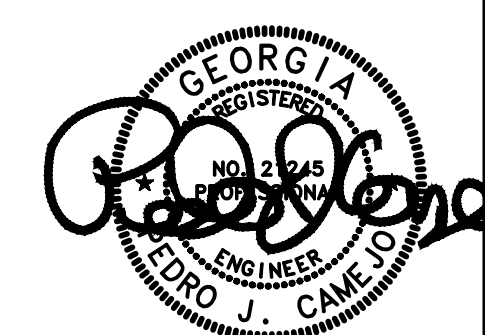

## SECOND FLOOR PLAN AND DETAIL

FINAL SUBMITTAL

## STEAM AND CONDENSATE PIPING SYSTEM STUDY

Building Number	11
-----------------	----

Location	CARL VINSON VA MEDICAL CENTER DUBLIN, GEORGIA
----------	--

Date	JUNE 23, 2012
------	---------------

Project No.

	DRAWING NO.

Pwa. 58 of 87