

KEYED SHEET NOTES

- ① NOT USED.
- ② ROUTE HOMERUN VIA A 20A/1P TOGGLE SWITCH LOCATED IN NURSE STATION #A320.
- ③ LOCATION OF THE TOGGLE SWITCHES THAT CONTROL THE RECEPTACLE HOMERUNS. COORDINATE THE LAYOUT OF SWITCHES WITH THE COTR.
- ④ FOR TV.
- ⑤ PROVIDE 2#12, 1#12G, 3/4" C AND CONNECT UNSWITCHED TO THE LOCAL LIGHTING CIRCUIT FOR THIS ROOM.
- ⑥ COORDINATE THE LOCATION OF ALL DEVICES AND EQUIPMENT IN THIS ROOM WITH THE COTR.
- ⑦ LOCATE JUNCTION BOX IN AN ACCESSIBLE LOCATION FOR USE BY THE MECHANICAL CONTRACTOR.
- ⑧ PROVIDE BACKBOX SPRINKLER SYSTEM ELECTRIC-POWER ALARM BELL. COORDINATE EXACT LOCATION.
- ⑨ NOT USED.
- ⑩ JUNCTION BOX IN AN ACCESSIBLE SPACE ABOVE THE LAYIN CEILING FOR THE SECURITY DASH HARDWARE. PROVIDE BACKBOX(ES) AS NEEDED FOR THE CARDREADER AND ALL CONTROL CONDUCTORS REQUIRED FOR A COMPLETE OPERABLE DOOR SYSTEM.
- ⑪ RECEPTACLE FOR THE SECURITY CAMERAS POWER SUPPLY. COORDINATE EXACT LOCATION WITH THE COTR.
- ⑫ RECEPTACLE FOR THE INTERCOM POWER SUPPLY. COORDINATE EXACT LOCATION WITH THE COTR.
- ⑬ PROVIDE DRYER RECEPTACLE MATCHING THE PLUG ON THE DRYER. COORDINATE WITH OWNER.
- ⑭ MOTOR OPERATED SMOKE CONTROL DOOR, 120V. COORDINATE CONNECTIONS AND REQUIREMENTS WITH THE FIRE MARSHAL AND AUTHORITIES HAVING JURISDICTION PRIOR TO ROUGH-IN.

1 ELECTRICAL - PARTIAL THIRD FLOOR PLAN - POWER  
1/8" = 1'-0"

[illegible]

## PROJECT TEAM


**ARCHITECTURE:**  
HDR Architecture, Inc.  
440 South Church Street  
Suite 1000  
Charlotte, NC 28202  
www.hdrinc.com  
704-338-6700

**STRUCTURAL:**  
HDR Architecture, Inc.  
17111 Preston Road  
Suite 300  
Dallas, Texas 75248  
www.hdrinc.com  
972-960-4000

**MECHANICAL/ELECTRICAL/  
PLUMBING/ FIRE PROTECTION**  
**Charlotte Engineers**  
5838 Monroe Road, Suite 100.  
Charlotte, NC 28212  
[www.charlotteengineers.com](http://www.charlotteengineers.com)  
704-531-3000



**CIVIL / LANDSCAPE:**  
ColeJenest & Stone  
200 South Tryon  
Suite 1400  
Charlotte, NC 28202  
www.colejeneststone.com  
704-376-1555

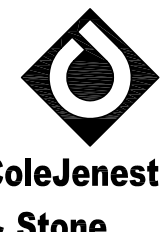

## ARCHITECTS/ENGINEERS




HDR Architecture Inc.  
440, S. Church Street, Suite 1000, Charlotte, NC 28205  
Phone: 704.338.6760 Fax: 704.338.6760

Drawing Title

ELECTRICAL - PARTIAL THIRD  
FLOOR PLAN - POWER

Approved : Project Director

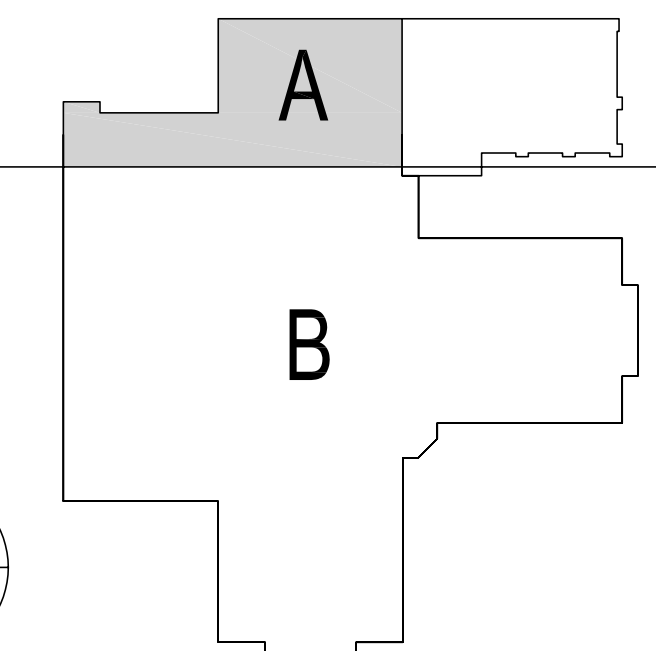

### WALL RATING LEGEND

1 HOUR FIRE

1 HOUR FIRE AND SMOKE

2 HOUR FIRE

2 HOUR FIRE AND SMOKE

3 HOUR FIRE

3 HOUR FIRE AND SMOKE

4 HOUR FIRE

4 HOUR FIRE AND SMOKE

SMOKE BARRIER

SMOKE SUITE

Office of  
Construction  
and Facilities  
Management

