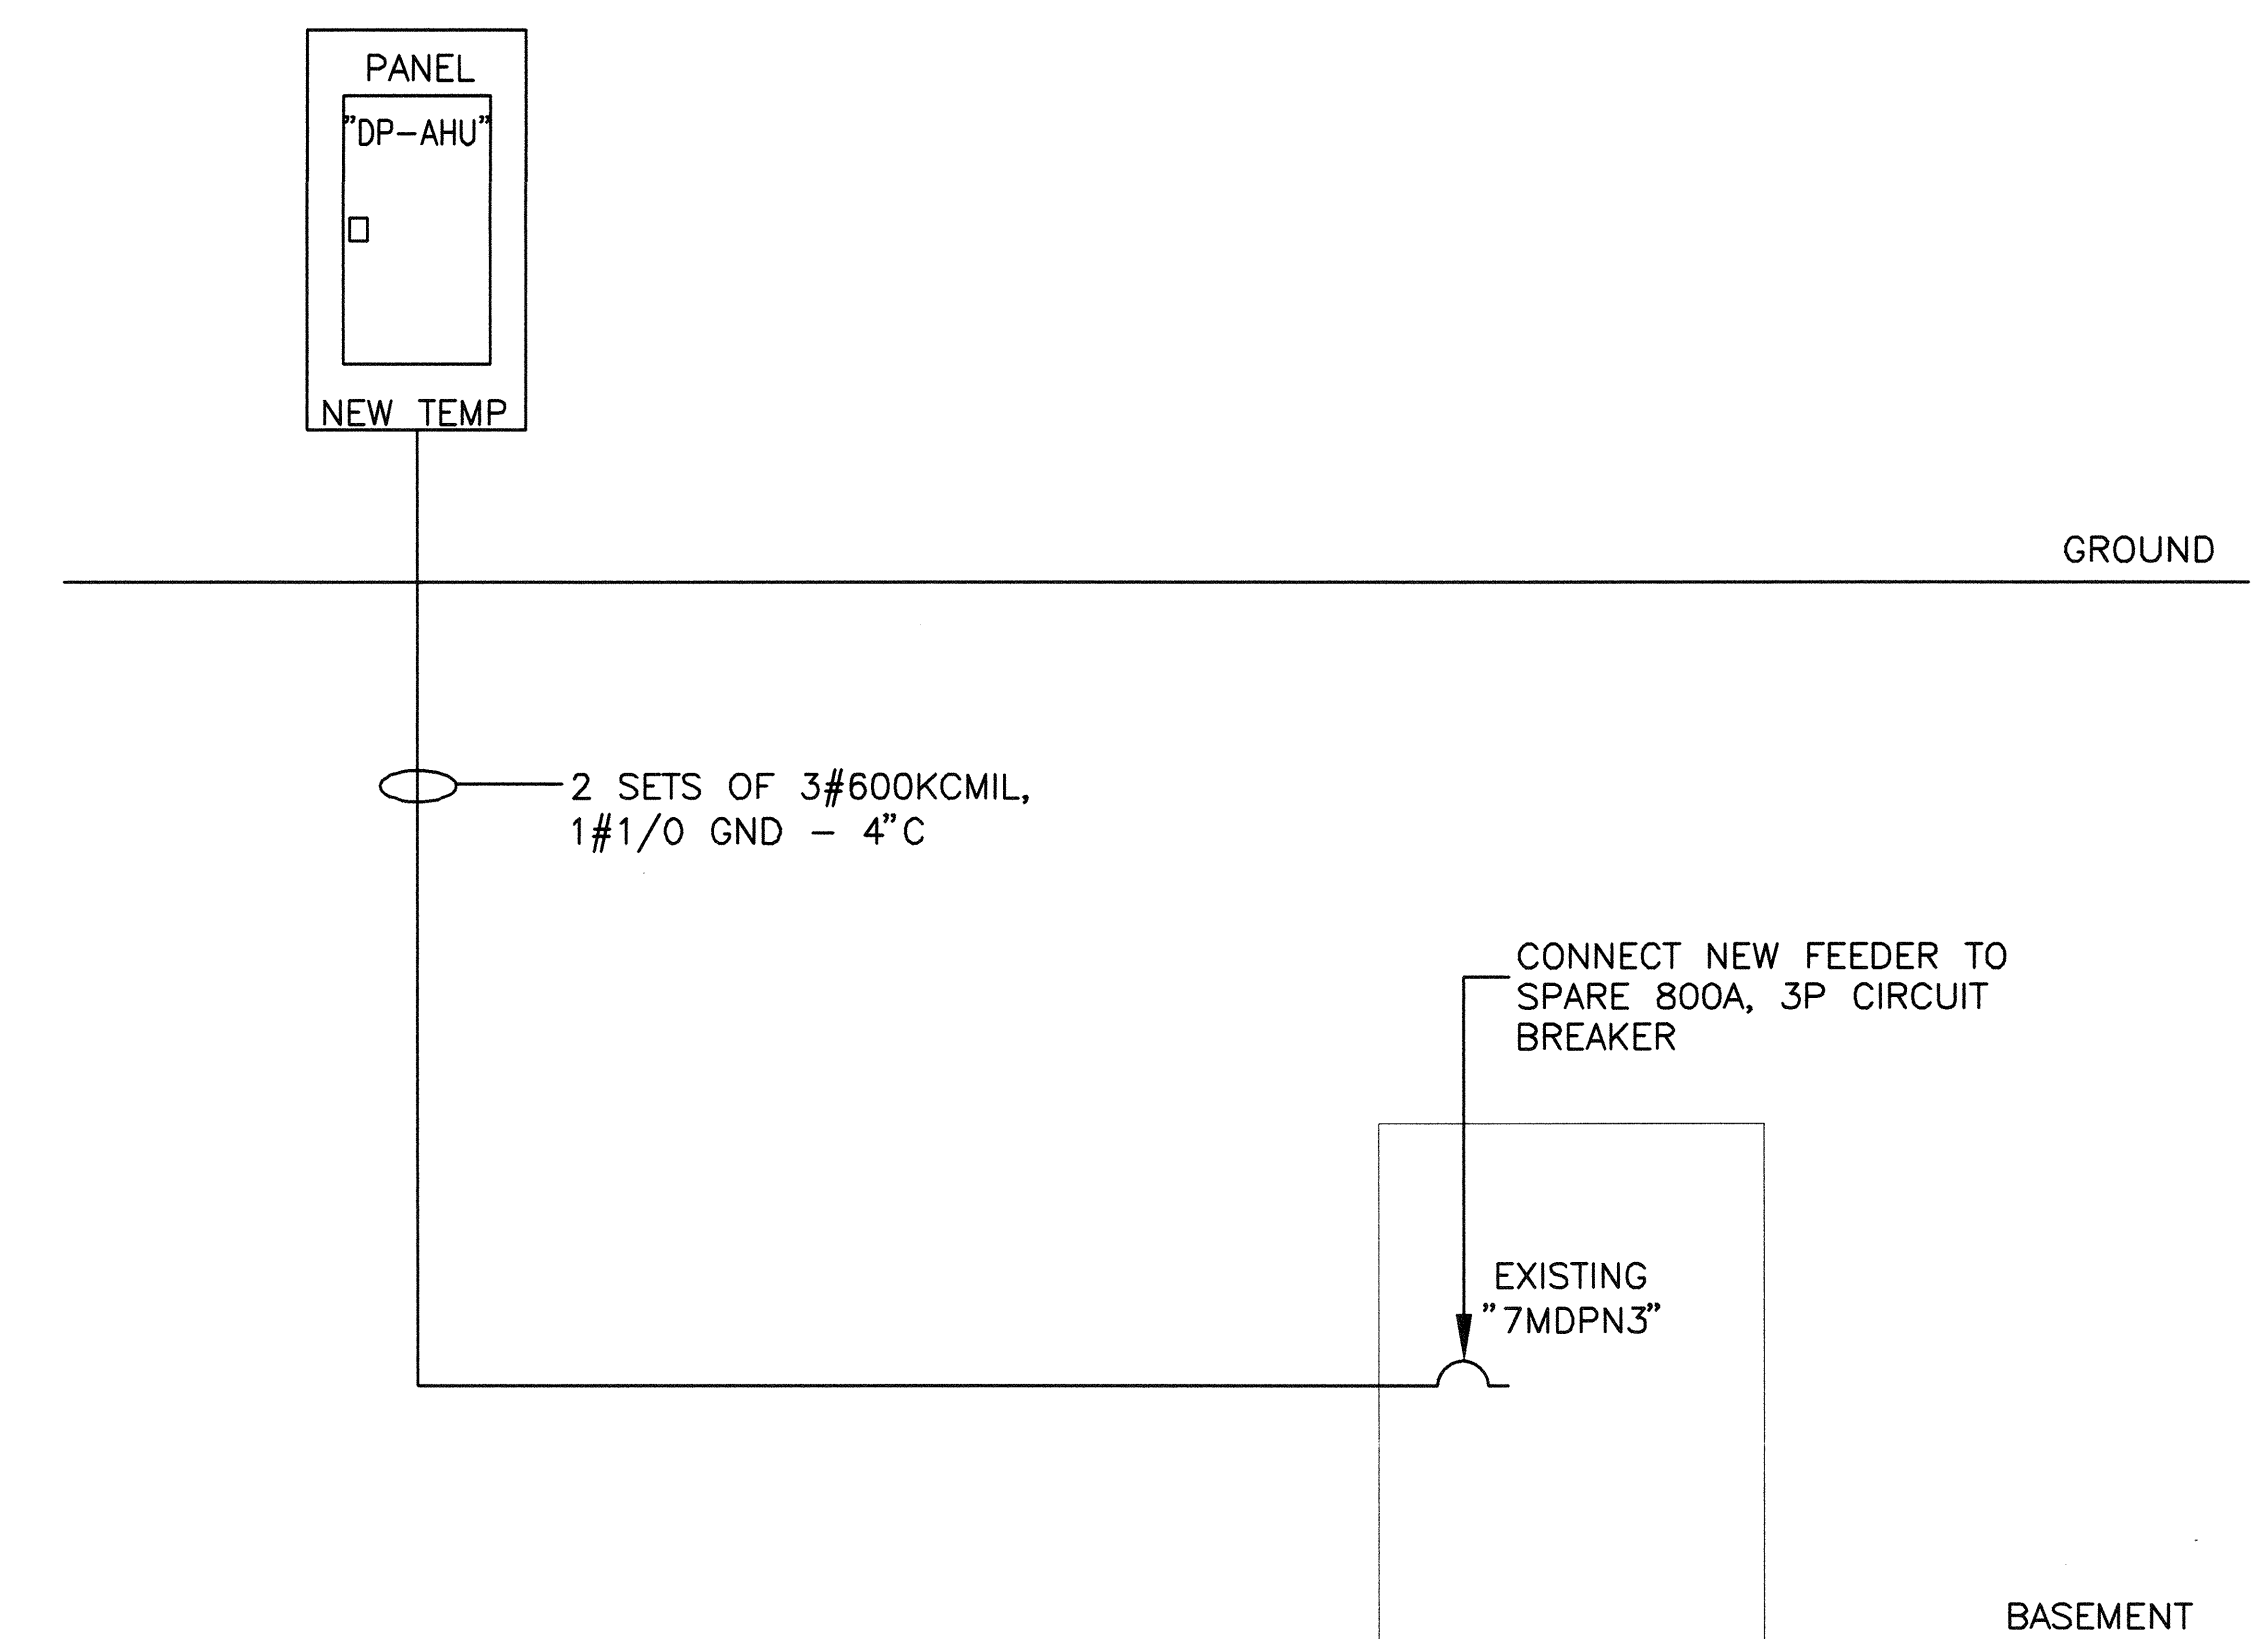


[illegible]

(D7) PARTIAL POWER RISER DIAGRAM
SCALE: NONE
NOTE:
UPON COMPLETION OF NEW EQUIPMENT INSTALLATION ALL
TEMPORARY WORK SHALL BE REMOVED. ALL BUILDING
SURFACES AND FINISHES DAMAGED AS A PART OF THE
TEMPORARY WORK SHALL BE REPAIRED AND REFINISHED TO
MATCH EXISTING ADJACENT FINISHES.

[illegible]

STATE OF LOUISIANA
 DANIEL C. JOHNSON
 License No. 380063
 PROFESSIONAL ENGINEER
 MECHANICAL ENGINEERING

Architect/Engineer Address

**Harrell,
Saltrick
&
Hopper**

Design & Management Solutions for the Built Environment

8016 TOWER POINT DRIVE
CHARLOTTE, NC 28227

WWW.HSNP.CM

COPYRIGHT © 2012 HARRELL, SALTTRICK & HOPPER, PC
HSH PROJECT # 12013

P 704.614.1320
F 704.321.0683

Recommended Approvals:	
1. MEDICAL DIRECTOR	6. OPERATIONS SERVICE LINE MANAGER
2. ASSOCIATE DIRECTOR	7. INFECTION CONTROL MANAGER
3. CHIEF OF STAFF	8. SAFETY MANAGER
4. ASSOC. DIRECTOR	9. GENERAL ENGINEER
5. SERVICE LINE MGRS.	10. COR

Drawing Title	SCHEDULES AND PARTIAL POWER RISER DIAGRAM
---------------	---

FINAL BID DOCUMENTS

Project Title	DESIGN BUILDING 7 AIR HANDLER UPGRADE - PROJECT A: 7-AHU107 & 7-AHU108
---------------	--

Drawn	ME
-------	----

Building Number
7

AutoCAD File Name

Date
SEPT 27 2013

Project Number
502-12-201

DRAWING No.
E601

