


SECTION A
SCALE: 1/4" = 1'-0"

SECTION B
SCALE: 1/4" = 1'-0"


SECTION C
SCALE: 1/4" = 1'-0"

SPECIAL NOTES

1. CHILLED WATER CONTROL VALVE DESIGNATIONS REFER TO REFRIGERATION CONTROL DIAGRAMS ON DWG. 1-H87 (IE, 3V4, 4V3 ETC.)

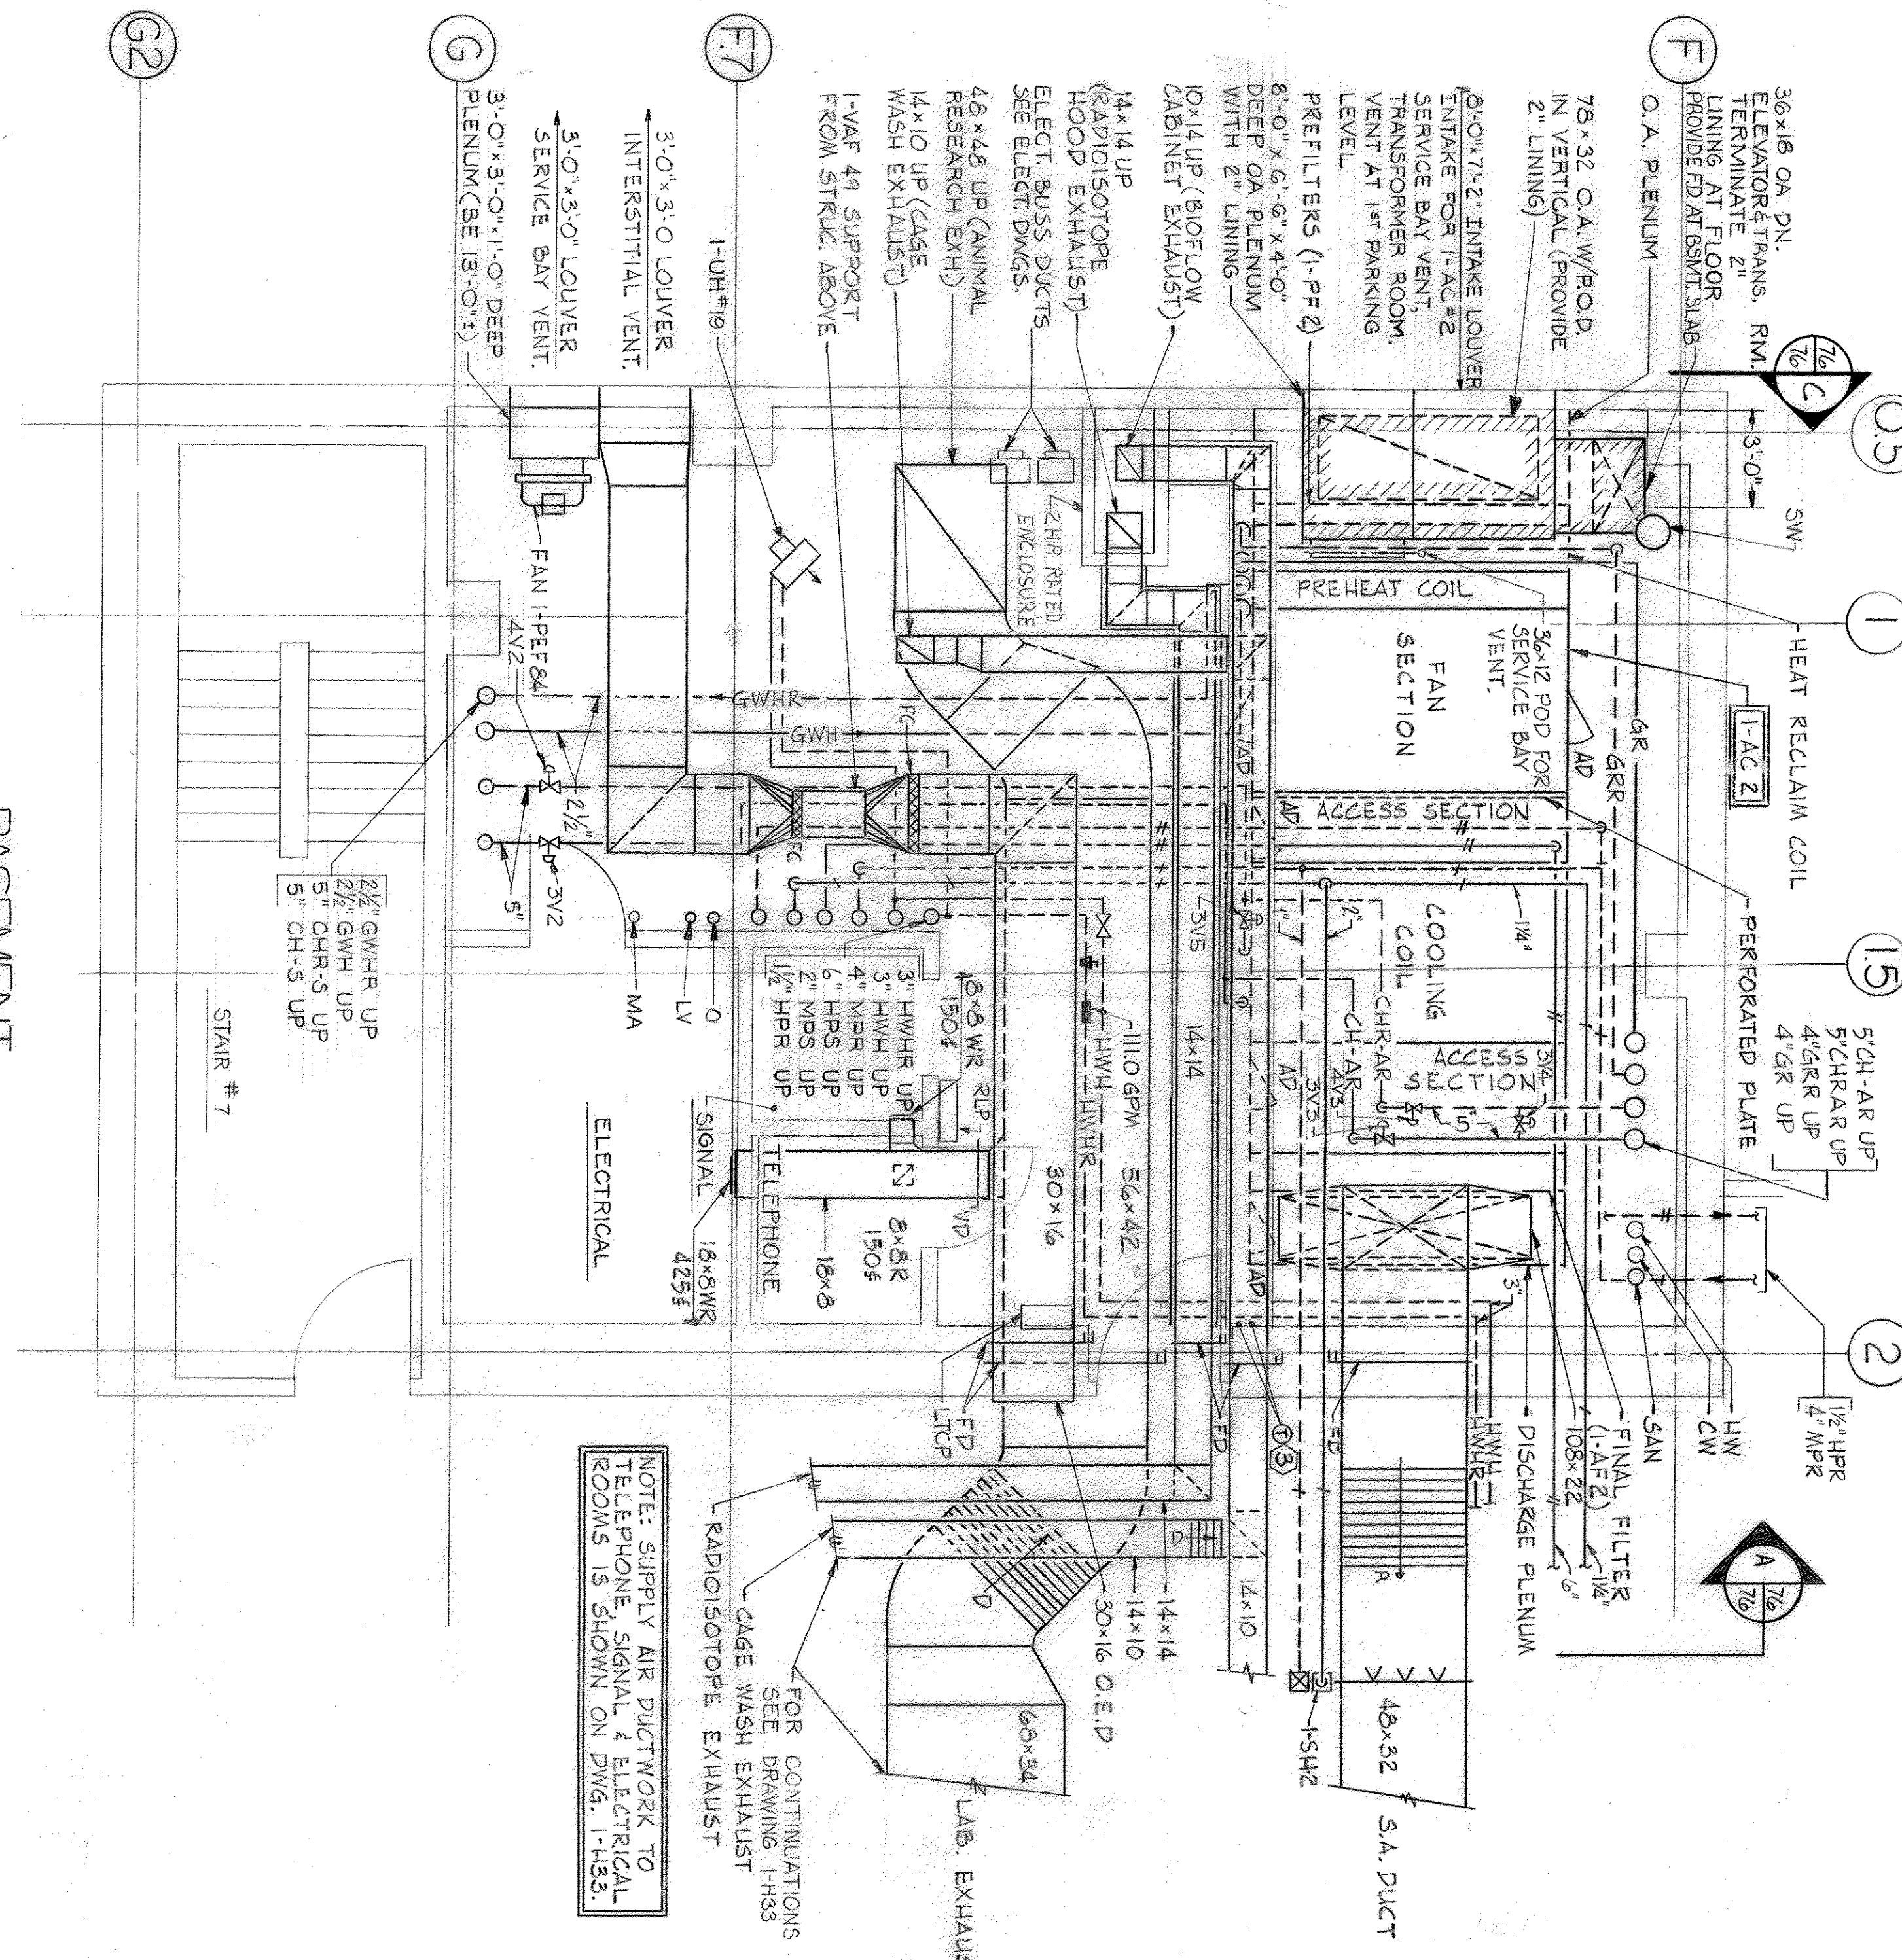

BASEMENT

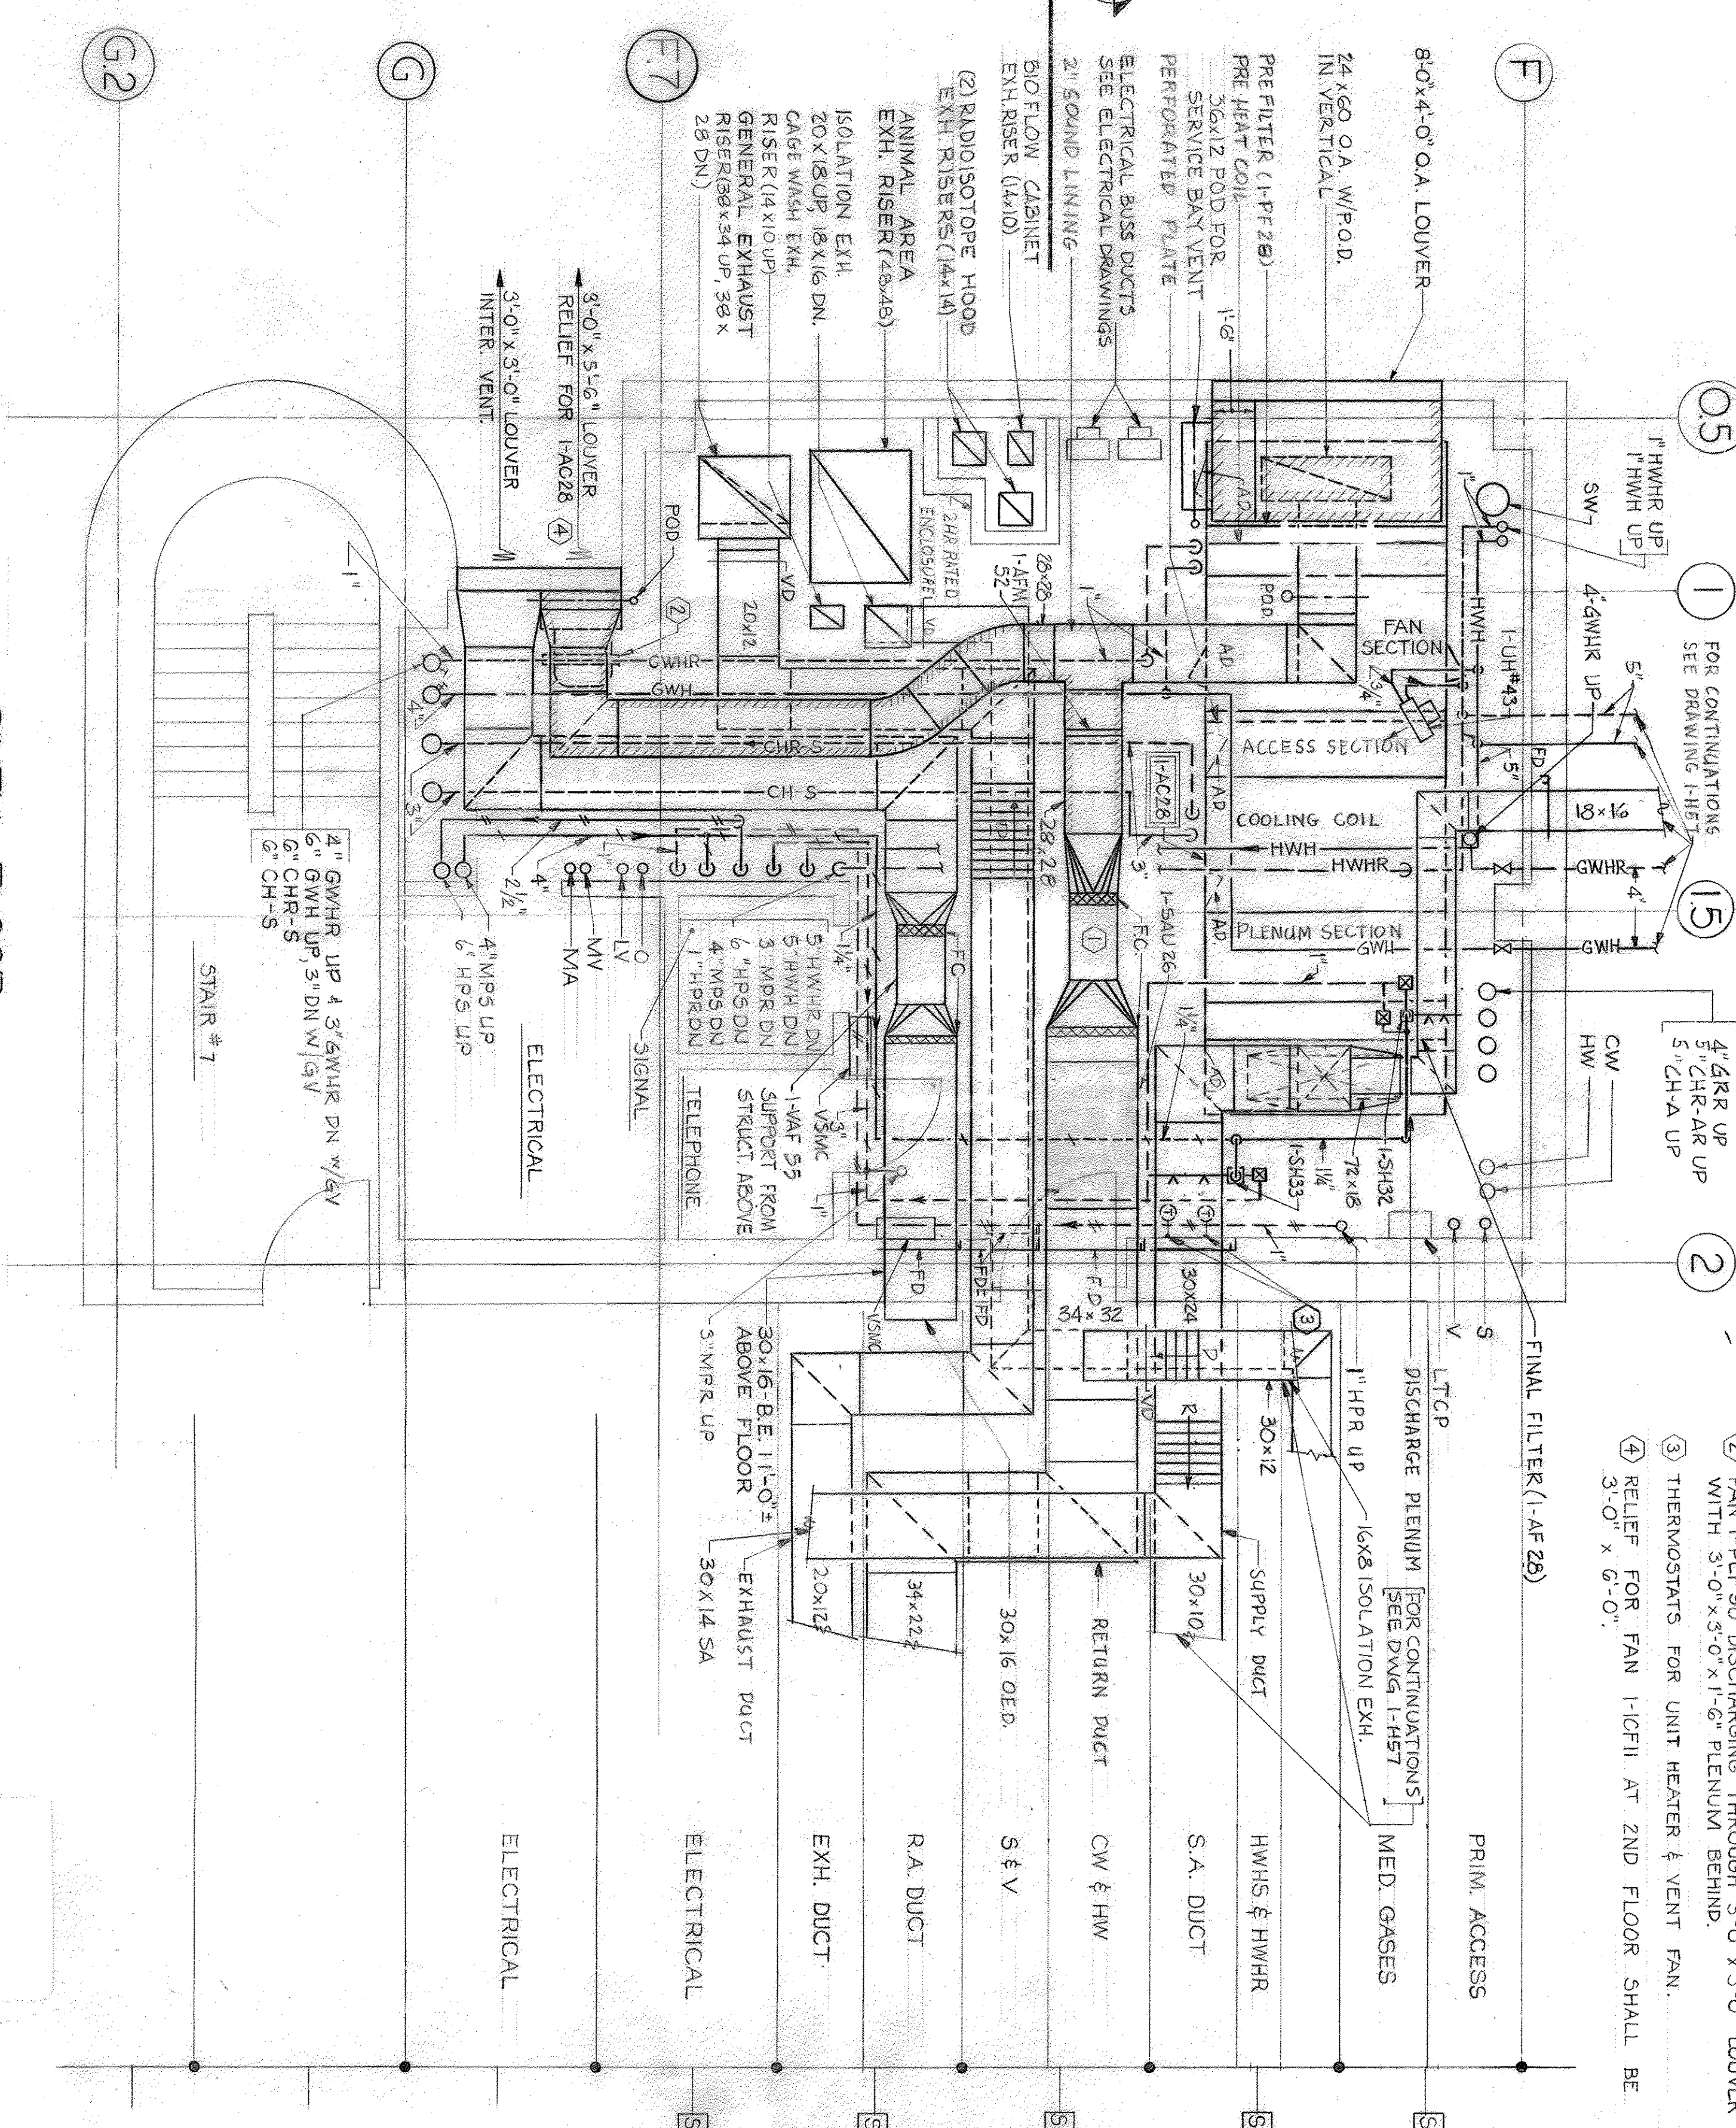

SIXTH FLOOR

ARRANGEMENT OF EQUIPMENT IS SIMILAR FOR FIFTH, FOURTH, THIRD, SECOND AND FIRST FLOOR SERVICE BAYS. WATER, STEAM AND DIST. FLOW DIAGRAMS FOR VARIOUS IN-SITE.

FULLY SPRINKLERED

AS BUILT

6-7-74

Date

Revisions

1

2

3

4

5

6

7

8

9

RECORD DRAWING

CONNECTED ON BASIS OF DATA FURNISHED BY THE RESIDENT ENGINEER

Key Plan

North

RTKL/CSD/HENRY ADAMS (L.V.) ARCHITECTS AND ENGINEERS 400 E. PRATT STREET BALTIMORE, MD 21202

Drawing Title

SERVICE BAY - BSMT & 6TH FL. AREA B HVAC

Project Title

324 - BED REPLACEMENT HOSPITAL - PHASE II

Scale

1/4" = 1'-0"

Approved Project Director

John Miller

Building Number

1

Location

VAMC - BALTIMORE, MD.

Drawing No.

1-H76

Date

9/1/88

Project No.

511-001D

VA FORM 88-3231, OCT 1978

MA JOB NO. 002240

Veterans Administration