



ATTACHMENT A1 (PAGE 1)

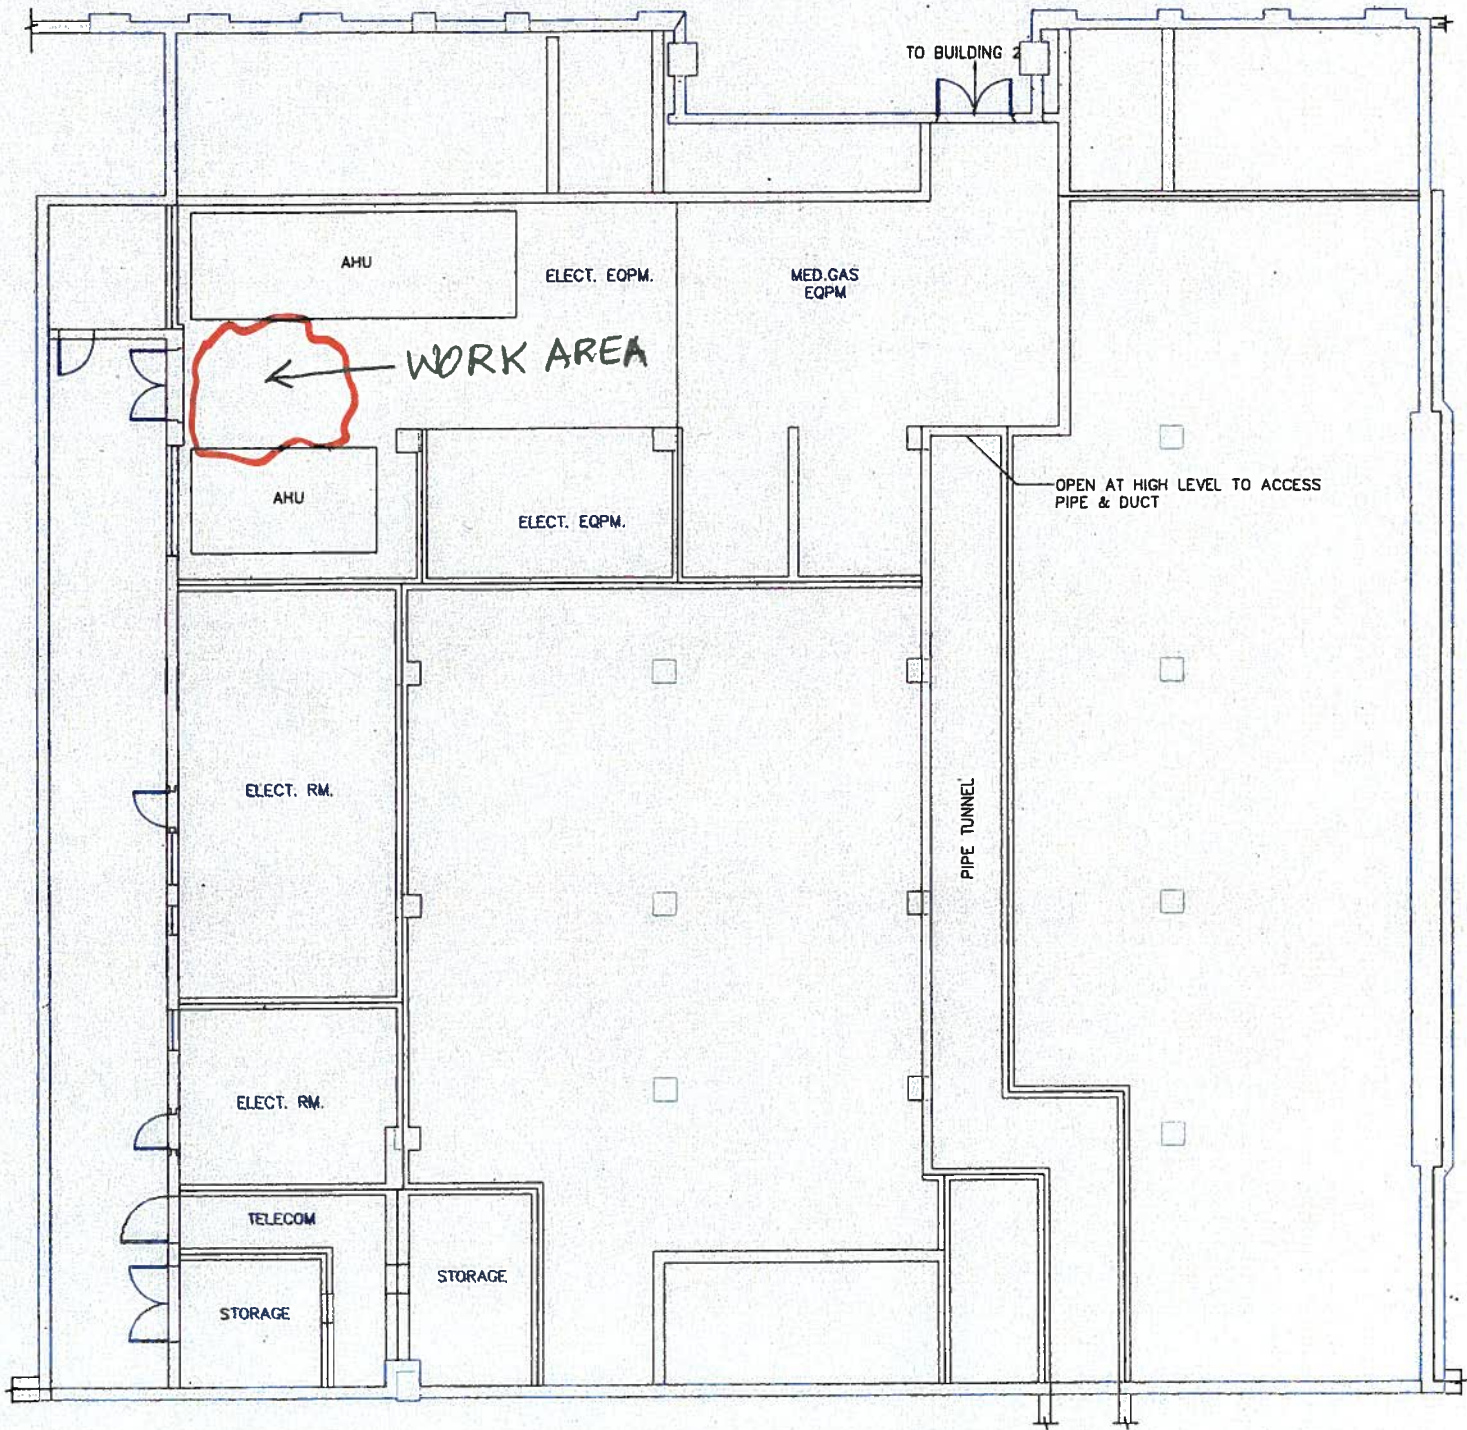

B-200
BASEMENT

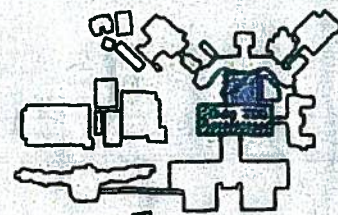

Drawing Title
BASEMENT FLOOR PLAN
ARCHITECTURAL

Approved:

Approved:


Date

Professional Seal

ATTACHMENT - A1 (PAGE 2)
B200 - BF



RAISE THIS
SPRINKLER

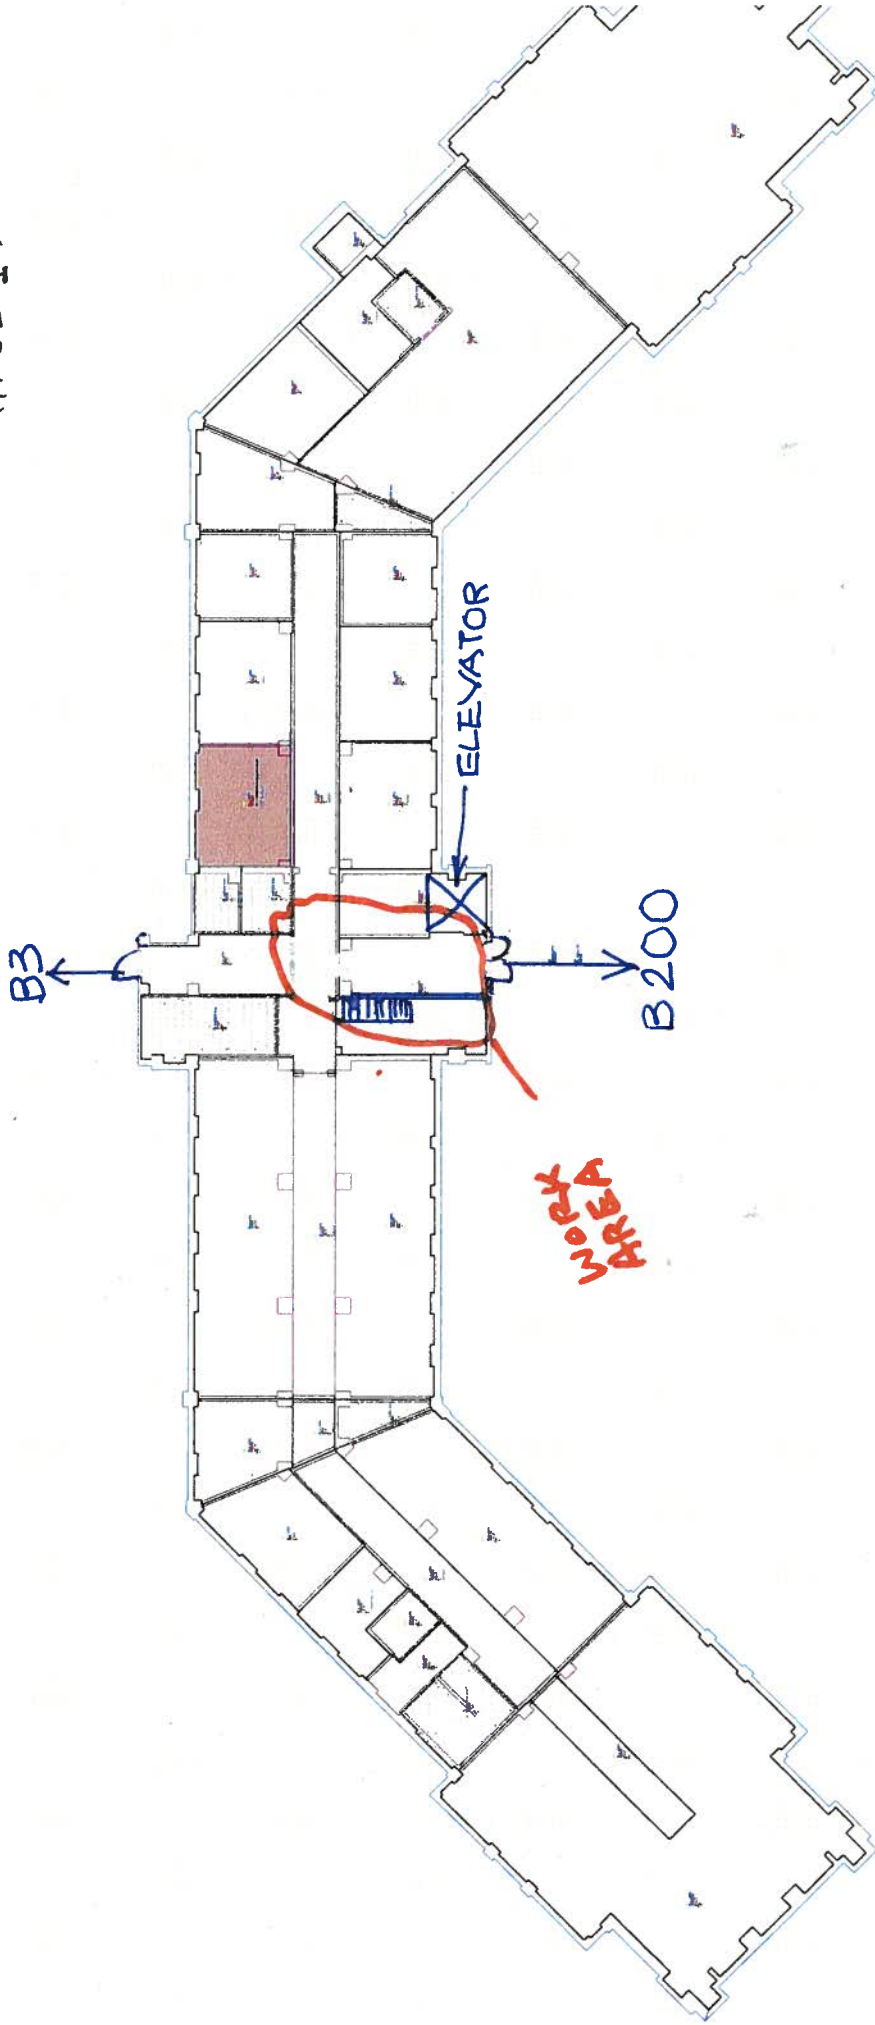

B2
BASEMENT

ATTACHMENT-A2 (PAGE 2)

B2 - BF ELEV LOBBY

↑ B200

B2


EXTEND



P

B3

B3/Rm B6

ELEVATOR

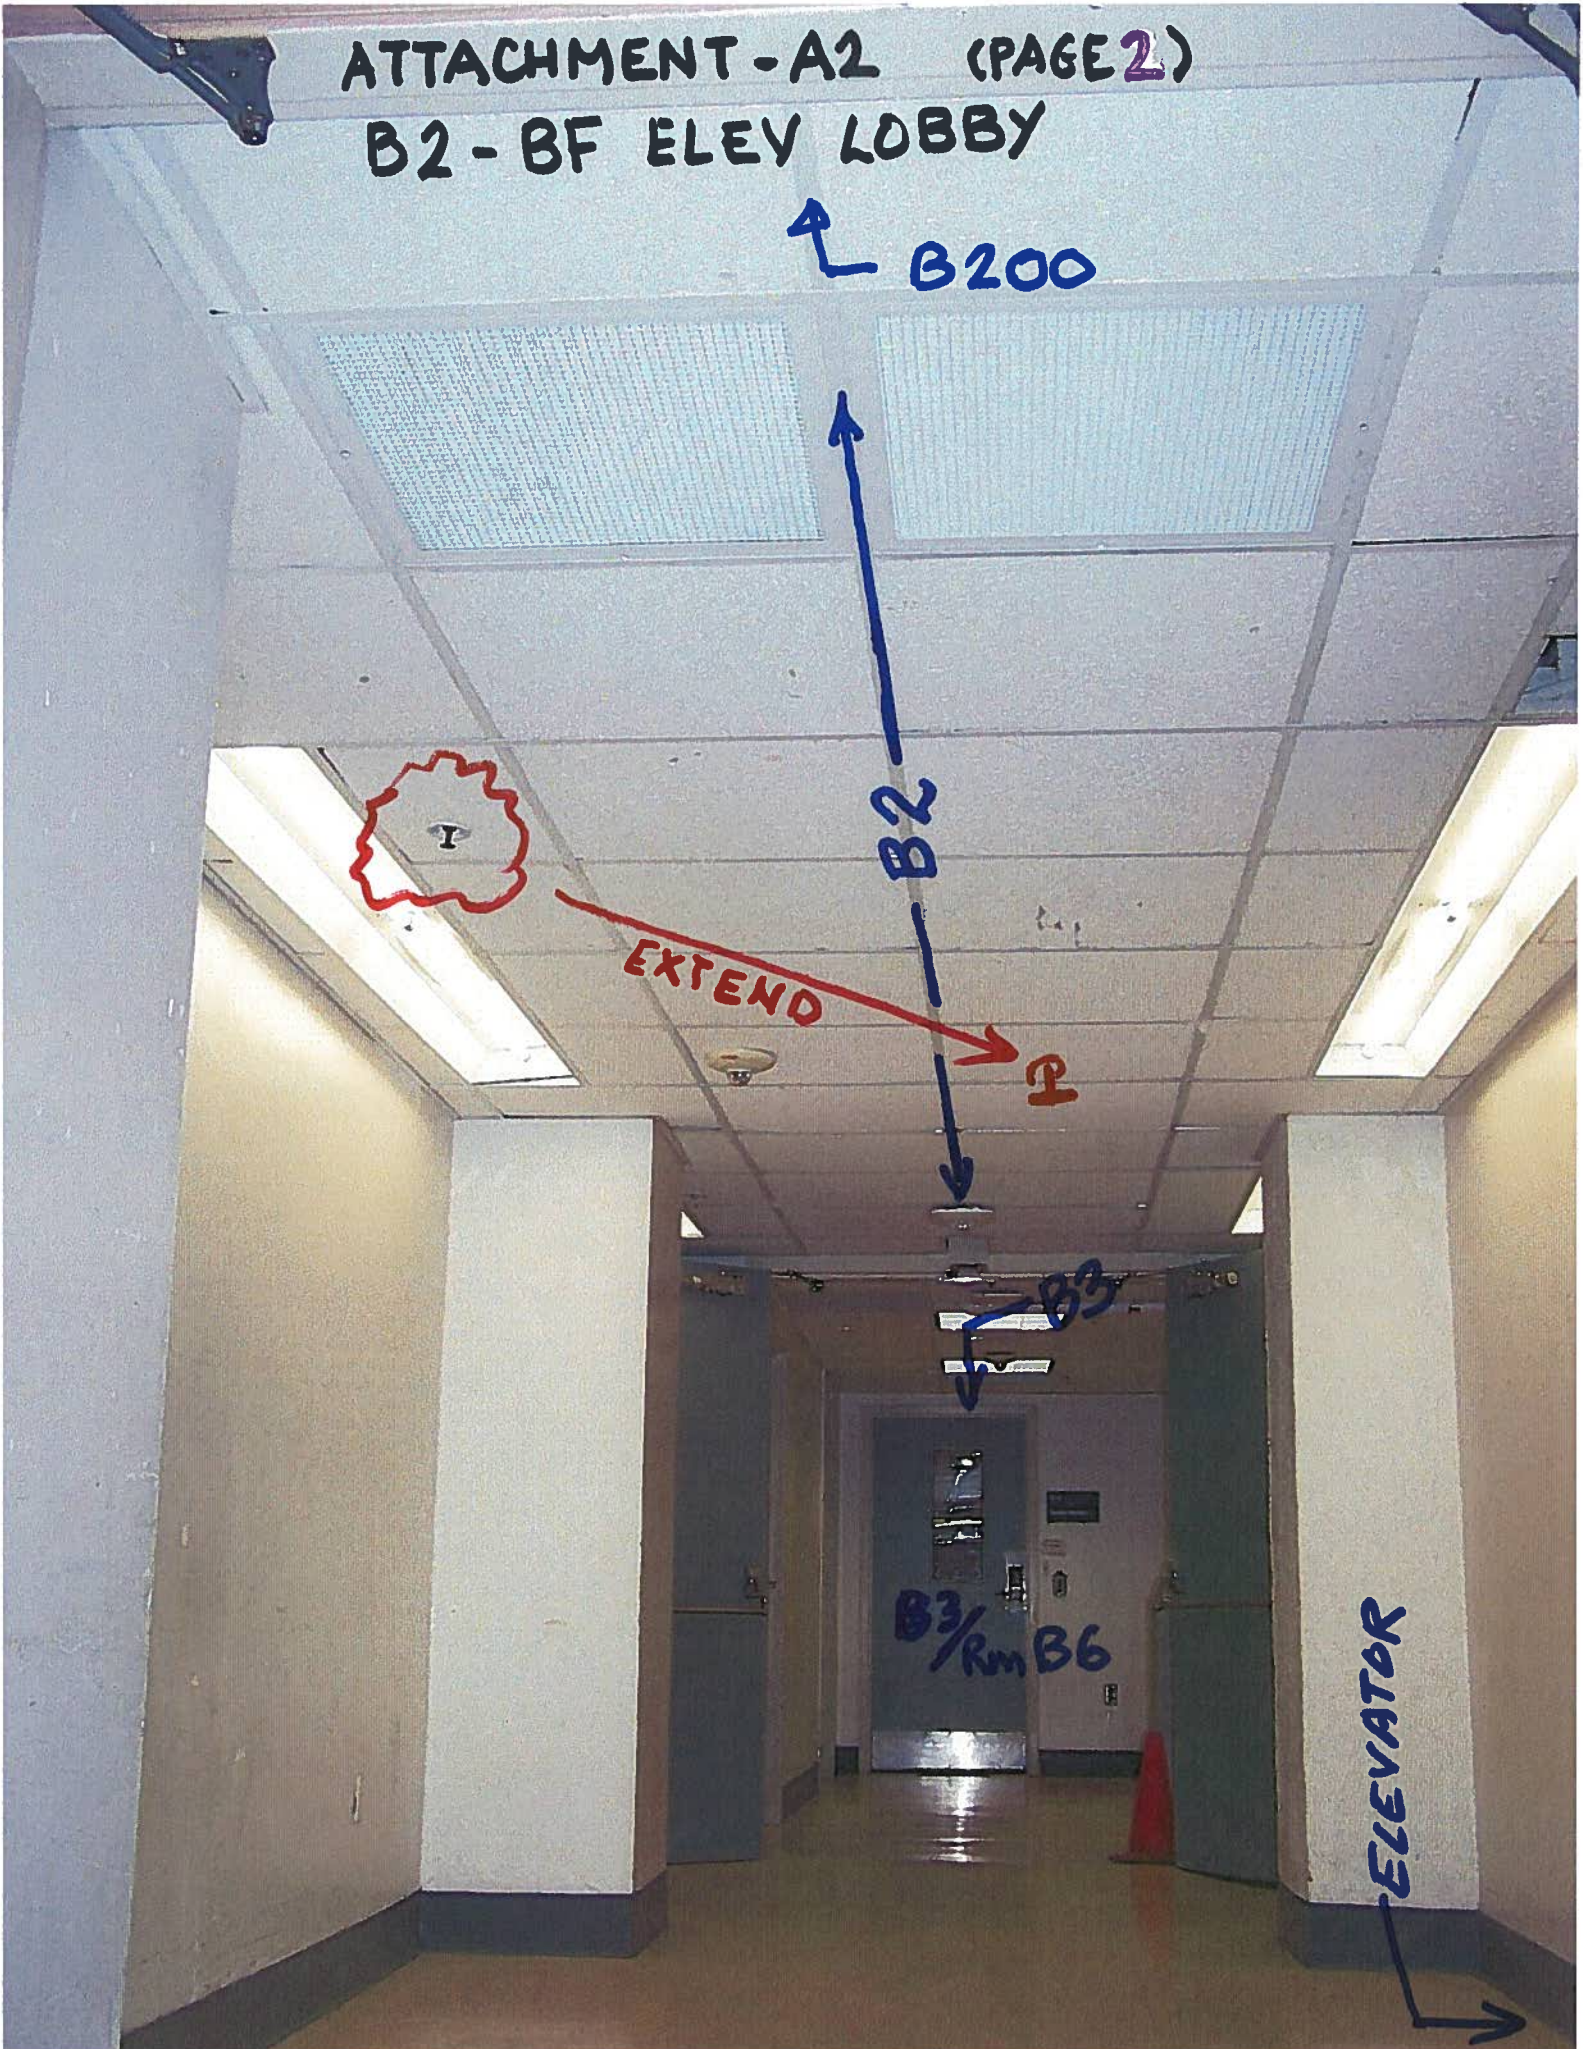

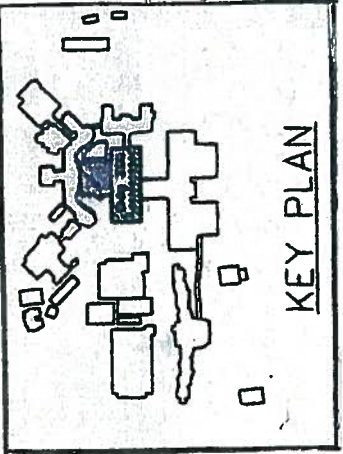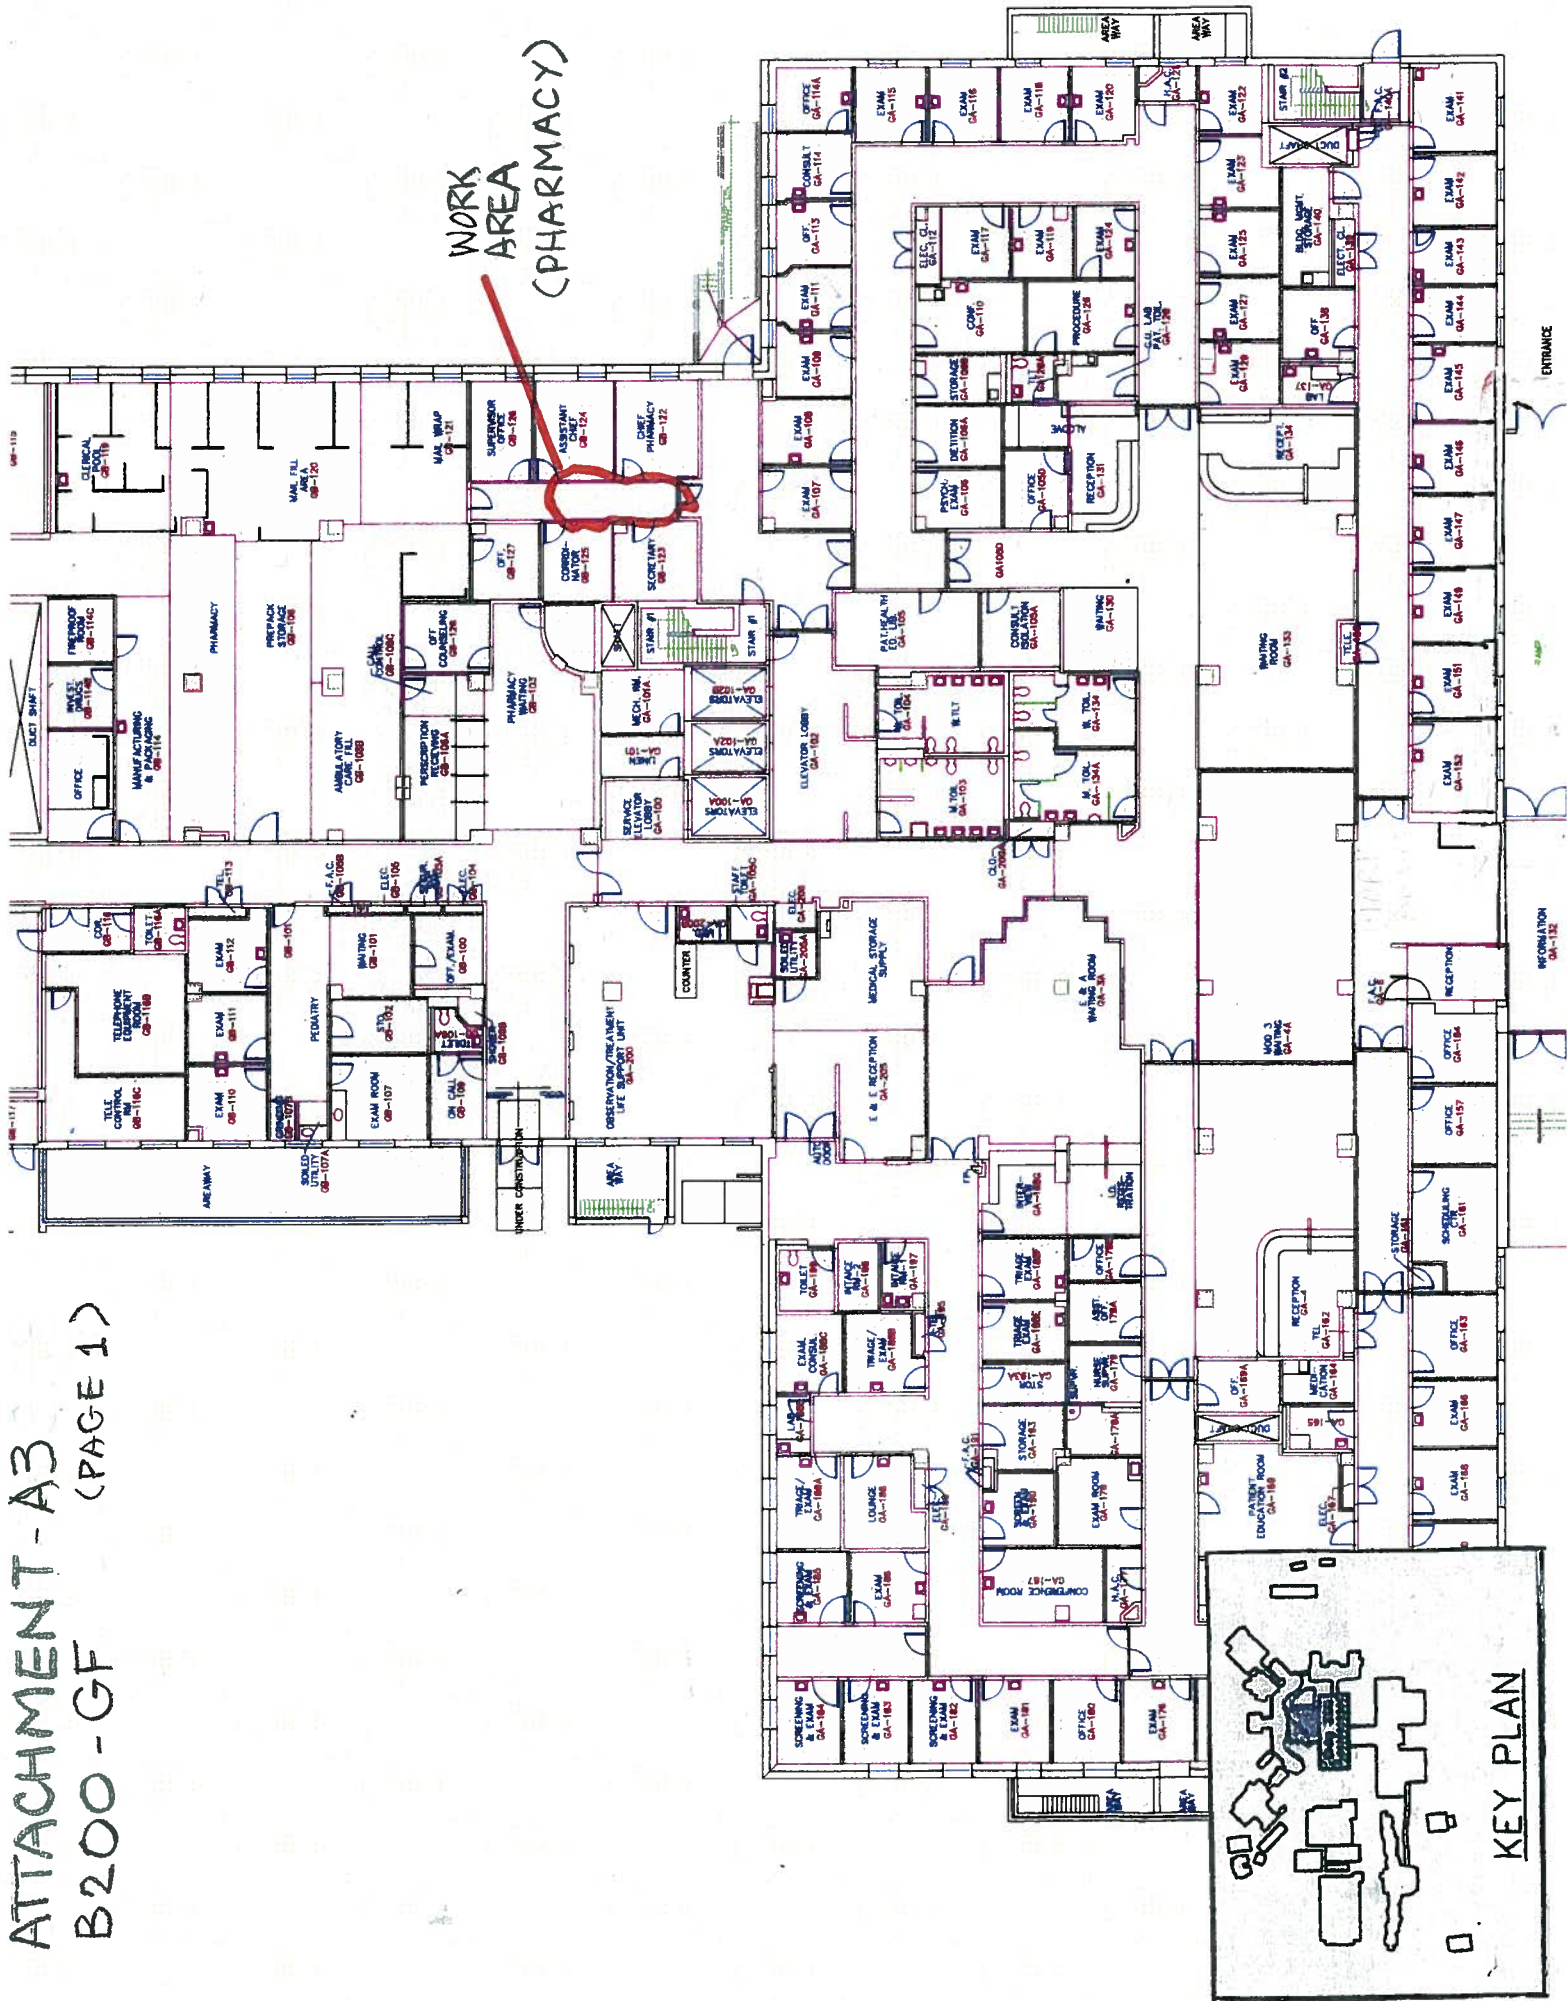

ATTACHMENT A3 (PAGE 2)
B200-GB123
(PHARMACY)

⊕ → ADDITIONAL
ONE HERE



EXISTING



9/16

ATTACHMENT - A4 B208 - ATTIC (PAGE 1)

AREA FROM
X-RAY

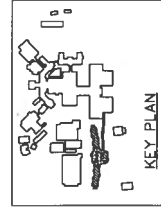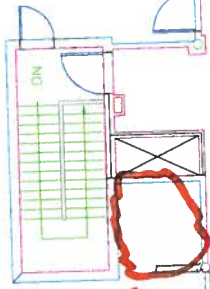

Indus Systems, Inc.
2152 Main Street, Concord MA 01742
Tel: 978-461-0555
www.indus-systems.com

		Date: 08-11-2008 Project No:	Drawing No:
Project Title: AS-BUILT Drawings		Building Number: 208	Location: VAMC, SAN FRANCISCO
Drawing Title: PENT HOUSE PLAN ARCHITECTURAL		Checked:	Drawn:
Approved:		Approved:	

ATTACHMENT - A4
B208 - PENTHOUSE
(PAGE 2)

