


GENERAL NOTES:

- A. "ETR" ADJACENT TO A DEVICE, FIXTURE, OR PIECE OF EQUIPMENT INDICATES ITEM SHALL REMAIN. MAINTAIN EXISTING ELECTRICAL CONNECTIONS UNLESS OTHERWISE NOTED.
- B. "ERL" ADJACENT TO A DEVICE, FIXTURE, OR PIECE OF EQUIPMENT INDICATES EXISTING ITEM SHALL BE RELOCATED. DISCONNECT AND REMOVE, REINSTALL AT NEW LOCATION AND RECONNECT ITEM AS REQUIRED.
- C. "T" TAPPING OF FIRE ALARM SYSTEM WIRING IS NOT ALLOWED. SYSTEM WIRING MUST BE RUN IN SERIES WITH PREVIOUS DEVICE ON SYSTEM CIRCUIT.
- D. CONTRACTOR IS RESPONSIBLE FOR ALL CUTTING AND PATCHING AT ALL WALL PENETRATIONS REQUIRED TO MOUNT NEW FIRE ALARM DEVICES. PATCH AND PAINT WALL TO MATCH EXISTING WALL CONDITIONS.

DRAWING NOTES:

- ① PROVIDE AUDIO/VISUAL FIRE ALARM NOTIFICATION APPLIANCE AND UTILIZE EXISTING •18AWG T.S.P. SYSTEM SIGNALING CIRCUIT •1CABLING MAINTAINED AFTER REMOVAL OF OLD DEVICE. PROVIDE (2)•12AWG SYSTEM CABLING FOR VISUAL SIGNAL IN EXISTING 1" CONDUIT. PROGRAM/TEST DEVICE TO ENSURE PROPER SYSTEM OPERATION. REFER TO RISER DIAGRAM ON E501 FOR MORE INFORMATION.
- ② PROVIDE AUDIO/VISUAL FIRE ALARM NOTIFICATION APPLIANCE AND PROVIDE SYSTEM SIGNALING CIRCUIT •2 CABLING TO DEVICE AS REQUIRED BY MANUFACTURER. PROVIDE (2)•12AWG SYSTEM CABLING FOR VISUAL SIGNAL AND •18AWG T.S.P. FOR AUDIO SIGNAL TO NEW AUDIO/VISUAL APPLIANCES IN EXISTING 1" CONDUIT. PROGRAM/TEST DEVICE TO ENSURE PROPER SYSTEM OPERATION. REFER TO RISER DIAGRAM ON E501 FOR MORE INFORMATION.
- ③ PROVIDE AUDIO/VISUAL FIRE ALARM NOTIFICATION APPLIANCE AND PROVIDE SYSTEM SIGNALING CIRCUIT •2 CABLING TO DEVICE AS REQUIRED BY MANUFACTURER. PROVIDE (2)•12AWG SYSTEM CABLING FOR VISUAL SIGNAL AND •18AWG T.S.P. FOR AUDIO SIGNAL TO NEW AUDIO/VISUAL APPLIANCES. PROVIDE 1" CONDUIT FOR ROUTING OF NEW SYSTEM CABLING. PROGRAM/TEST DEVICE TO ENSURE PROPER SYSTEM OPERATION. REFER TO RISER DIAGRAM ON E501 FOR MORE INFORMATION.

NO HANGERS SHALL BE CONNECTED TO EXISTING CONCRETE BEAMS. ALL HANGERS SHALL BE SECURED FROM THE DECK.

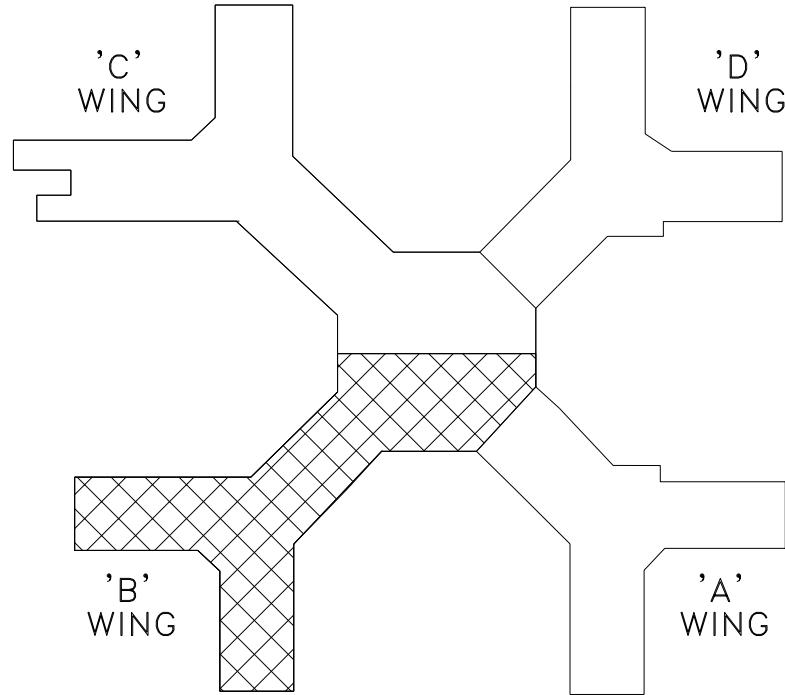

TENTH FLOOR

KEY PLAN

NO SCALE

10TH FLOOR PLAN – "B" WING – ELECTRICAL

1" = 10'-0"

1

ISSUE FOR BID		02/07/14
Revisions		Date

VA WESTERN NEW YORK HEALTHCARE SYSTEM
3495 BAILEY AVENUE
BUFFALO, NEW YORK 14215

CLINICAL ENGINEERING	DATE	ENGINEERING MANAGER	DATE
INFECTION CONTROL	DATE	CARELINE MANAGER	DATE
SAFETY OFFICER	DATE	CHIEF OF STAFF	DATE

Drawing Title 10TH FLOOR PLAN – "B" WING	
MEDICAL CENTER DIRECTOR	
ASSOCIATE MEDICAL CENTER DIRECTOR	

Project Title 10TH FLOOR FIRE ALARM UPDATES		
Building Number 1	Checked CDW	Drawn JTR
Location V.A.M.C. BUFFALO, NEW YORK		

Date FEBRUARY 7, 2014
Station No. 528
08-116-E101

