


FIRE ALARM WIRE LIST (POWER LIMITED)	
B	VISUAL/SIGNAL CIRCUIT - (2)#12AWG SOLID
S	SPEAKER CIRCUIT - (1)18 AWG T.S.P. OVERALL SHIELD

- DRAWING NOTES:
- ① ALL DEVICES AND WIRING ON THIS CIRCUIT ARE EXISTING TO REMAIN.
- ② FIRE ALARM SPEAKER/STROBE CIRCUIT. T-TAPPING IS NOT ALLOWED. PROVIDE #18AWG T.S.P. IN - #18AWG T.S.P. OUT FOR SPEAKER CIRCUIT AND (2)#12AWG (RED/BLACK) IN - (2)#12AWG (RED/BLACK) OUT FOR STROBE CIRCUIT. POLARITY MUST BE CONSISTENT. UTILIZE EXISTING 10K END OF LINE RESISTOR.
- ③ PROVIDE (2)#12AWG (RED/BLACK) IN - (2)#12AWG (RED/BLACK) OUT FOR STROBE CIRCUIT TO NEW AUDIO/VISUAL APPLIANCES ONLY. 18AWG T.S.P. EXISTING TO REMAIN. EXTEND 18AWG T.S.P. TO NEW DEVICES ON THIS CIRCUIT. REFERENCE DRAWINGS E101/E102 FOR NEW APPLIANCE LOCATIONS. UTILIZE EXISTING 10K END OF LINE RESISTOR.

11TH FLOOR (BLDG. 1)

10TH FLOOR (BLDG. 1)

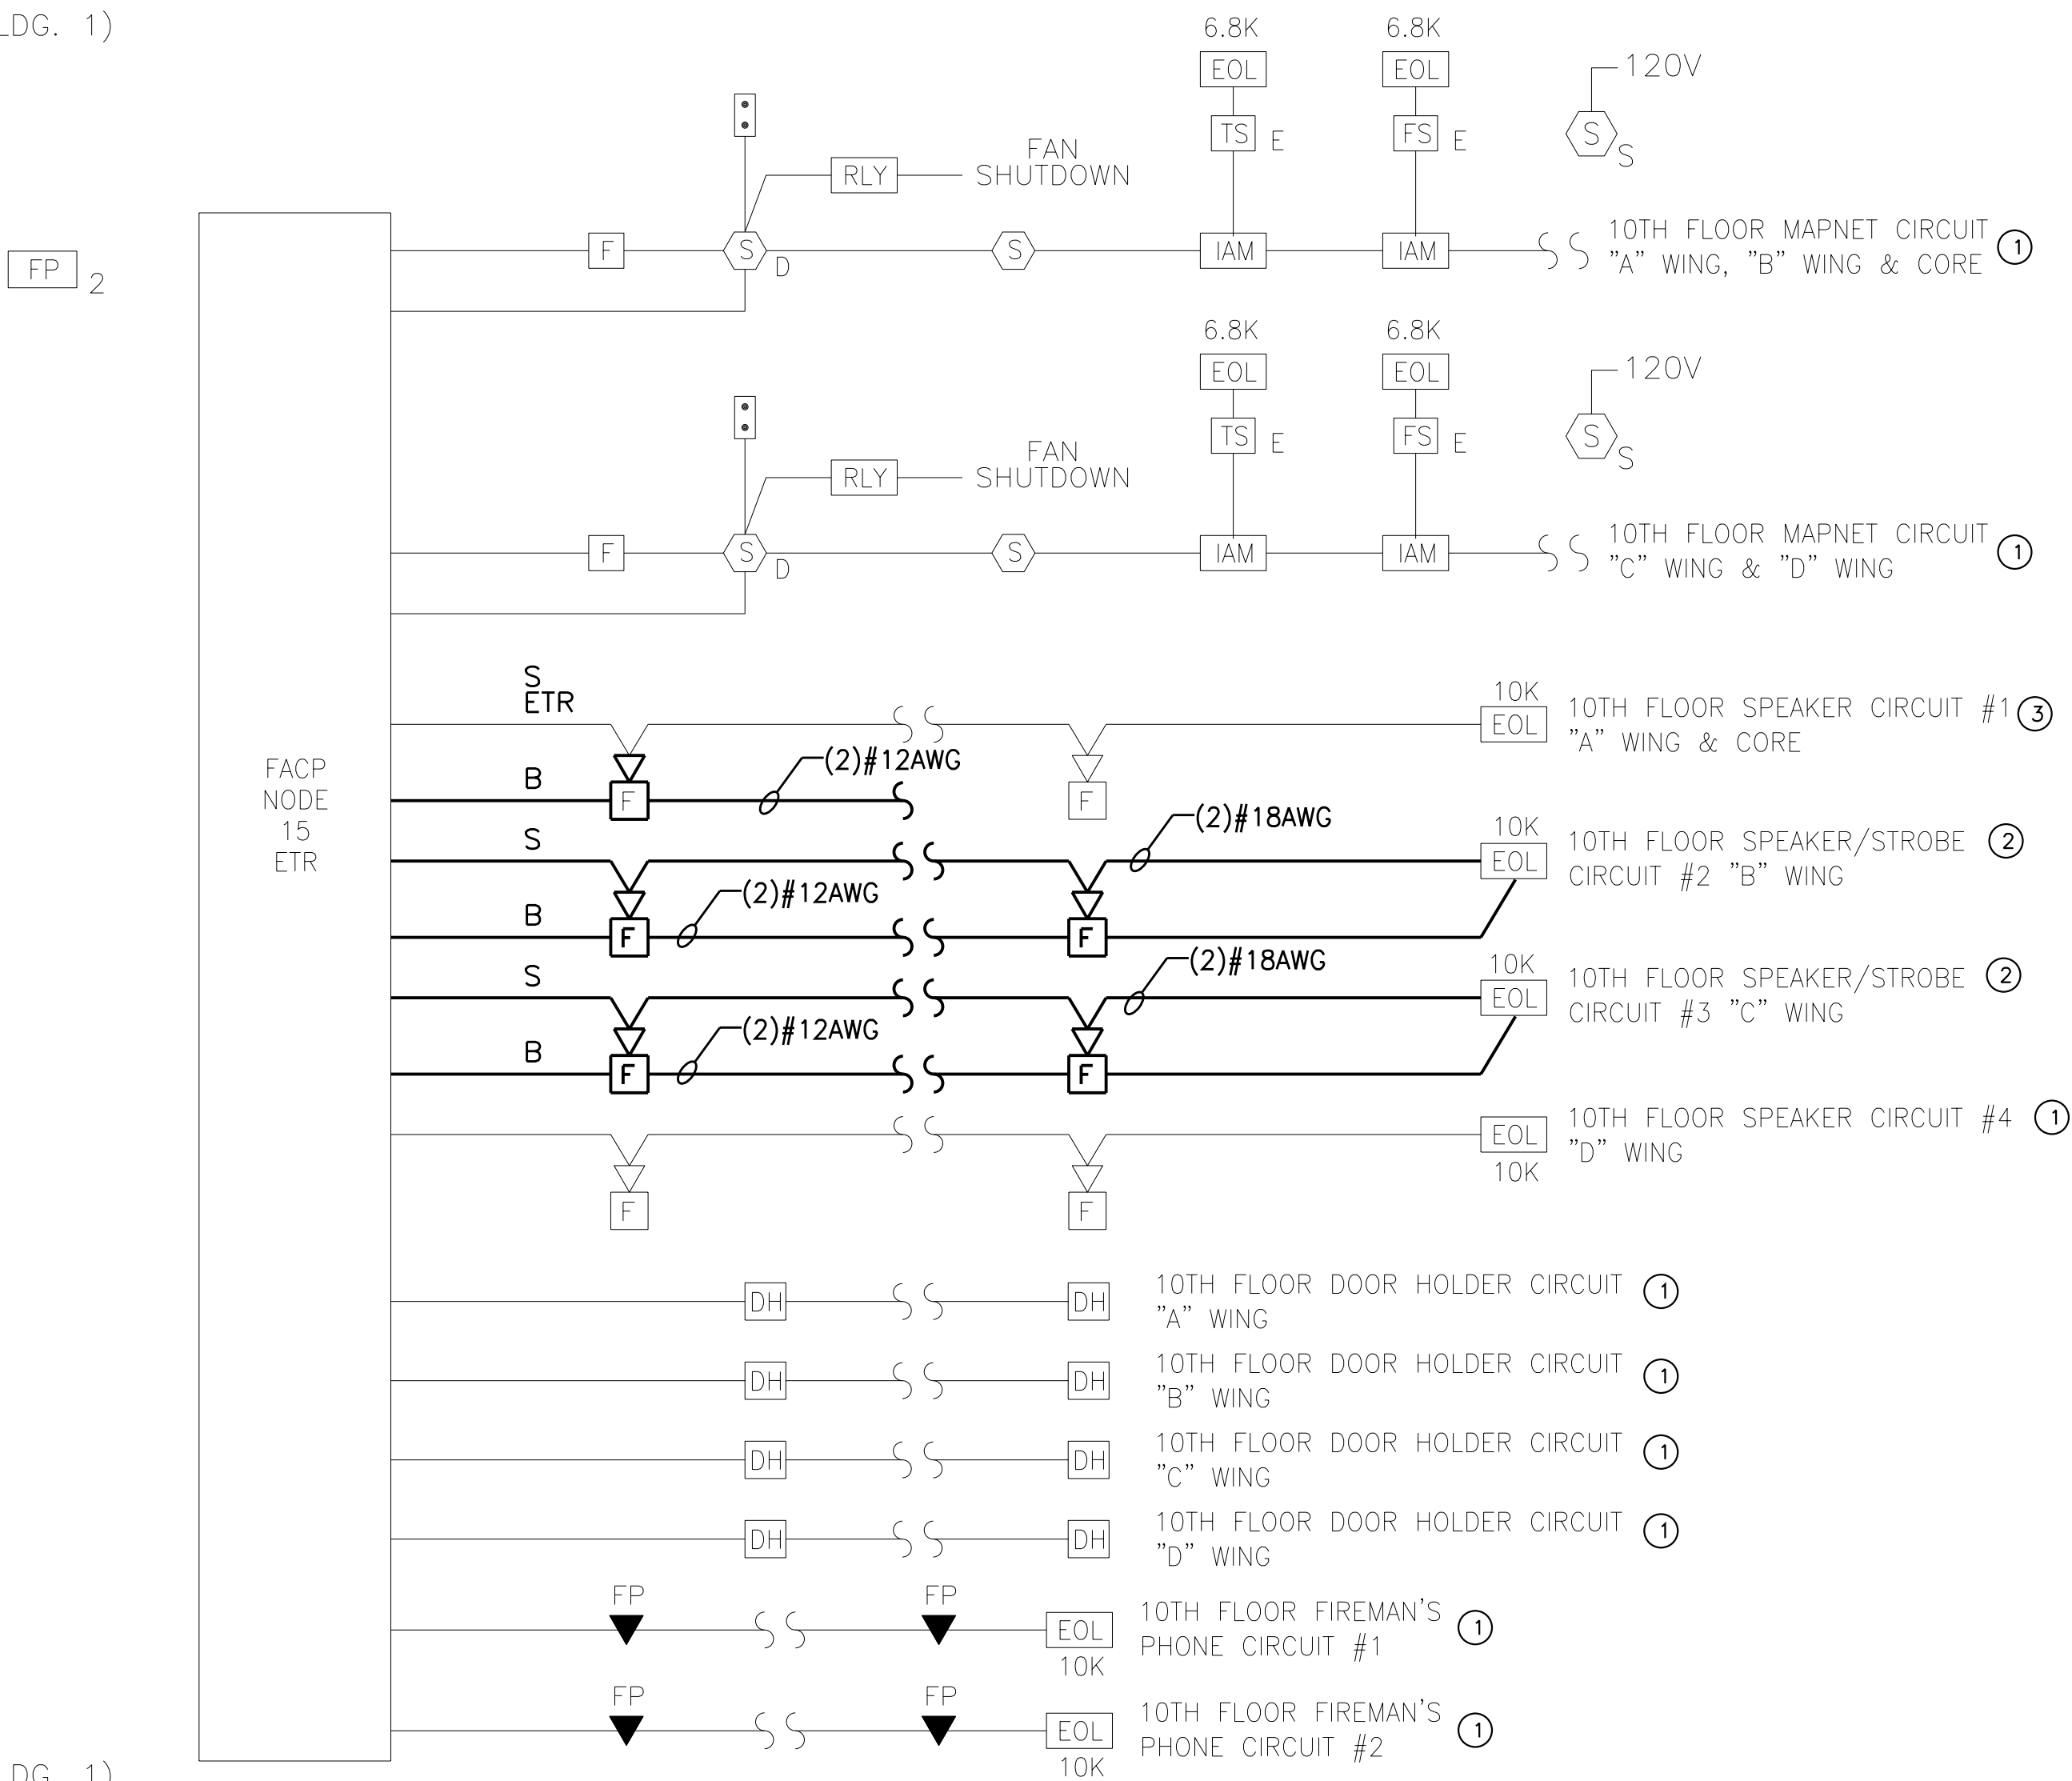

10TH FLOOR (BLDG. 1)

9TH FLOOR (BLDG. 1)

ISSUE FOR BID		02/07/14
Revisions		Date

VA WESTERN NEW YORK HEALTHCARE SYSTEM
3495 BAILEY AVENUE
BUFFALO, NEW YORK 14215

CLINICAL ENGINEERING	DATE	ENGINEERING MANAGER	DATE
INFECTION CONTROL	DATE	CARELINE MANAGER	DATE
SAFETY OFFICER	DATE	CHIEF OF STAFF	DATE

Drawing Title	
ELECTRICAL DETAILS	
MEDICAL CENTER DIRECTOR	
ASSOCIATE MEDICAL CENTER DIRECTOR	

Project Title		
10TH FLOOR FIRE ALARM UPDATES		
Building Number	Checked	Drawn
1	CDW	JTR
Location		
V.A.M.C. BUFFALO, NEW YORK		

Date
FEBRUARY 7, 2014
Station No.
528
08-116-E501

