

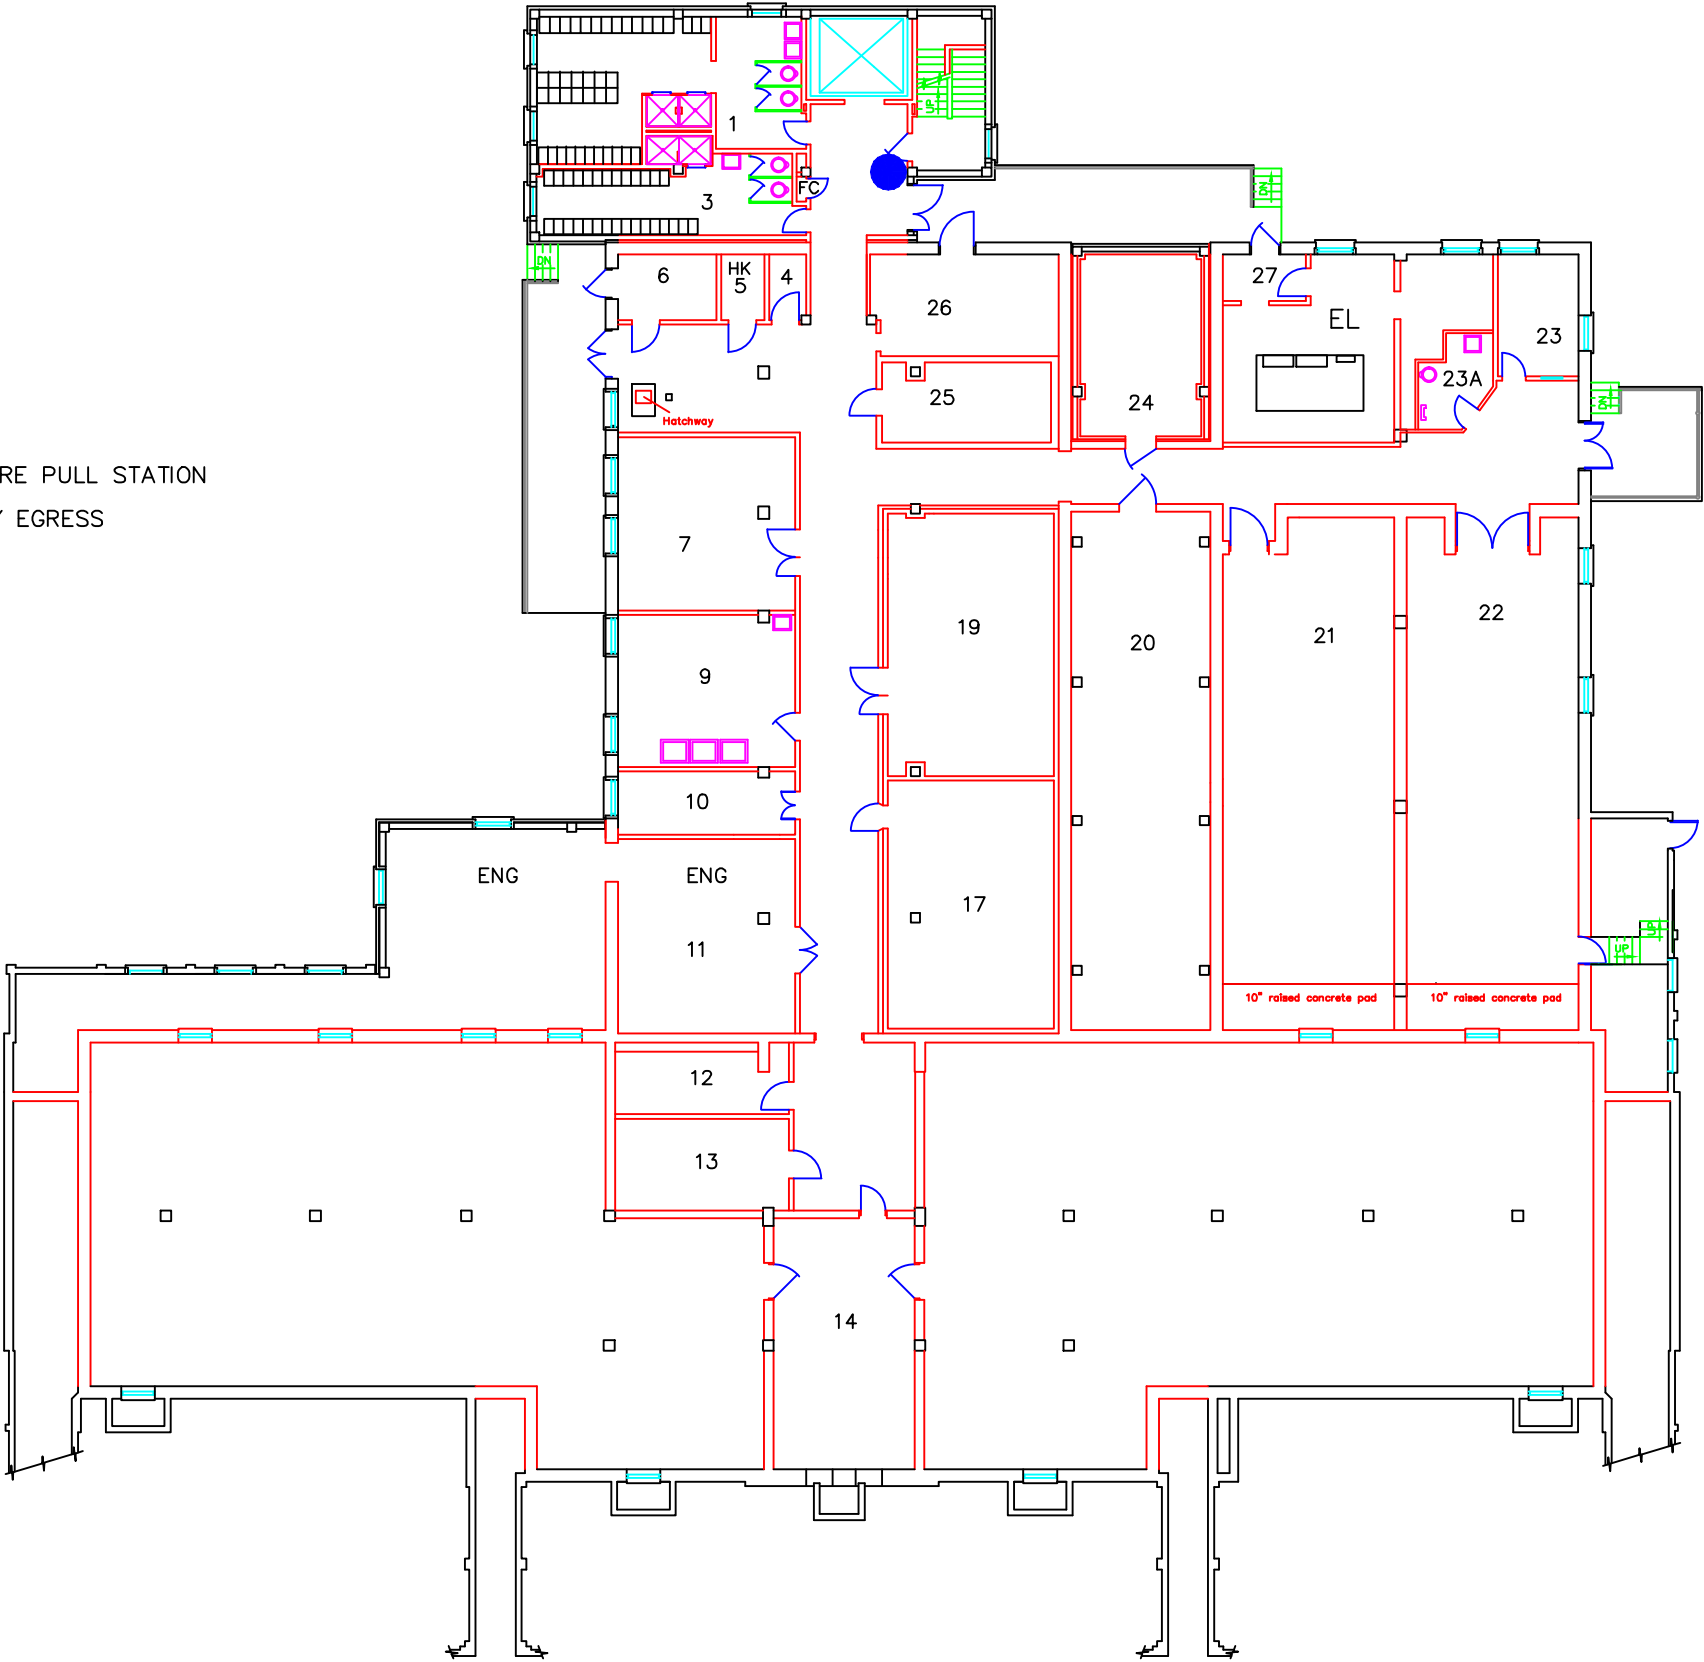


P:\Shared\PROJECTS\Building & Site Projects\MULTIPLE BLDGS\Bldg 5 & 11 -- Install Fire Pull Stations\NH-11-01.dwg



Revisions	Date	Professional Seal	Drawing Title	Project Title		Date		VA Department of Veterans Affairs	
			FIRST FLOOR	RECREATION HALL		02/2014			
			Approved: Project Manager	Drawing No.	Checked	Drawn GT			Project No.
			Approved: Service Chief	Location		VAMC, NORTHAMPTON MASS.			Building Number
					11				


EXISTING FIRE PULL STATION
EMERGENCY EGRESS

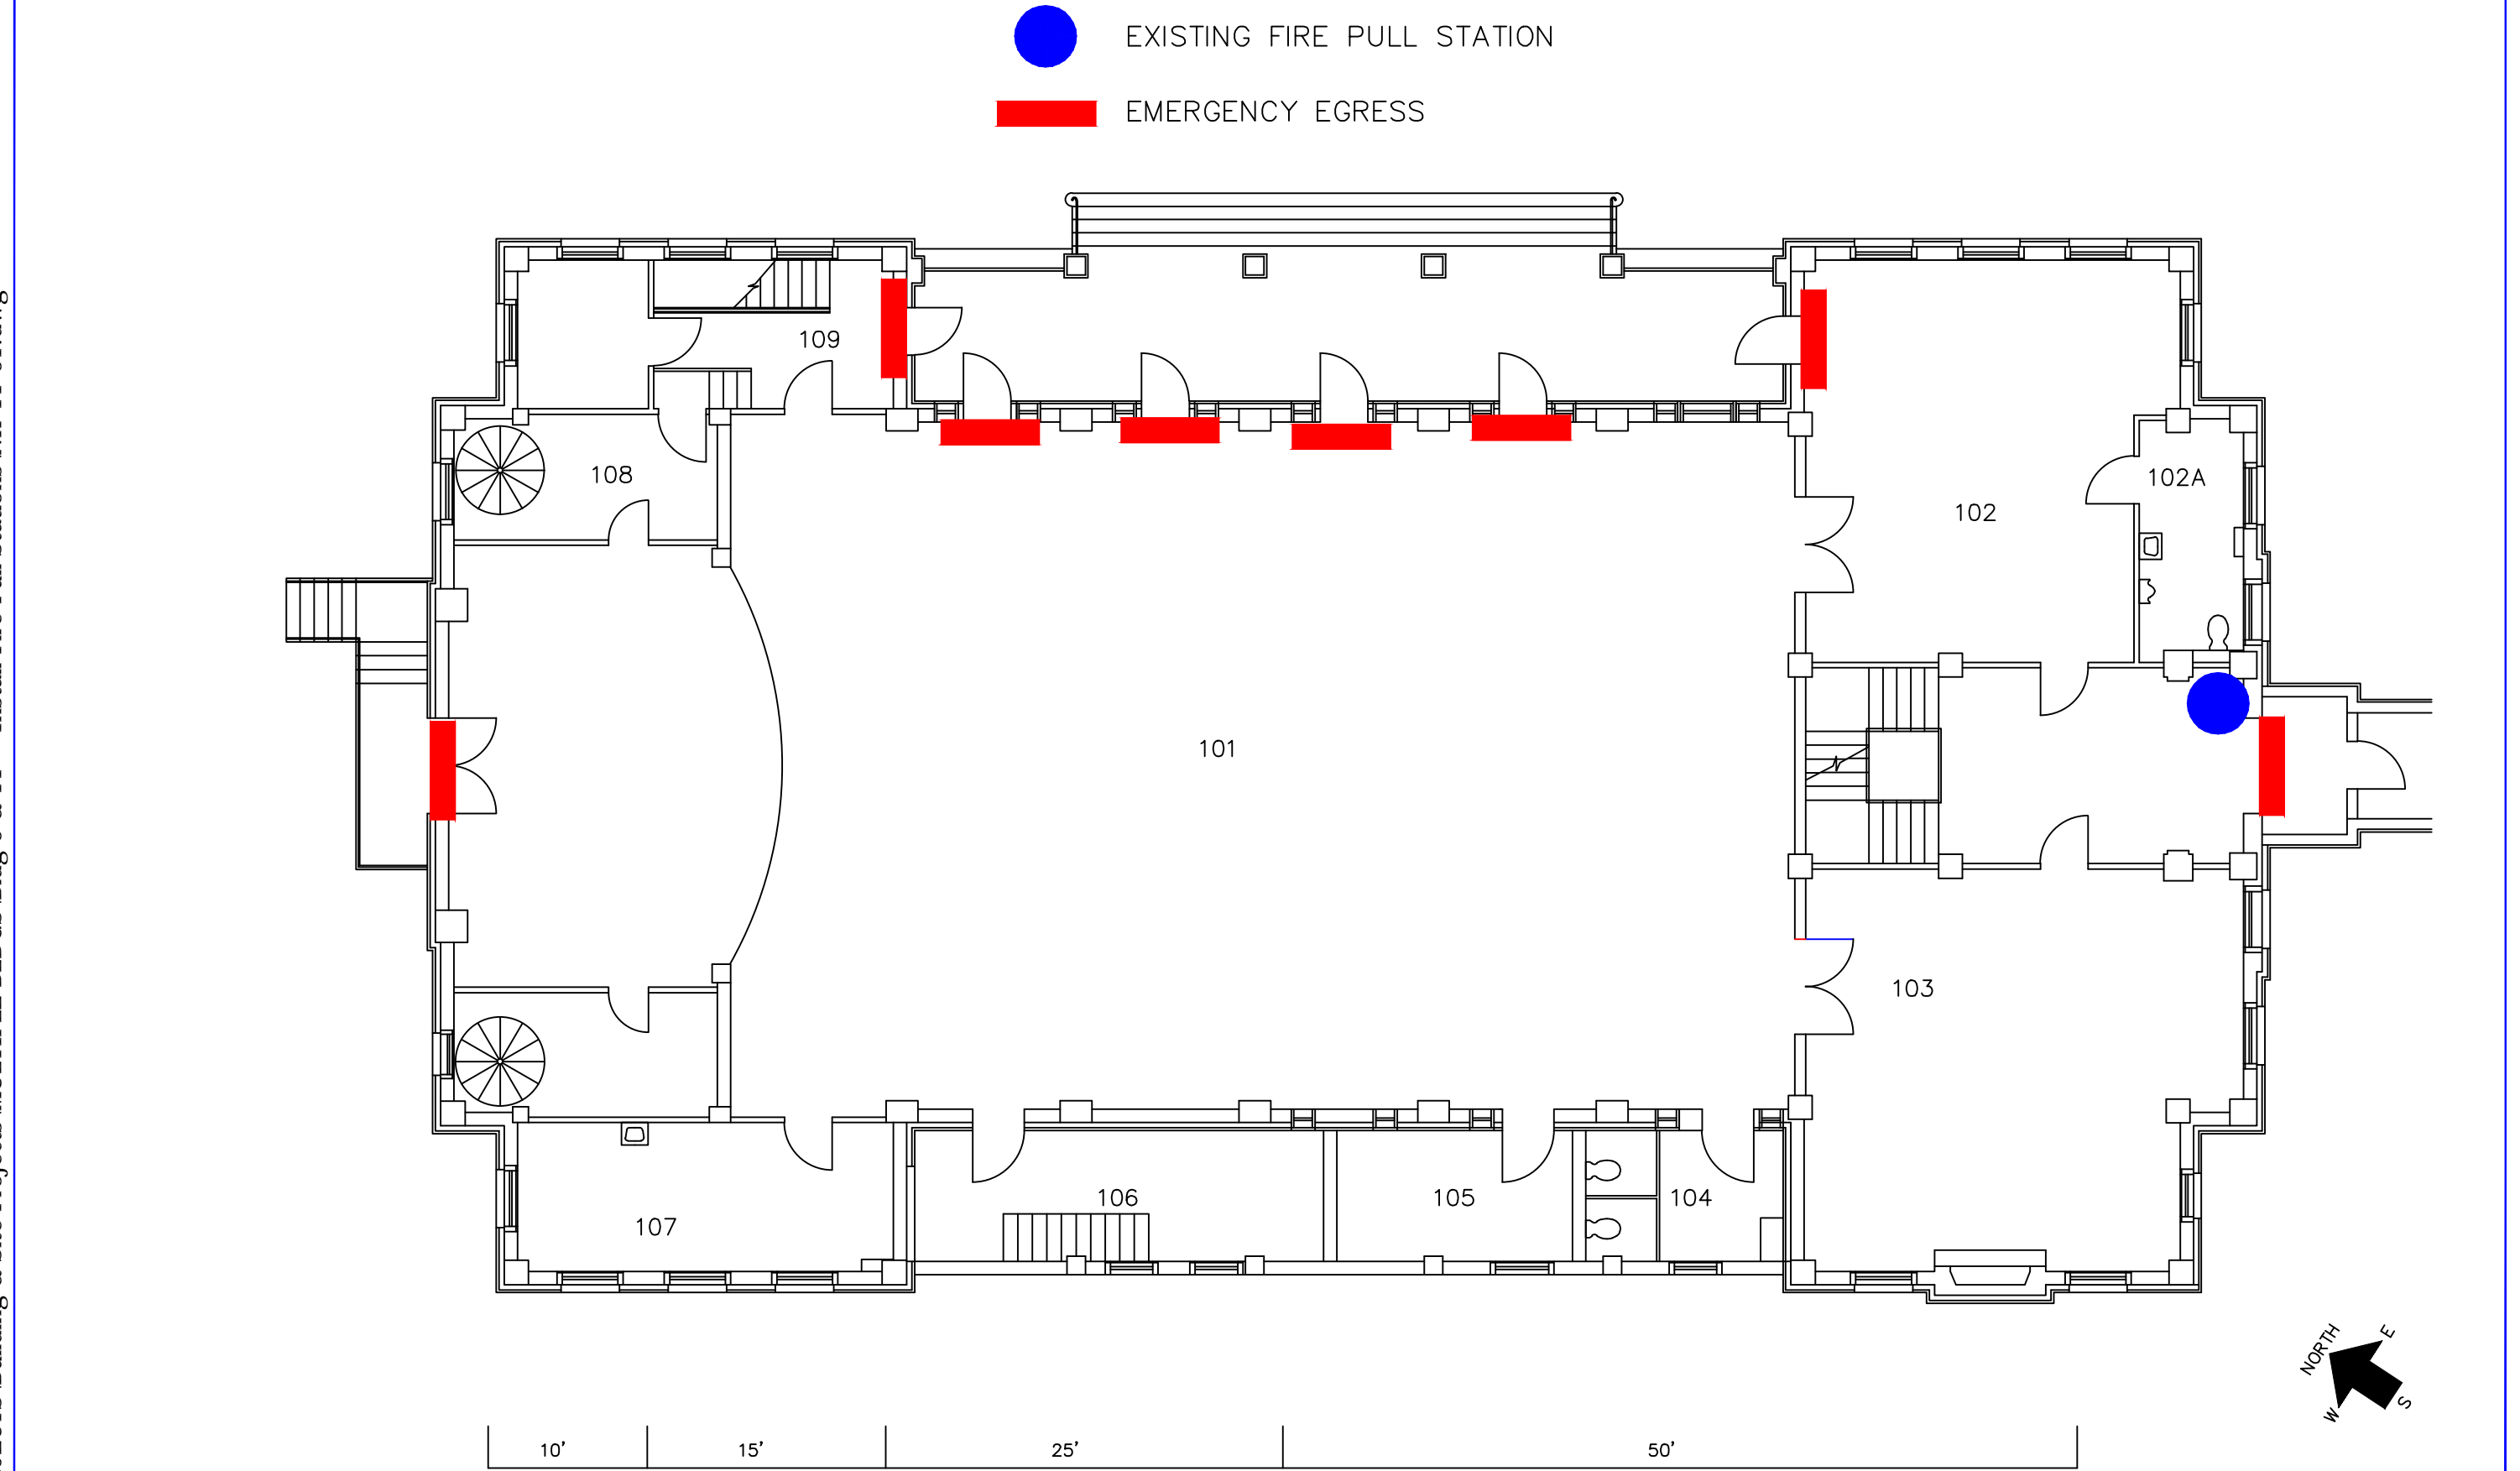



10' 15' 25' 50'

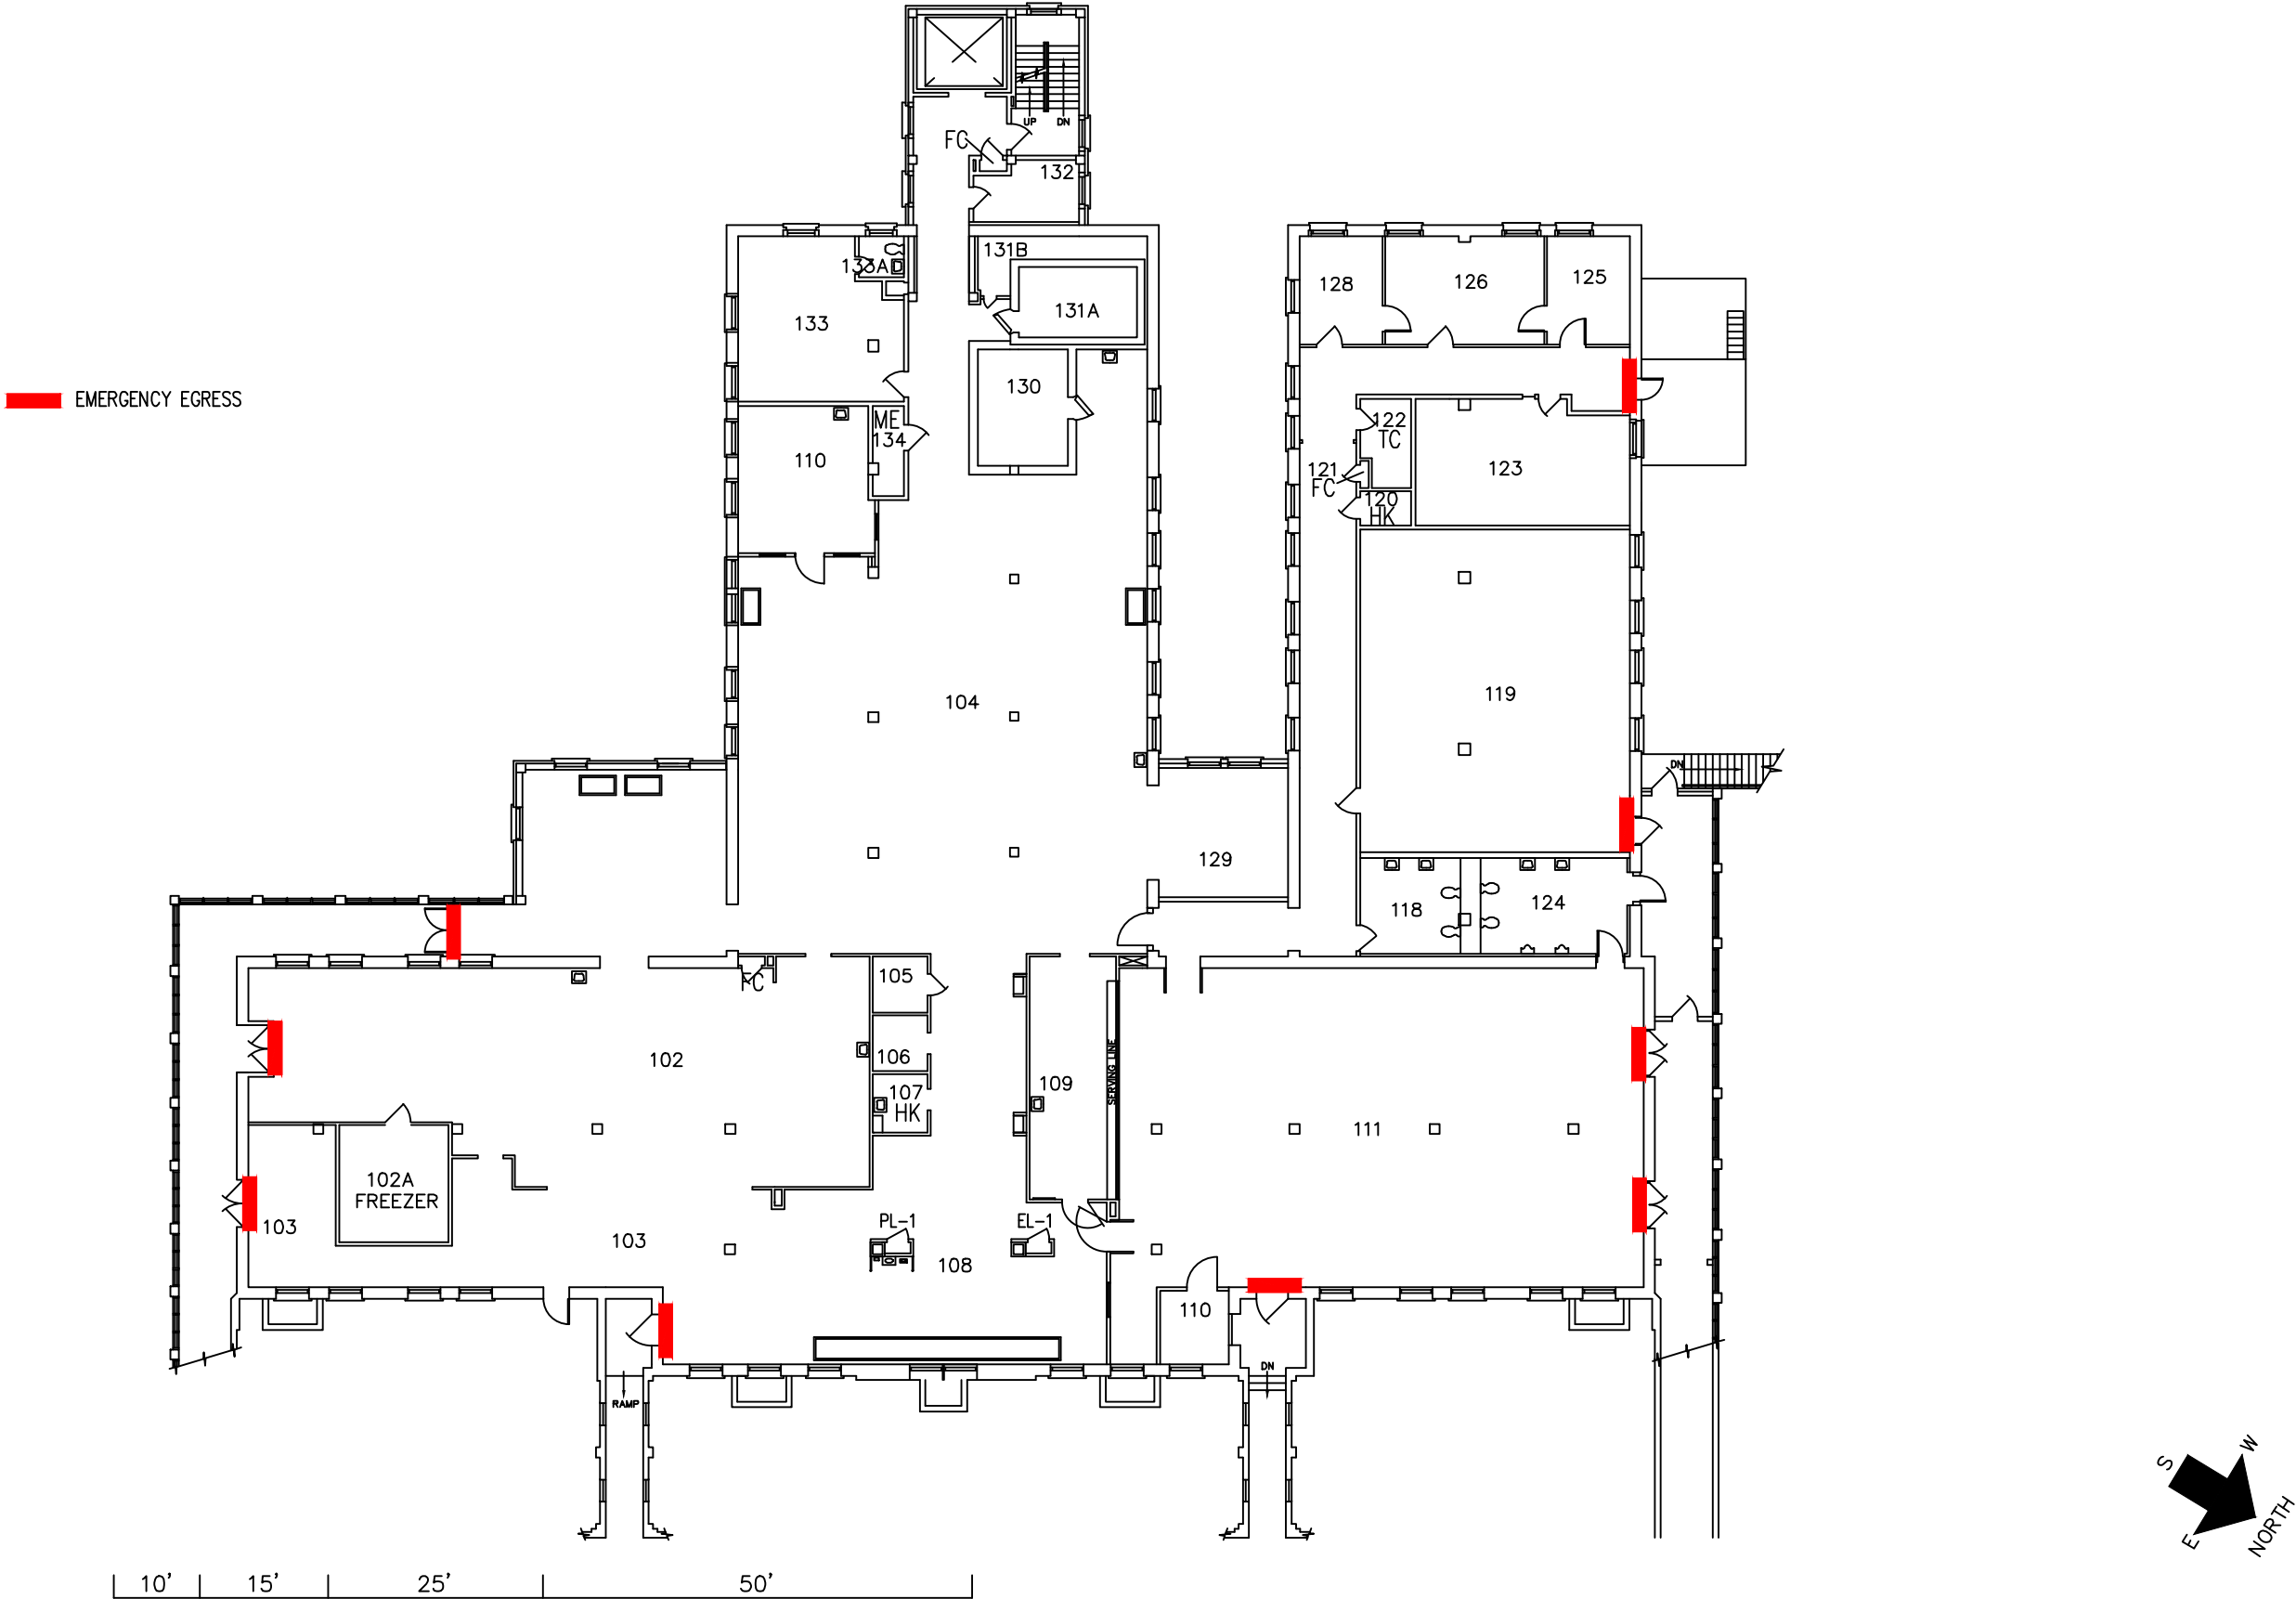


Revisions		Date	Professional Seal	Drawing Title		Project Title		Date			VA Department of Veterans Affairs
				BASEMENT FLOOR PLAN		MAIN KITCHEN		02/2014			
				Approved: Project Manager		Drawing No.	Checked	Drawn GT	Project No.		
				Approved: Service Chief		Location		VAMC, NORTHAMPTON MASS.		Building Number	
										5	



						Drawing Title		Project Title			Date			
						FIRST FLOOR		MAIN KITCHEN			02/2014			
											Project No.			
Approved: Project Manager		Drawing No.		Checked		Drawn GT		Building Number						
Approved: Service Chief		Location		VAMC, NORTHAMPTON MASS.			5							

P:\Shared\PROJECTS\Building & Site Projects\MULTIPLE BLDGS\Bldg 5 & 11 -- Install Fire Pull Stations\NH-11-OB.dwg

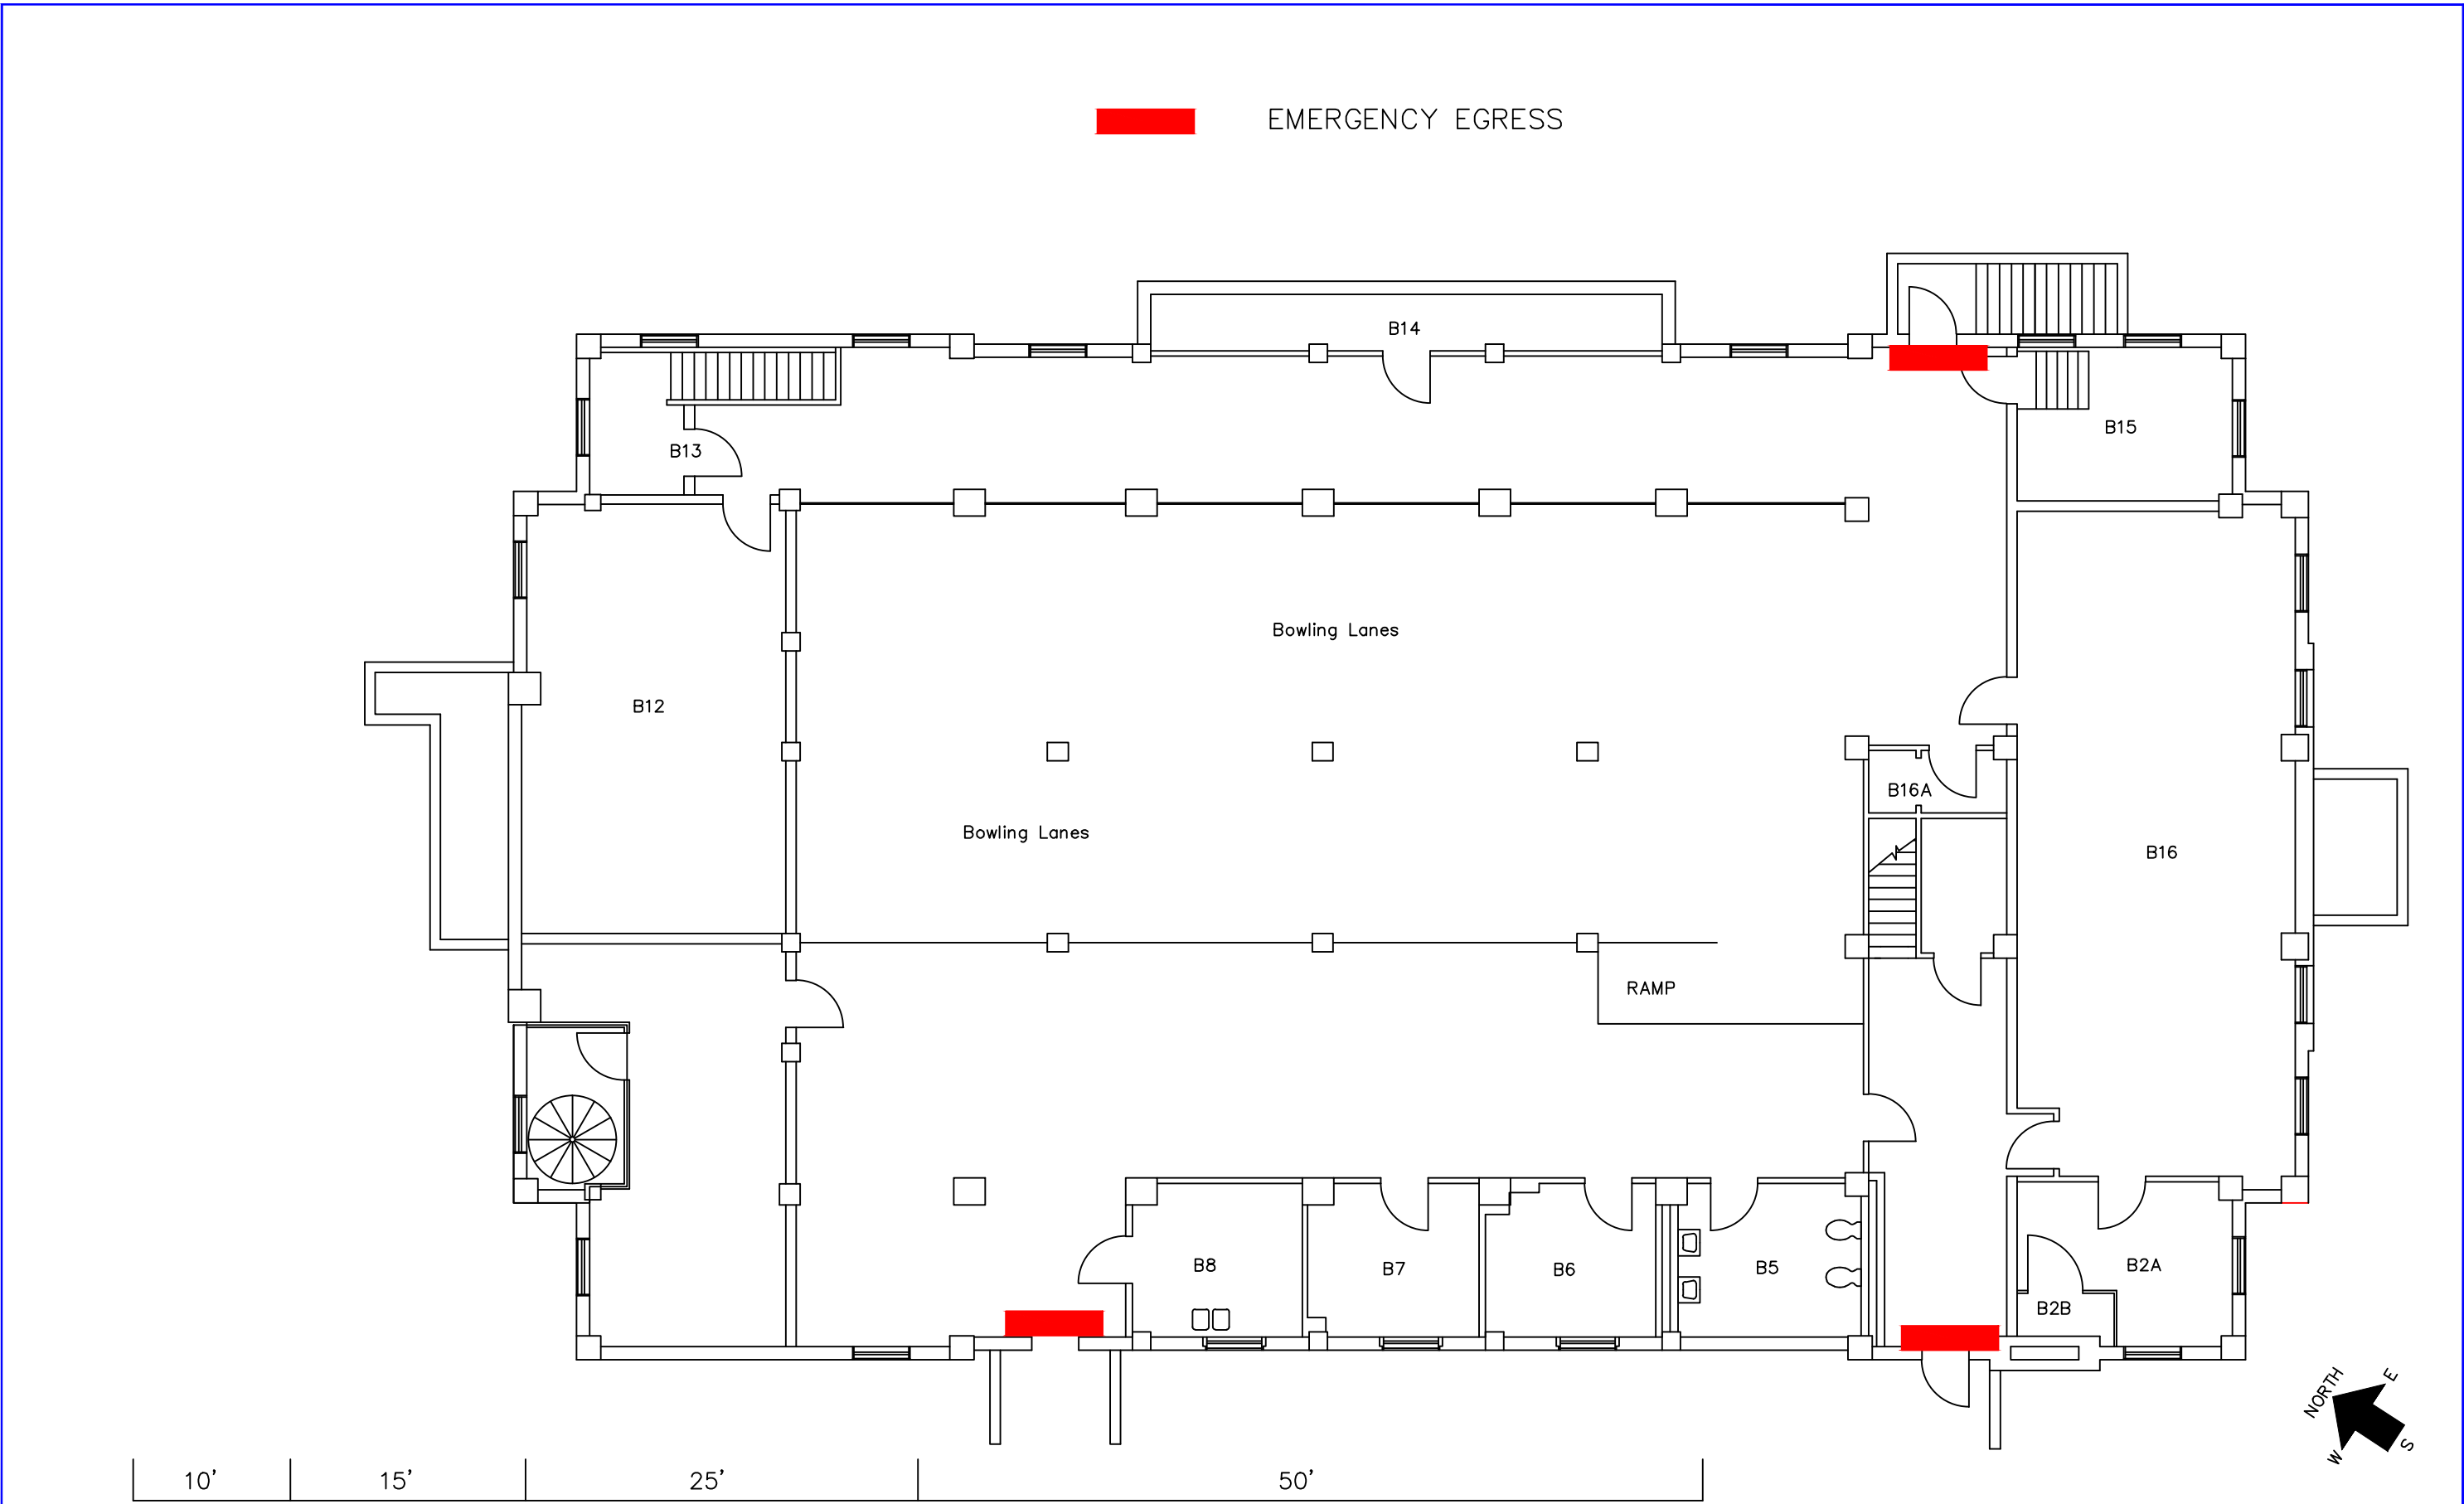

						Drawing Title		Project Title		Date 02/2014			VA Department of Veterans Affairs		
						BASEMENT		RECREATION HALL		Project No.					
						Approved: Project Manager		Drawing No.		Checked				Drawn GT	
						Approved: Service Chief		Location VAMC, NORTHAMPTON MASS.		Building Number 11					
Revisions		Date		Professional Seal											