

A

B

C

D

E

F

A


B

C

D

E

F

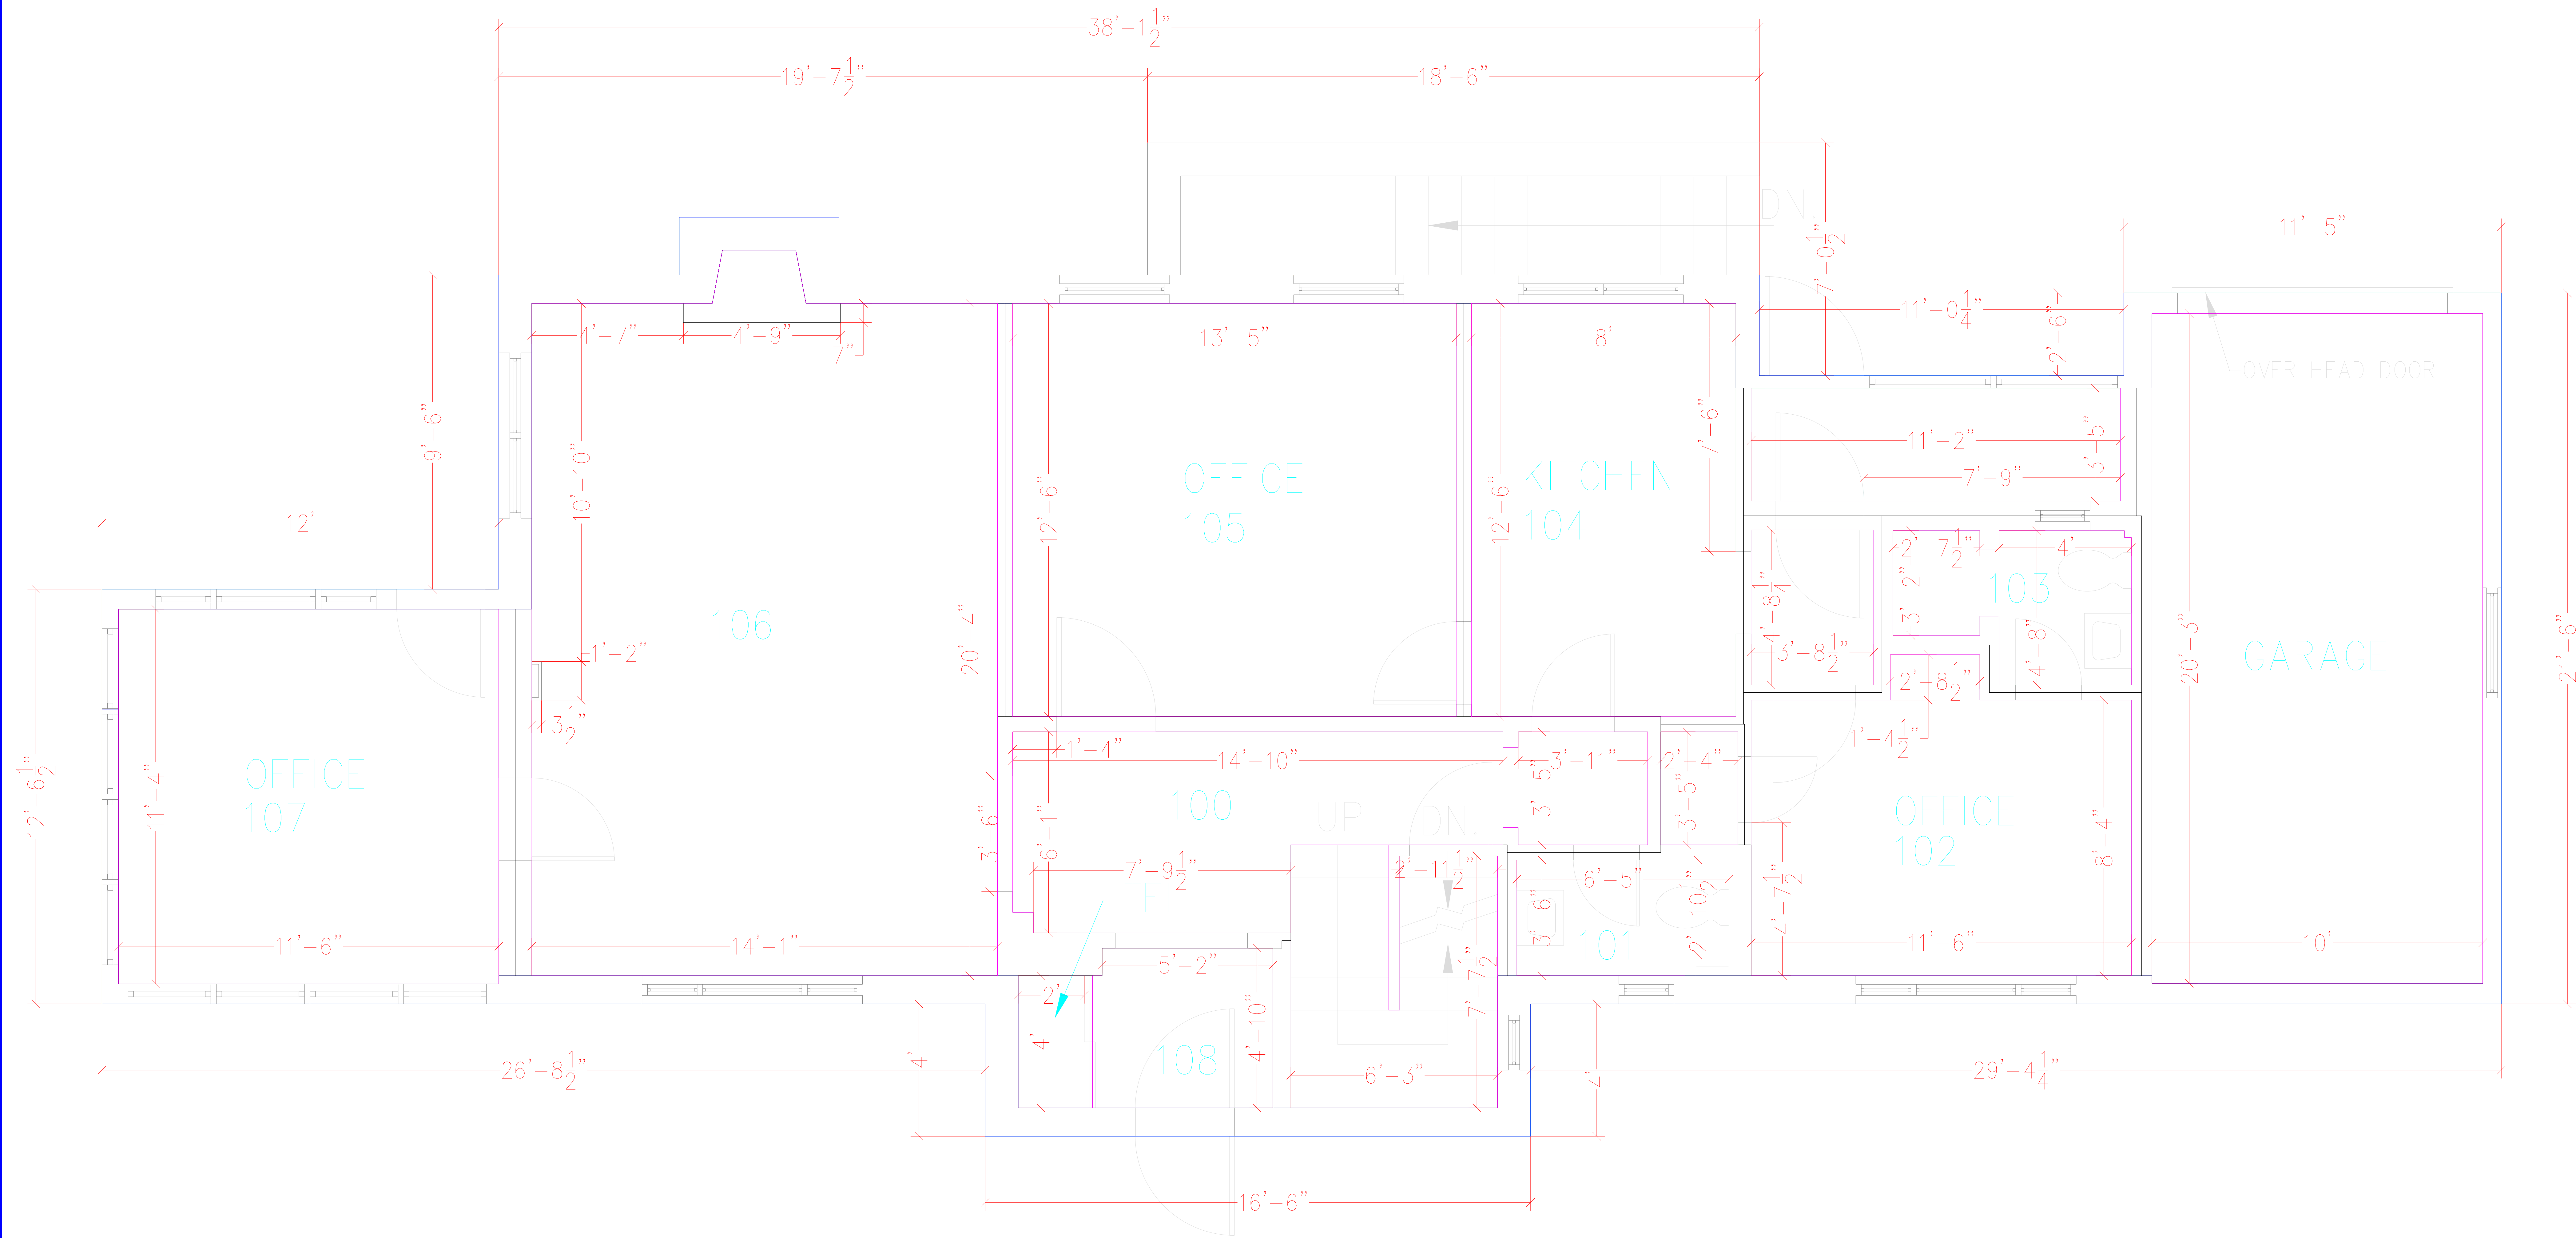

				<div><div><div>i</div></div><div>Indus Systems, Inc. 2352, Main Street, Concord MA 01742 Tel: 978-461-0555 www.indus-systems.com</div></div>	Drawing Title FIRST FLOOR PLAN ARCHITECTURAL		Project Title AS-BUILT Drawings			Date 10-15-2010		Project No.	Drawing No.	<div><div></div><div>VAMC, ERIE</div><div></div></div>	VA Department of Veterans Affairs
					Approved:		Building Number 02		Checked	Drawn	Location VAMC, ERIE PENNSYLVANIA				
Revisions		Date		Professional Seal		Approved:		Location VAMC, ERIE PENNSYLVANIA							