

A

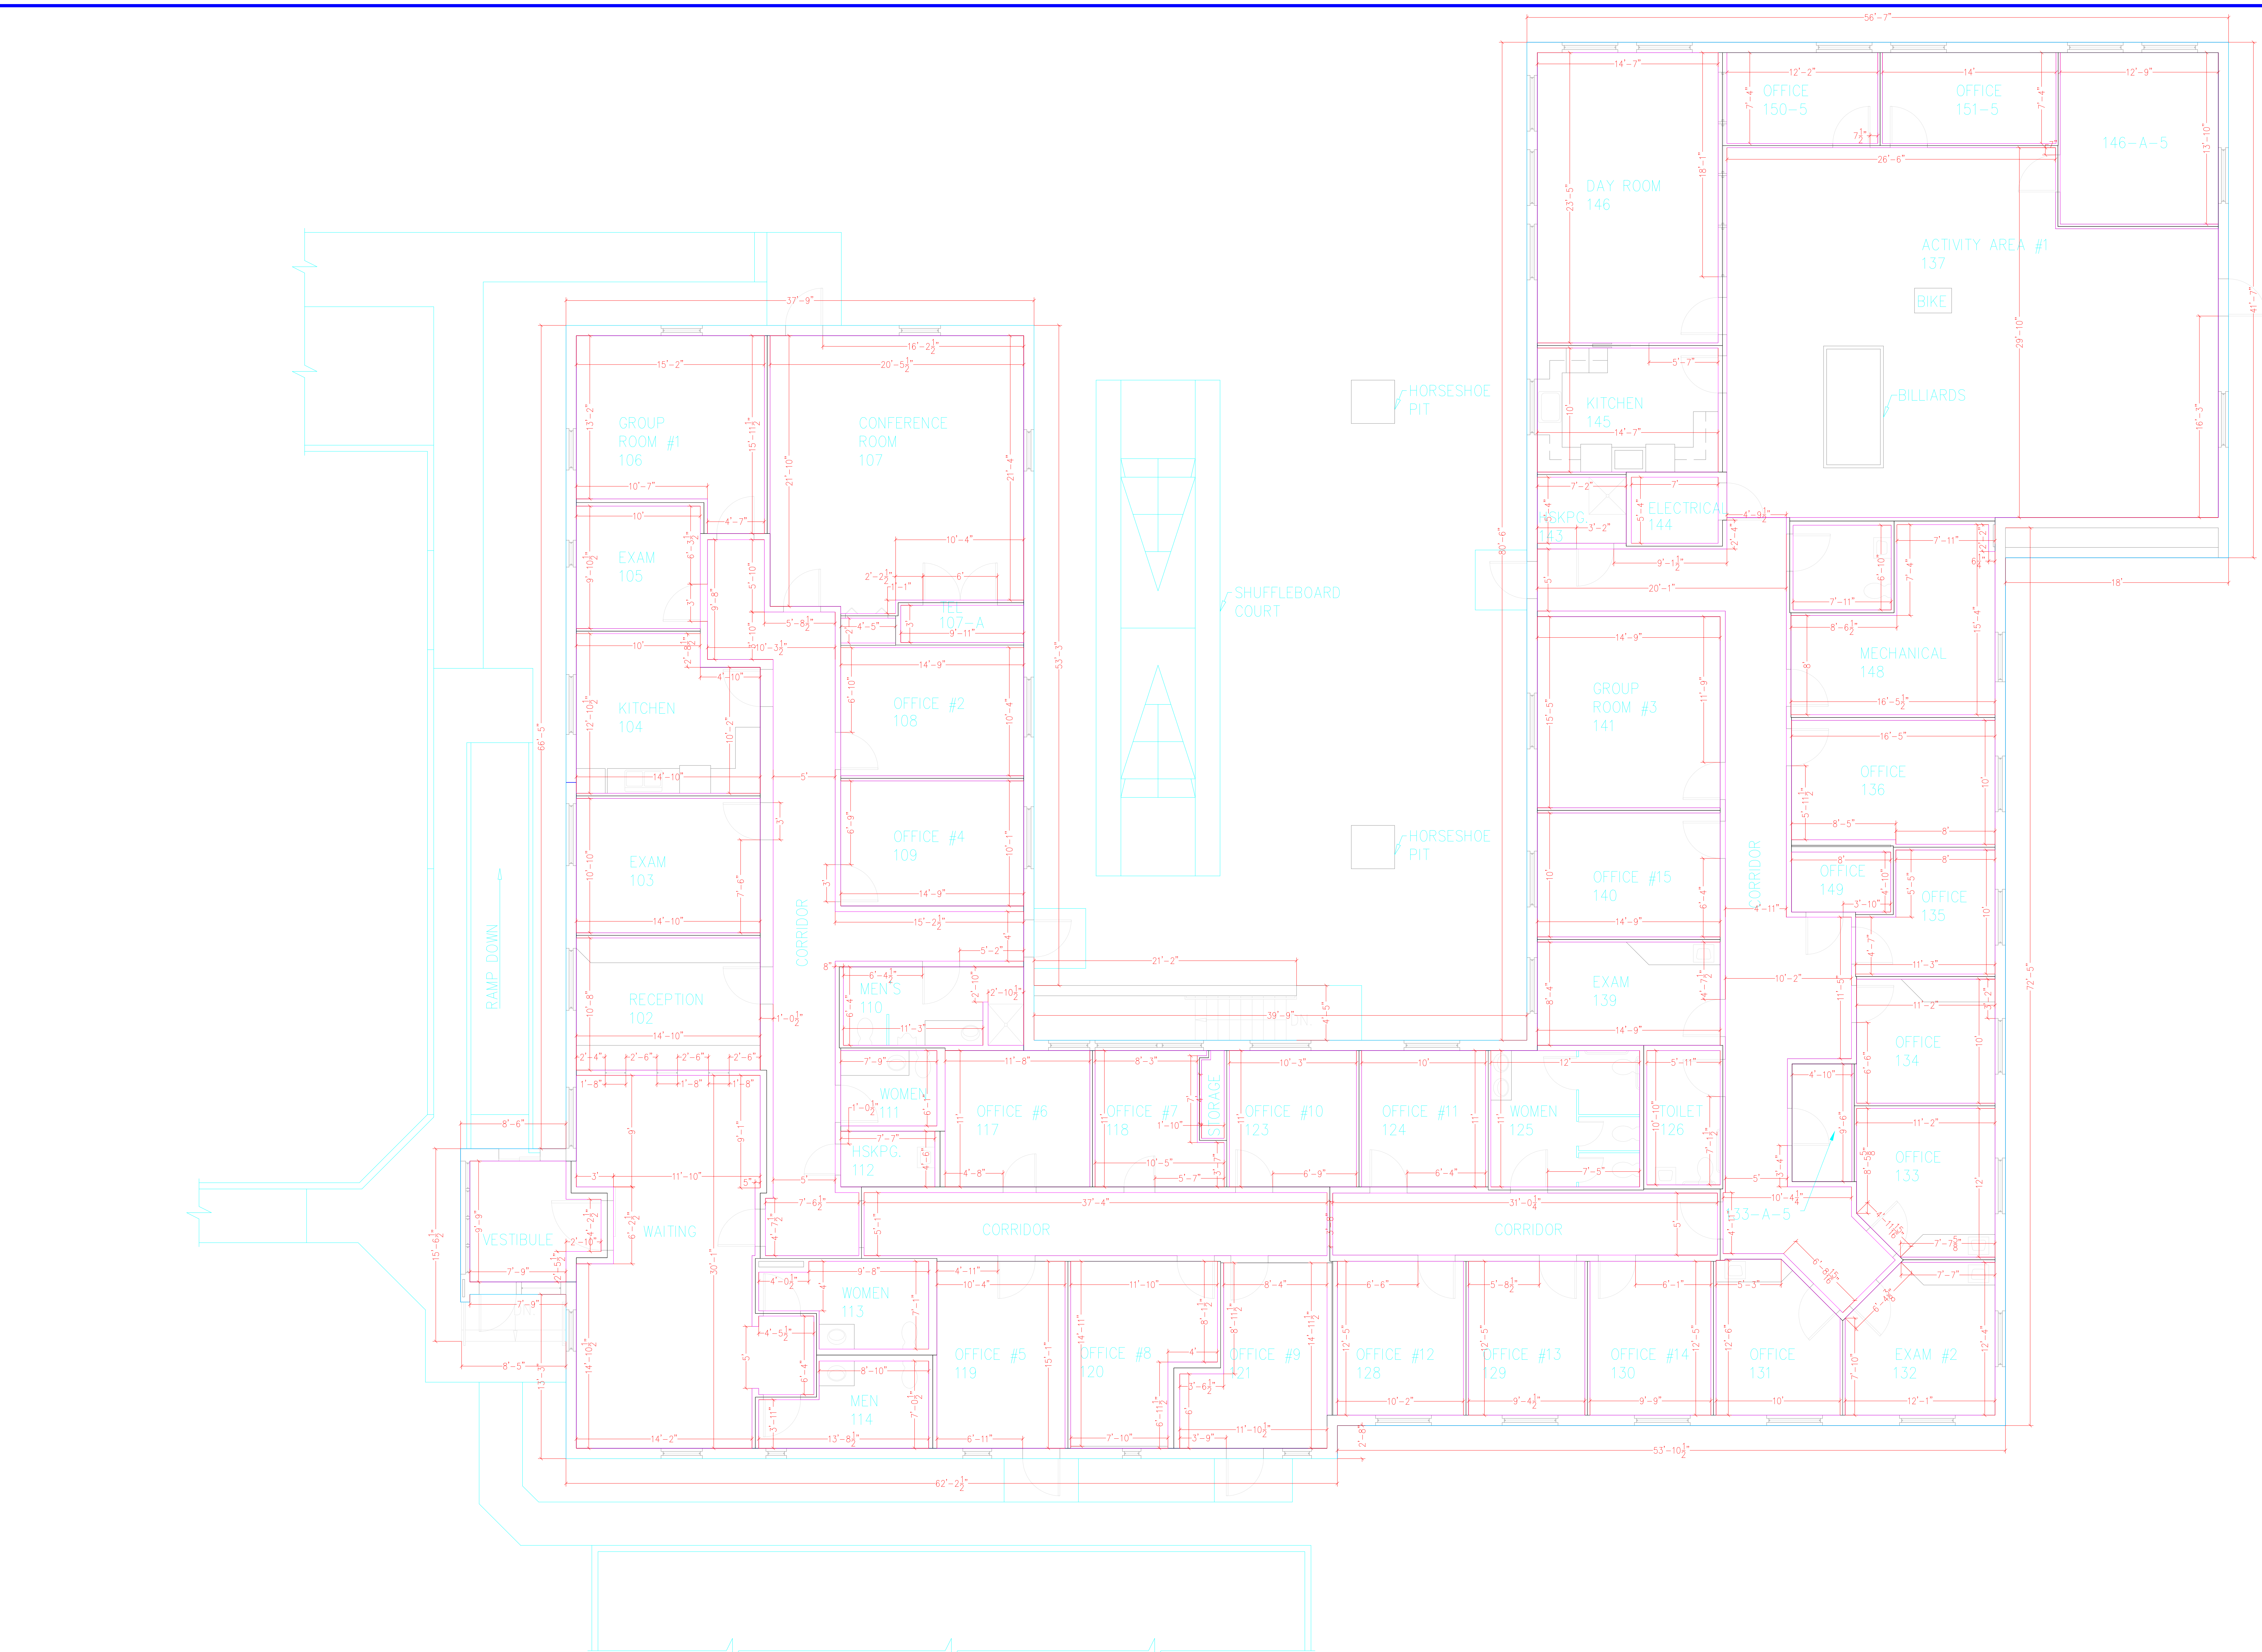
B

C

D

E

F



A

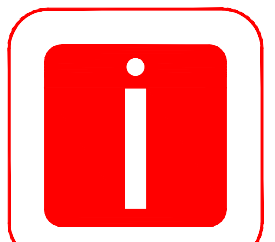
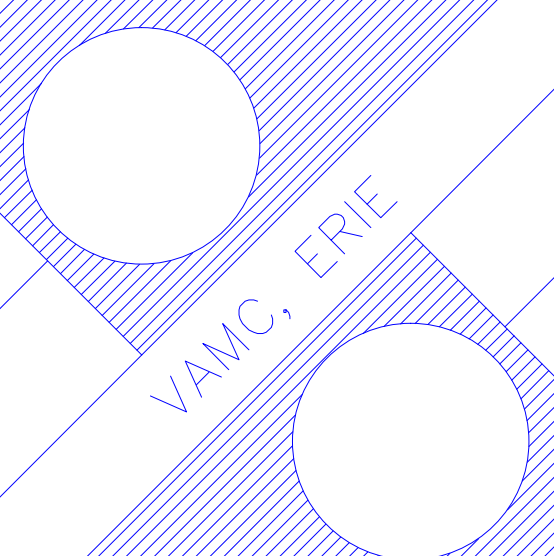
B

C

D

E

F

				 Indus Systems, Inc. 2352, Main Street, Concord MA 01742 Tel: 978-461-0555 www.indus-systems.com		Drawing Title FIRST FLOOR PLAN ARCHITECTURAL		Project Title AS-BUILT Drawings		Date 10-15-2010				VA Department of Veterans Affairs					
						Approved:		Building Number 05		Checked						Drawn		Project No.	
						Approved:		Location VAMC, ERIE PENNSYLVANIA										Drawing No.	
Revisions		Date		Professional Seal															

1

2

3

4

5

6

7

8

9