

A

B

C

D

E

F

A

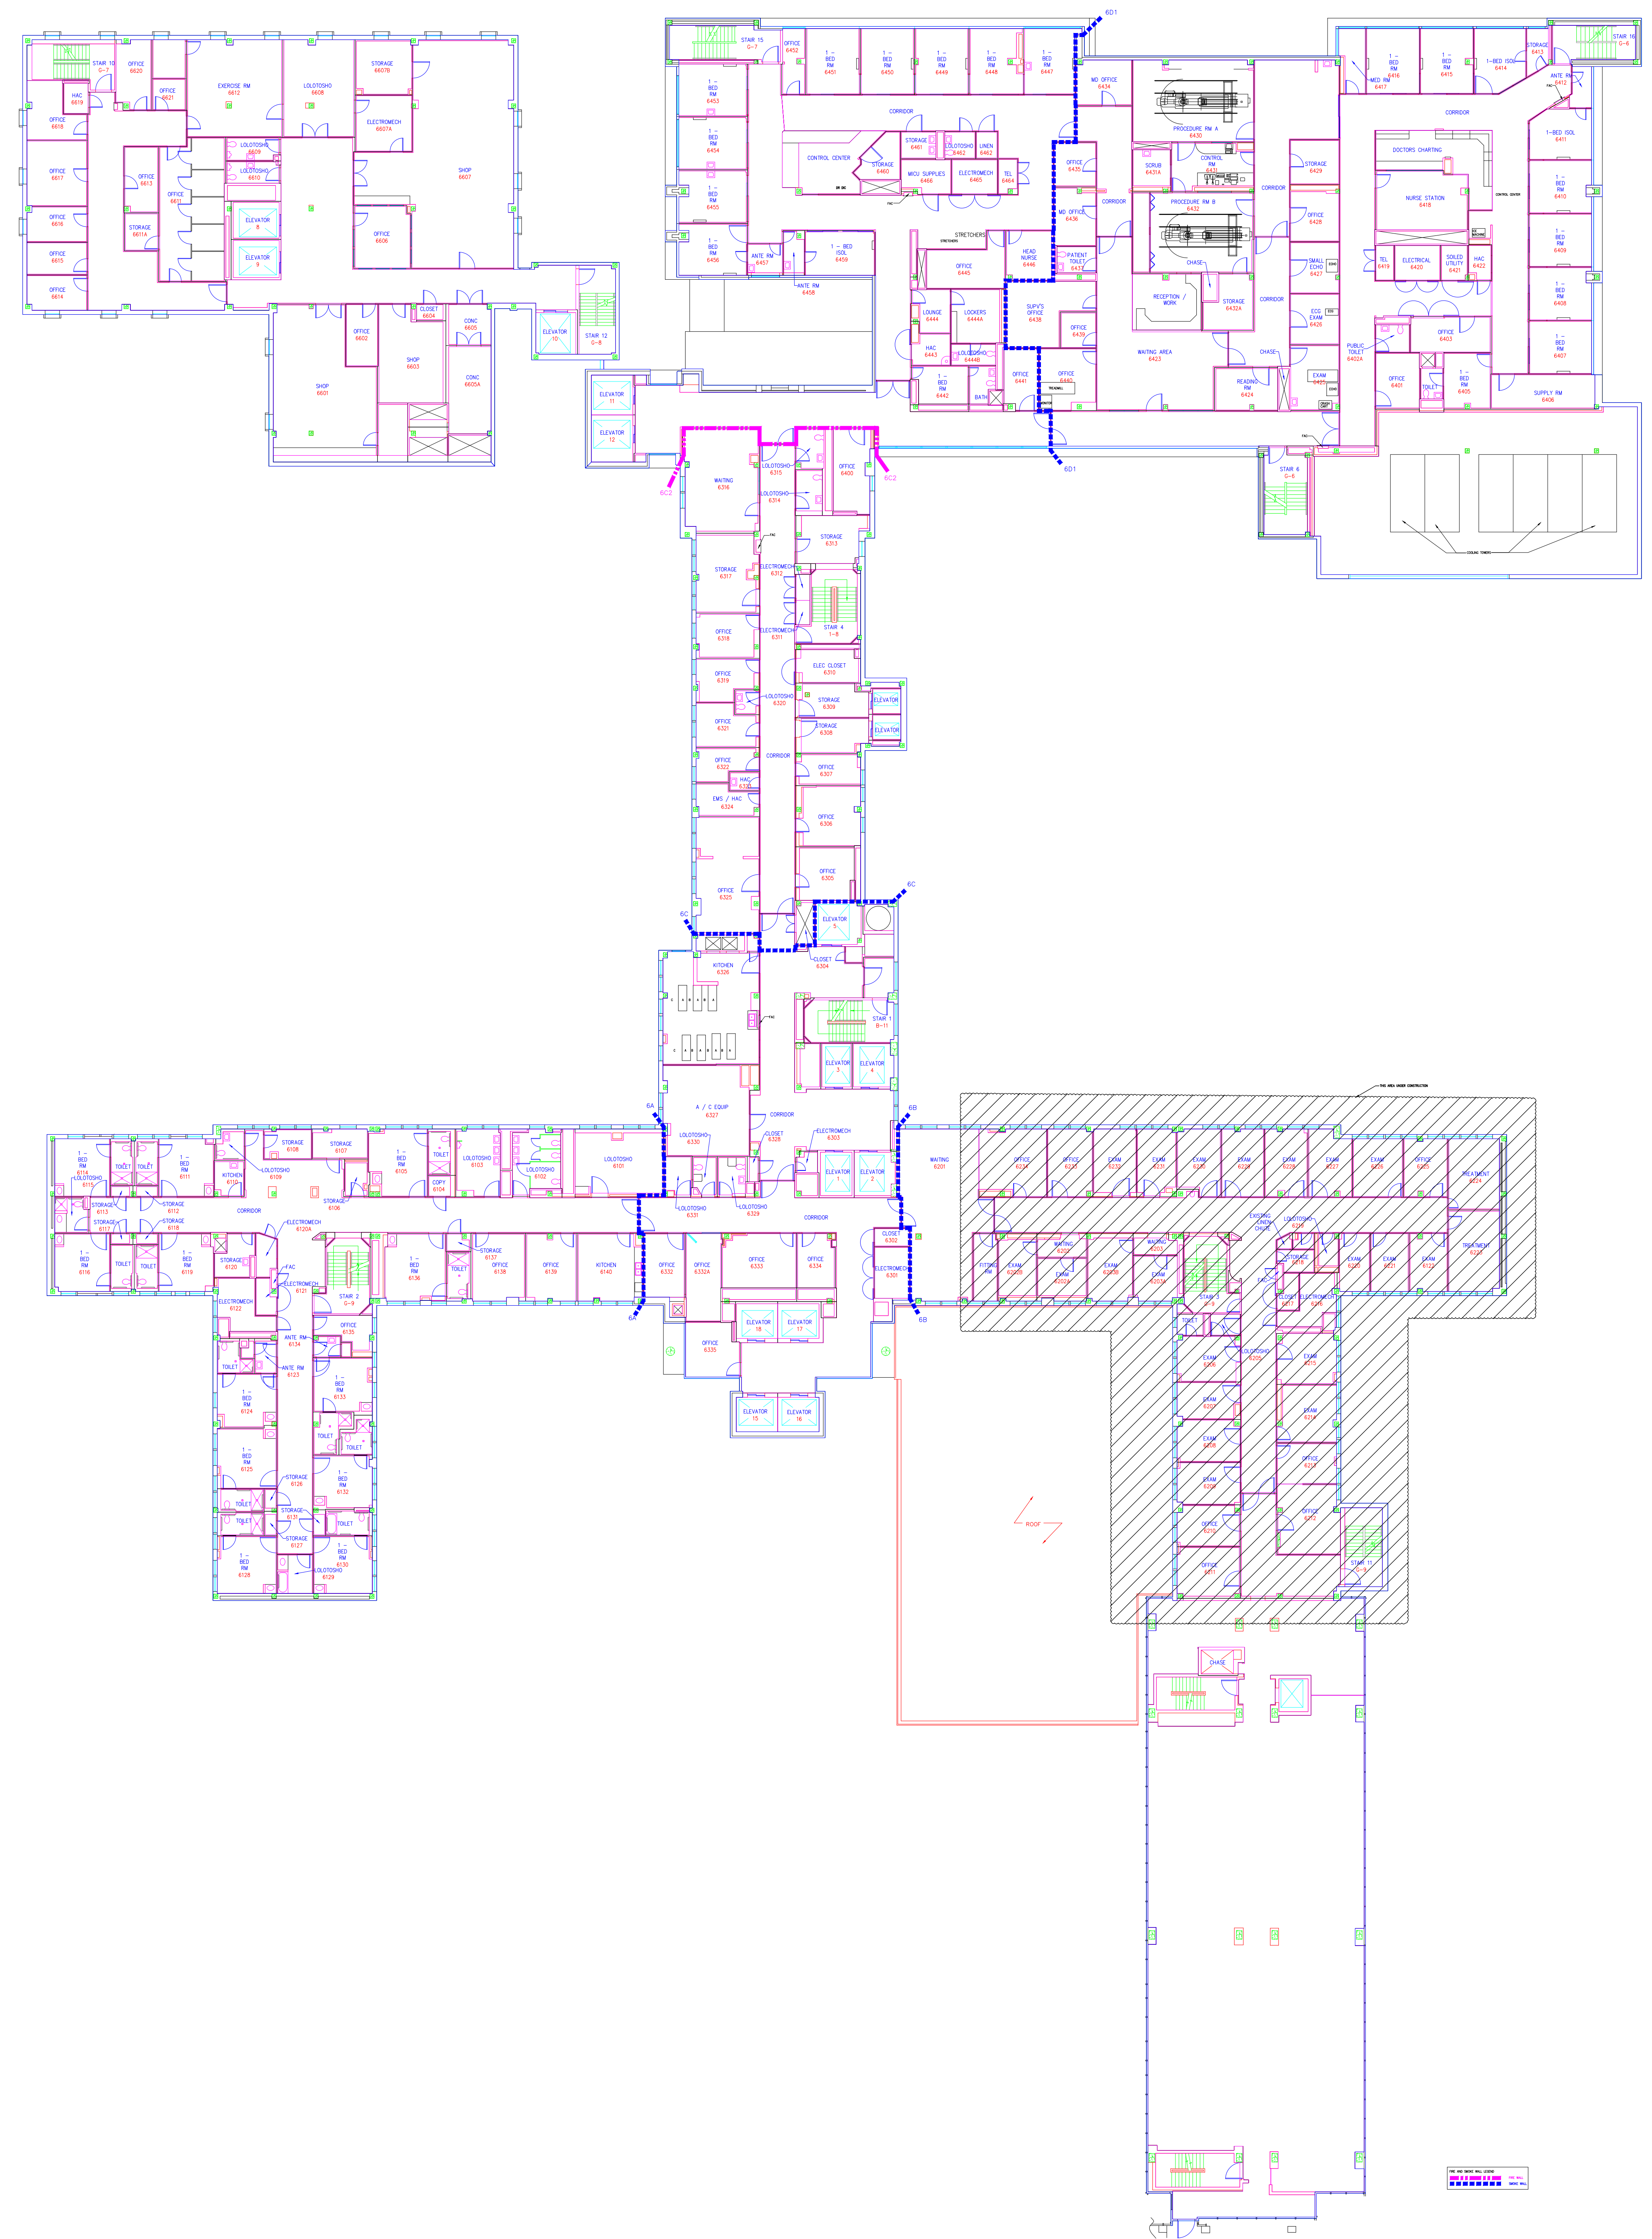
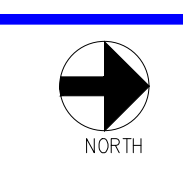
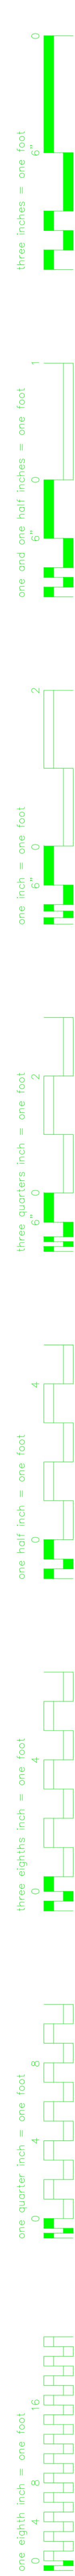
B

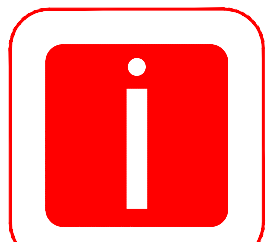

C

D

E

F



				 <b>Indus Systems, Inc.</b> 2352, Main Street, Concord MA 01742 Tel: 978-461-0555 www.indus-systems.com		Drawing Title SIXTH FLOOR PLAN ARCHITECTURAL		Project Title AS-BUILT Drawings		Date 11-18-2010				Department of Veterans Affairs					
Revisions		Date		Professional Seal		Approved:		Building Number 01		Checked						Drawn		Project No.	
						Approved:		Location VAMC BIRMINGHAM										Drawing No.	