


 
1. REFER TO SPECIFICATION SECTION 010000 FOR REQUIREMENTS REGARDING PRE-CONSTRUCTION INVESTIGATION PRIOR TO COMMENCEMENT OF WORK.
2. REFER TO SPECIFICATION SECTION 283100 FOR REQUIREMENTS REGARDING FIRE ALARM INSTALLATION WORK.

KEYED NOTES


- 1 INSTALL NEW FIRE ALARM PANEL AND COMMAND CENTER CENTRAL TERMINAL IN THIS LOCATION. PROVIDE UPS POWER AND REQUIRED COMMUNICATIONS TO NEW FIRE ALARM PANELS IN BUILDINGS #1, #3 AND #14.

LEGEND

AREA APPLIED TO THIS PORTION OF PROJECT

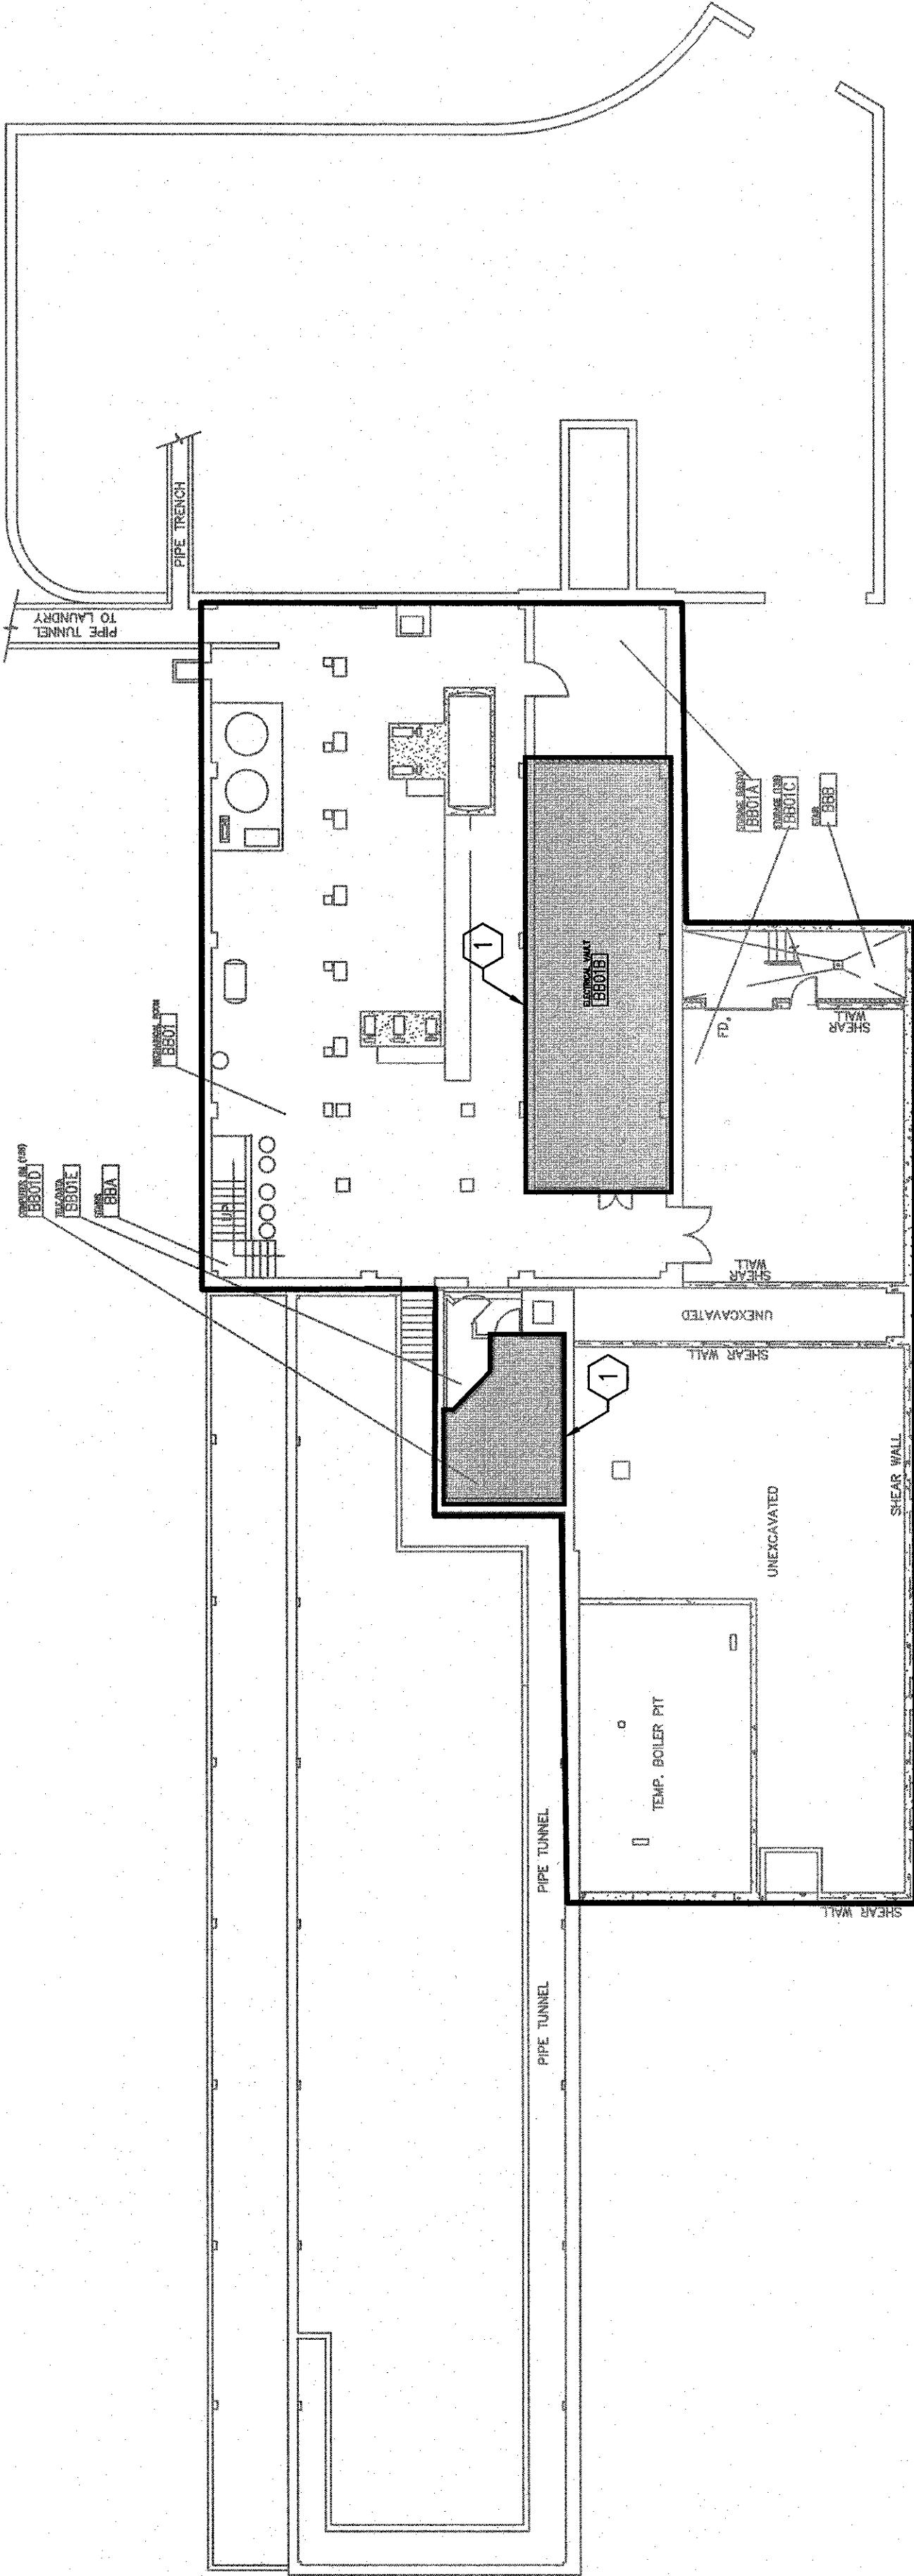

E3 **FLOOR PLAN**
1/16" = 1'-0"

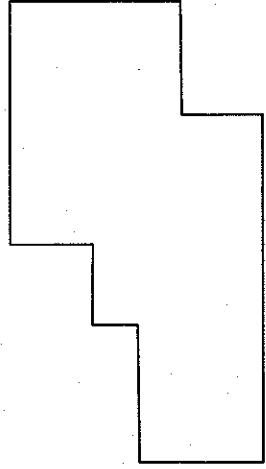

 KEY PLAN - NOT TO SCALE

**FULLY SPRINKLERED
BID DOCUMENTS
FOR CONSTRUCTION**

[illegible]