

 
NOTES

1. REFER TO SPECIFICATION SECTION 010000 FOR REQUIREMENTS REGARDING PRE-CONSTRUCTION INVESTIGATION PRIOR TO COMMENCEMENT OF WORK. CONTRACTOR TO CONDUCT A COMPLETE SURVEY OF EVERY FIRE PROTECTION SPRINKLER HEAD TO ASSESS EACH HEAD'S AGE, CONDITION, AND VIABILITY.
2. UPON COMPLETION OF THE ABOVE SURVEY, THE VAMC COR SHALL DESIGNATE THIS TO 240 HEADS TO BE REPLACED/REWORKED BY THE CONTRACTOR UNDER THIS CONTRACT.
3. THE 240 HEADS DESIGNATED BY THE VAMC COR LISTED ABOVE ARE IN ADDITION TO ANY SPECIFIC ITEMS INDICATED ON THIS SHEET.


KEYED NOTES

- 1 REWORK EXISTING SPRINKLER HEADS AND PIPING PER CODE IN ROOMS 2A17D, 2B01C, AND 2C18C.


LEGEND



AREA APPLIED TO THIS PORTION OF PROJECT

 


THIS AREA IS WITHIN AN ONGOING PROJECT THAT INCLUDES FIRE PROTECTION UPGRADE.

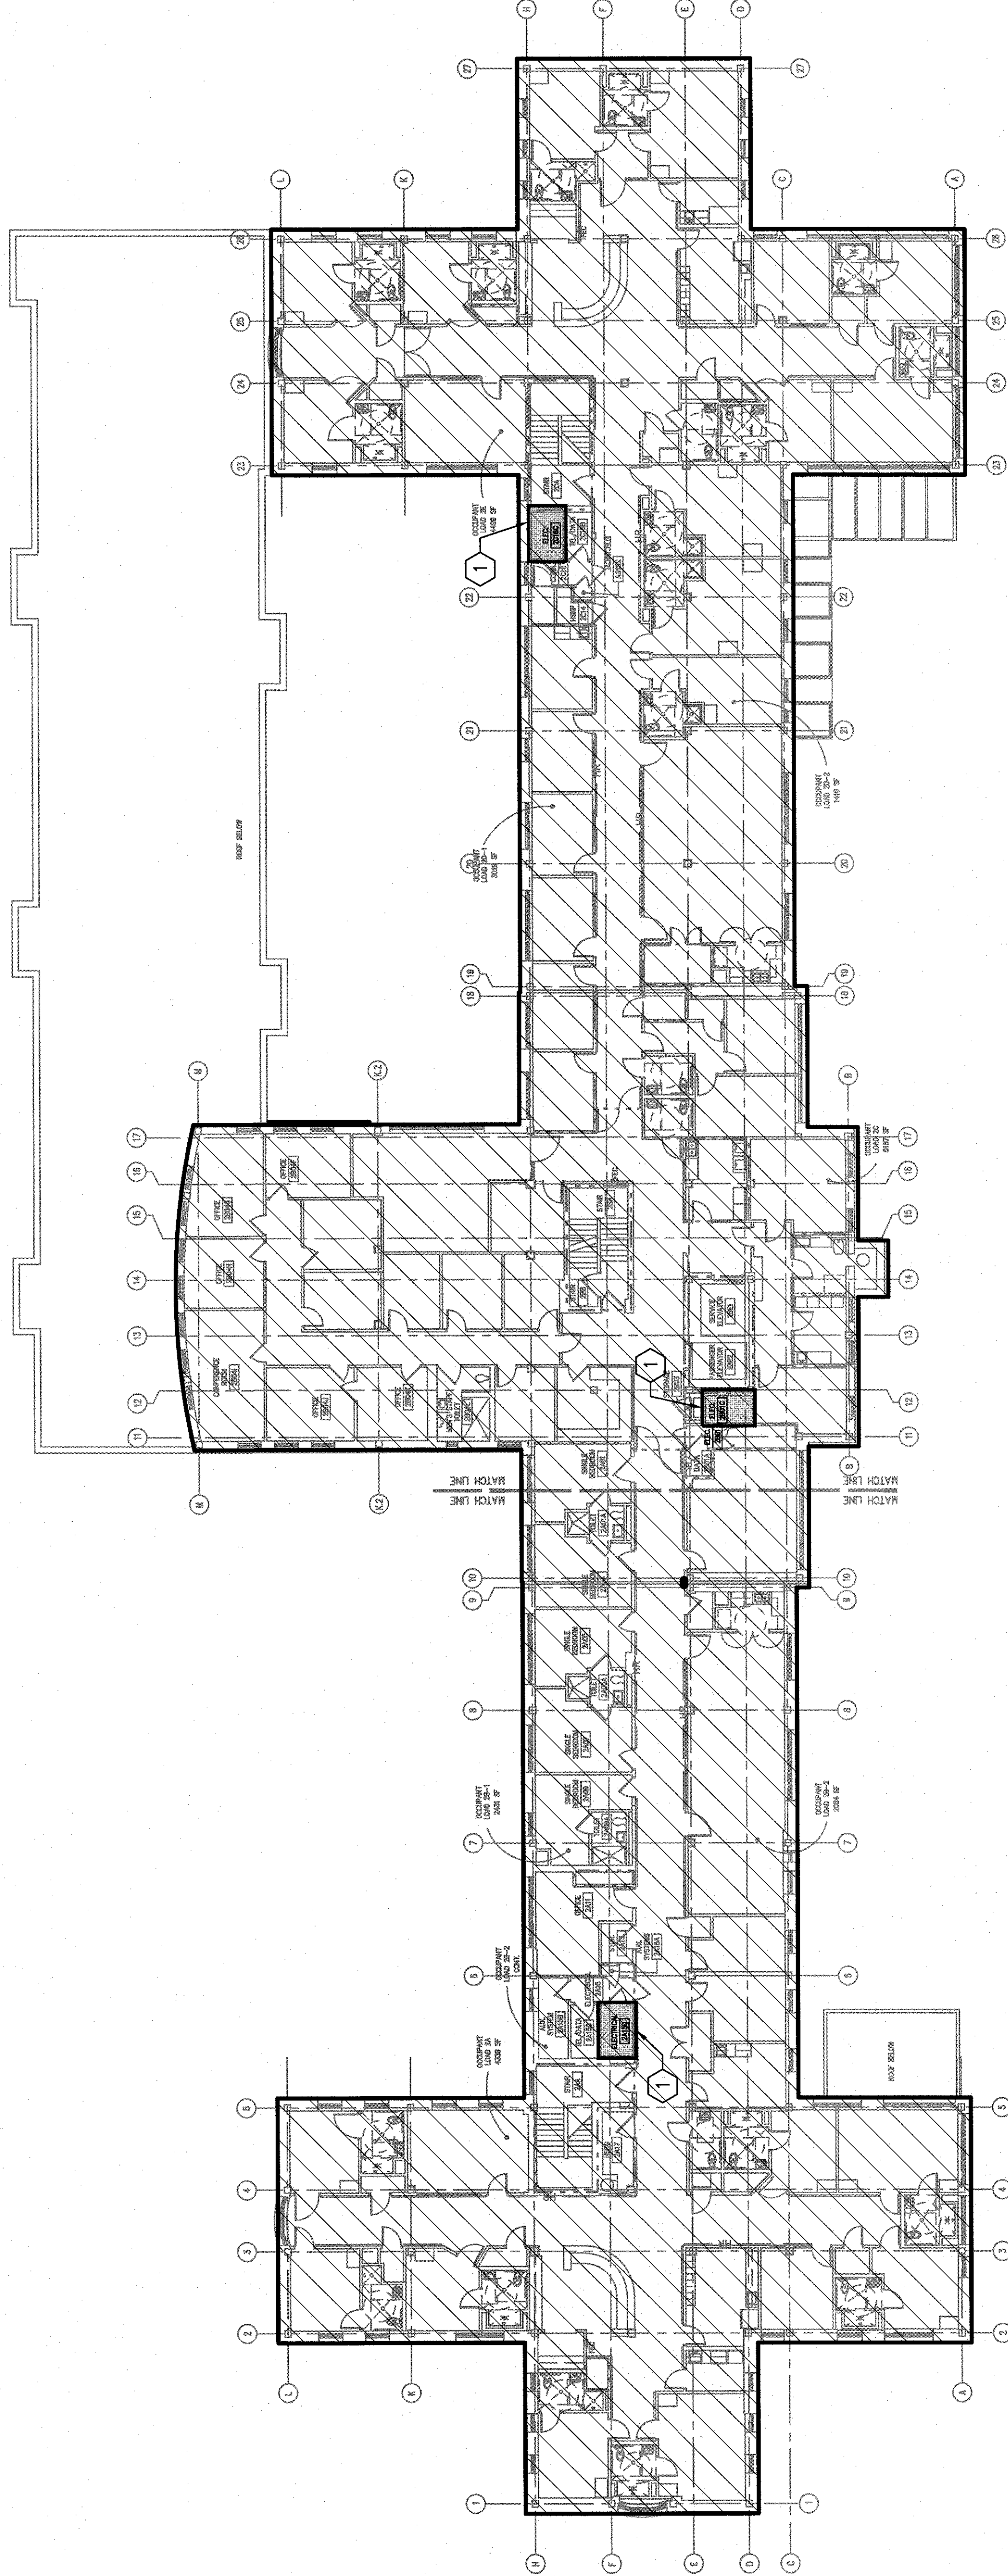

E1 **FLOOR PLAN** $1/16" = 1'-0"$

GENERAL NOTE:
ALL EXISTING PIPING, DUCTWORK, SPRINKLERS, CONDUIT, LIGHTING OR OTHER CONSTRUCTION SHALL BE RELOCATED AS NECESSARY FOR ALL DEMOLITION AND INSTALLATION WORK.

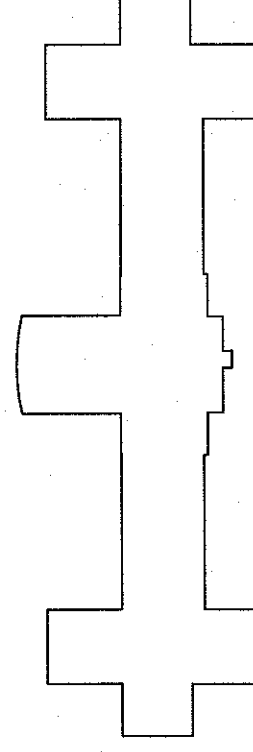

KEY PLAN - NOT TO SCALE

**FULLY SPRINKLERED
BID DOCUMENTS
FOR CONSTRUCTION**

[illegible]