



JAMES H. QUILLEN
VA MEDICAL CENTER
BUILDING 204
MOUNTAIN HOME, TN 37684

INDEX OF DRAWINGS	
GENERAL	
G001	COVER SHEET, SHEET INDEX
ARCHITECTURAL	
A101	ARCHITECTURAL DEMOLITION PLAN
A102	ARCHITECTURAL RENOVATION PLAN - PHASING PLAN
A103	ARCHITECTURAL REFLECTED CEILING PLAN
A501	WALL SECTIONS
ELECTRICAL	
EL101	ELECTRICAL LIGHTING PLAN
EP101	ELECTRICAL POWER PLAN
E501	ELECTRICAL DETAILS
PLUMBING	
P101	PLUMBING PLAN
HEATING, VENTILATING, AIR CONDITIONING AND REFRIGERATION	
H101	HVAC PLAN
INTERIOR	
IN101	INTERIOR DESIGN
IN102	INTERIOR ELEVATIONS AND ENLARGED DETAILS
EXISTING FACILITY DRAWINGS (FOR REFERENCE ONLY)	
204-E4	GROUND FLOOR PLAN LIGHTING
204-E5	GROUND FLOOR PLAN POWER
204-P6	PLUMBING GROUND FLOOR PLAN
204-H15	GROUND FLOOR PLAN HVAC DUCTWORK
204-H16	GROUND FLOOR PLAN HVAC PIPING


REVISIONS	BY
#	

BUILDING 204
RENOVATE AUDIOLOGY
COVER SHEET
1-17-14


PROJECT # 621-14 -136

RENOVATE AUDIOLOGY


Construction Documents

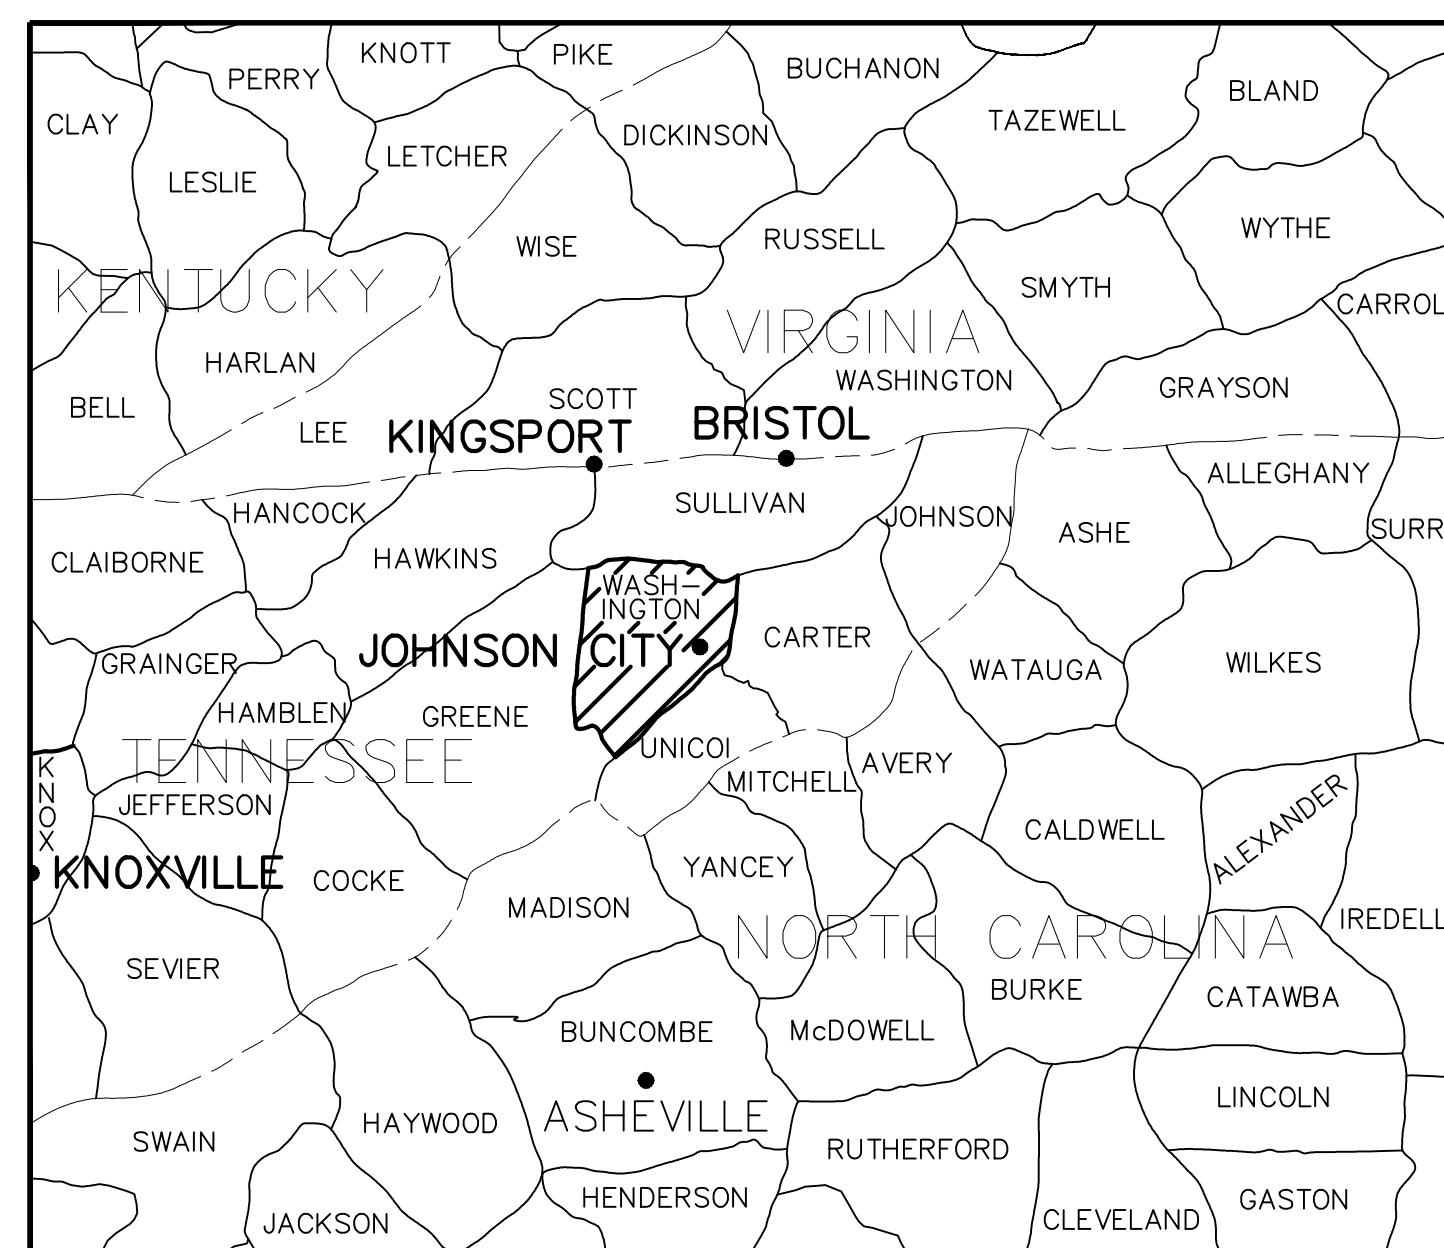

COUNTY LOCATION
NTS

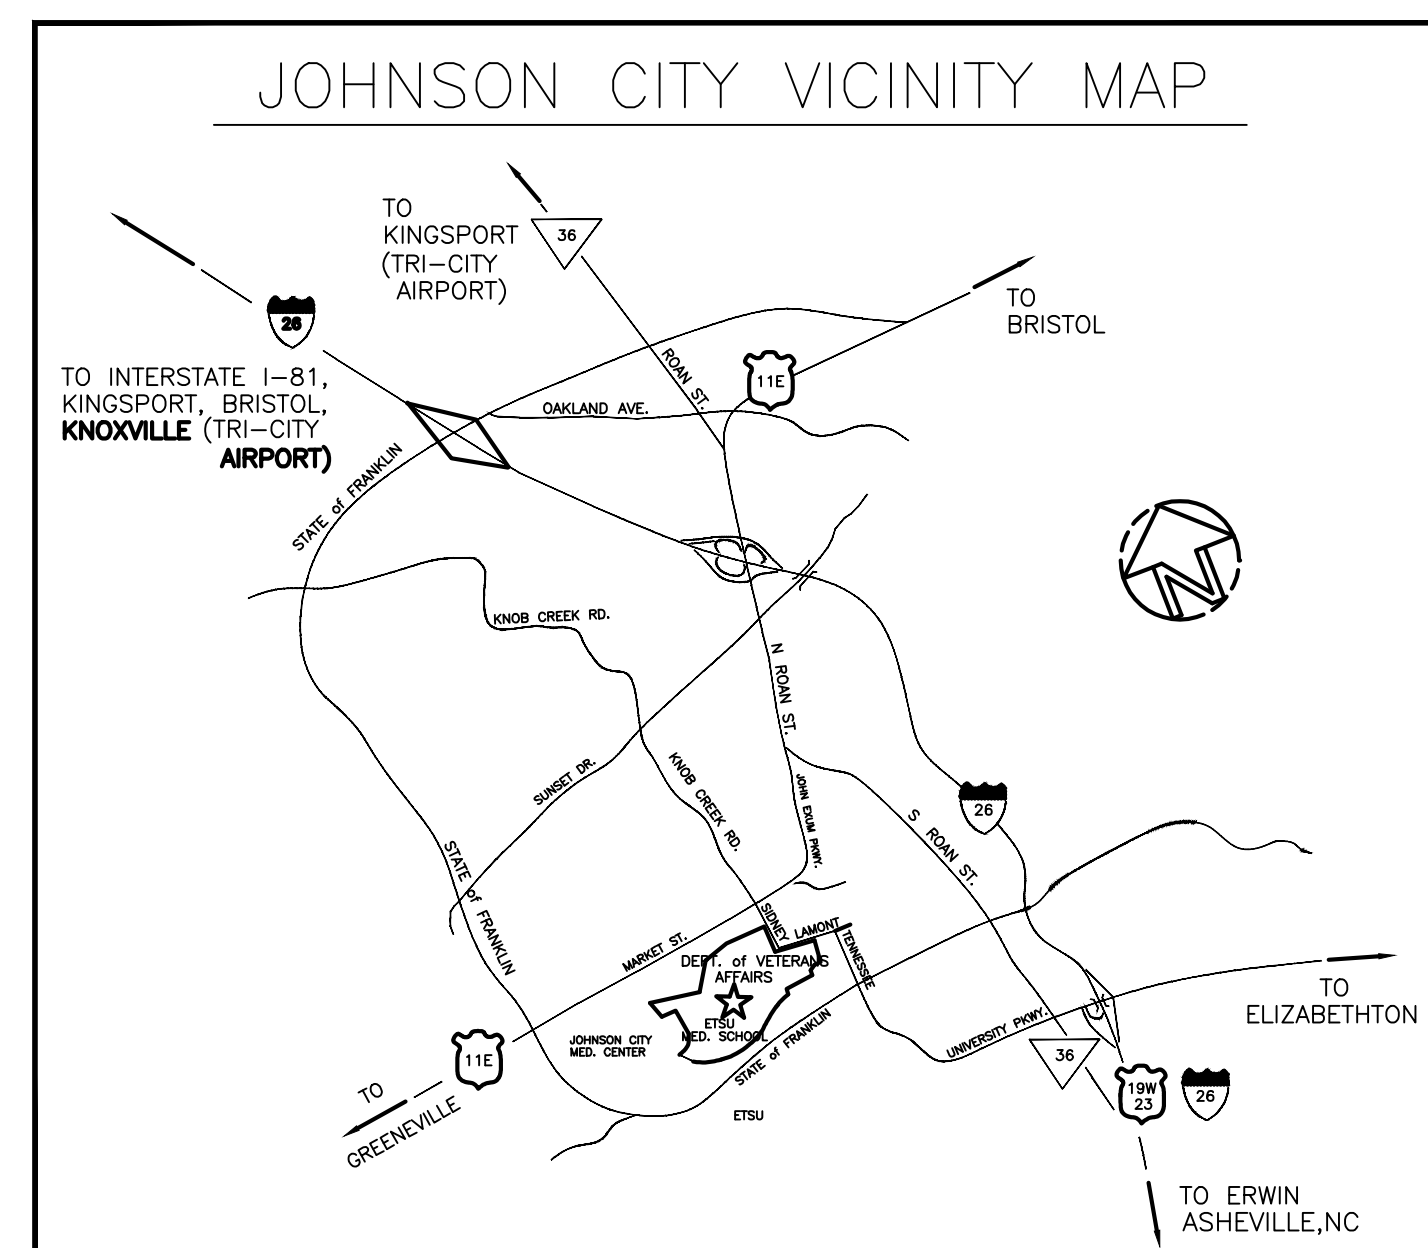

VICINITY MAP
NTS

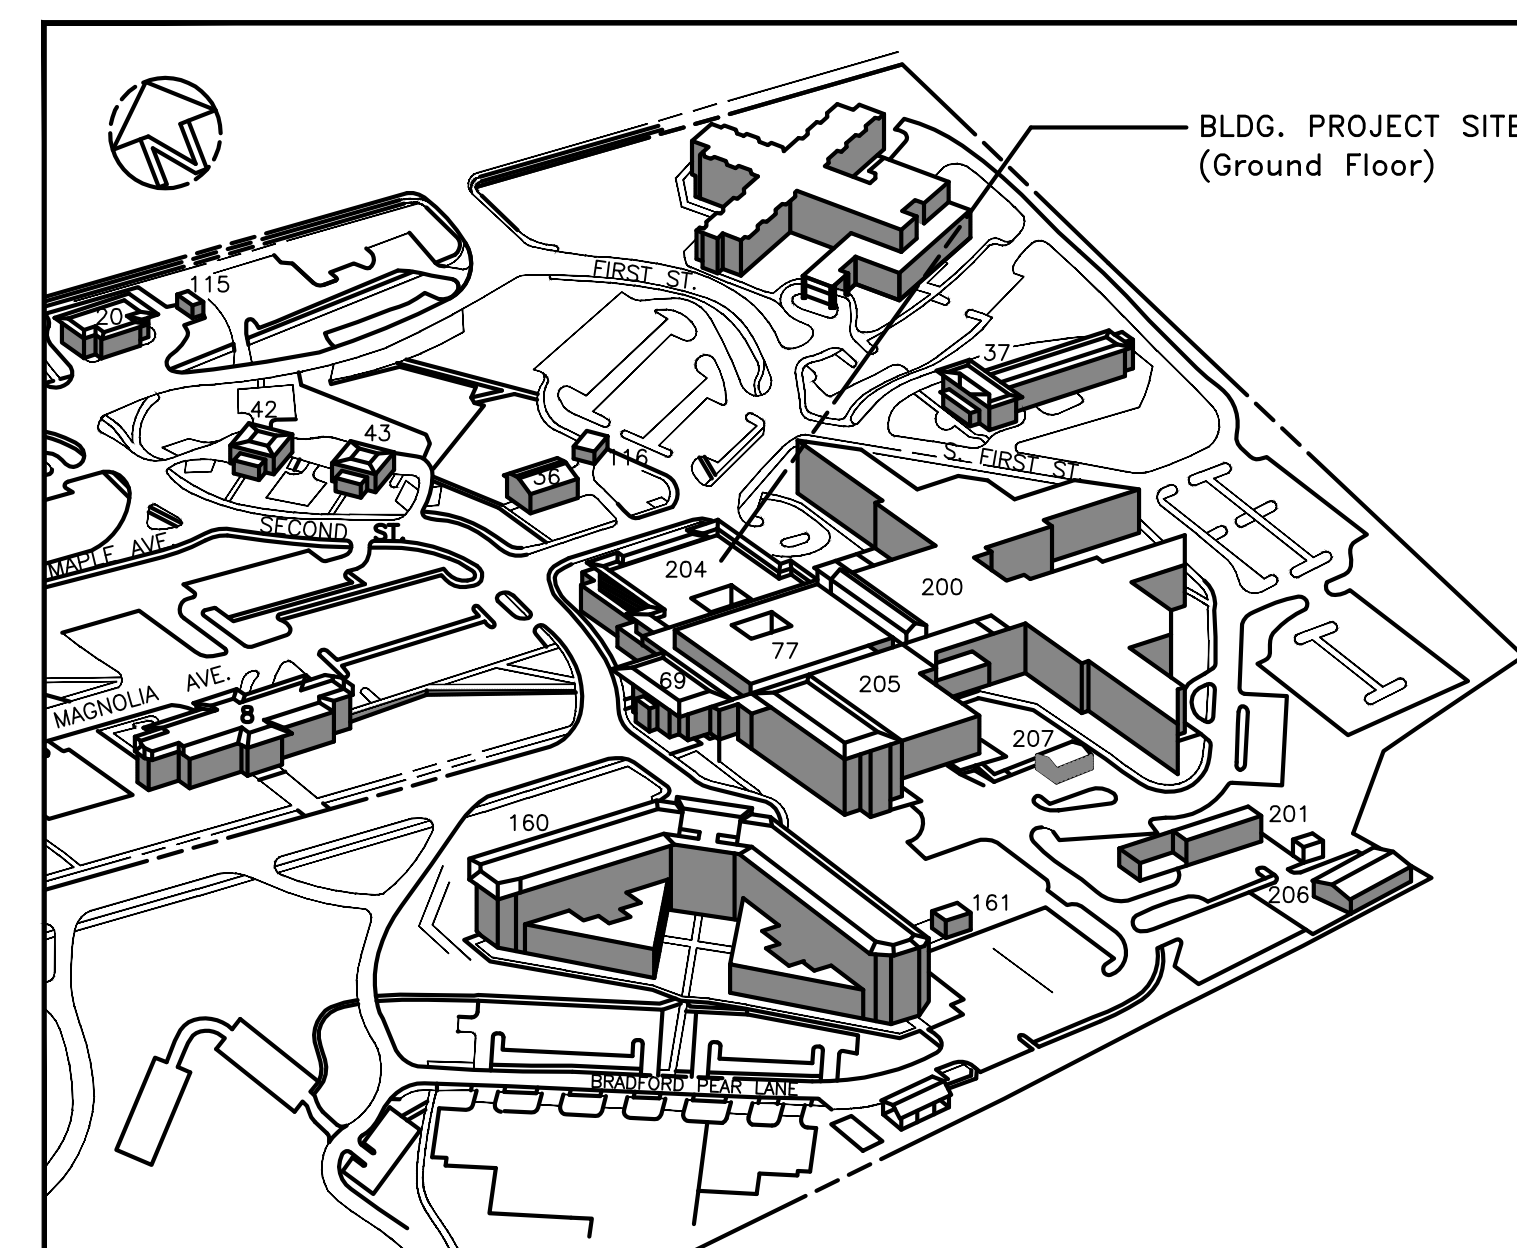

STATION MAP
NTS



DRAWN BY	PROJ. MGR
CLAWSON	PROSAK
ORIGINAL DATE	1-13-14
LAST REVISION	1-17-14
SCALE	1/8"=1'-0"
G001	