


2 Electrical Lighting Plan  
Scale: 1/2"=1'-0"

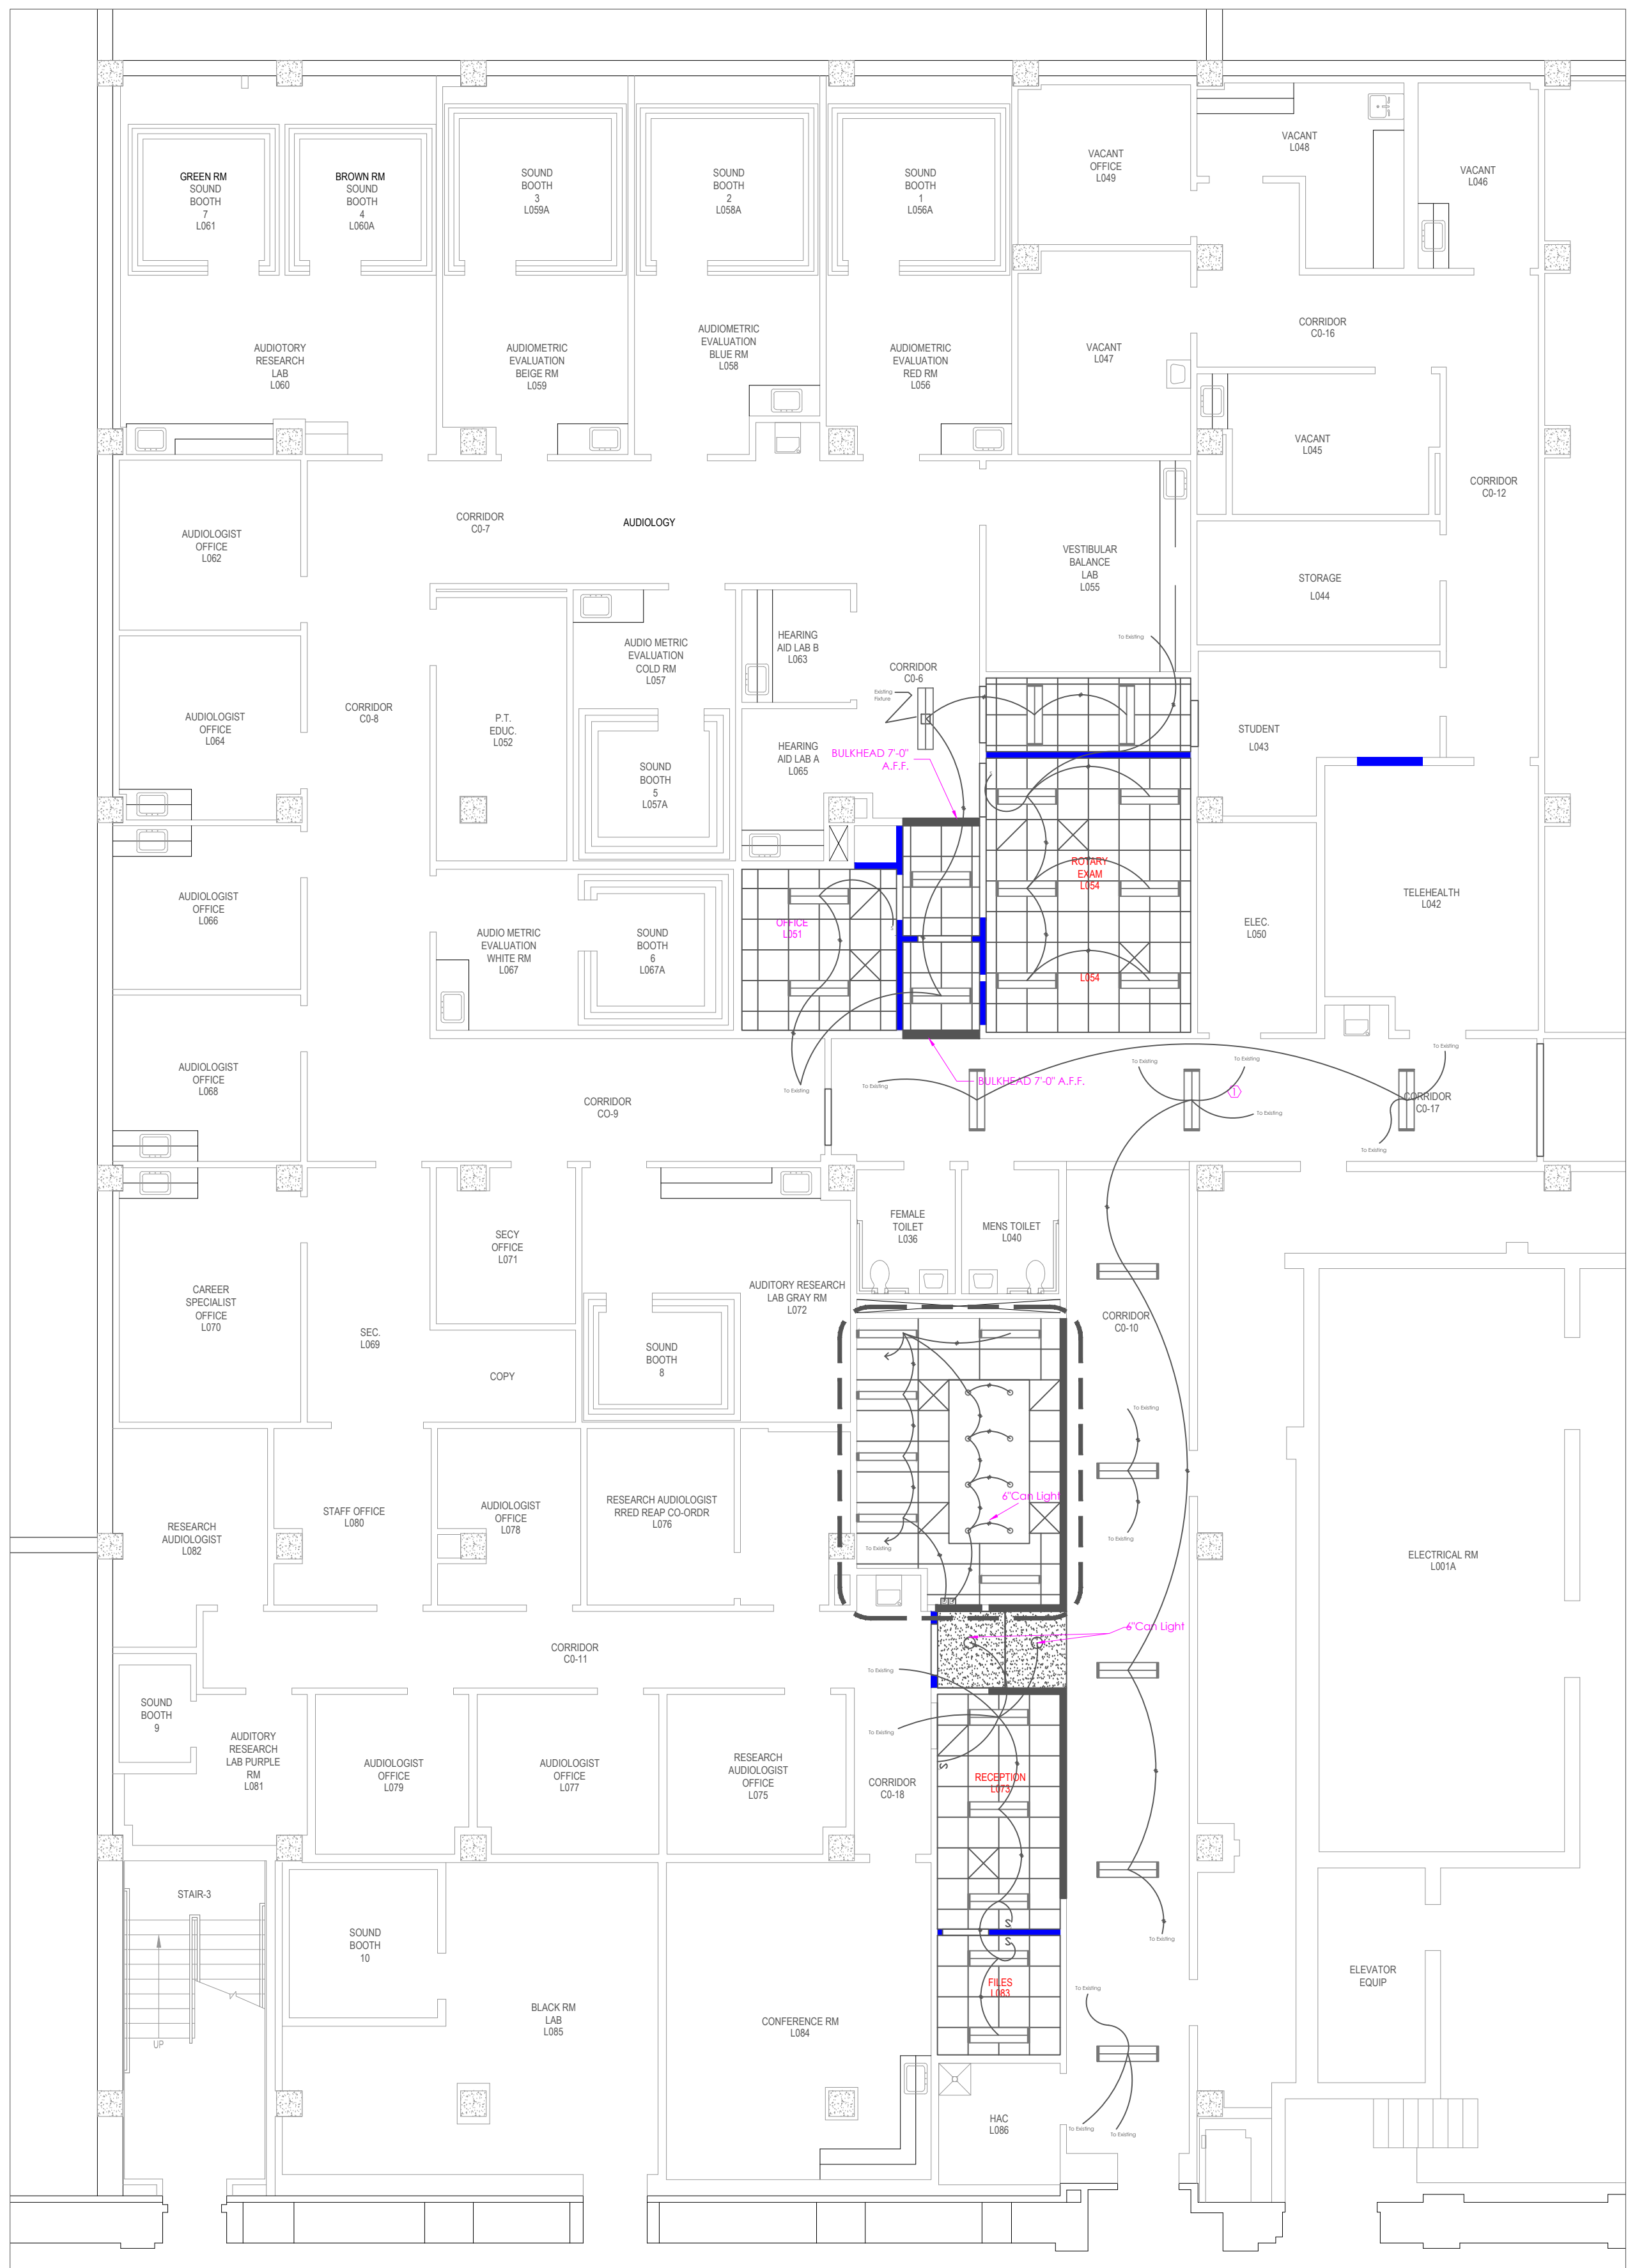

1 Electrical Lighting Plan  
Scale: 1/8"=1'-0"

#	REVISIONS	BY

BUILDING 204
ENHANCE AUDIOLOGY INTERIOR
ELECTRICAL – LIGHTING PLAN
3/10/14

JAMES H. QUILLEN  
VA MEDICAL CENTER



DRAWN BY	PROJ. MGR
CLAWSON	PROSAK
ORIGINAL DATE	3/7/14
LAST REVISION	3/10/14
SCALE	1/8"=1'-0"

EL-101