


three inches = one foot
one and one half inches = one foot
one inch = one foot
three quarters inch = one foot
one half inch = one foot
three eighths inch = one foot
one quarter inch = one foot
one eighth inch = one foot
one eighth inch = one foot

HILLIARD ARCHITECTS INC. COPYRIGHT

1 FIRST FLOOR REFLECTED CEILING PLAN
3/16" = 1'-0"

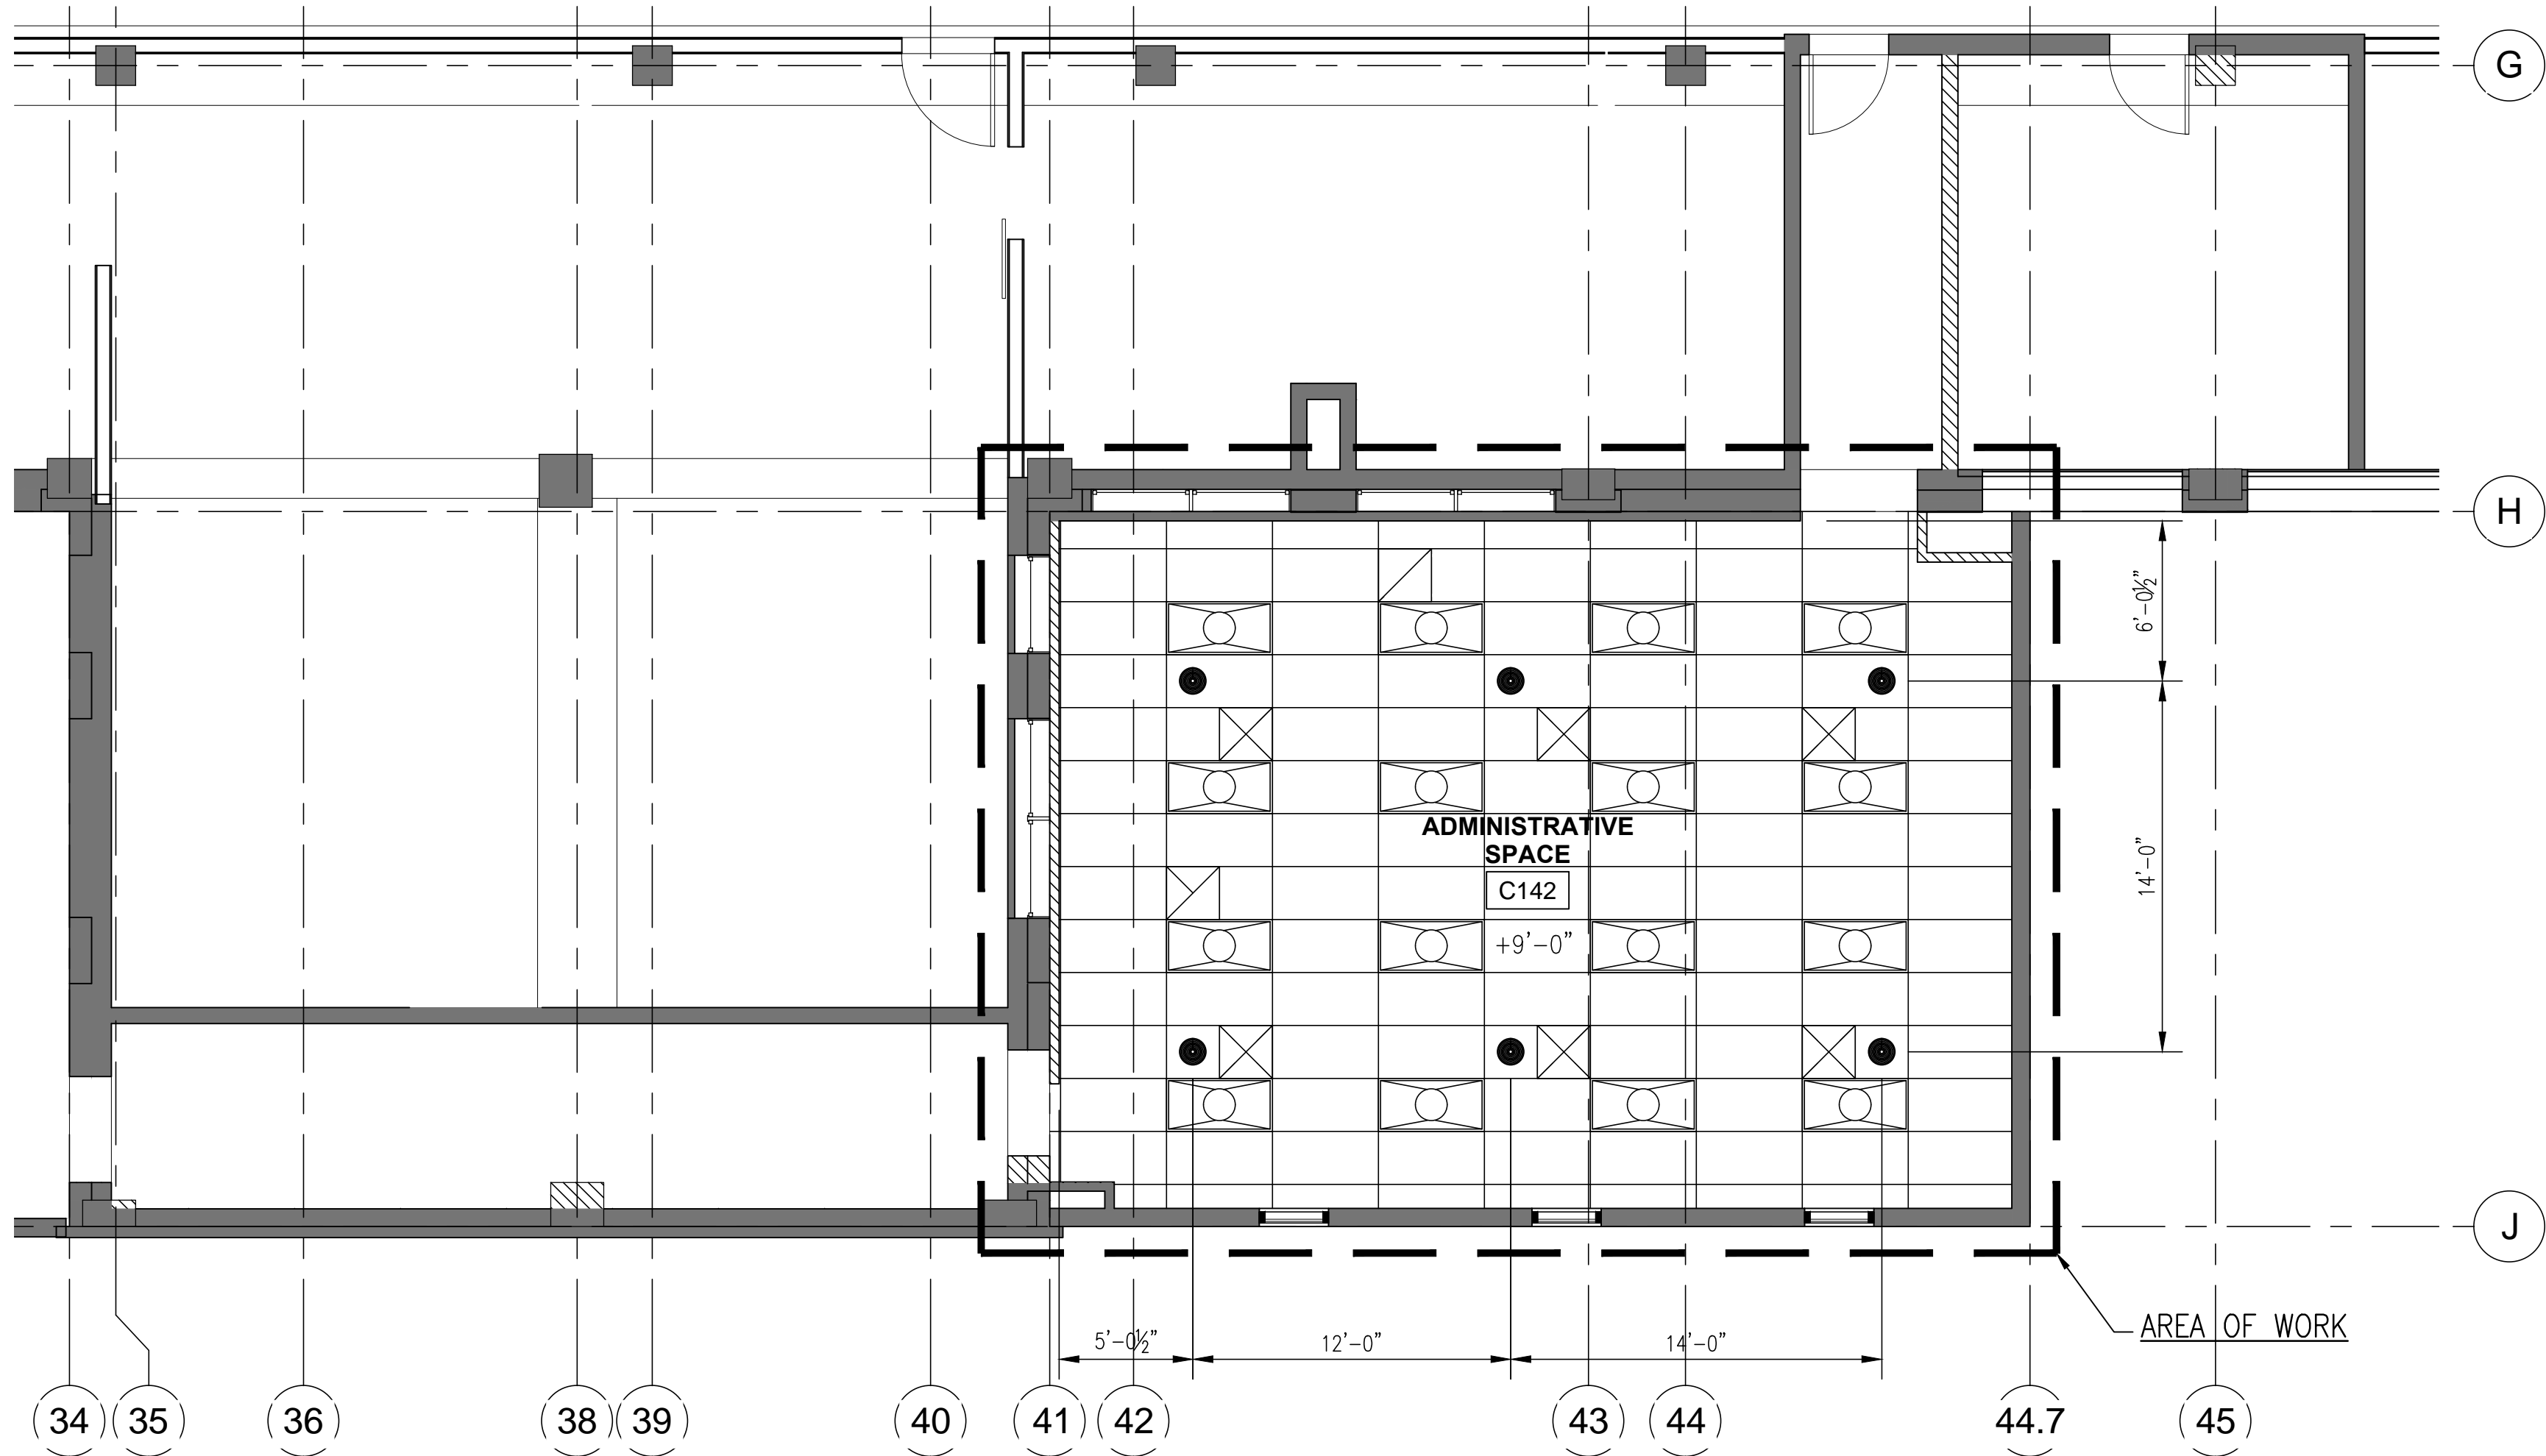

FIRST FLOOR REFLECTED CEILING PLAN

- PENDENT SPRINKLERS SHALL BE CENTER OR "QUARTER POINT" OF CEILING TILES.
- SPACING OF SPRINKLERS IN ADMINISTRATIVE AREA IS FOR LIGHT HAZARD PER NFPA 13. SPACING OF SPRINKLERS IN CIRCULATION/STORAGE IS FOR ORDINARY HAZARD PER NFPA 13.
- PENDENT SPRINKLERS SHALL BE CHROME WITH CHROME SEMI-RECESSED ESCUTCHEONS.
- INDICATES RATED WALLS.
- - - INDICATES EXISTING PIPING TO REMAIN.
- FOR PROTECTION OF AREAS NOT SHOWN SEE PIPING PLAN.



FINAL BID DOCUMENTS

				CONSULTANTS:				ARCHITECT/ENGINEERS:		Drawing Title		Project Title		Project Number		Office of Construction and Facilities Management	
				<div><div>MARQUEE</div><div> FIRE PROTECTION</div><div>710 W. Stadium Lane Sacramento, CA 95834-1130 TEL 916. 641-7997 / 707. 642-7905 FAX 916. 641-0775 CA. LIC. 570970 C-16</div></div>		<div><div></div><div>MFP JOB#: 1113-880</div></div>		<div><div></div><div>HILLIARD ARCHITECTS, INC 251 Post Street, Suite 620 San Francisco, CA 94108-5017 Tel 415 989 6400, Fax 415 989 3056 www.HilliardArchitects.com</div></div>		REFLECTED CEILING PLAN		VA PALO ALTO BLDG 6 ADMINISTRATIVE EXPANSION		640-13-121P			
								Approved: Project Director		Location		Building Number					
Revisions:		Date								VAPAHCS, PALO ALTO CAMPUS 3801 MIRANDA AVE, PALO ALTO, CA 94304		6					
										Date		Checked		Drawing Number			
										04.17.2014		M.D.		FP1.31A			
												J. HINTZ		Dwg. of			

