


PROJECT 640-14-901, B-334, CHILLED
WATER PUMPS & PIPING REPLACEMENT
DEDUCTIVE BID OPTION 1

BASEMENT PIPING PLAN
SCALE: 1/8" = 1'-0"

CONSULTANTS:		B334 KEY PLAN	STAMP	ARCHITECT/ENGINEERS:	Drawing Title DEDUCTIVE BID OPTION 1	Project Title B-334, CHILLED WATER PUMPS & PIPING REPLACEMENT	Project Number 640-14-901	Office of Facilities Management Department of Veterans Affairs	
					Approved: Project Director	Location MENLO PARK CAMPUS	Building Number B334		
					Date 08/01/13	Checked H. OJEDA	Drawn RSOTELO		Drawing Number 334-H-80-0.9.1
									Dwg. -- of --
Revisions:									
15% SCHEMATIC DEVELOPMENT (13-232) CONCEPTUAL REPORT (13-203)		12/12/13 10/7/13							
Date									

VA FORM 08-6231, OCT 1978

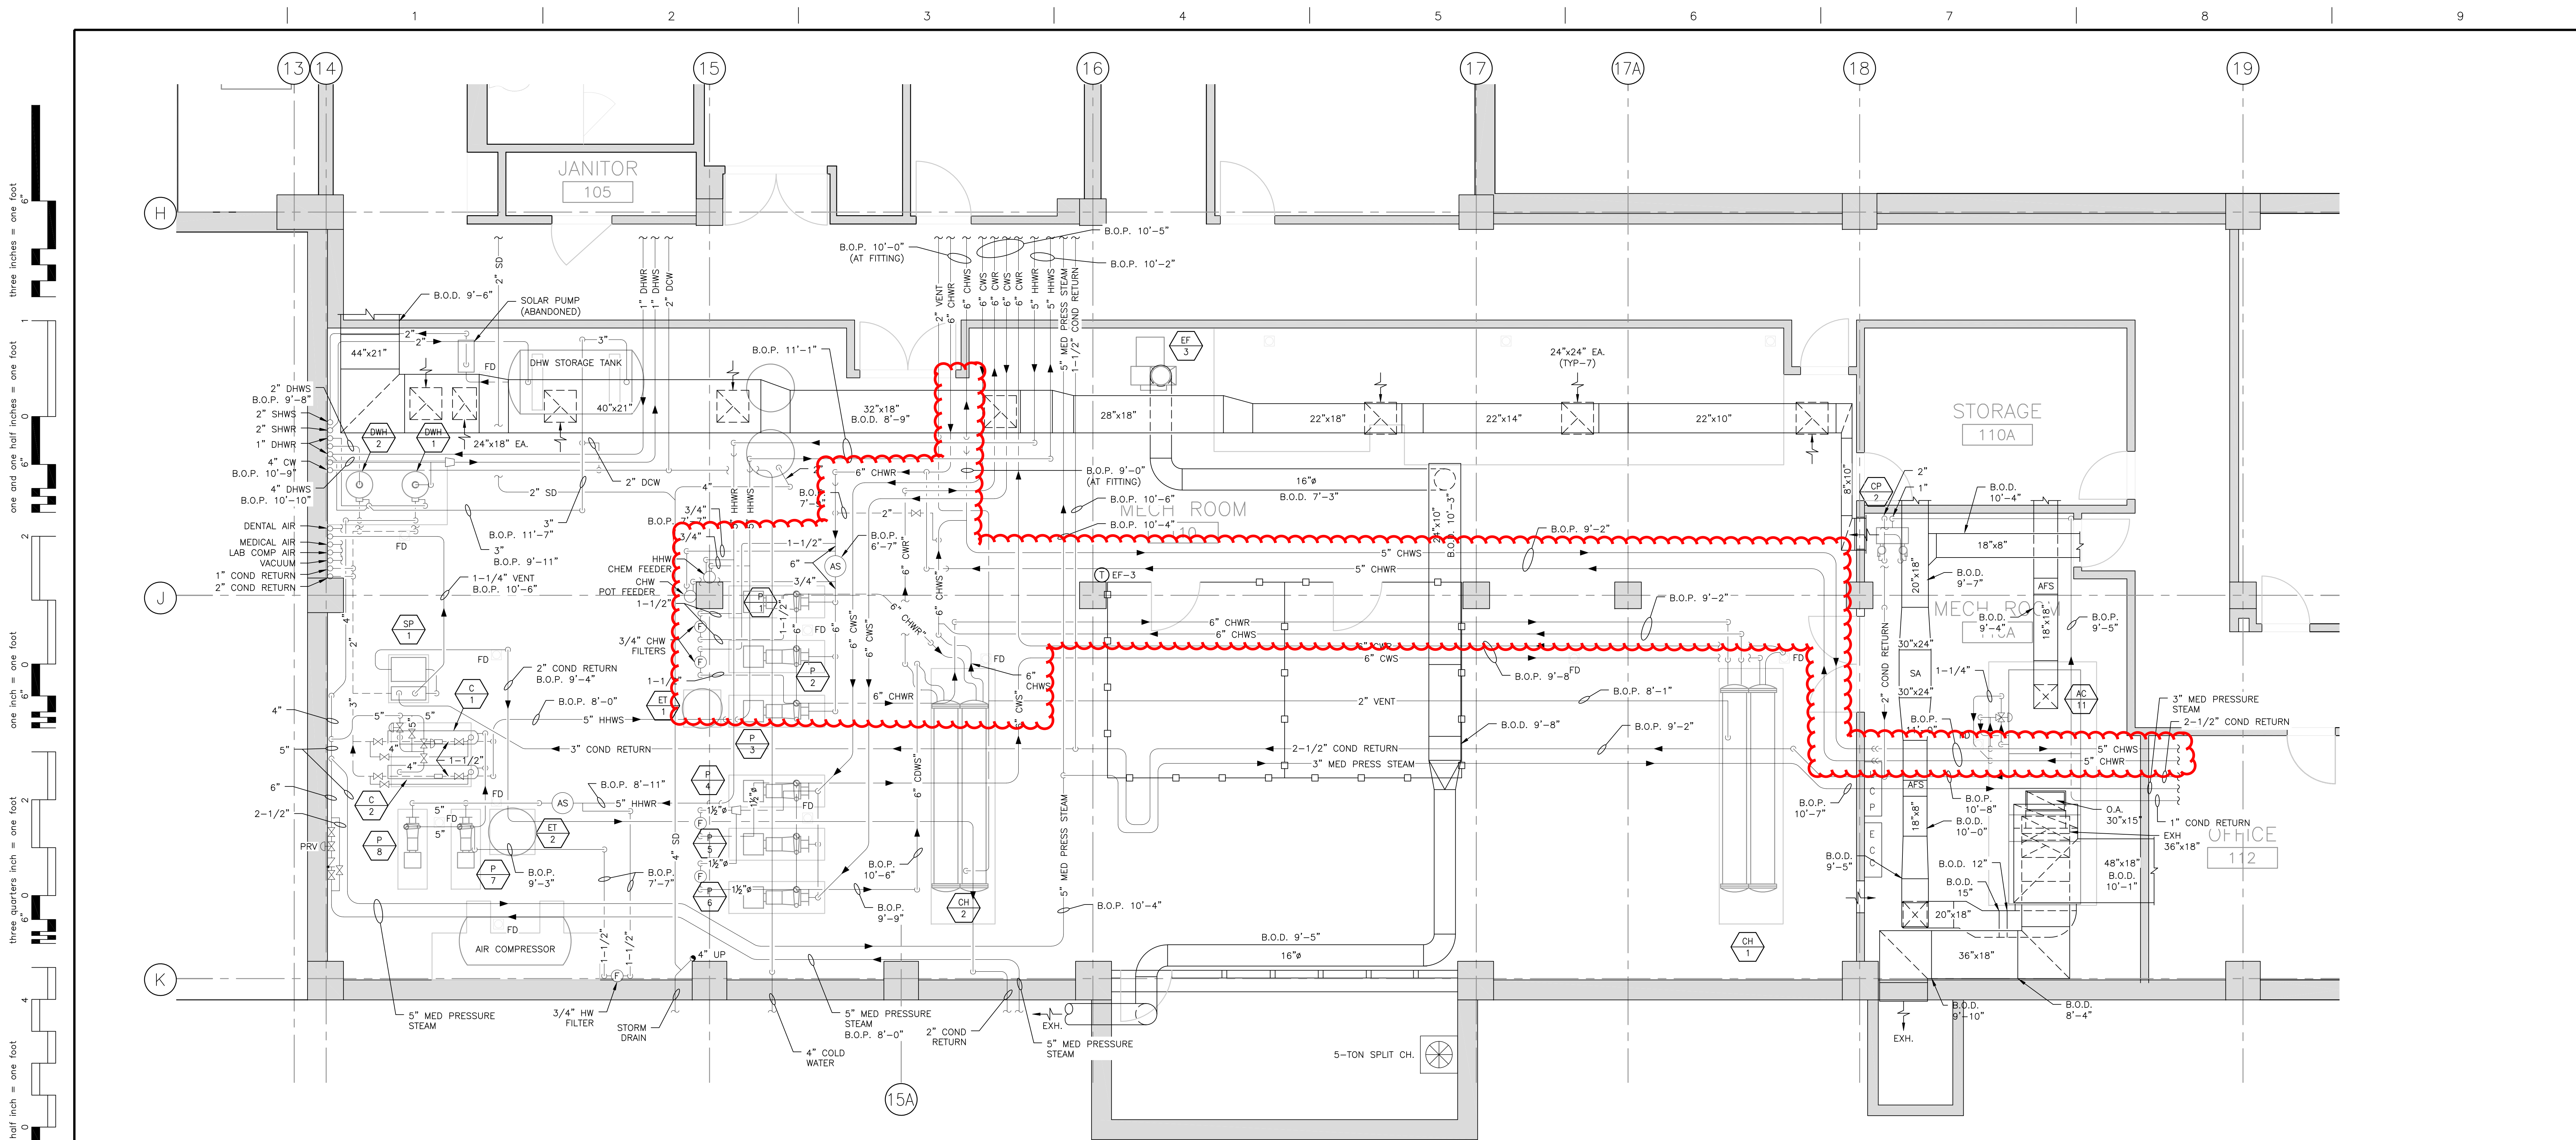


ENLARGED BASEMENT MECHANICAL ROOM HVAC AND EQUIPMENT PLAN
SCALE: 1/4" = 1'-0"

PROJECT 640-14-901, B-334, CHILLED WATER
PUMPS & PIPING REPLACEMENT
BID OPTION 1

15% SCHEMATIC DEVELOPMENT (13-232)		12/12/13
CONCEPTUAL REPORT (13-203)		10/7/13
Revisions:		Date

CONSULTANTS:

B334 KEY PLAN

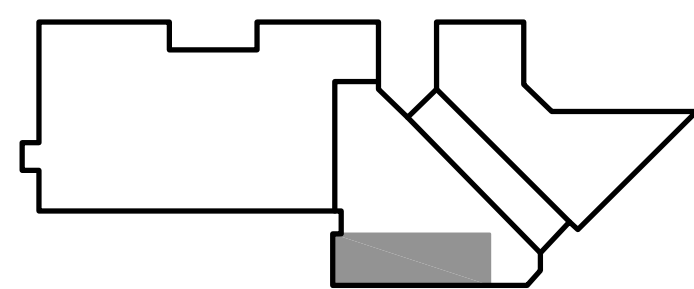

STAMP

ARCHITECT/ENGINEERS:



ATTENTION:
ONLY WET SIGNED DOCUMENTS CONSTITUTE ADVANCE DESIGN CONSULTANTS, INC. PROFESSIONAL WORK AND BECAUSE OTHER REPRODUCIBLE DOCUMENTS MAY BE EASILY ALTERED WITHOUT THE CONSENT OF ADVANCE DESIGN CONSULTANTS, INC. THE WET SIGNED DOCUMENTS MUST BE REFERRED TO FOR THE ORIGINAL AND CORRECT INFORMATION. IF THERE ARE ANY DIFFERENCES BETWEEN THE WET SIGNED DOCUMENTS AND ANY OTHER DOCUMENTS, THE WET SIGNED DOCUMENTS SHALL GOVERN.
ADVANCE DESIGN CONSULTANTS, INC. IS NOT RESPONSIBLE FOR ANY MODIFICATIONS MADE TO OUR DOCUMENTS BY ANYONE OTHER THAN AUTHORIZED REPRESENTATIVES OF ADVANCE DESIGN CONSULTANTS, INC.
PDR 13-208-28

Drawing Title
BASE BID
Approved: Project Director

Project Title		Project Number
B-334, CHILLED WATER PUMPS & PIPING REPLACEMENT		640-14-901
Building Number		B334
Location		Drawing Number
MENLO PARK CAMPUS		334-H-80-0.10
Date	Checked	Drawn
08/01/13	H. OJEDA	R. SOTELO
Dwg. -- of --		

Office of
Facilities
Management

Department of
Veterans Affairs