




ROOF MOUNTED EQUIPMENT CURB DETAIL
NO SCALE

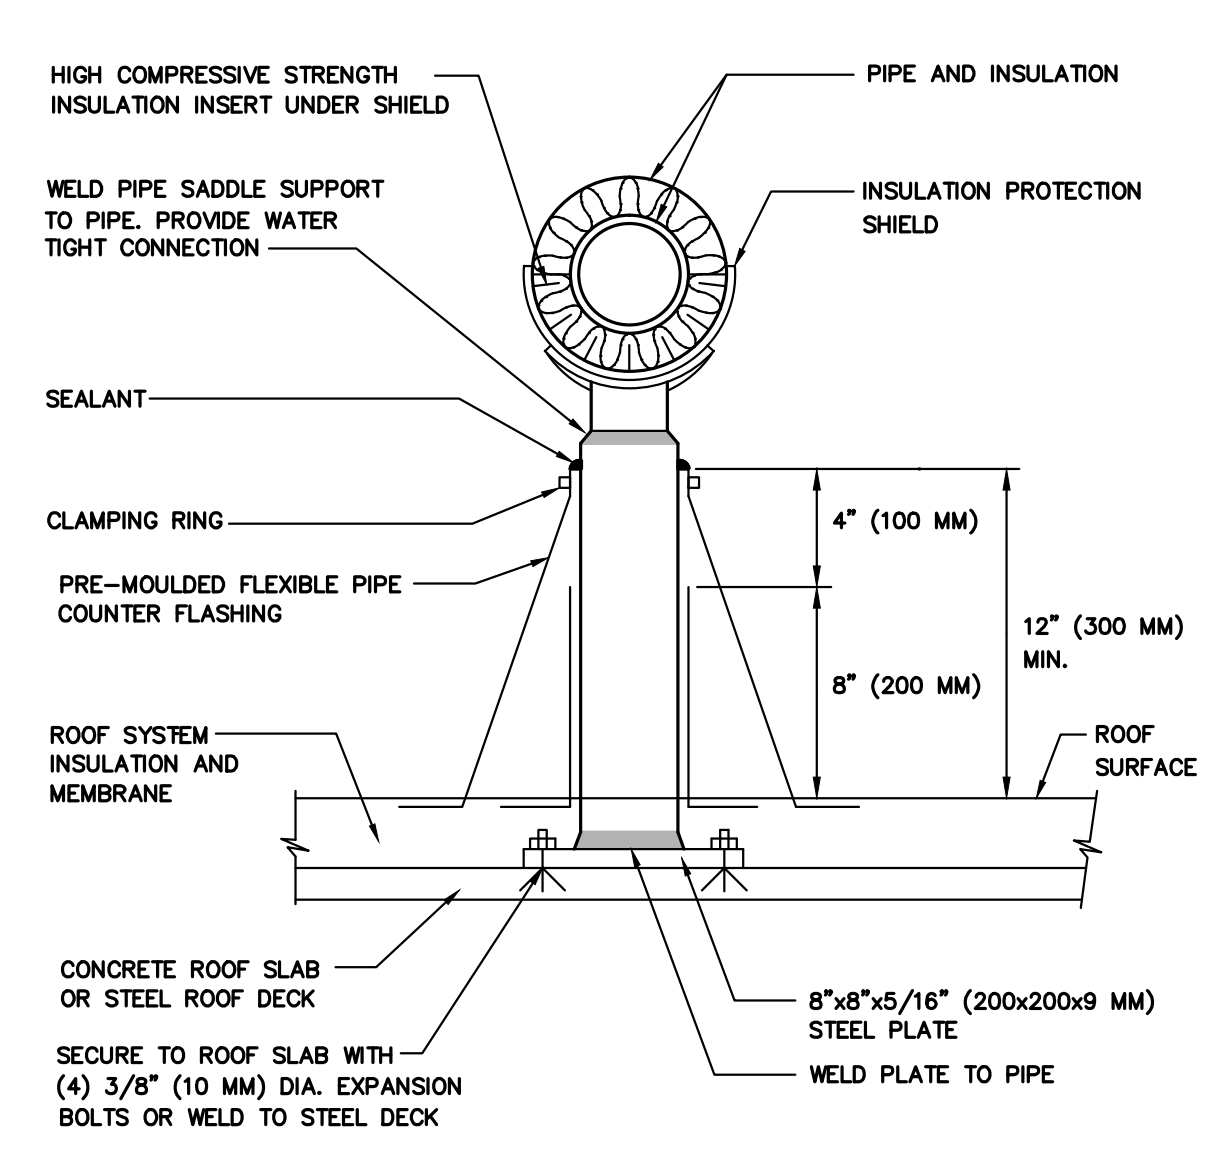


DETAIL FOR SUPPORTING PIPE ON ROOF

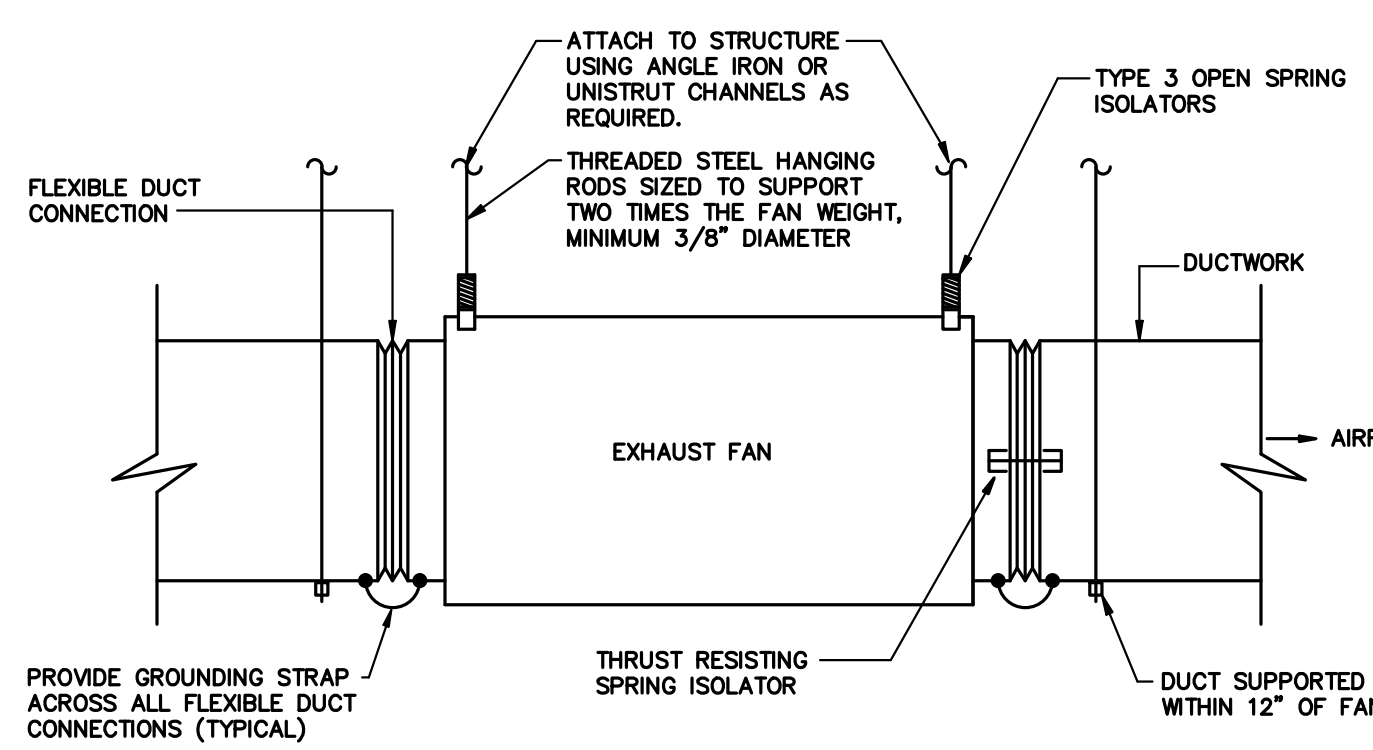


INLINE EXHAUST FAN DETAIL
NO SCALE

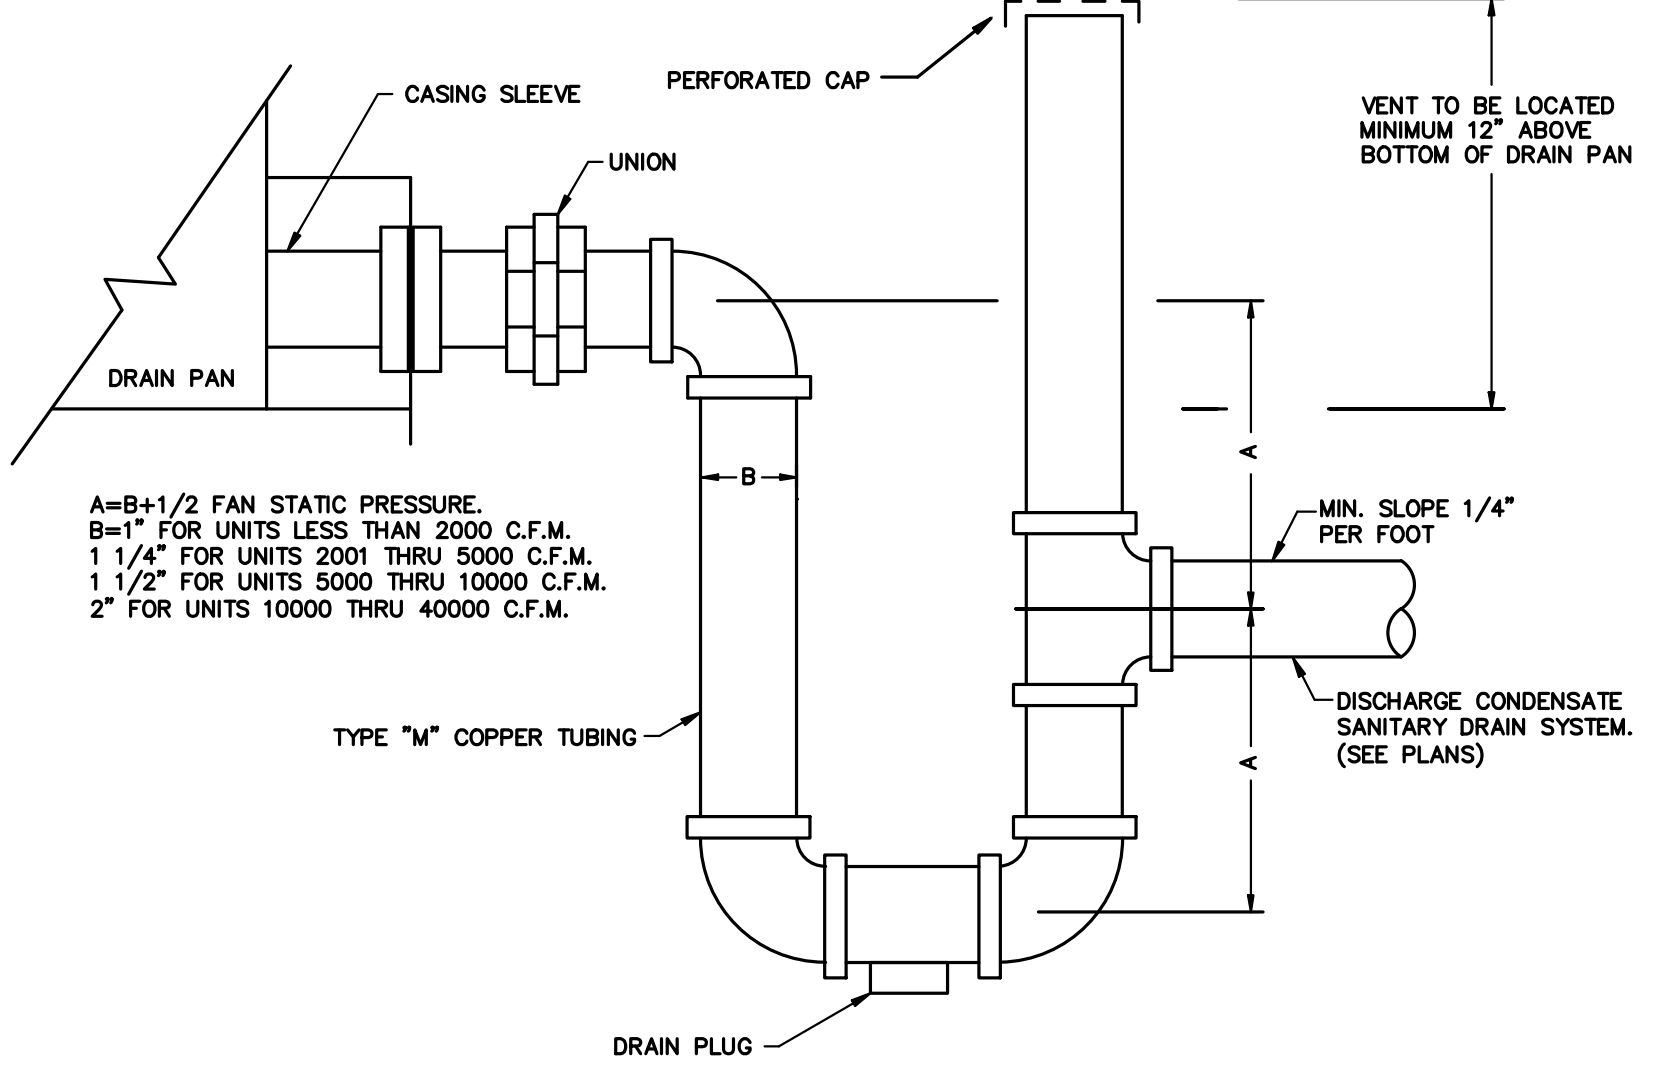


AIR CONDITIONING UNIT DRAIN TRAP DETAIL
NO SCALE

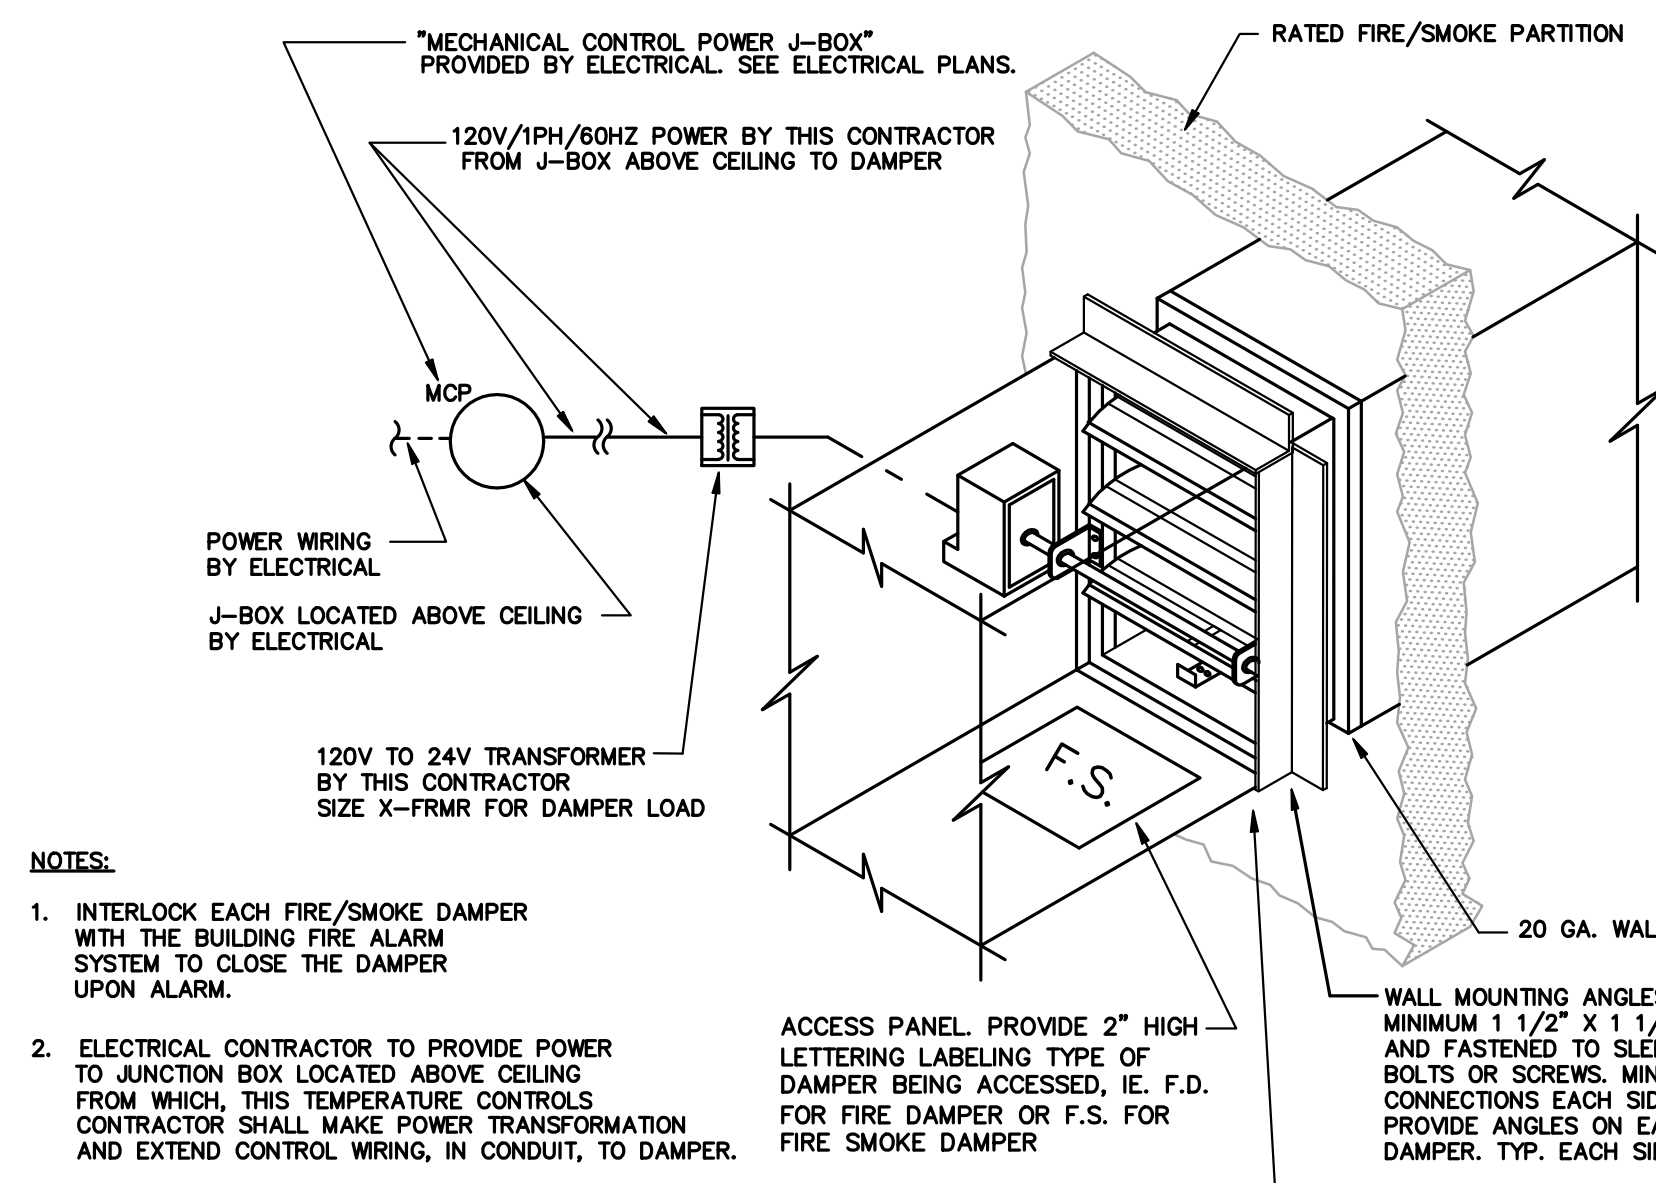


COMBINATION FIRE/SMOKE DAMPER DETAIL
TYPICAL FOR SMOKE DAMPERS
NO SCALE

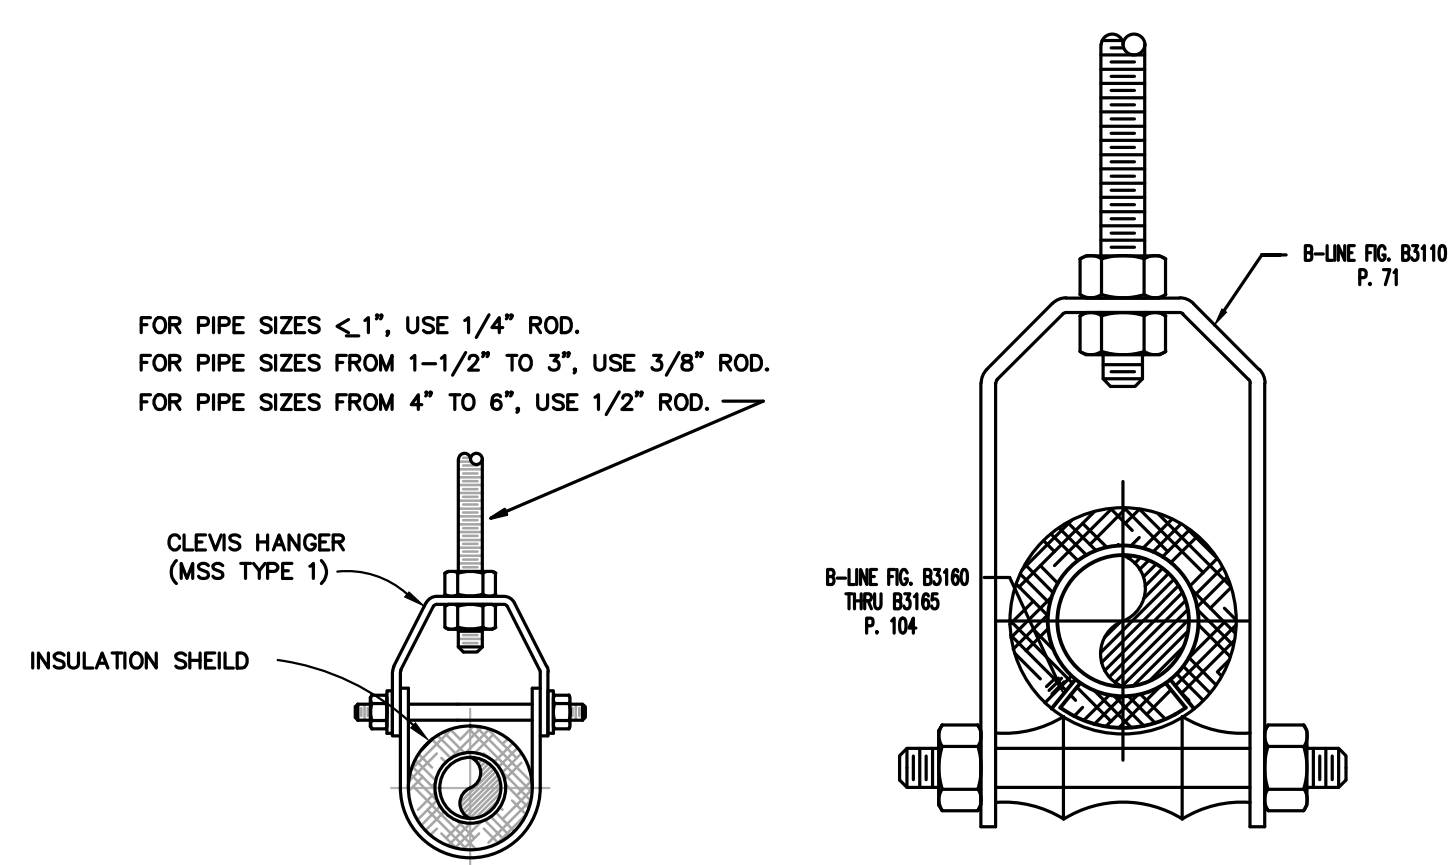


PIPE HANGER DETAIL
NO SCALE

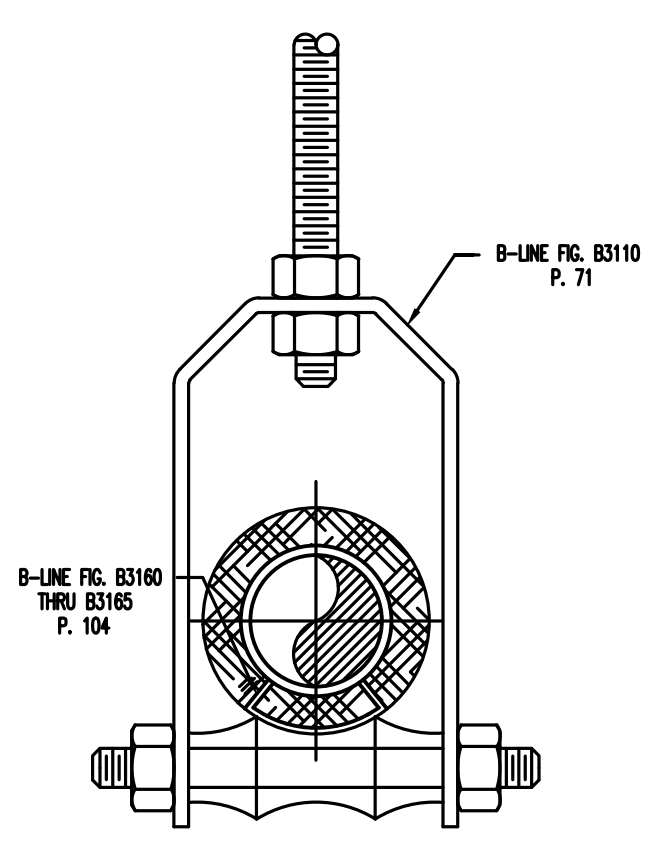


ROLLER PIPE SUPPORT
NO SCALE

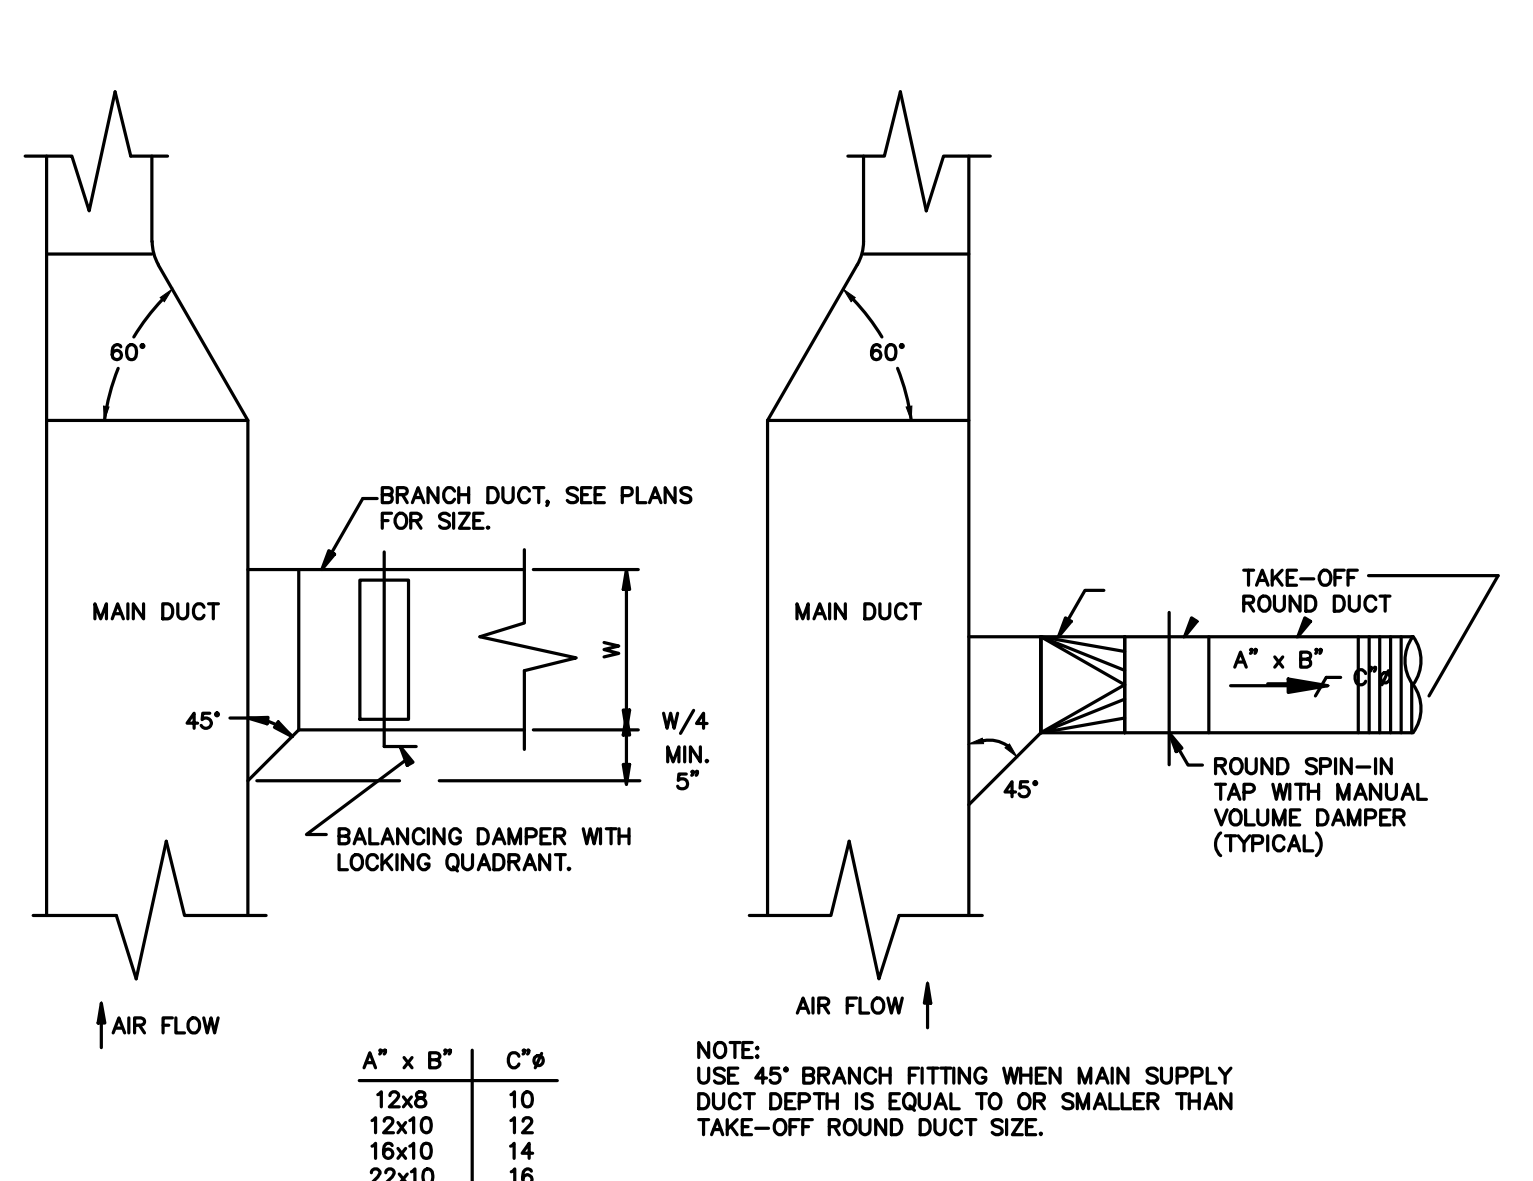


TYPICAL DUCT TAKEOFF DETAIL
NO SCALE

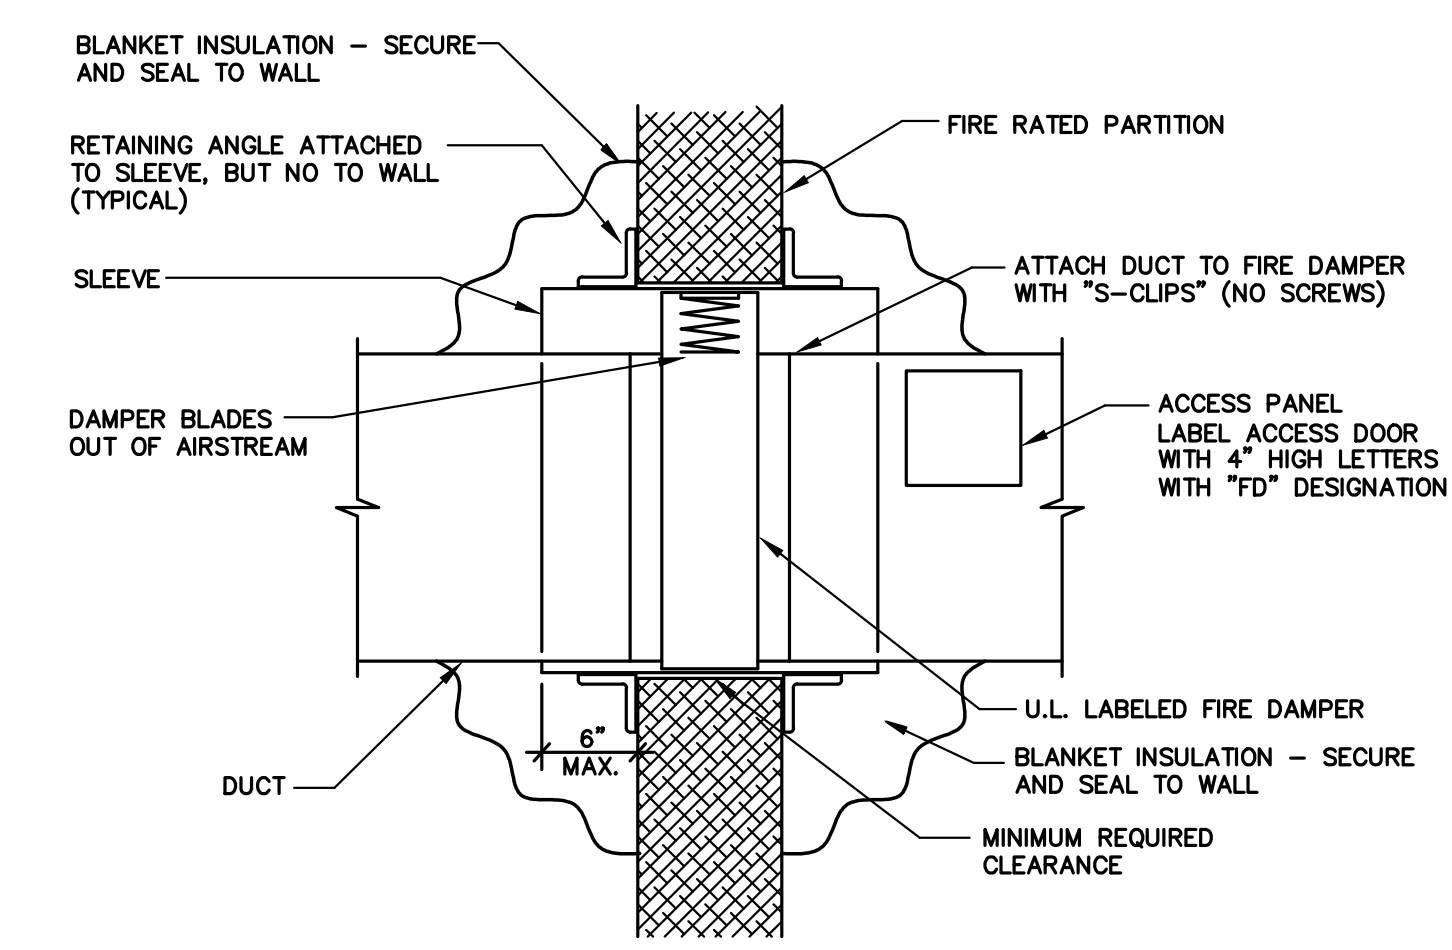


TYPICAL FIRE DAMPER INSTALLATION DETAIL
NO SCALE

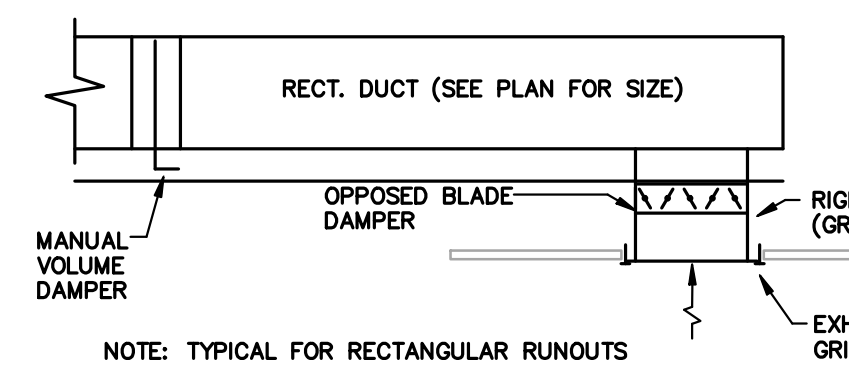


TYPICAL RETURN AND EXHAUST RUN-OUT DETAIL
NO SCALE

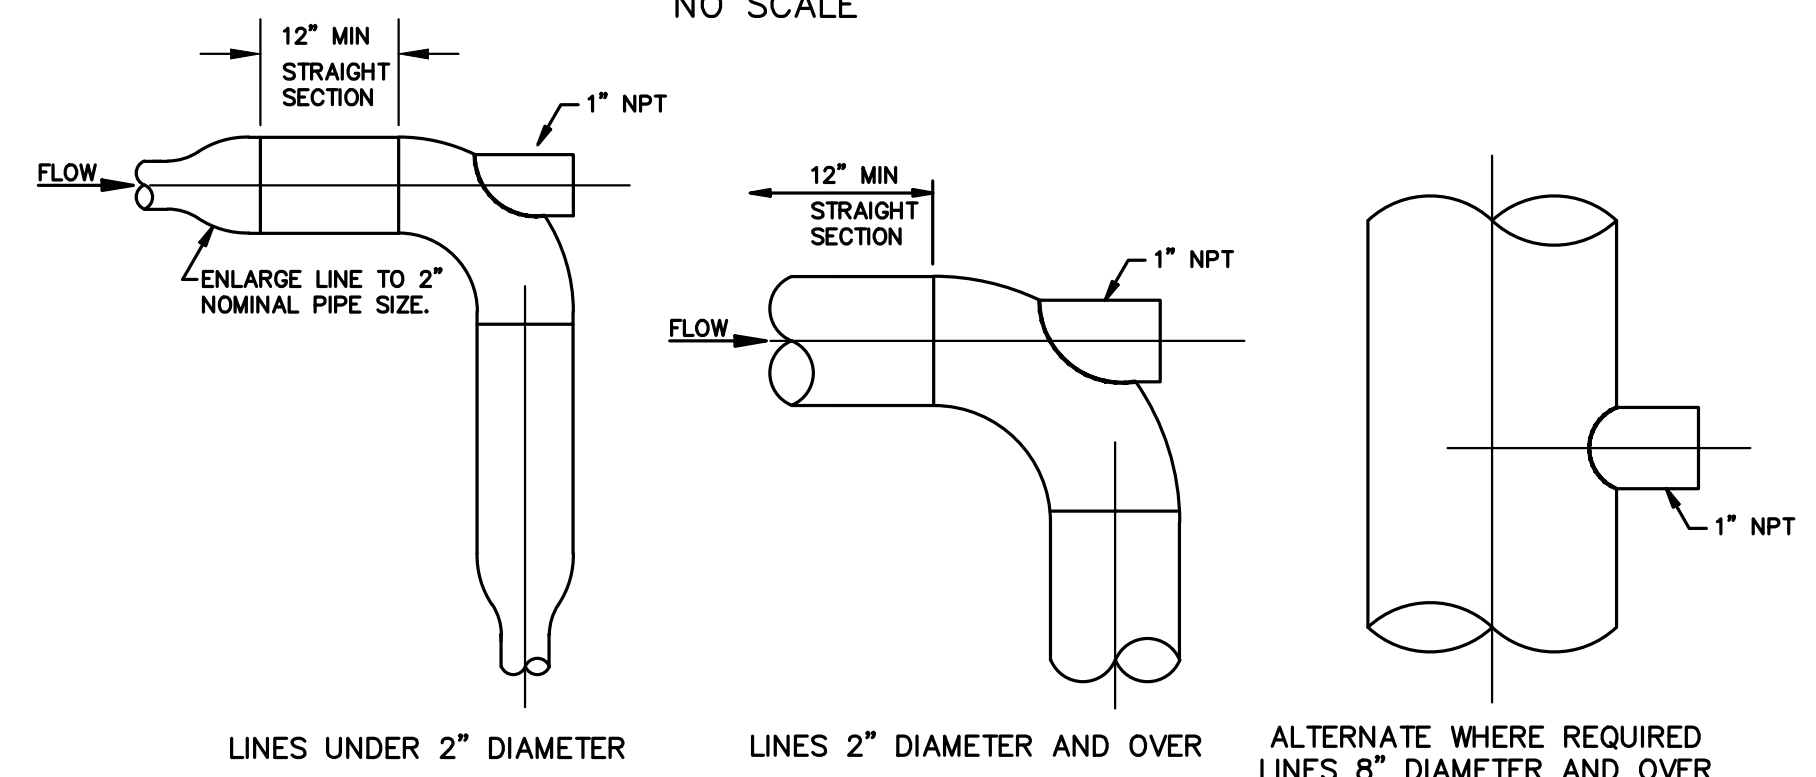


THERMOWELL DETAIL
NO SCALE

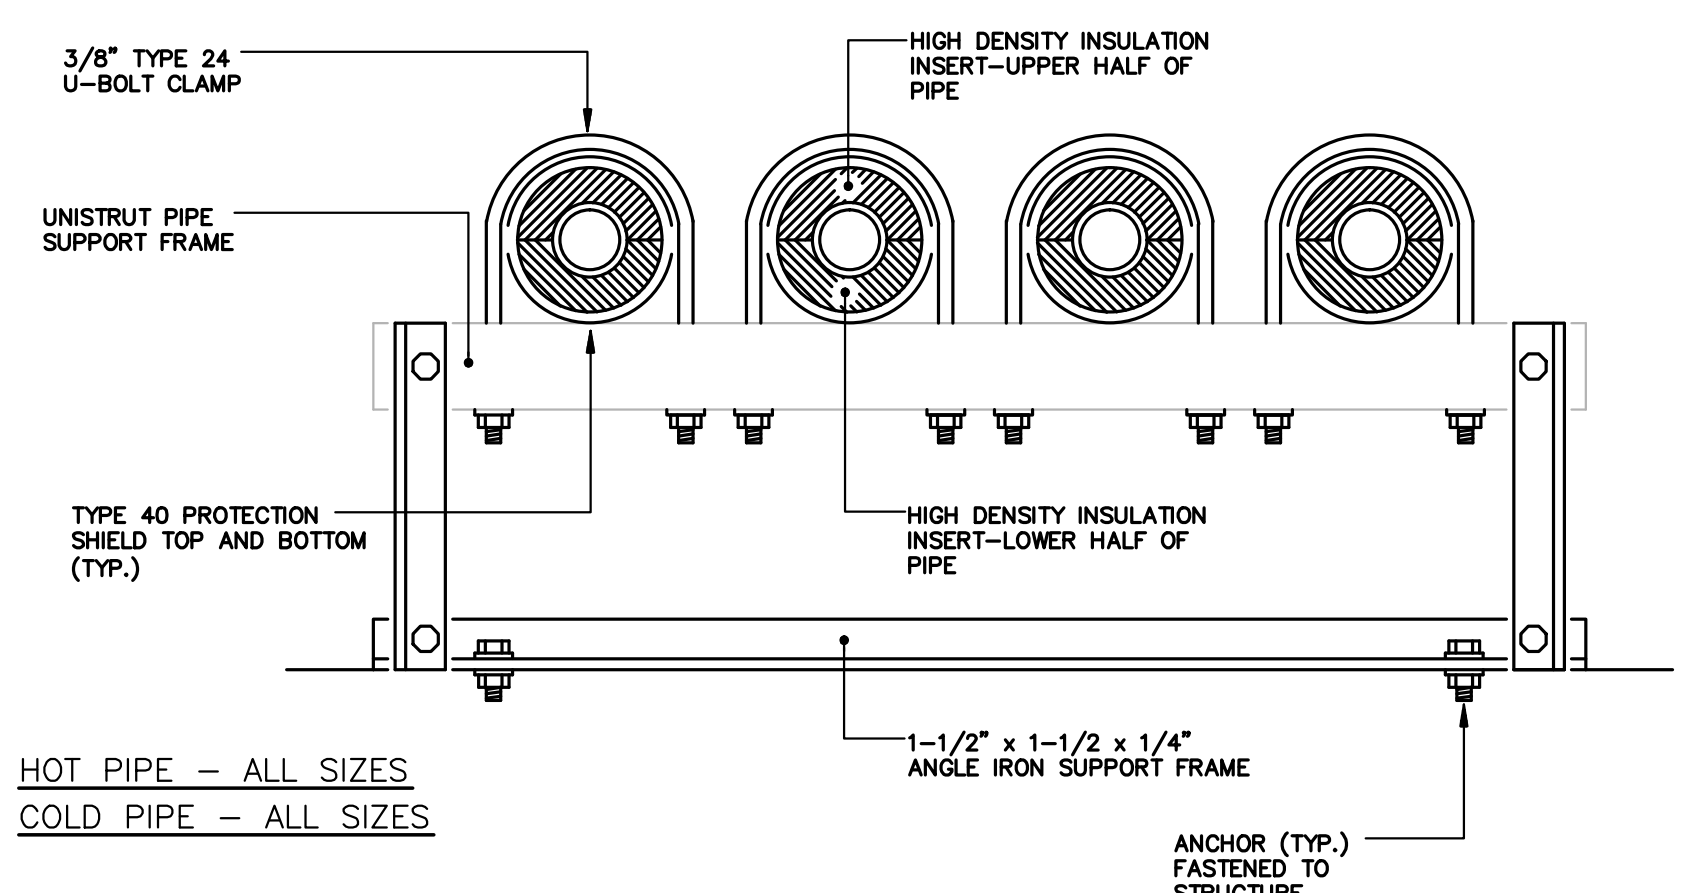


CONDENSATE HORIZONTAL PIPE SUPPORT DETAIL
NO SCALE

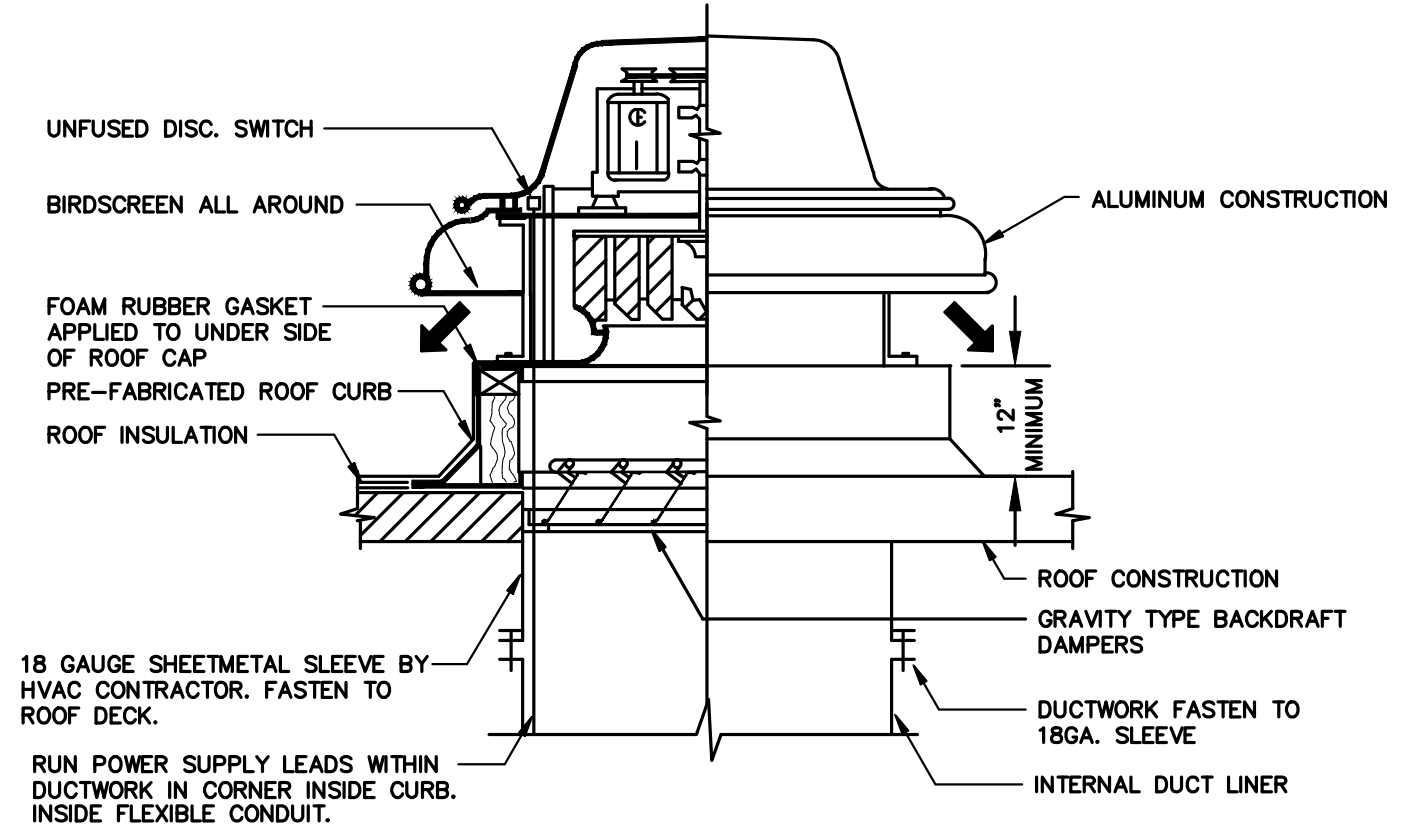

ROOF EXHAUST FAN DETAIL
NO SCALE

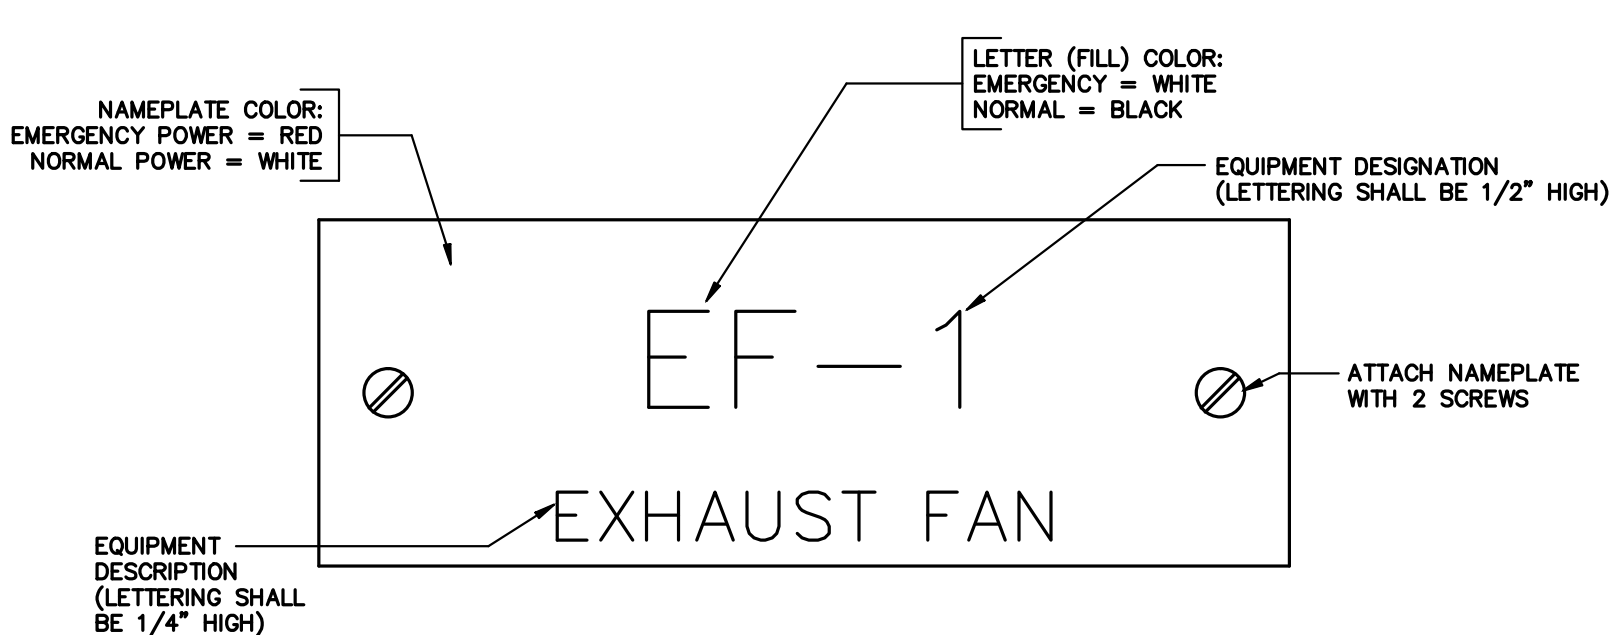

MECHANICAL EQUIPMENT NAMEPLATE DETAIL
NO SCALE

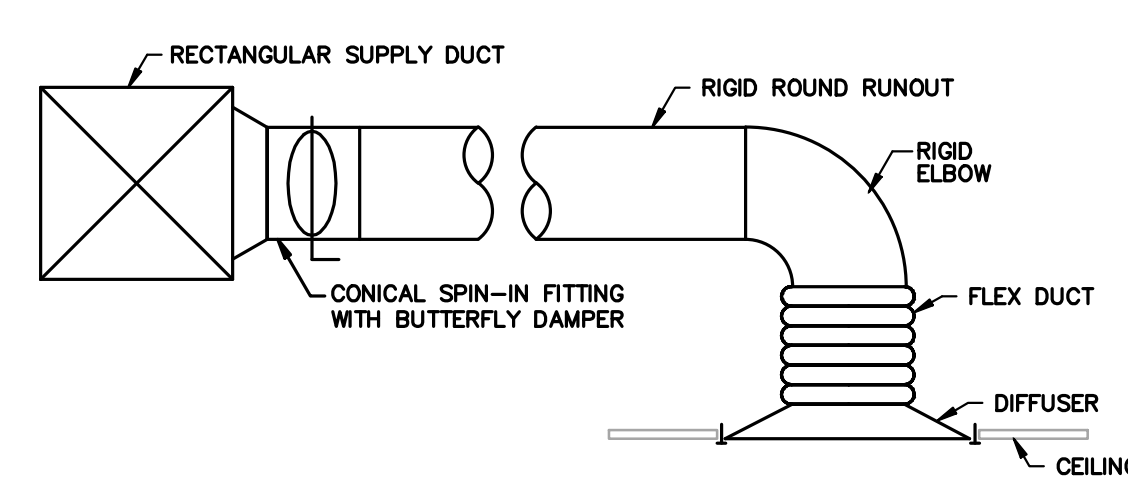

TYPICAL DIFFUSER RUN-OUT DETAIL
NO SCALE

COMPLETION ITEM NO. _____
CONSTRUCTION DOCUMENTS - 100% FINALS FULLY SPRINKLERED

CONSULTING ENGINEERS: LBYO, Inc. Civil and Structural Engineers 716 South 30th Street Birmingham, AL 35223 Main (205) 251-4500 Fax (205) 324-4181 © copyright 2002		SSOE, Inc. 3504 7th Avenue South Birmingham, AL 35222 T 205-925-2375 Project # 012-01051.00		ARCHITECT: CMH Architects, Inc. 1800 International Park Drive, Suite 300 Birmingham, AL 35243 (205) 969-2696 - TEL (205) 969-3950 - FAX www.cmharch.com Copyright © 2011 CMH Architects, Inc.		PROJECT MANAGEMENT: WALKER AND MOORE 1100 Laurel Lane Montgomery, Alabama 36106 Telephone: 334.380.4399 Fax: 334.264.5555		Drawing Title HVAC DETAILS Approved Project Director James Zellander		Project Title A/E AMBULATORY SURGERY IMPROVEMENTS Location VAMC - Birmingham, Alabama Date 5/23/2014 Checked DSH Drawn JAG		Project Number 521-328 Building Number 0000000000 Drawing Number M003 Dwg. 83 of 124		Office of Construction and Facilities Management Department of Veterans Affairs	
---	--	--	--	--	--	---	--	---	--	---	--	---	--	--	--