


FIRST FLOOR PLAN  
HVAC & PIPING  
0 2 4 6 8 16  
SCALE: 1/8" = 1'-0"

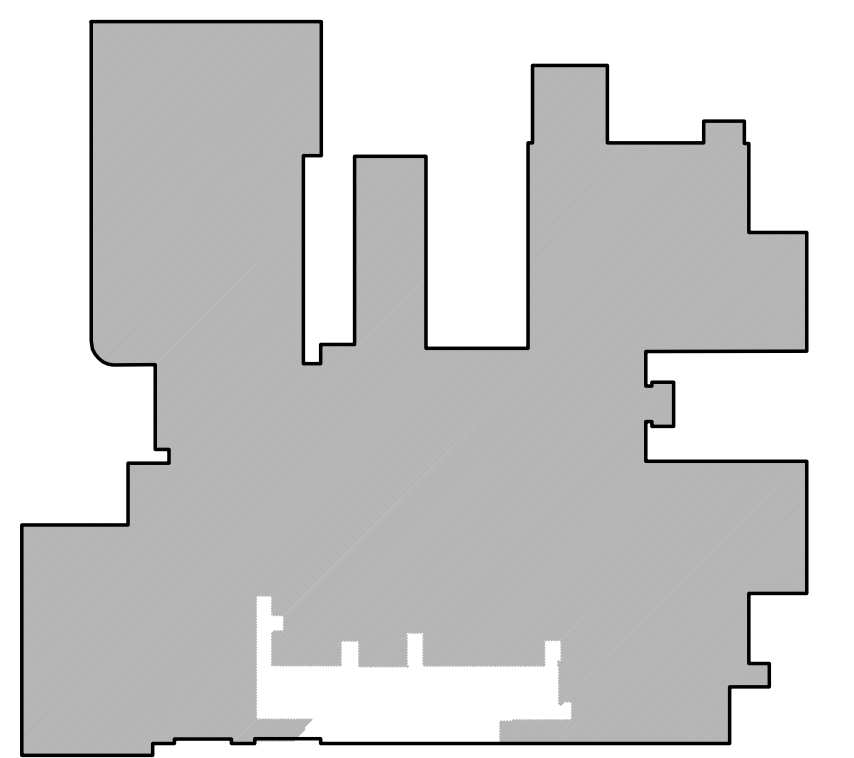

KEY PLAN

COMPLETION ITEM NO. \_\_\_\_\_  
CONSTRUCTION DOCUMENTS - 100% FINALS FULLY SPRINKLERED

<p>MECH REVIEW RESPONSE</p> <p>2014/02/24</p> <p>Revisions</p> <p>Date</p>		<p>CONSULTING ENGINEERS:</p> <p><b>LBYD, Inc.</b> Civil and Structural Engineers 716 South 30th Street Birmingham, AL 35233 Main (205) 251-4500 Fax (205) 324-4181</p> <p><b>SSOE</b> SSOE, Inc. 3504 7th Avenue South Birmingham, AL 35222 T 205-925-2375 Project # 012-01051.00</p>		<p><b>ARCHITECT:</b></p> <p><b>CMH Architects, Inc.</b> 1800 International Park Drive, Suite 300 Birmingham, AL 35243 (205) 969-2696 - TEL (205) 969-3950 - FAX www.cmharch.com Copyright © 2011 CMH Architects, Inc.</p>	<p><b>PROJECT MANAGEMENT:</b></p> <p><b>WALKER AND MOORE</b> 1100 Laurel Lane Montgomery, Alabama 36106 Telephone: 334.380.4399 Facsimile: 334.264.5555</p>	<p><b>Drawing Title</b></p> <p><b>FIRST FLOOR PLAN</b> <b>HVAC</b></p> <p><b>Approved Project Director</b> <b>James Zellander</b></p>	<p><b>Project Title</b></p> <p><b>A/E AMBULATORY SURGERY IMPROVEMENTS</b></p> <p><b>Location</b> <b>VAMC - Birmingham, Alabama</b></p> <p><b>Date</b> <b>5/23/2014</b></p> <p><b>Checked</b> <b>DSH</b></p> <p><b>Drawn</b> <b>JAG</b></p>	<p><b>Project Number</b> <b>521-328</b></p> <p><b>Building Number</b> <b>0000000000</b></p> <p><b>Drawing Number</b> <b>M201</b> Dwg. 88 of 124</p>	<p><b>Office of Construction and Facilities Management</b></p> <p><b>Department of Veterans Affairs</b></p>
--	--	---	--	---	---	---	--	---	---