


one eighth inch = one foot  
one quarter inch = one foot  
three eighths inch = one foot  
one half inch = one foot  
one inch = one foot  
three quarters inch = one foot  
one and one half inches = one foot  
two inches = one foot  
three inches = one foot

T:\1010129\Drawings-BHM\10129M03.dwg  
PLOT DATE: 5/20/2014 9:52 AM

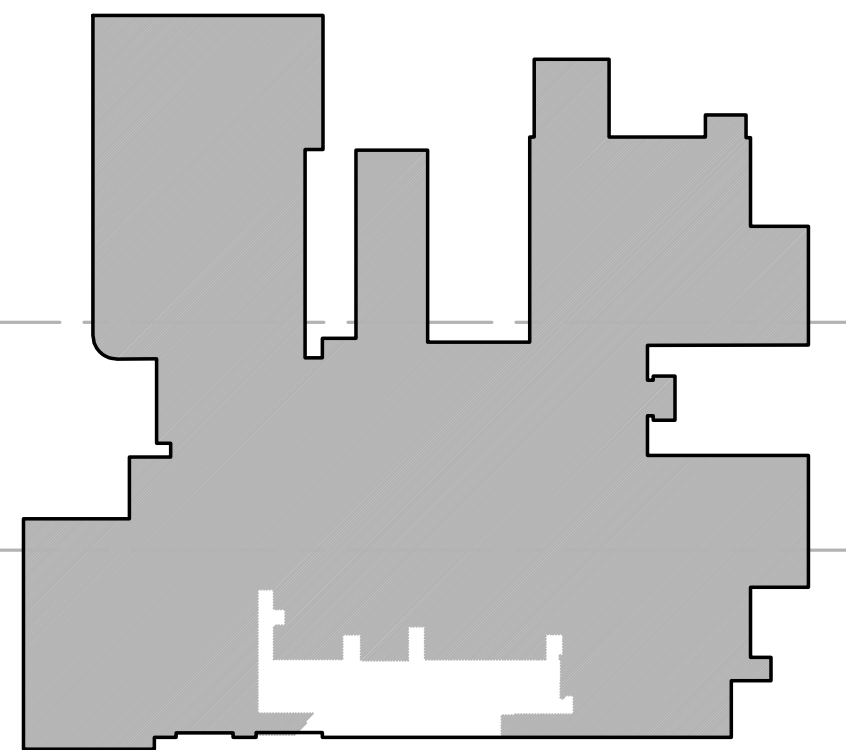

KEY PLAN

THIRD FLOOR PLAN - NEW  
HVAC DUCTWORK  
0 2 4 6 8 16  
SCALE: 1/8" = 1'-0"

COMPLETION ITEM NO. \_\_\_\_\_  
CONSTRUCTION DOCUMENTS - 100% FINALS FULLY SPRINKLERED

<b>CONSULTING ENGINEERS:</b>  LBYO, Inc. Civil and Structural Engineers 716 South 30th Street Birmingham, AL 35233 Main (205) 251-4500 Fax (205) 324-4181		<b>SSOE, Inc.</b> 3504 7th Avenue South Birmingham, AL 35222 T 205-325-2375 Project # 012-01051.00		 5-20-2014		<b>ARCHITECT:</b>  CMH Architects, Inc. 1800 International Park Drive, Suite 300 Birmingham, AL 35243 (205) 969-2696 - TEL (205) 969-3950 - FAX www.cmharch.com Copyright © 2011 CMH Architects, Inc.		<b>PROJECT MANAGEMENT:</b>  WALKER AND MOORE 11000 Laurel Lane Montgomery, Alabama 36106 Telephone: 334.380.4399 Fax: 334.264.5555		<b>Drawing Title</b> <b>THIRD FLOOR PLAN HVAC - NEW</b> <b>Approved Project Director</b> James Zellander		<b>Project Title</b> <b>A/E AMBULATORY SURGERY IMPROVEMENTS</b>		<b>Project Number</b> 521-328 <b>Building Number</b> 0000000000		<b>Office of Construction and Facilities Management</b> 	
<b>MECH REVIEW RESPONSE</b> 2014/02/24 Date												<b>Location</b> VAMC - Birmingham, Alabama		<b>Drawing Number</b> <b>M203</b> Dwg. 90 of 124			
												<b>Date</b> 5/23/2014		<b>Checked</b> DSH			
												<b>Drawn</b> JAG					