
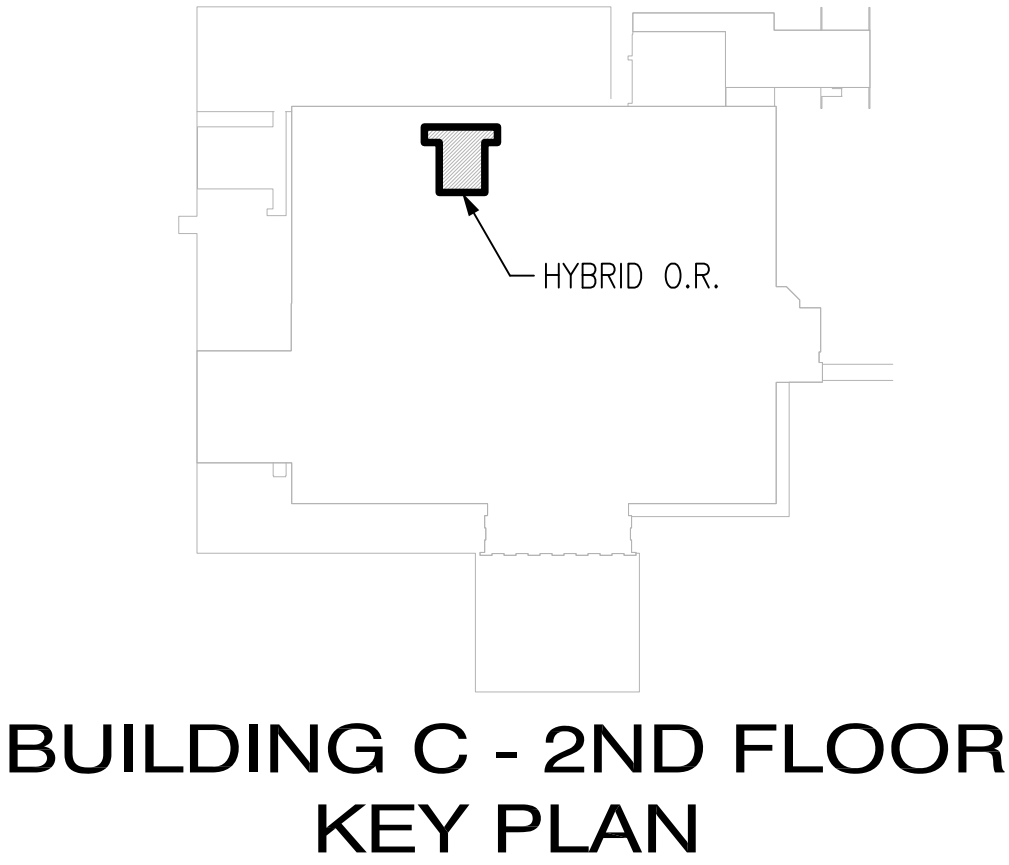


1
2
3
4
5
6
7
8
9

A
B
C
D
E
F

three inches = one foot
one and one half inches = one foot
one inch = one foot
three quarters inch = one foot
one half inch = one foot
three eighths inch = one foot
one quarter inch = one foot
one eighth inch = one foot

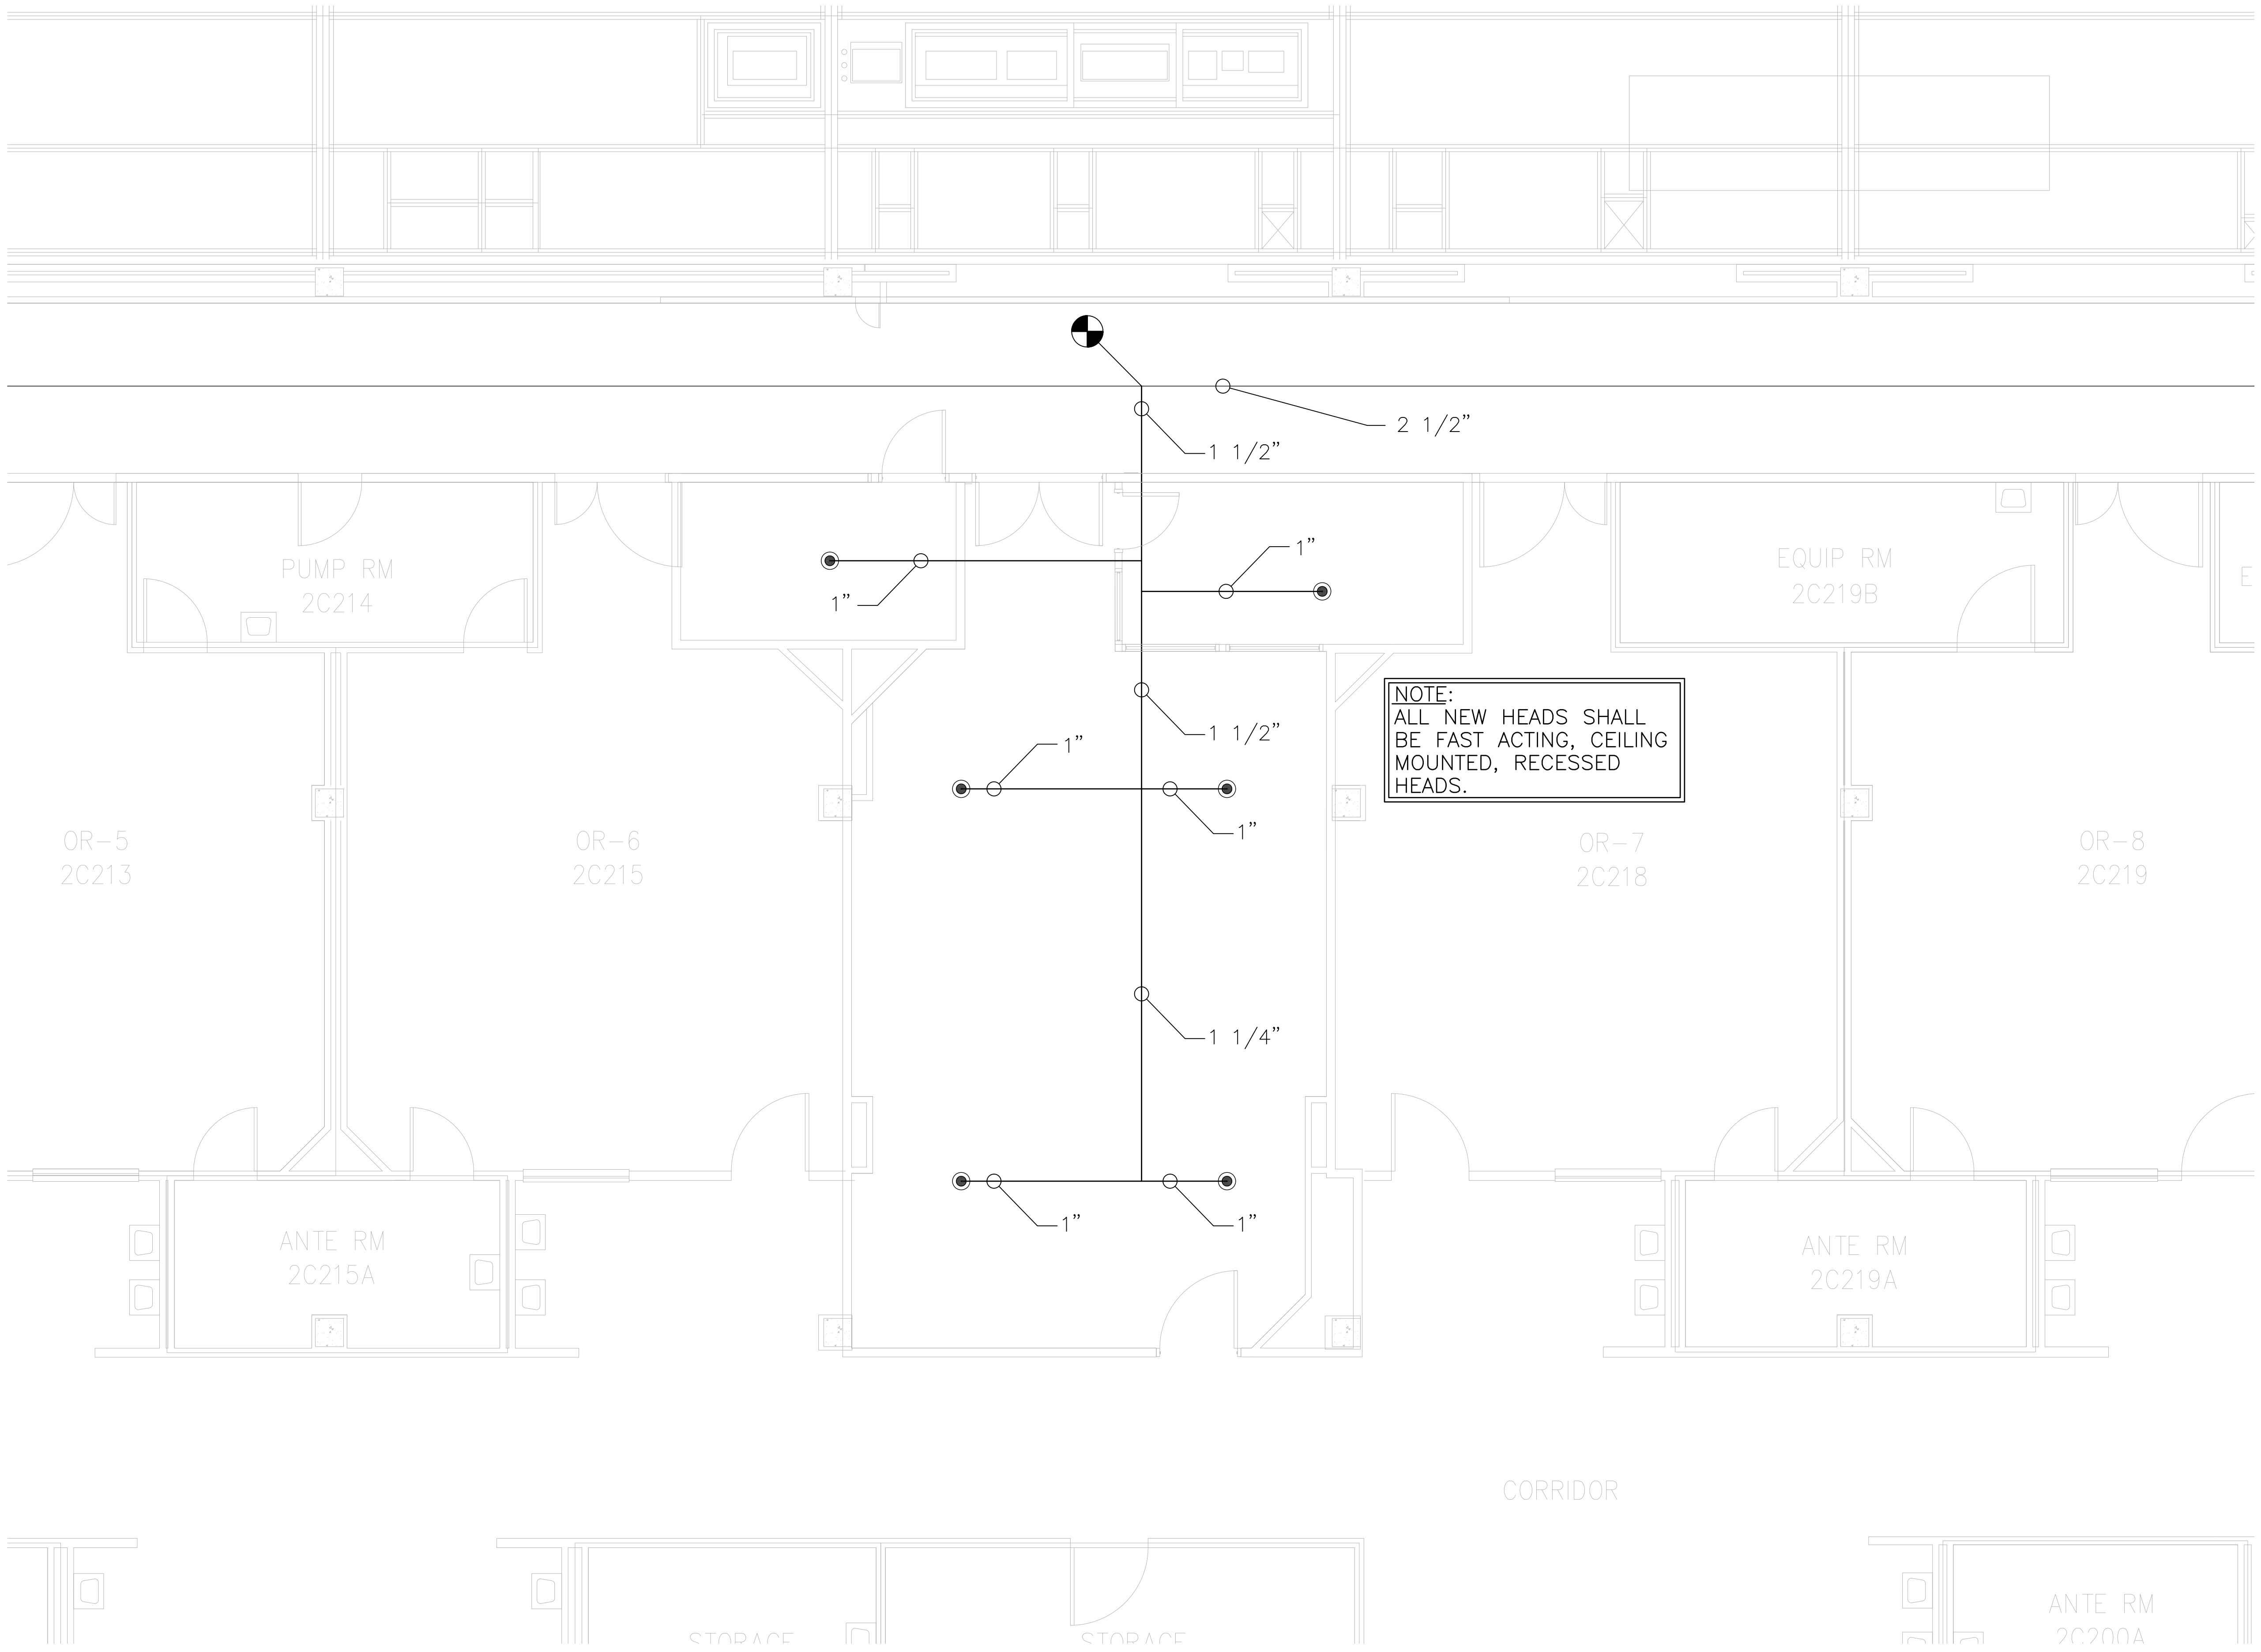

1 FIRE PROTECTION PLAN - NEW WORK
SCALE: 1/8" = 1' - 0"

FINAL SUBMITTAL
APPROVED FOR CONSTRUCTION

		CONSULTANTS:		ENGINEER-OF-RECORD STEPHEN T. STEFFE		GA. P.E. NO. 24897		ARCHITECT/ENGINEERS:				Drawing Title FIRE SPRINKLER - NEW WORK		Project Title NEW SURGICAL 9TH OR SUITE		Project Number 508-14-105		Office of Construction and Facilities Management					
								AKEA INC. 3603 NW 98th Street, Suite B Gainesville, FL 32606 Phone: (352) 474-6124 Fax: (352) 474-6324 COA: FL #26693 AKEA Project No. 072-14				Approved: Project Director		Location Atlanta, Georgia		Building Number							
														Date APRIL 30, 2014		Checked STS				Drawn TJM		Drawing Number FP200 36 of 36	
Revisions:														Date									