


1 POOL HOT WATER SCHEMATIC
3/32" = 1'-0"

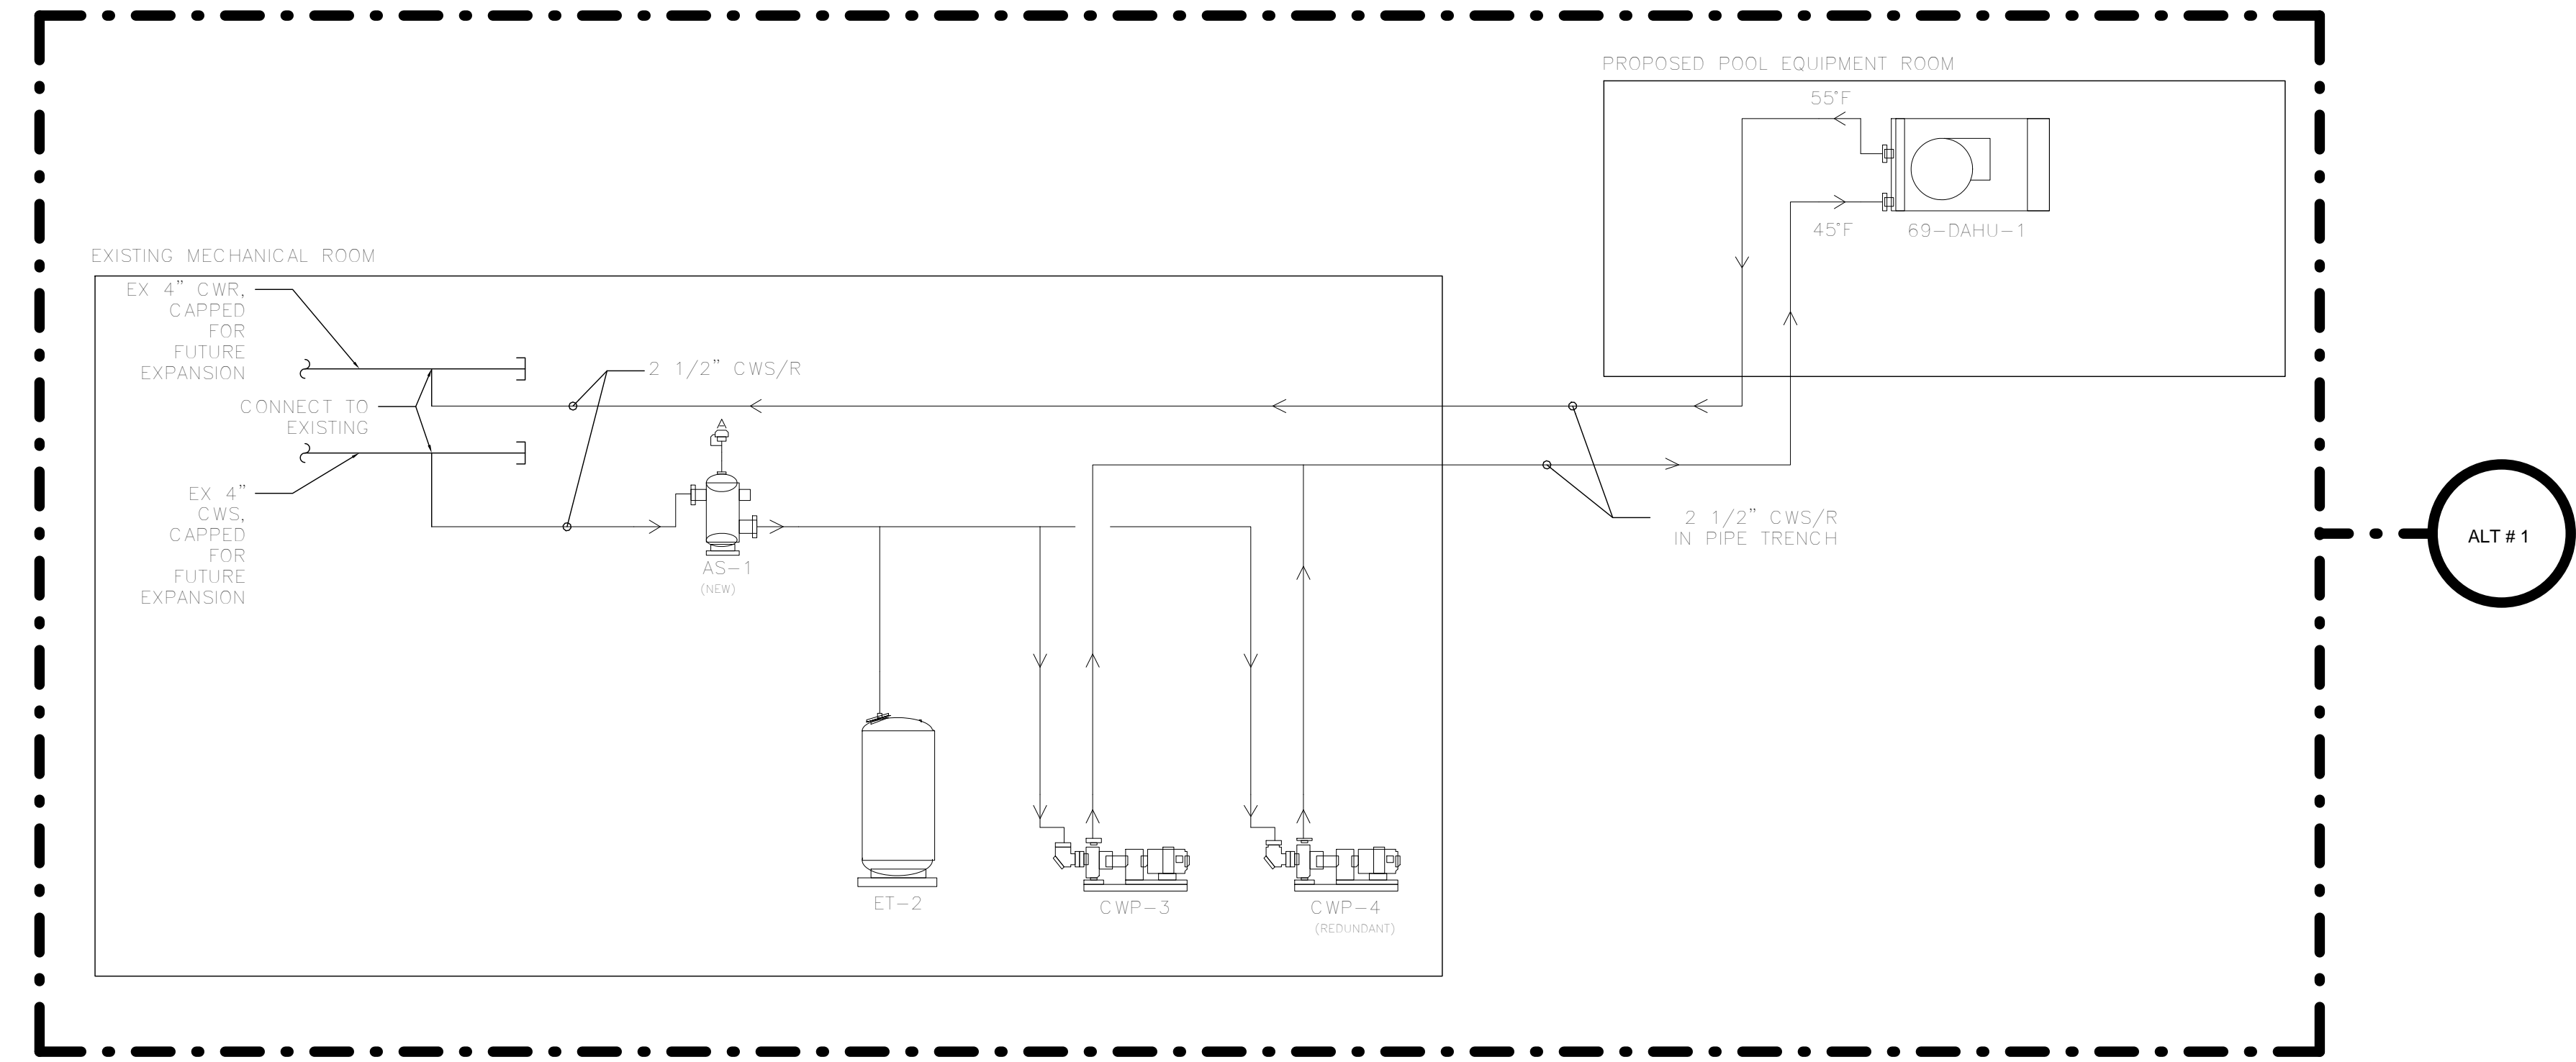

2 POOL COLD WATER SCHEMATIC
3/32" = 1'-0"

CONSULTANTS:

Project Manager
BRAY MOONEY CONSULTING

410 E. 21 STREET
CHESTER, PA. 19013
Tel: (610) 872-3716

Architect
ARRAY HEALTHCARE FACILITIES SOLUTIONS

2520 RENAISSANCE BLVD.,
SUITE 110
KING OF PRUSSIA, PA. 19406
Tel: (610) 270-0599

Structural Engineer
WZG, STRUCTURAL CONSULTING ENGINEERS

P.O. BOX 24
40 LITTLE ROAD
ZIEGLERVILLE, PA. 19402
Tel: (610) 287-5194

MEP/FP Engineer
APOGEE CONSULTING GROUP

7330 CHAPEL HILL ROAD,
SUITE 202
RALEIGH, NC. 27606
Tel: (919) 859-7420

Civil Engineer
GUIDON DESIGN

2453 N DELAWARE STREET
INDIANAPOLIS, IN 46205
Tel: (317) 800-6388

Fire Protection Consultant
HARRINGTON GROUP

7508 E. INDEPENDENCE
BLVD., SUITE 116
CHARLOTTE, NC. 28227
Tel: (704) 531-9077

Cost Estimator

BRAY MOONEY CONSULTING

410 E. 21 STREET
CHESTER, PA. 19013
Tel: (610) 872-3716

Aquatic Consultant

ATLANTIC AQUATIC ENGINEERING

1823 DEEP RUN ROAD
PIPERSVILLE, PA. 18947
Tel: (215) 786-0409

Associate Architects

W. COOK ARCHITECTS

1251 ROMANSVILLE ROAD
COATESVILLE, PA. 19320
Tel: (610) 383-4460

PROJECT MANAGER:



Project Number

3627

Scale

3/32" = 1'-0"

Drawing Title

MECHANICAL DETAILS

Project Title

RENOVATE BUILDING 69

VA Project Number

542-CSI-203

Building Number

69

Drawing Number

MH503

Dwg. 50 of 86

Office of
Facilities
Management

