


NOTES:

1. REFER TO SHEET AS1-101 FOR ARCHITECTURAL GENERAL NOTES.
2. REFER TO ASD SERIES FOR ROOF SLOPE/ DRAINAGE INFORMATION, TYP.

KEY PLAN



PLAN NORTH

PLAN SOUTH

PLAN WEST

PLAN EAST

FULLY SPRINKLERED

CONSULTANTS:

FDZ

HDR Architecture, Inc.

1101 King Street | Suite 400 | Alexandria, Virginia 22314-2944 | 703.518.8500

ARCHITECT/ENGINEERS:

ARCHITECTURE
ENGINEERING
INTERIOR DESIGN
DESIGN/BUILD

ASTORINO

TEL 412 765 1700 FAX 412 765 1711 WWW.ASPECIO.COM

PENTHOUSE ROOF PLAN - AREA A

Approved: Project Director

**VA CARES CONSOLIDATION
VAMC, PITTSBURGH, PA
CONSOLIDATION BUILDING**

CONSOLIDATION BUILDING

GONSO

CONSOLIDA

CONSOLIDA

CONSOLIDA

CONSOLIDA



CONSOLIDA

CONSOLIDA


CONSOLIDA

Office of Facilities Management





Department of
Veterans Affairs

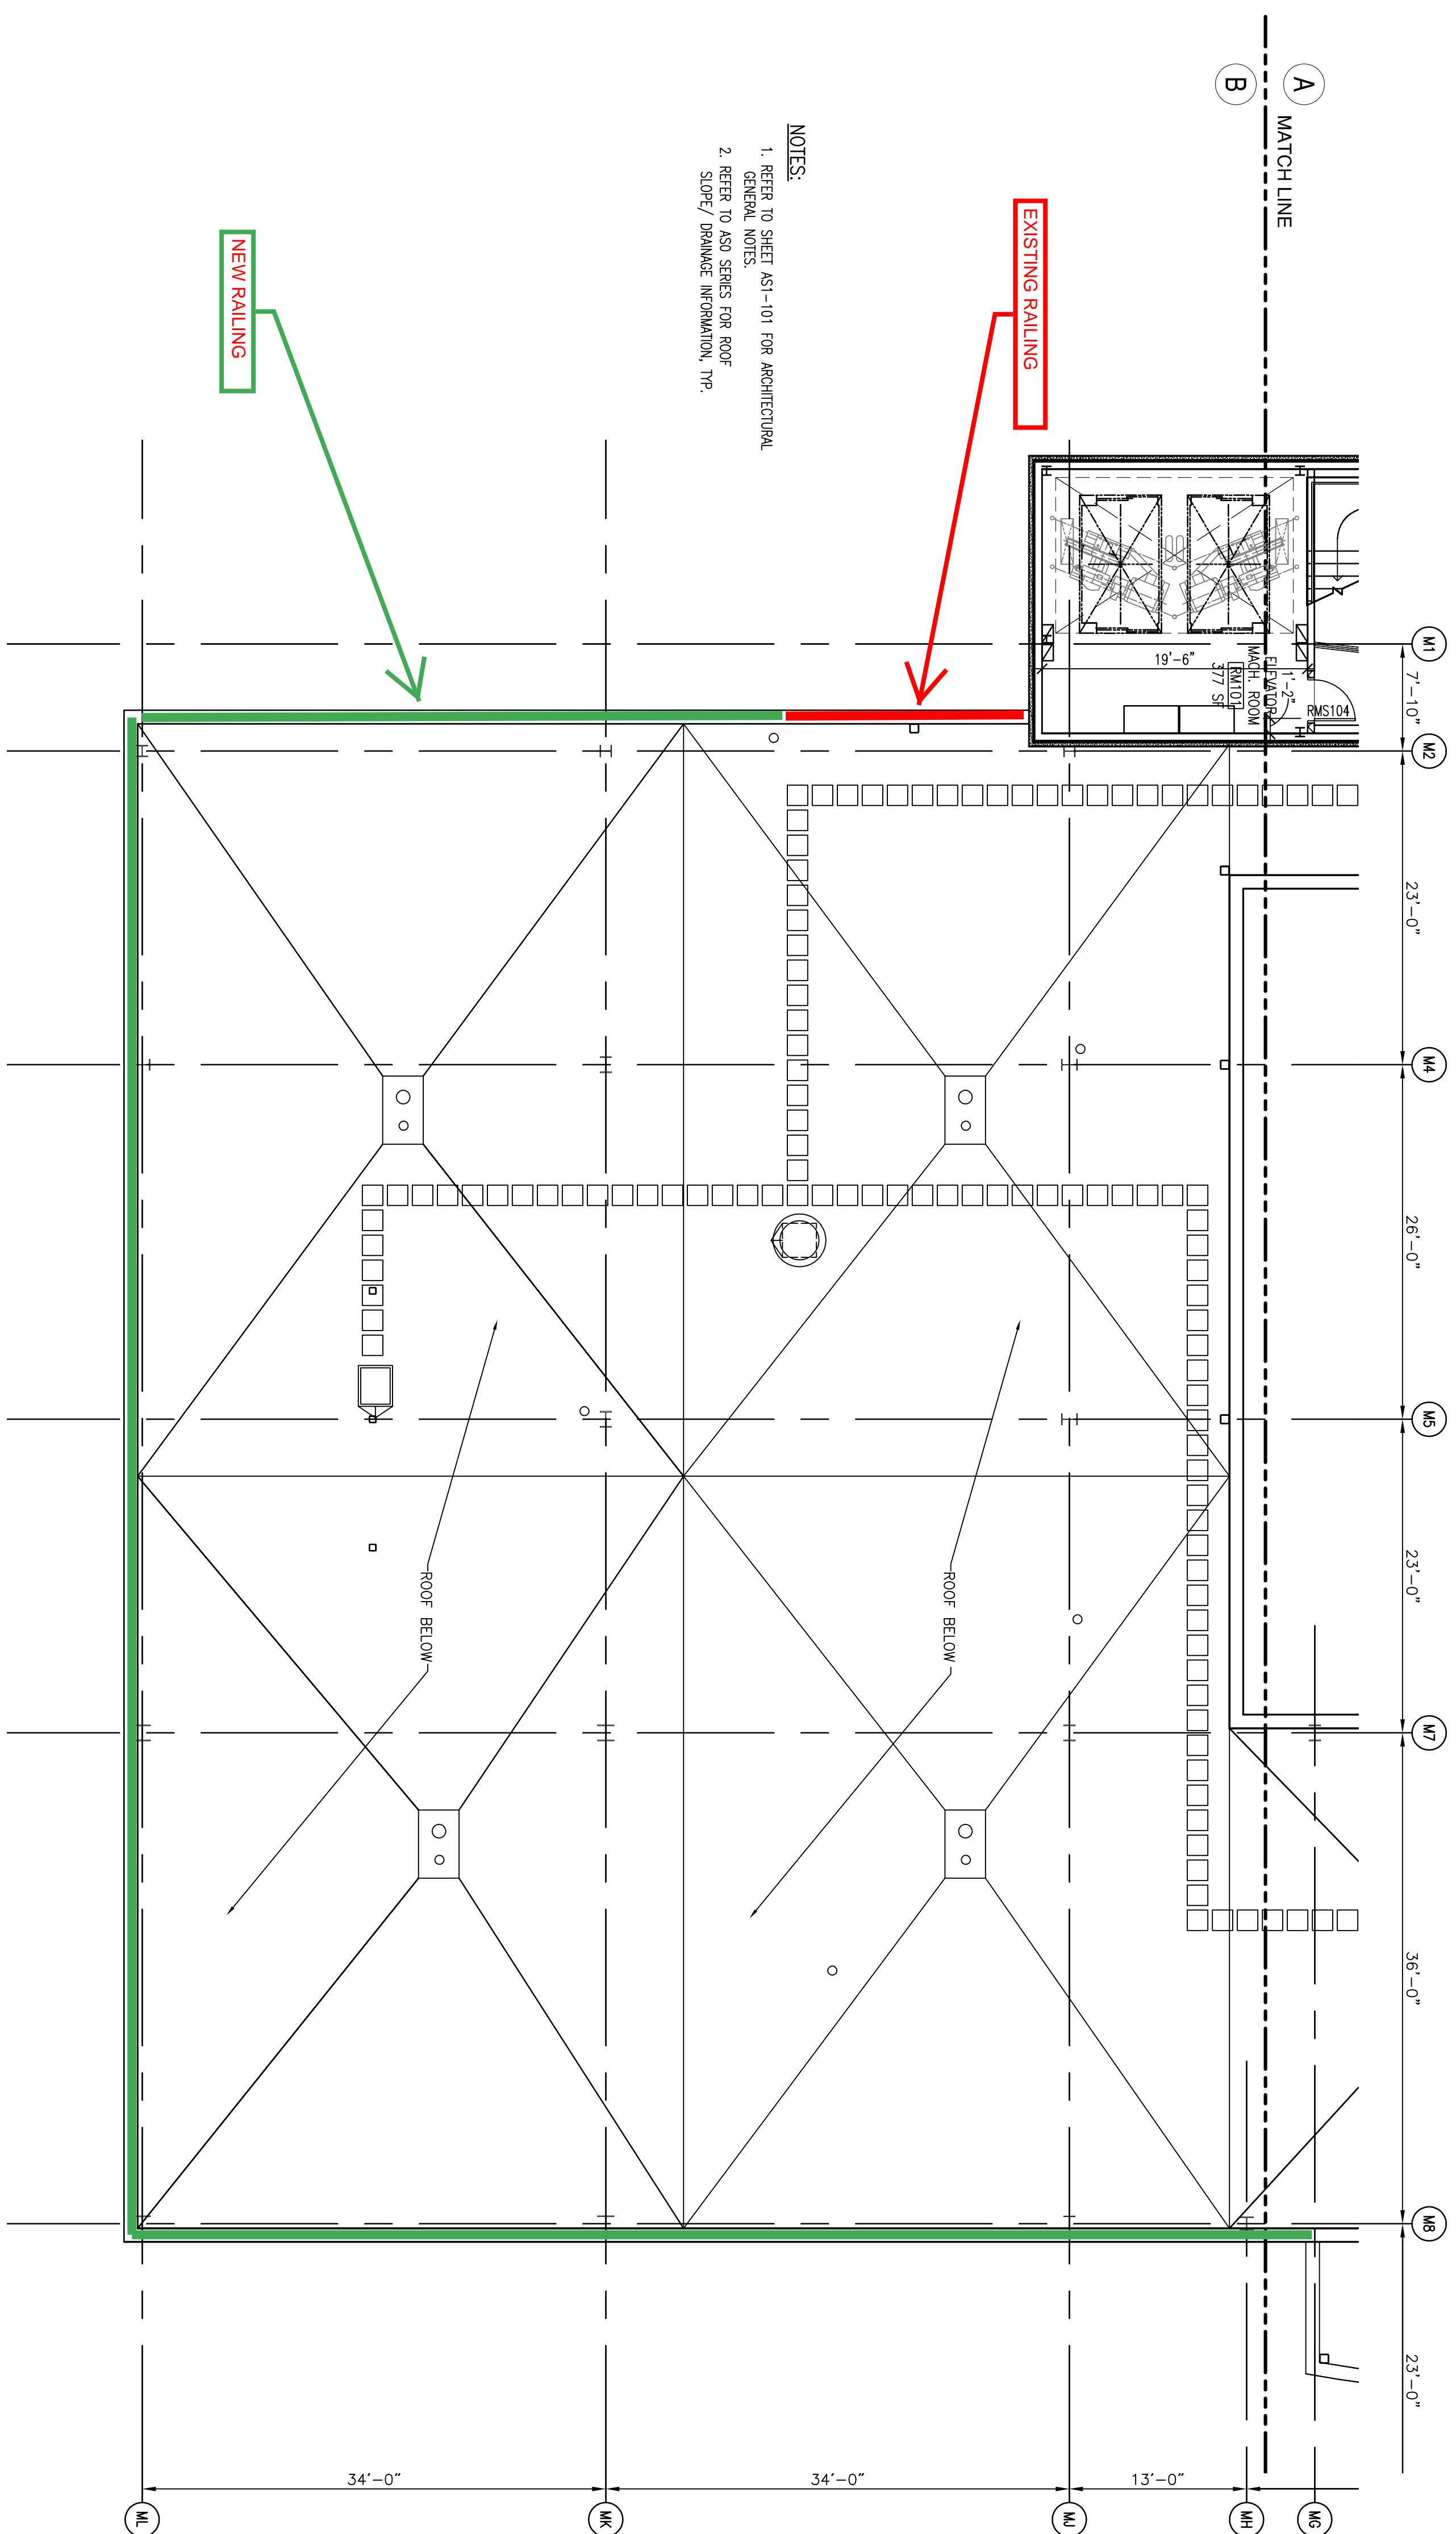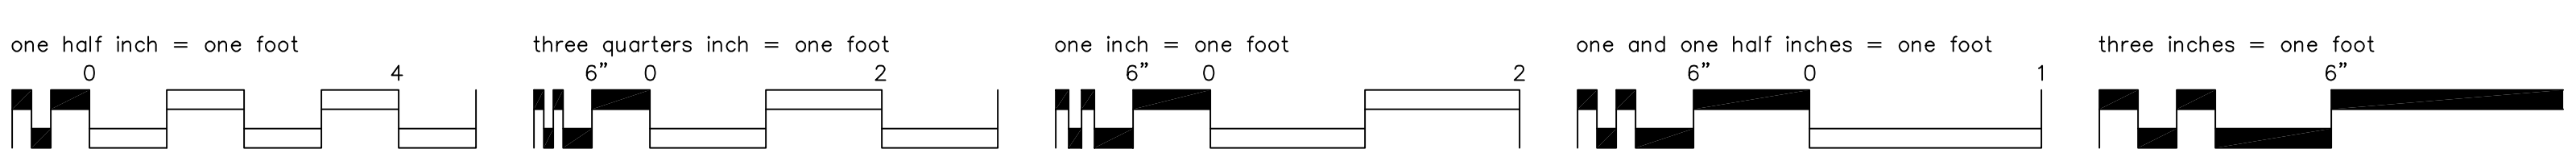


1 PENTHOUSE ROOF PLAN - AREA B
1/8" = 1'-0"

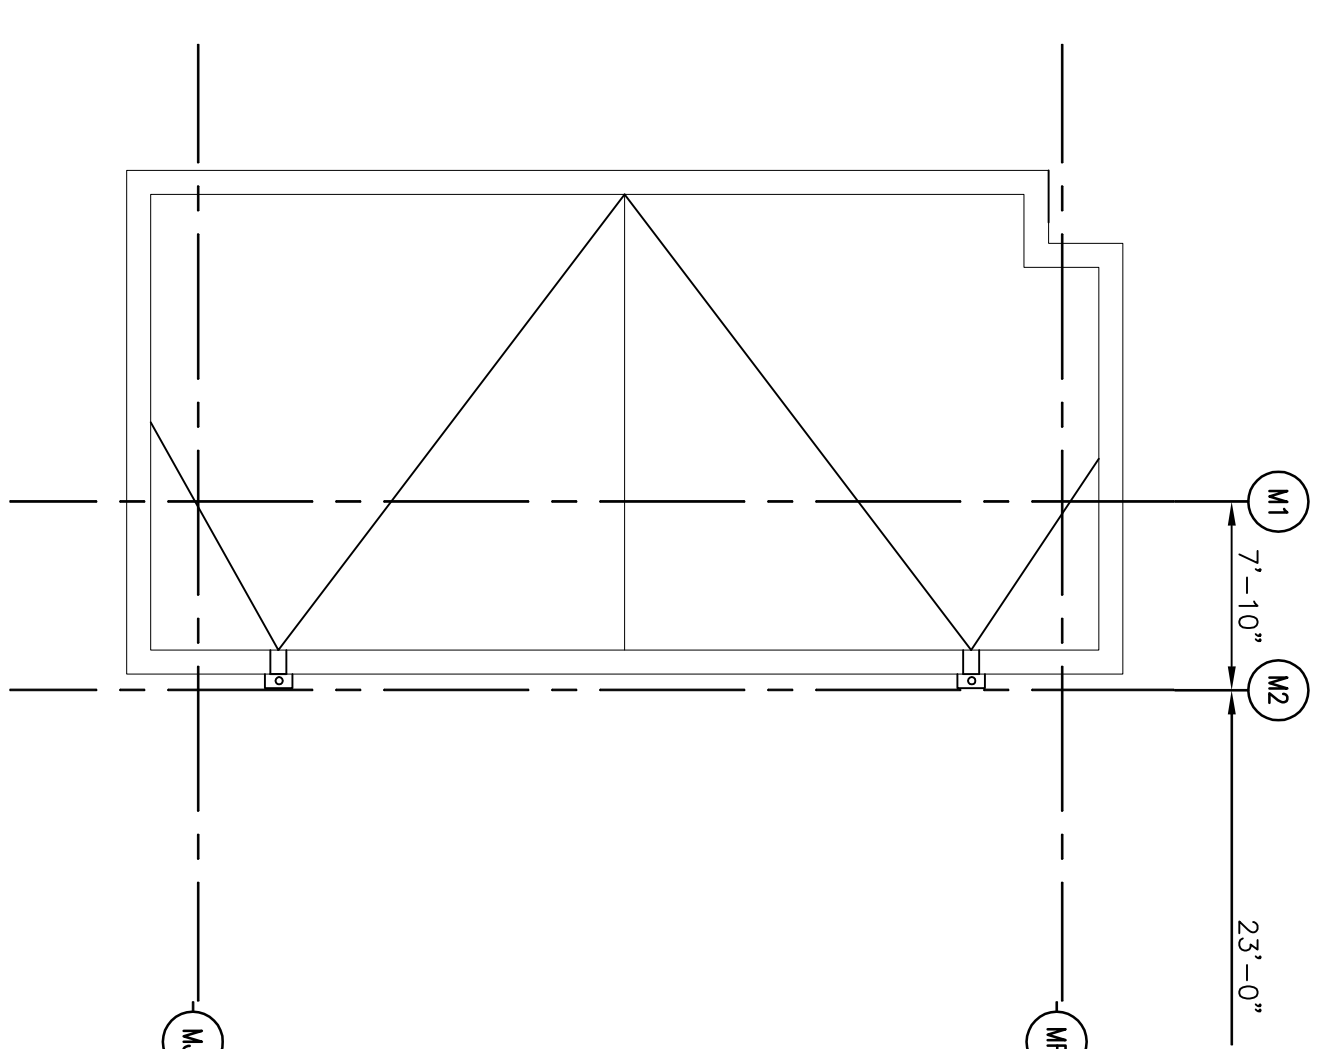

2 ROOF PLAN AREA B
ELEVATOR/ MACHINE ROOM ROOF
1/8" = 1'-0"

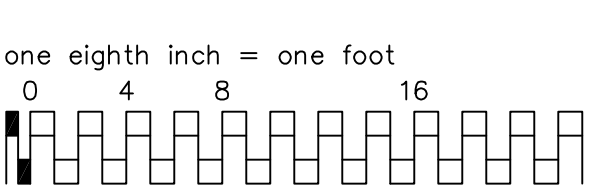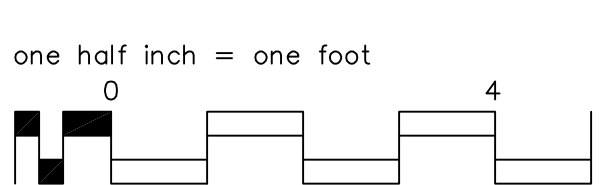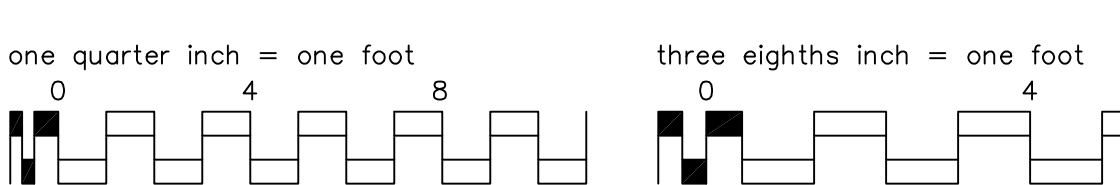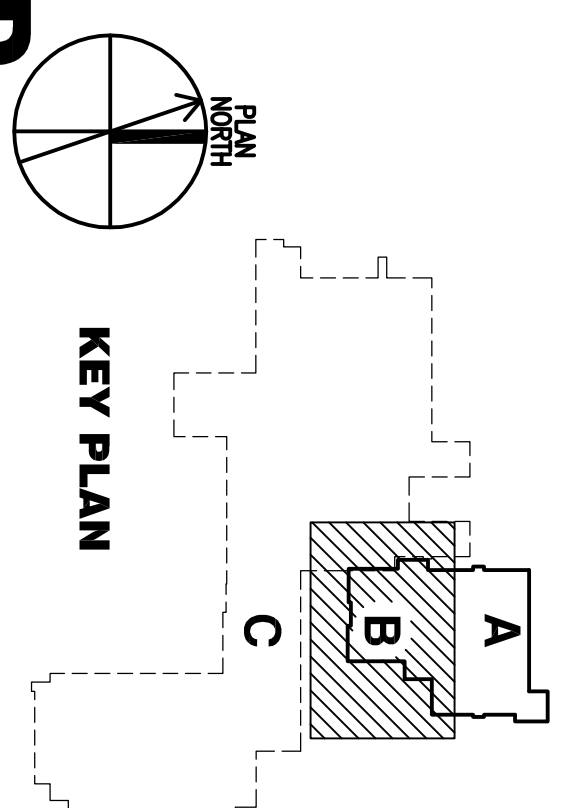[illegible]

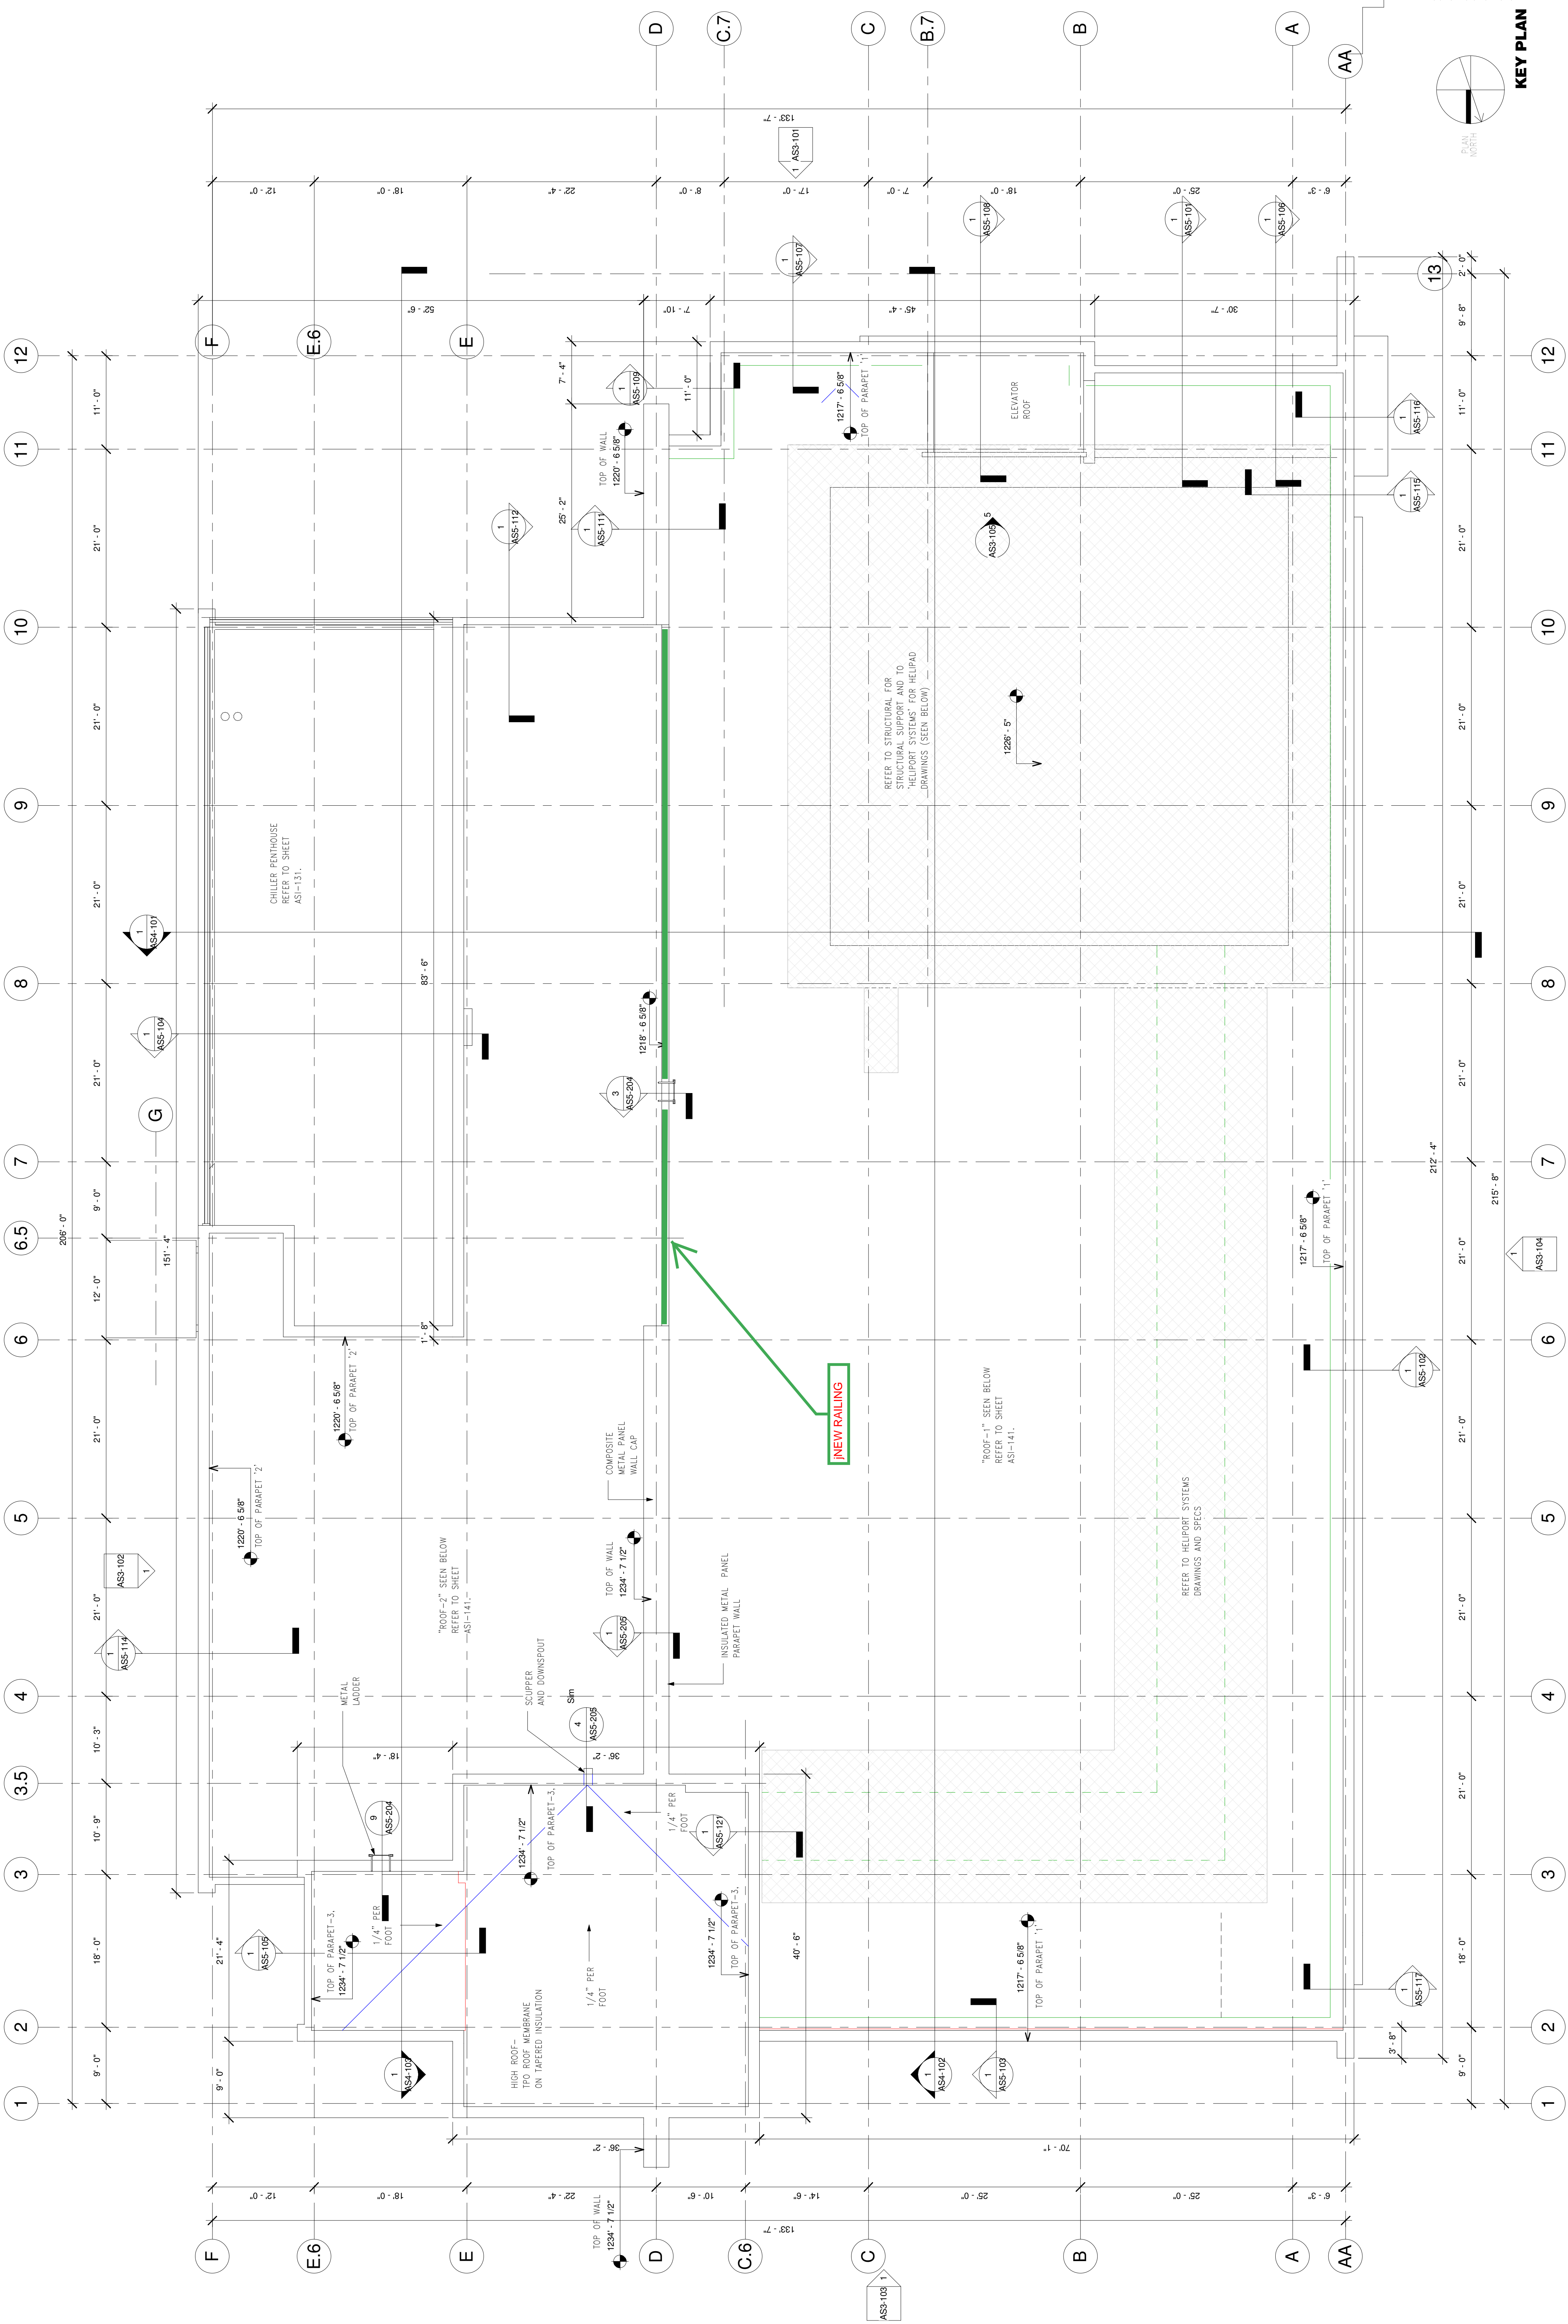

1 HIGH ROOF
1 7/8" = 1'-0"

[illegible]

CONSULTANTS:	HDR	HDR Architecture, Inc.	1101 King Street, Suite 400, Alexandria, Virginia 22314-2944
---------------------	------------	-------------------------------	--

[illegible]

--	--

ARCHITECT/ENGINEER

LINEERS:


E
G
N
N
D

ASTORINO

105 Via F.lli. D'Adda - 20145 Milano - Tel. 02/58 11 22 33
Tel. 02/58 11 22 30 - FAX 02/58 11 22 31 - www.astorino.it

Drawing Title	HIGH ROOF PLAN
Approved: Project Director	

Project Title	VA CARES CONSOLIDATION VAMC, PITTSBURGH, PA, RESEARCH OFFICE BLDG		
Location	VAPHS UNIVERSITY DRIVE		
Date	08-18-2010	Checked Checker	Drawn Author

Office of Facilities Management		Department of Veterans Affairs
		
Project Number 646CA2500R	Building Number 30	Dwg. of
Drawing Number AS1-142		

VA FORM 08-6231, OCT 1978

1

1

1

1

1

1

1