


- NOTES**
1. REFER TO SPECIFICATION SECTION 010000 FOR REQUIREMENTS REGARDING PRE-CONSTRUCTION INVESTIGATION PRIOR TO COMMENCEMENT OF WORK. CONTRACTOR TO CONDUCT A COMPLETE SURVEY OF EVERY FIRE PROTECTION SPRINKLER HEAD TO ASSESS EACH HEAD'S CONDITION AND VIABILITY.
 2. UPON COMPLETION OF THE ABOVE SURVEY, THE VAMC COR SHALL DESIGNATE UP TO 2,400 HEADS TO BE REPLACED/REWORKED BY THE CONTRACTOR UNDER THIS CONTRACT.
 3. THE 2,400 HEADS DESIGNATED BY THE VAMC COR LISTED ABOVE ARE IN ADDITION TO ANY SPECIFIC ITEMS INDICATED ON THIS SHEET.

KEYED NOTES

- ① INSTALL A SPRINKLER HEADS IN ROOM GD04 PER CODE NFPA13 AS NONE EXIST.
- ② REWORK EXISTING FIRE SPRINKLER HEAD AND PIPING PER CODE NFPA13 IN ROOM GA09 TO INCLUDE UNDER OBSTRUCTIONS OVER 48" A.F.F. VERIFY DEFLECTOR POSITIONS.


LEGEND

AREA APPLIED TO THIS PORTION OF PROJECT

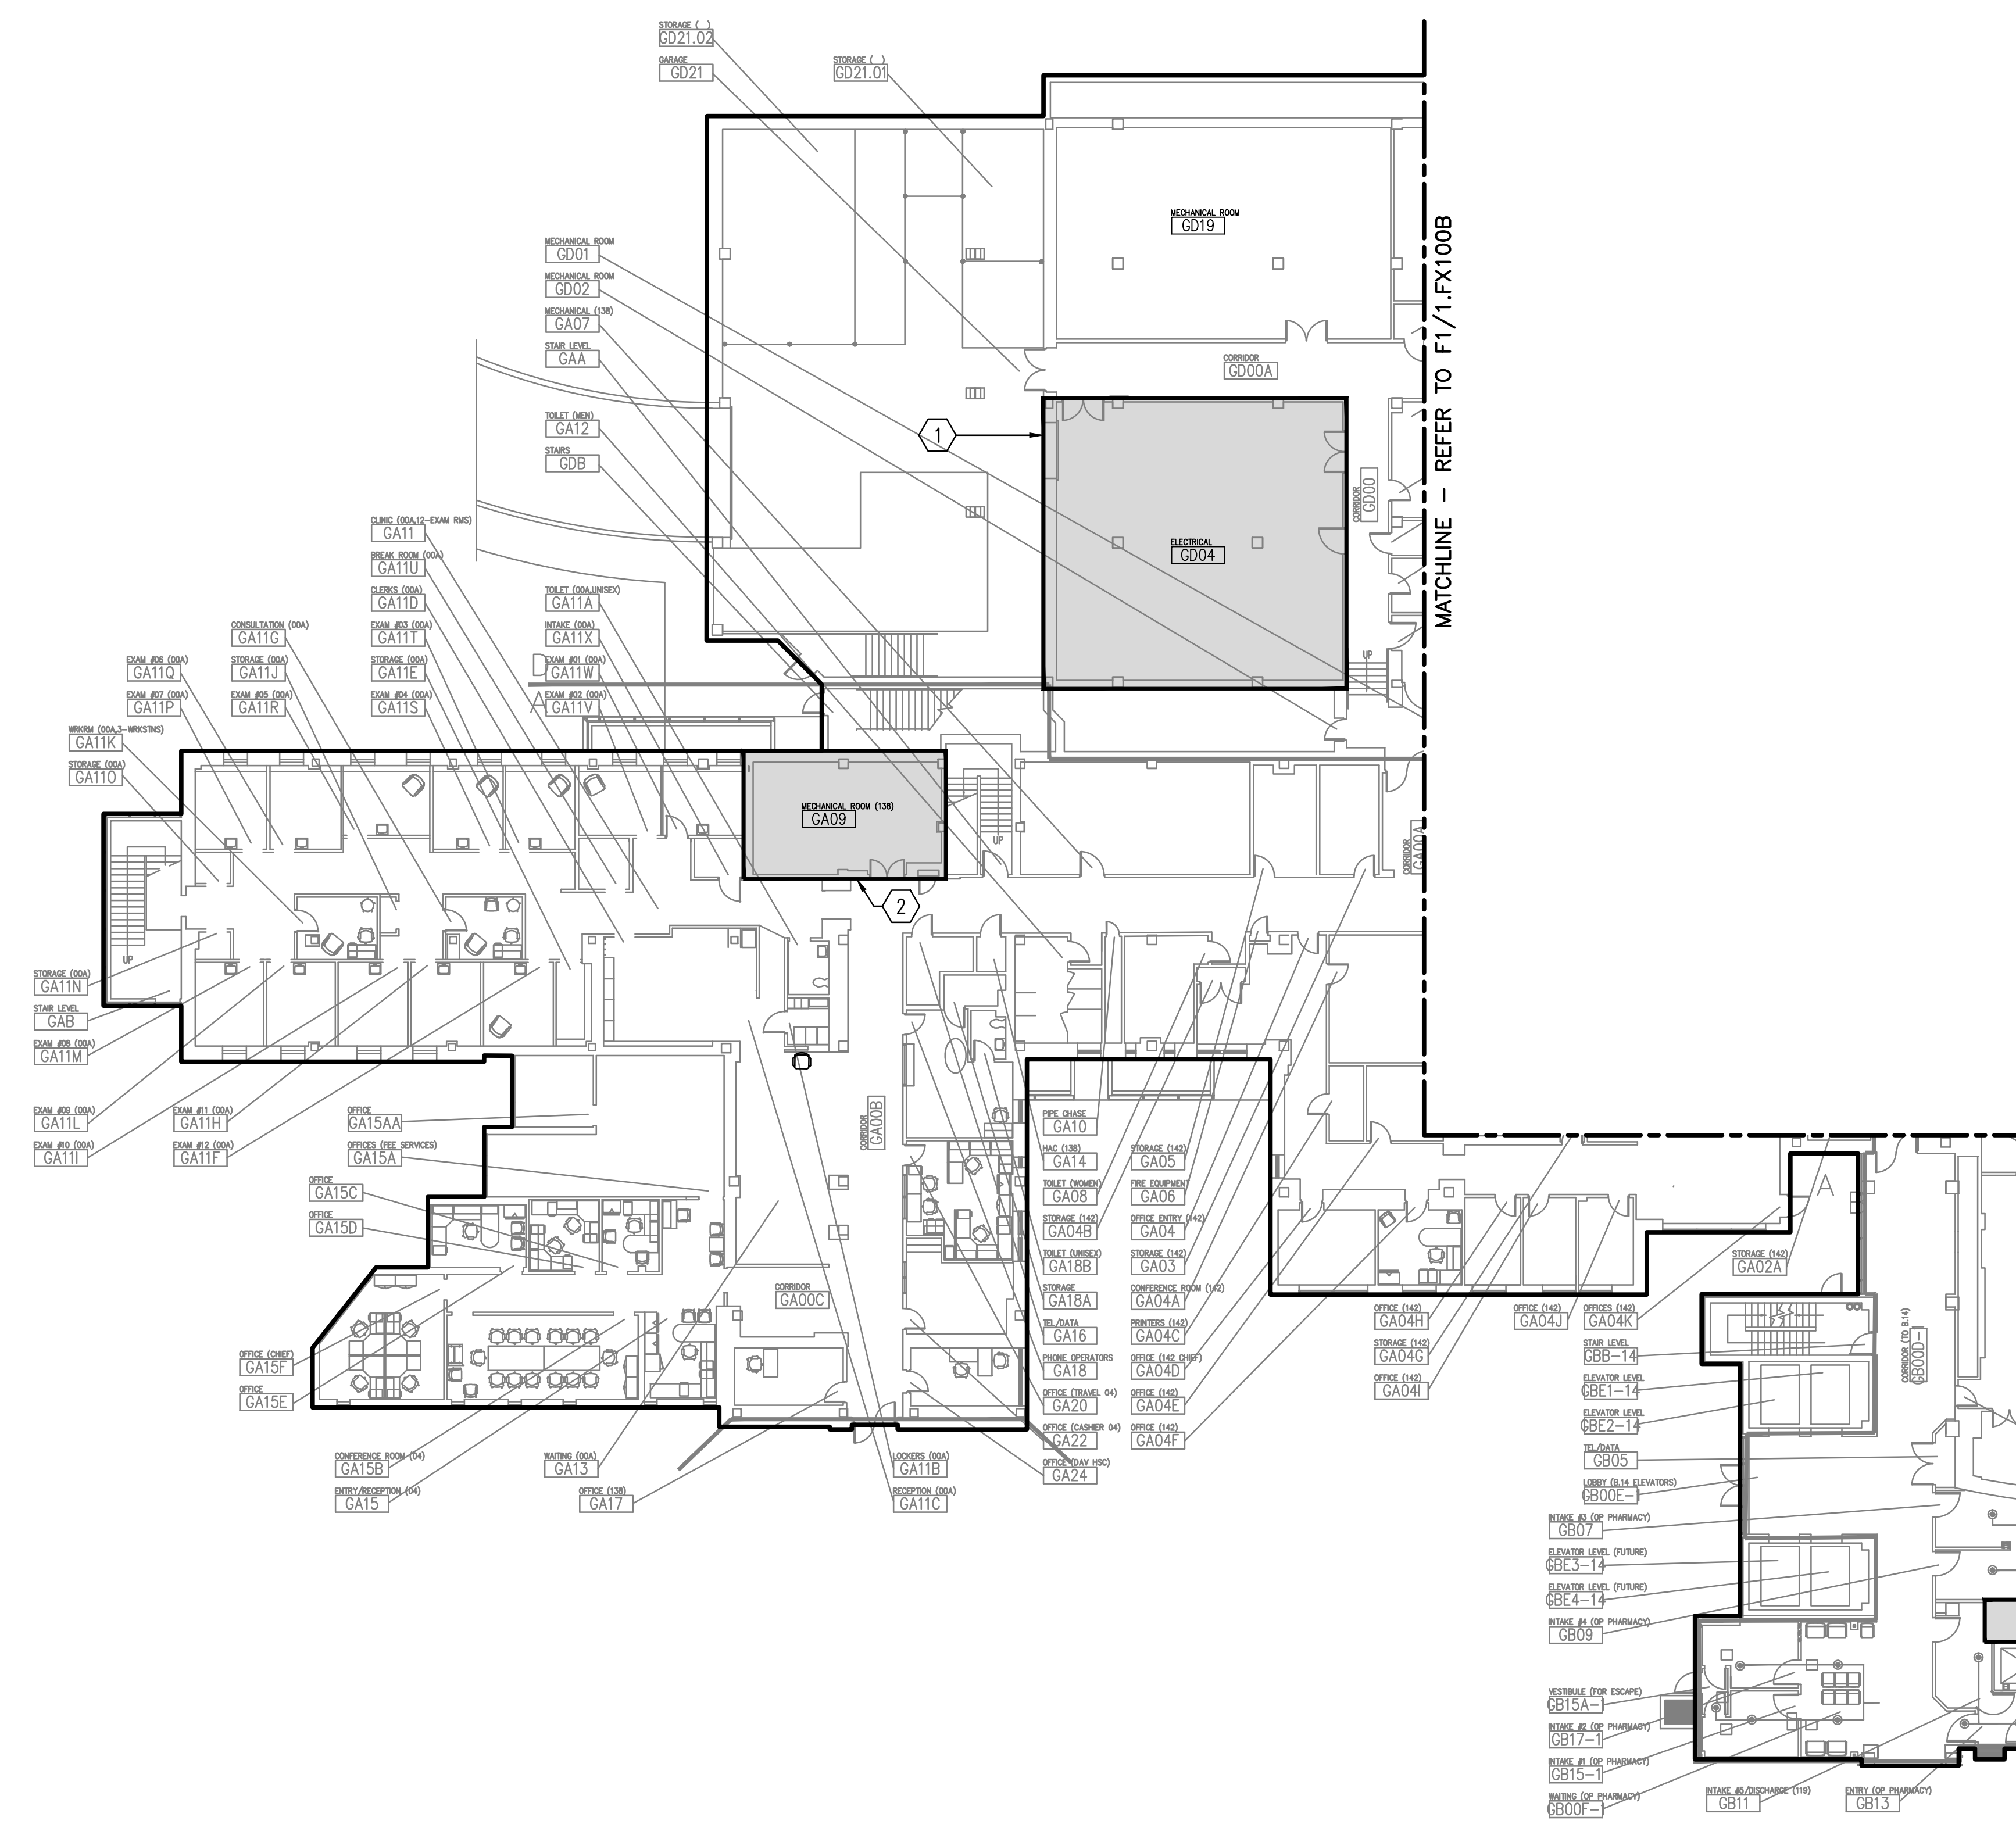

MATCHLINE - REFER TO F1/1.FX100B

GENERAL NOTE:
ALL EXISTING PIPING, DUCTWORK, SPRINKLERS, CONDUIT, LIGHTING OR OTHER CONSTRUCTION SHALL BE RELOCATED AS NECESSARY FOR ALL DEMOLITION AND INSTALLATION WORK.

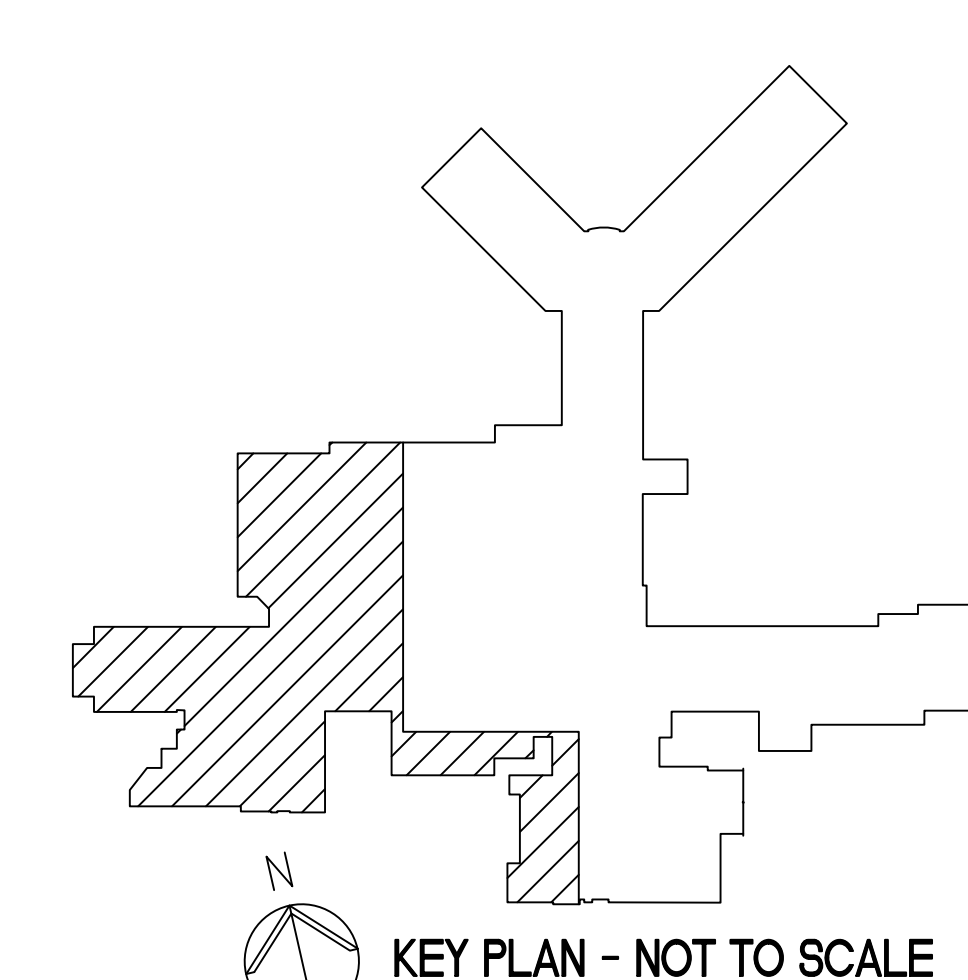

KEY PLAN - NOT TO SCALE

FULLY SPRINKLERED
BID DOCUMENTS
FOR CONSTRUCTION

Office of
Construction
and Facilities
Management

 Department of
Veterans Affairs

F1 PARTIAL FLOOR PLAN
1/16" = 1'-0"

			ARCHITECT/ENGINEERS:		Drawing Title: FIRE PROTECTION PLAN - GROUND FLOOR BUILDING 1 WEST	Project Title: FIRE SAFETY UPGRADES	Project Number: 660-14-104	Office of Construction and Facilities Management
			<div>PARADIGM ENGINEERS AND CONSTRUCTORS</div> <div>200 Envoy Circle #201, Louisville KY 40299 ~ PH: 502.339.8511 ~ www.paradigmusa.com</div>		Approved Project Director	Location: GEORGE E WAHLEN VAMC 500 FOOTHILL DR SALT LAKE CITY, UT	Building Number: 1	
AMENDMENT #3	5/20/14				Date: 12-18-2013	Checked: KLP	Drawn: JDM	<div>Department of Veterans Affairs</div>
Revisions:	Date							