


three inches = one foot
one and one half inches = one foot
one inch = one foot
three quarters inch = one foot
one half inch = one foot
three eighths inch = one foot
one quarter inch = one foot
one eighth inch = one foot

- NOTES**
1. REFER TO SPECIFICATION SECTION 010000 FOR REQUIREMENTS REGARDING PRE-CONSTRUCTION INVESTIGATION PRIOR TO COMMENCEMENT OF WORK. CONTRACTOR TO CONDUCT A COMPLETE SURVEY OF EVERY FIRE PROTECTION SPRINKLER HEAD TO ASSESS EACH HEAD'S CONDITION AND VIABILITY.
 2. UPON COMPLETION OF THE ABOVE SURVEY, THE VAMC COR SHALL DESIGNATE UP TO 2,400 HEADS TO BE REPLACED/REWORKED BY THE CONTRACTOR UNDER THIS CONTRACT.
 3. THE 2,400 HEADS DESIGNATED BY THE VAMC COR LISTED ABOVE ARE IN ADDITION TO ANY SPECIFIC ITEMS INDICATED ON THIS SHEET.

- KEYED NOTES**
- 1 INSTALL A SPRINKLER HEAD IN ROOM 1D04A PER CODE NFPA13 AS ONE DOES NOT EXIST. REFER TO PHOTO A2/1.FX601.
 - 2 REWORK EXISTING FIRE SPRINKLER HEAD AND PIPING PER CODE IN ROOM 1A19B. REFER TO PHOTO A4/1.FX601.

LEGEND


AREA APPLIED TO THIS PORTION OF PROJECT

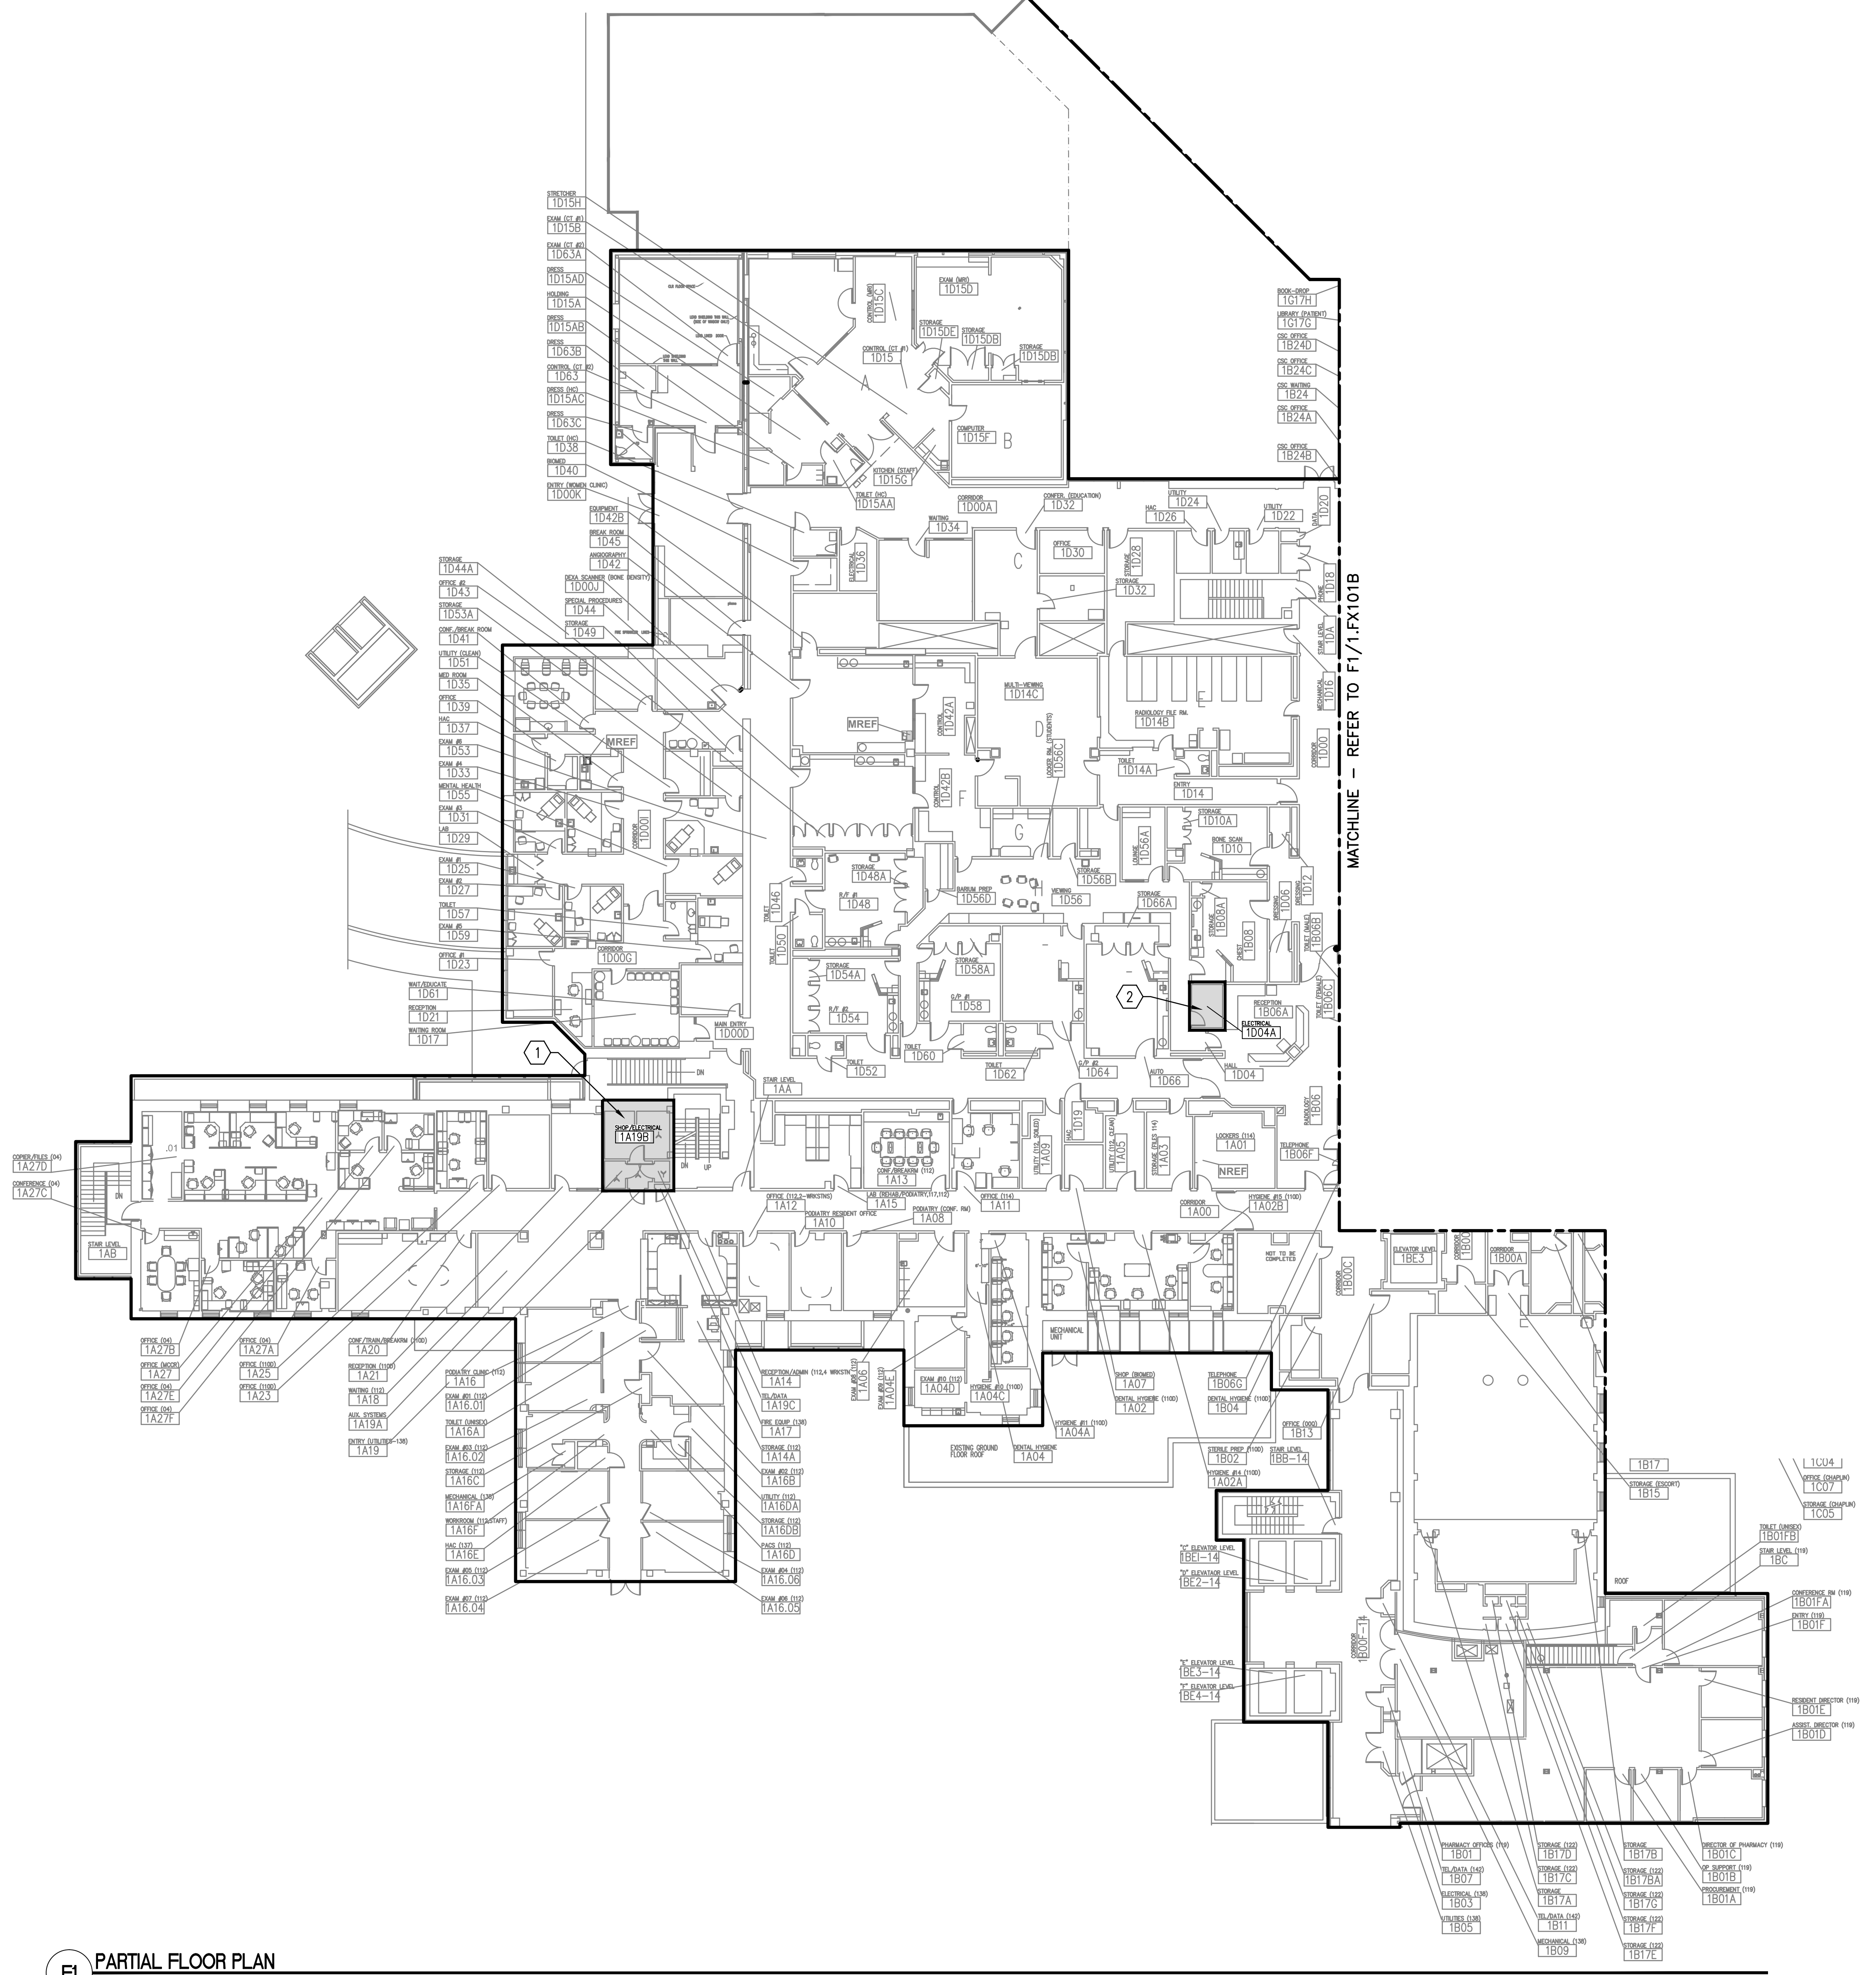

MATCHLINE - REFER TO F1/1.FX101B

F1 PARTIAL FLOOR PLAN
1/16" = 1'-0"

GENERAL NOTE:
ALL EXISTING PIPING, DUCTWORK, SPRINKLERS, CONDUIT, LIGHTING OR OTHER CONSTRUCTION SHALL BE RELOCATED AS NECESSARY FOR ALL DEMOLITION AND INSTALLATION WORK.

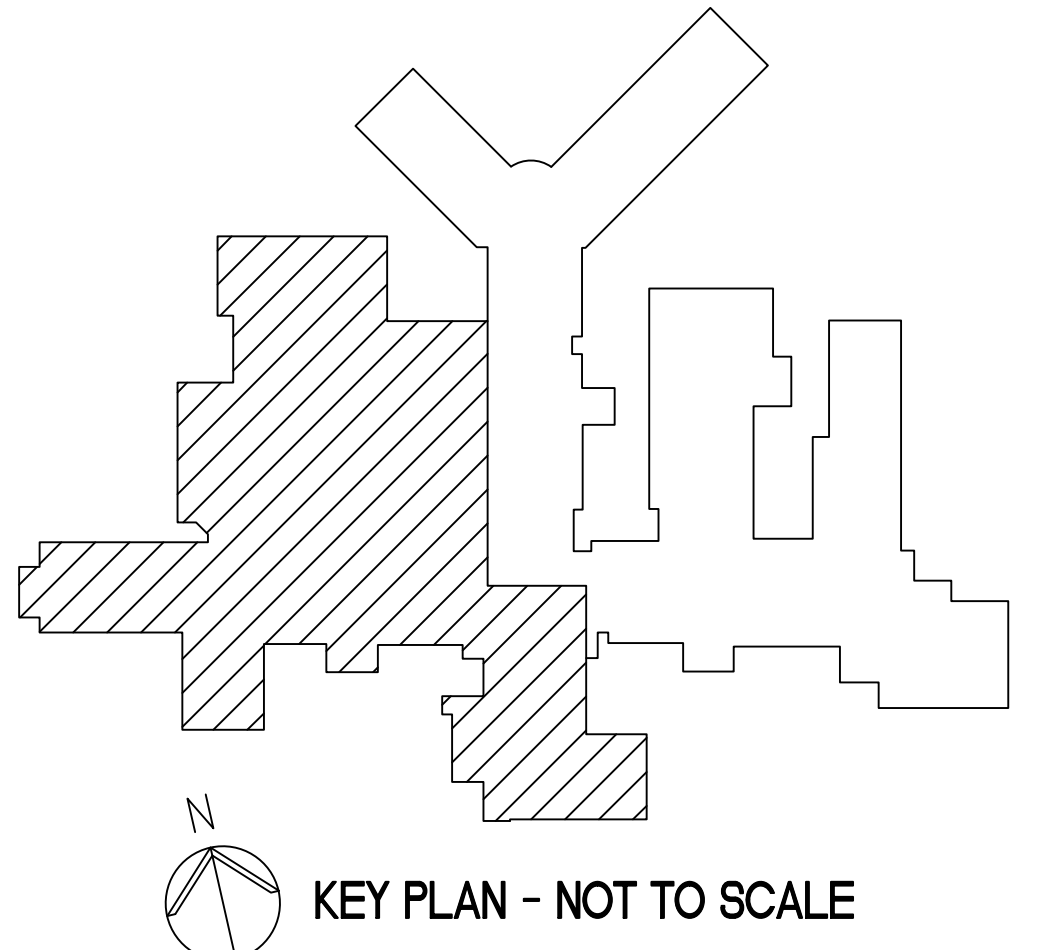

KEY PLAN - NOT TO SCALE

FULLY SPRINKLERED
BID DOCUMENTS
FOR CONSTRUCTION

Office of
Construction
and Facilities
Management
Department of
Veterans Affairs

AMENDMENT #3 Revisions		5/20/14 Date	ARCHITECT/ENGINEERS: PARADIGM ENGINEERS AND CONSTRUCTORS 200 Envoy Circle #201, Louisville KY 40299 - PH: 502.339.8511 - www.paradigmusa.com		Drawing Title: FIRE PROTECTION PLAN - FIRST FLOOR BUILDING 1 WEST		Project Title: FIRE SAFETY UPGRADES		Project Number: 660-14-104 Building Number: 1		Office of Construction and Facilities Management Department of Veterans Affairs	
Approved Project Director							Location: GEORGE E WAHLEN VAMC 500 Foothill Dr. SALT LAKE CITY, UT		Drawing Number: 1.FX101A			
Date: 12-19-2013		Checked: KLP	Drawn: JDM									