


three inches = one foot  
one and one half inches = one foot  
one inch = one foot  
three quarters inch = one foot  
one half inch = one foot  
three eighths inch = one foot  
one quarter inch = one foot  
one eighth inch = one foot

- NOTES**
1. REFER TO SPECIFICATION SECTION 010000 FOR REQUIREMENTS REGARDING PRE-CONSTRUCTION INVESTIGATION PRIOR TO COMMENCEMENT OF WORK. CONTRACTOR TO CONDUCT A COMPLETE SURVEY OF EVERY FIRE PROTECTION SPRINKLER HEAD TO ASSESS EACH HEAD'S CONDITION AND VIABILITY.
  2. UPON COMPLETION OF THE ABOVE SURVEY, THE VAMC COR SHALL DESIGNATE UP TO 2,400 HEADS TO BE REPLACED/REWORKED BY THE CONTRACTOR UNDER THIS CONTRACT.
  3. THE 2,400 HEADS DESIGNATED BY THE VAMC COR LISTED ABOVE ARE IN ADDITION TO ANY SPECIFIC ITEMS INDICATED ON THIS SHEET.

- KEYED NOTES**
- 1 CORRECT SPRINKLER HEAD SPACING/PLACEMENT TO COMPLY WITH CODE IN ROOMS 2A15B AND 2EAA. ADD AND/OR RESPACE AND RELOCATE HEADS AS REQUIRED.
  - 2 INSTALL ADDITIONAL FIRE PROTECTION SPRINKLER HEAD(S) IN ROOMS 2B05 AND 2C20A AND MODIFY/RESpace/RELOCATE EXISTING HEAD(S) TO MEET CODE.
  - 3 INSTALL ADDITIONAL FIRE PROTECTION SPRINKLER HEAD(S) IN ROOM 2D03 AND MODIFY/RESpace/RELOCATE EXISTING HEAD(S) TO MEET CODE. ADDITIONAL FIRE PROTECTION SPRINKLERS TO AREA BLOCKED OFF.


**LEGEND**

AREA APPLIED TO THIS PORTION OF PROJECT

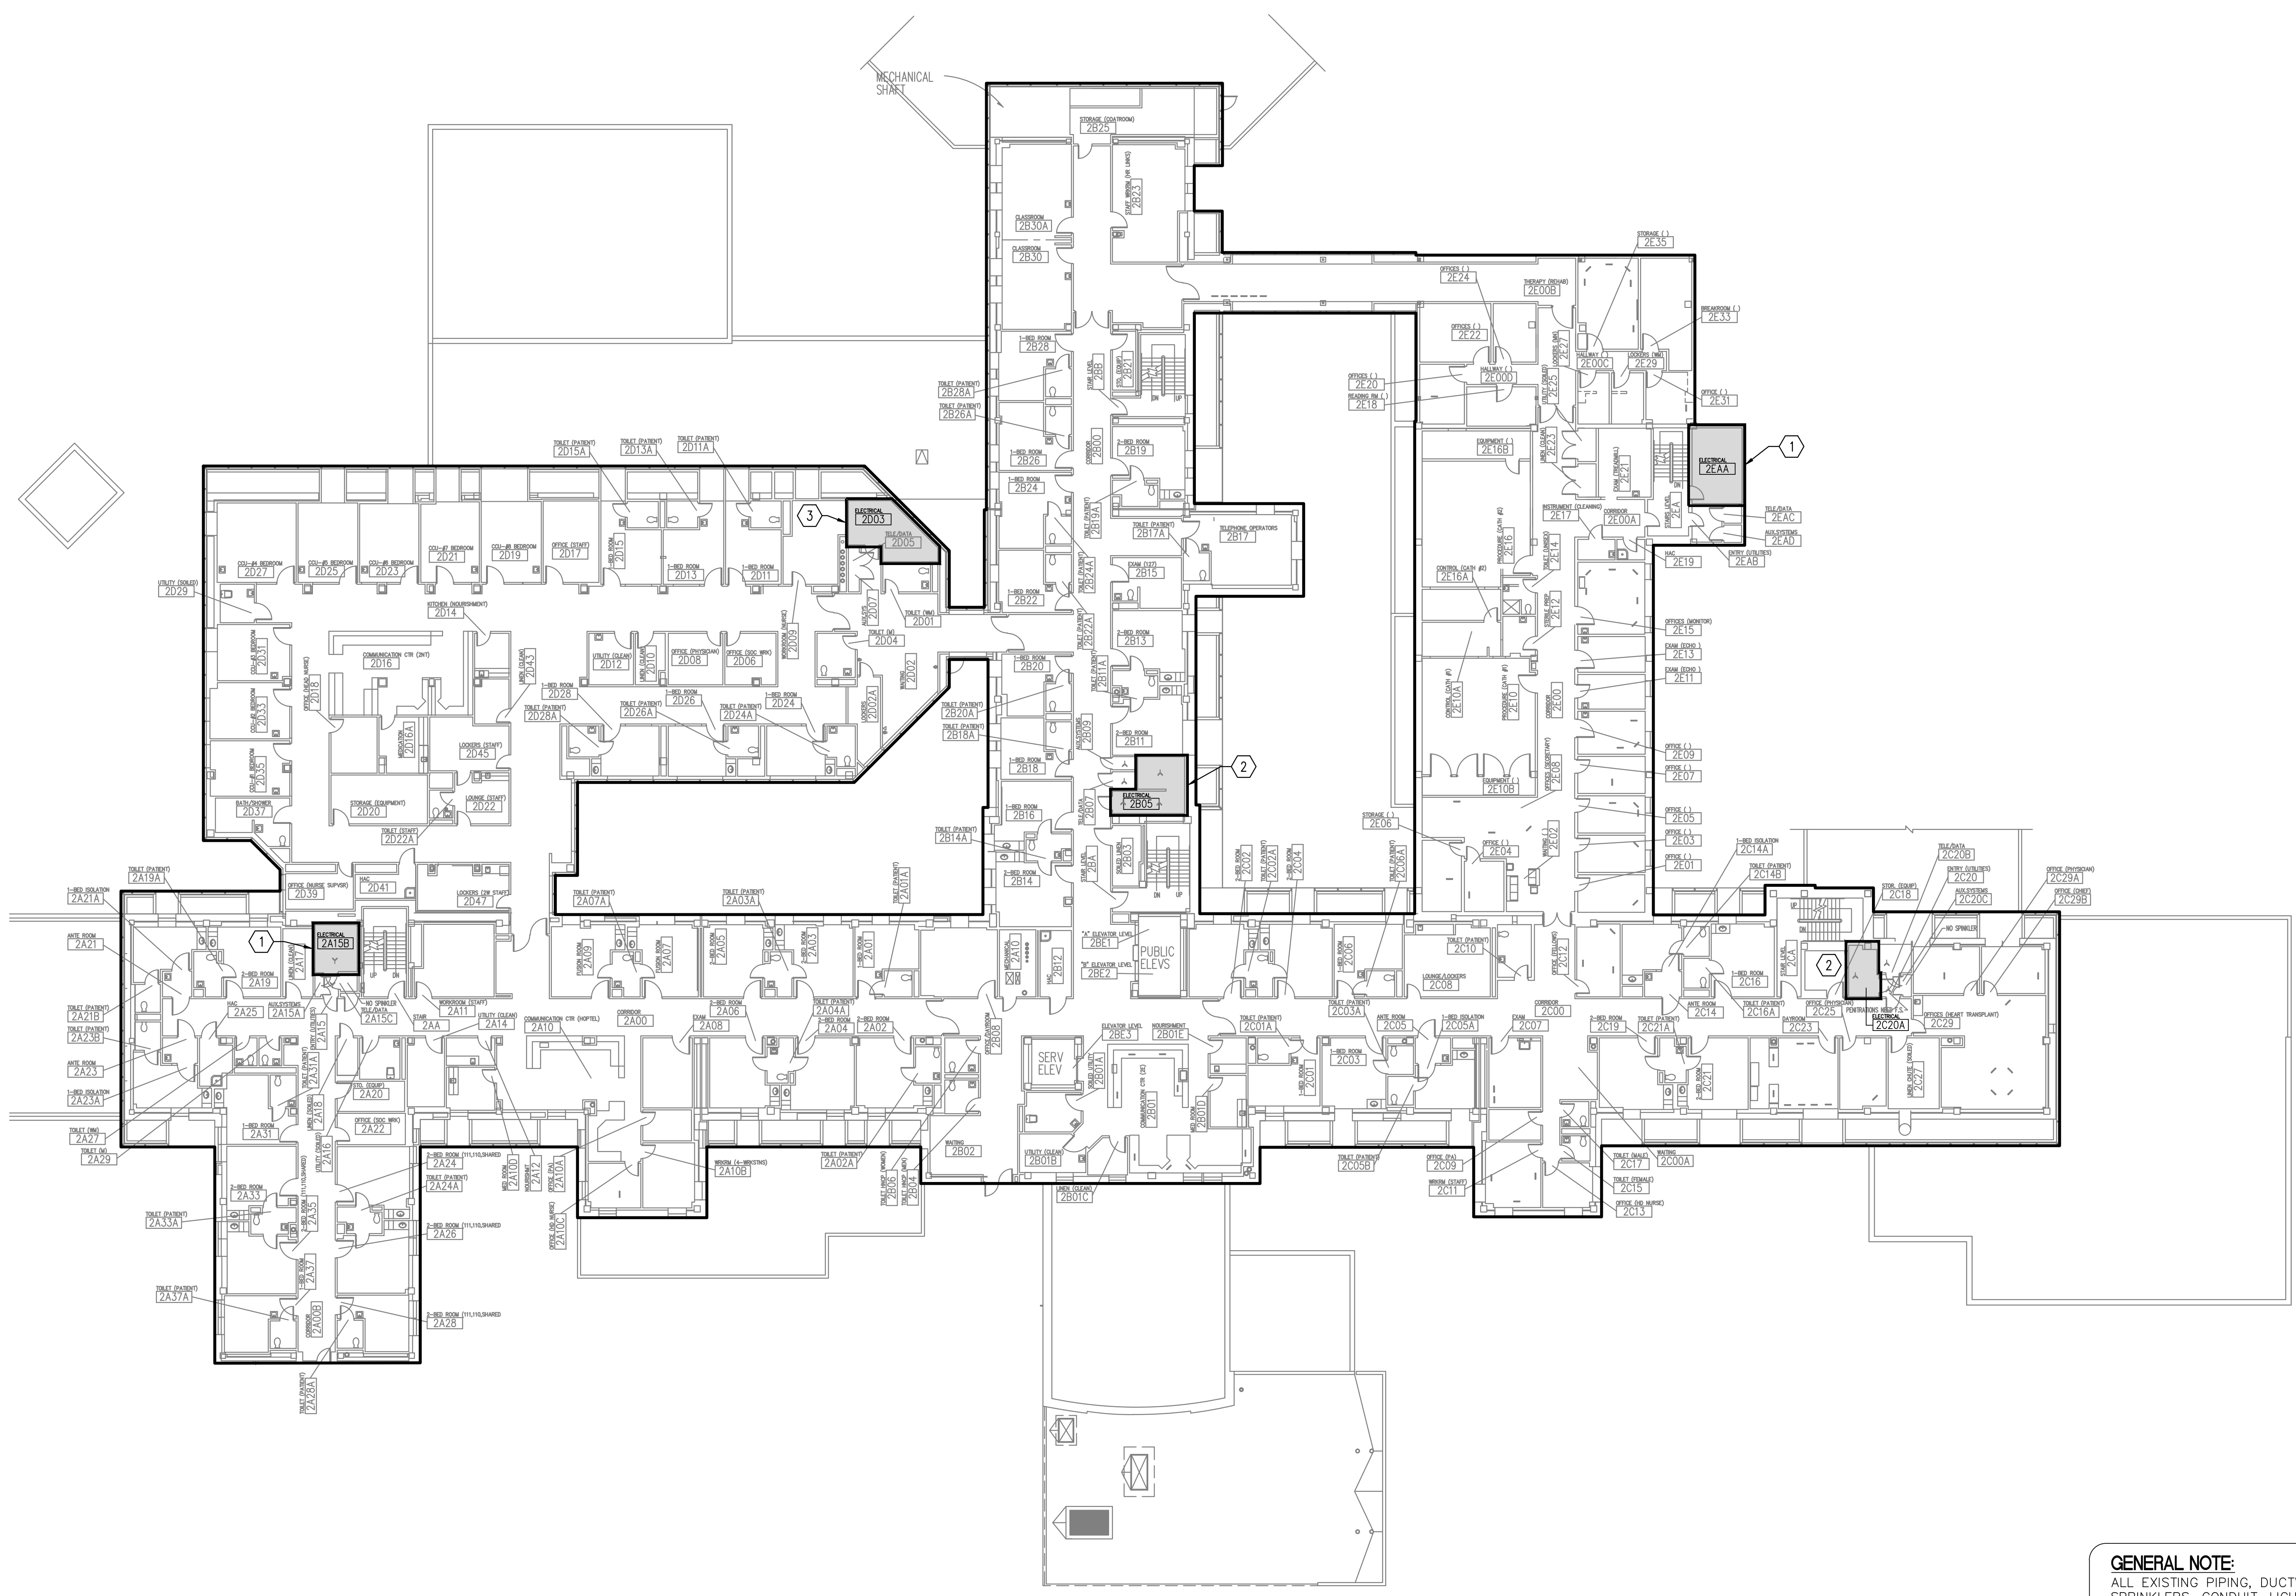

**F1 FLOOR PLAN**  
1/16" = 1'-0"

**GENERAL NOTE:**  
ALL EXISTING PIPING, DUCTWORK, SPRINKLERS, CONDUIT, LIGHTING OR OTHER CONSTRUCTION SHALL BE RELOCATED AS NECESSARY FOR ALL DEMOLITION AND INSTALLATION WORK.

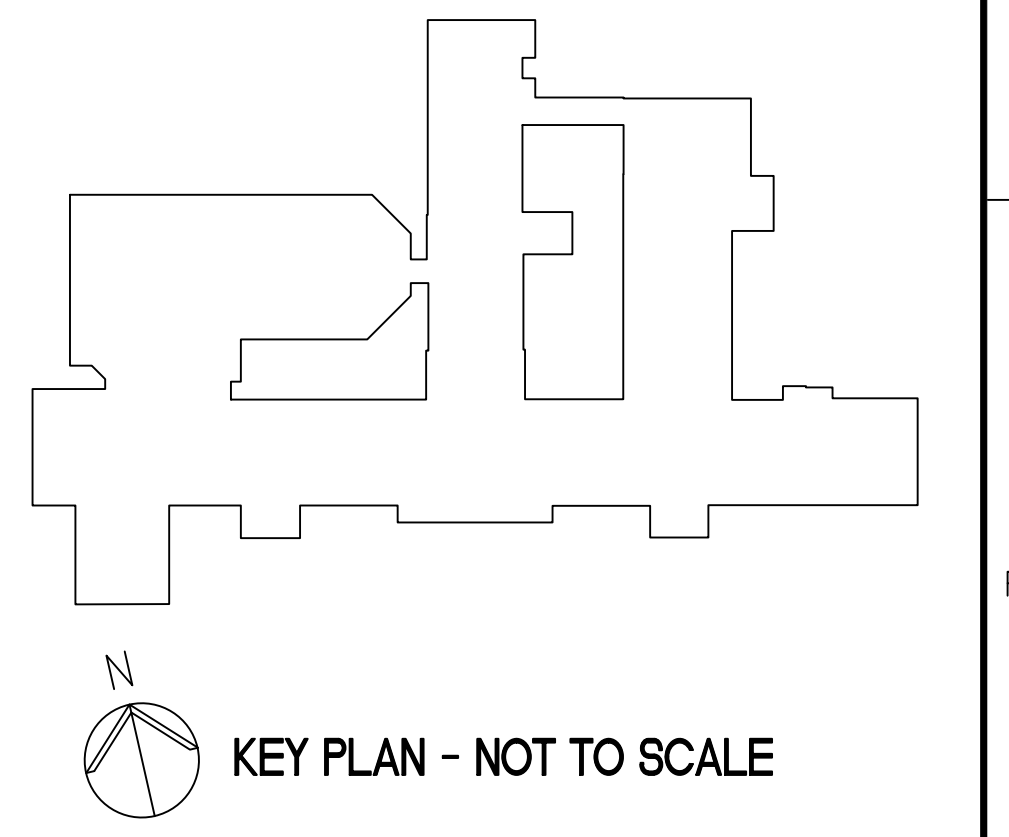

AMENDMENT #3 Revisions		5/20/14 Date		ARCHITECT/ENGINEERS: <b>PARADIGM</b> ENGINEERS AND CONSTRUCTORS 200 Envoy Circle #201, Louisville KY 40299 - PH: 502.339.8511 - www.paradigmusa.com		Drawing Title: <b>FIRE PROTECTION PLAN - SECOND FLOOR BUILDING 1</b>		Project Title: <b>FIRE SAFETY UPGRADES</b>		Project Number: <b>660-14-104</b> Building Number: <b>1</b>		Office of Construction and Facilities Management Department of Veterans Affairs	
Approved Project Director		Date: 12-19-2013		Checked: KLP		Drawn: JDM		Location: GEORGE E WAHLEN VAMC 500 Foothill Dr. SALT LAKE CITY, UT		Drawing Number: <b>1.FX102</b>			