


three inches = one foot  
one and one half inches = one foot  
one inch = one foot  
three quarters inch = one foot  
one half inch = one foot  
one quarter inch = one foot  
three eighths inch = one foot  
one eighth inch = one foot  
one eighth inch = one foot

- NOTES**
1. REFER TO SPECIFICATION SECTION 010000 FOR REQUIREMENTS REGARDING PRE-CONSTRUCTION INVESTIGATION PRIOR TO COMMENCEMENT OF WORK.
  2. REFER TO SPECIFICATION SECTION 283100 FOR FIRE ALARM PANELS.

- KEYED NOTES**
- ① REPLACE EXISTING SIEMENS MXL SERIES FIRE ALARM PANELS WITH NEW DIGITAL PANELS IN ROOMS GA08B, GB05B, GB05D, AND GC14C.


**LEGEND**

AREA APPLIED TO THIS PORTION OF PROJECT

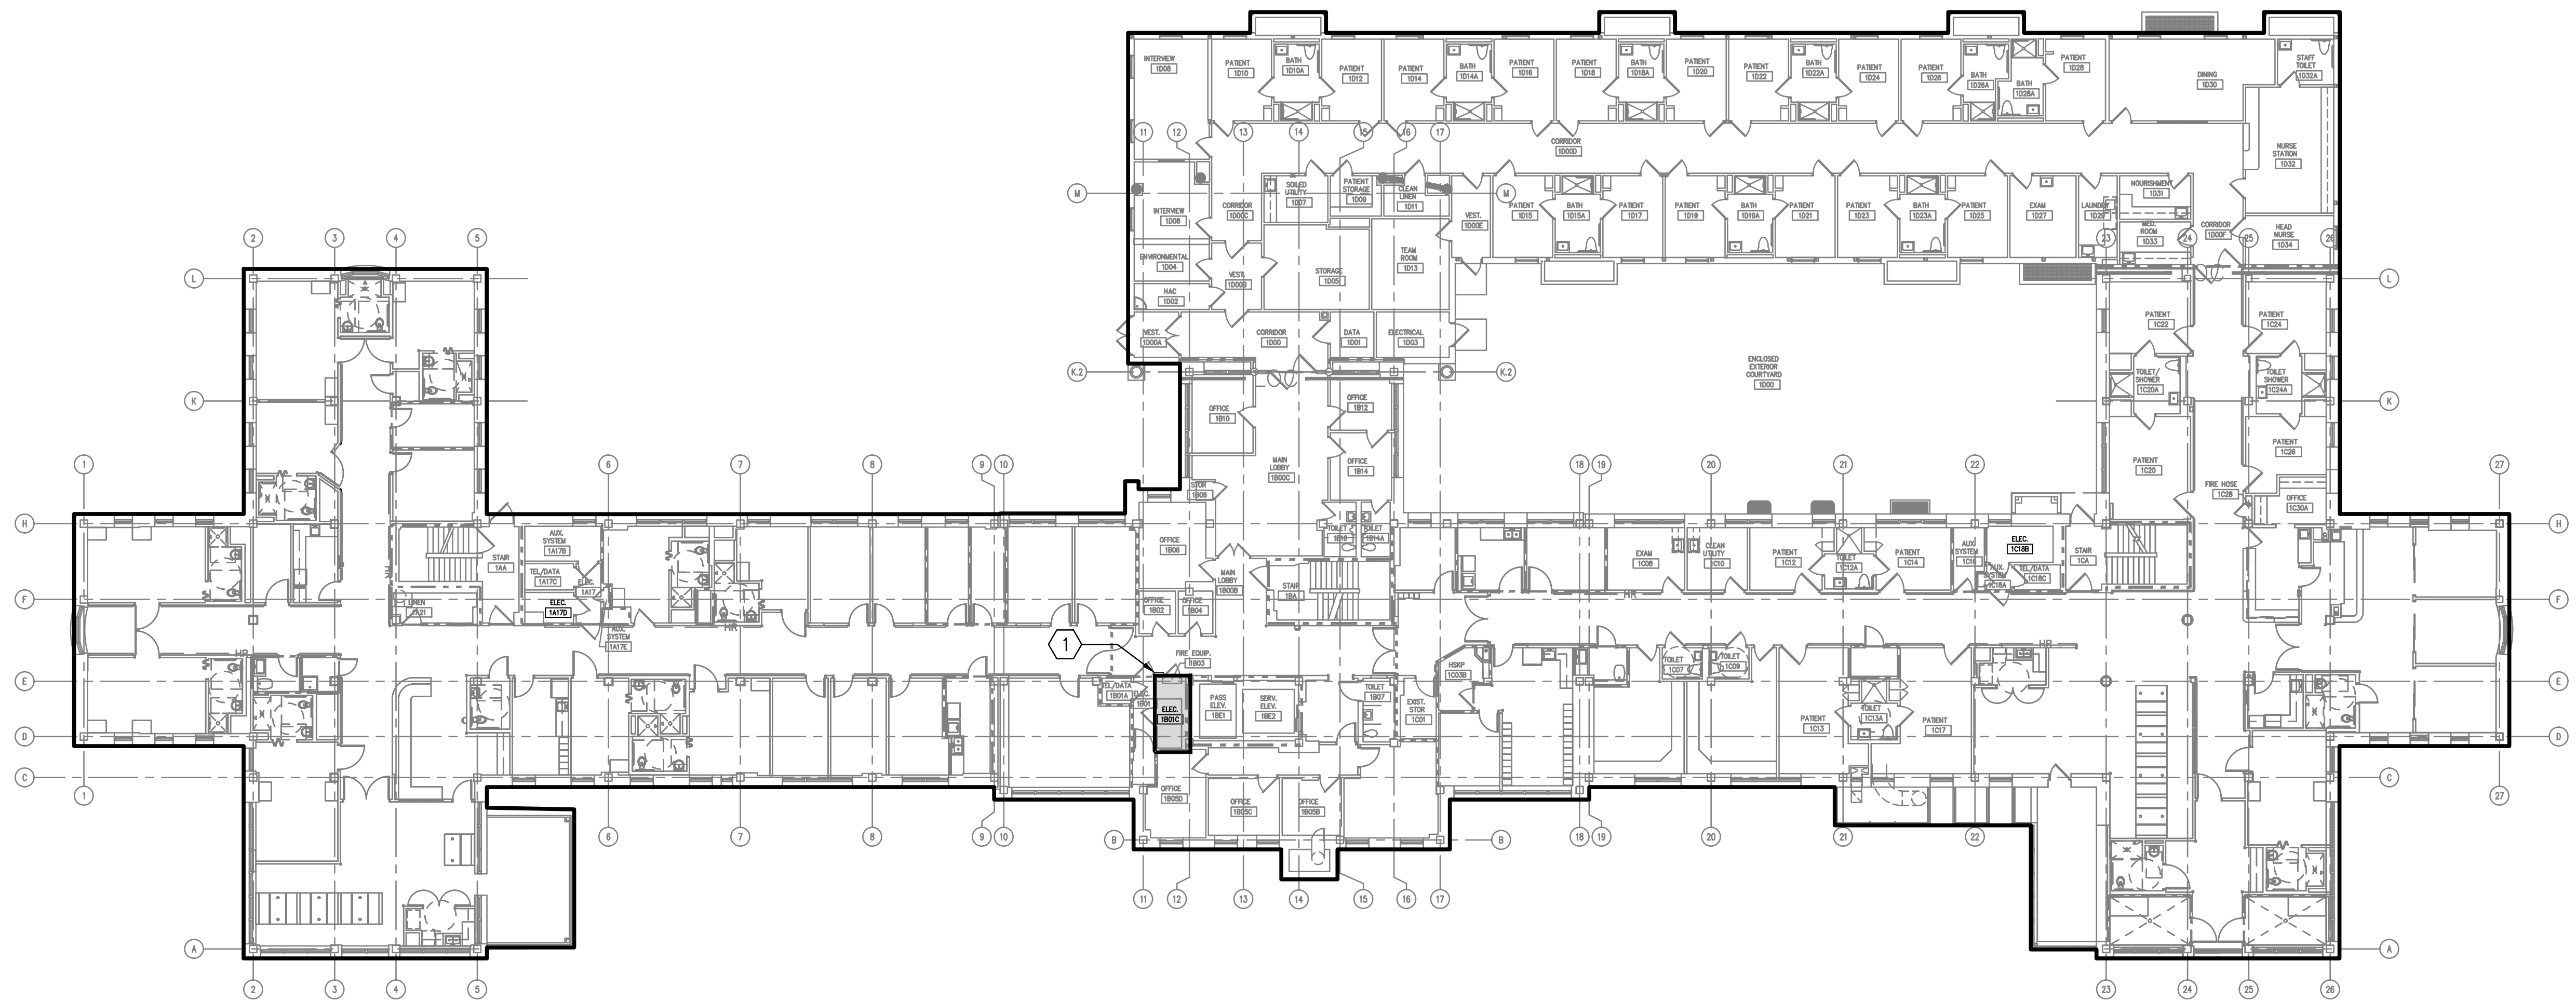

E1 FLOOR PLAN  
1/16" = 1'-0"

**GENERAL NOTE:**  
ALL EXISTING PIPING, DUCTWORK, SPRINKLERS, CONDUIT, LIGHTING OR OTHER CONSTRUCTION SHALL BE RELOCATED AS NECESSARY FOR ALL DEMOLITION AND INSTALLATION WORK.

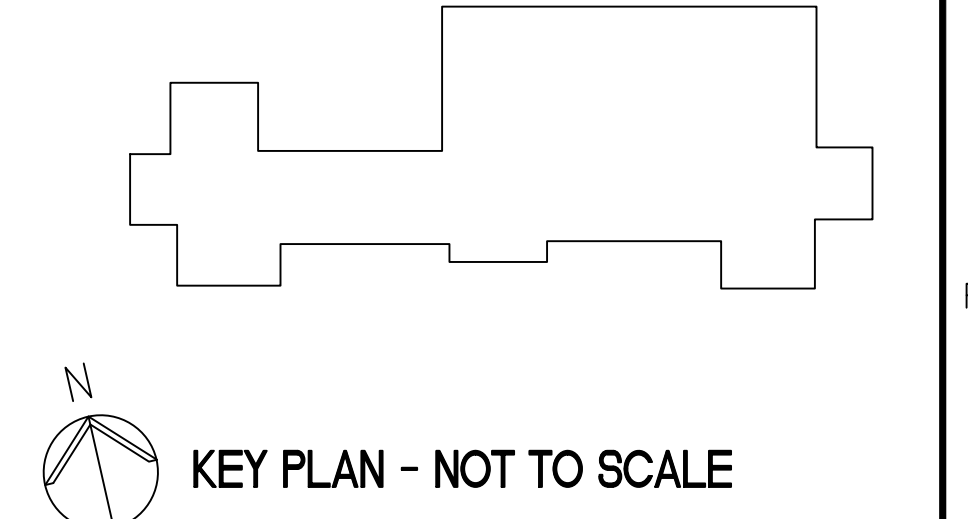

FULLY SPRINKLERED  
BID DOCUMENTS  
FOR CONSTRUCTION

Office of  
Construction  
and Facilities  
Management

Department of  
Veterans Affairs

AMENDMENT #3 Revisions		5/20/14 Date		ARCHITECT/ENGINEERS: <b>PARADIGM</b> ENGINEERS AND CONSTRUCTORS 200 Envoy Circle #201, Louisville KY 40299 - PH: 502.339.8511 - www.paradigmusa.com		Drawing Title: FIRE ALARM PLAN - FIRST FLOOR BUILDING 3		Project Title: FIRE SAFETY UPGRADES		Project Number: 660-14-104 Building Number: 3		Drawing Number: 3.FA101	
Approved Project Director		Date: 12-19-2013		Checked: KLP		Drawn: JDM		Location: GEORGE E WAHLEN VAMC 500 Foothill Dr. SALT LAKE CITY, UT		Date: 12-19-2013		Checked: KLP	