



three inches = one foot
one and one half inches = one foot
one inch = one foot
three quarters inch = one foot
one half inch = one foot
three eighths inch = one foot
one quarter inch = one foot
one eighth inch = one foot

- NOTES**
1. REFER TO SPECIFICATION SECTION 010000 FOR REQUIREMENTS REGARDING PRE-CONSTRUCTION INVESTIGATION PRIOR TO COMMENCEMENT OF WORK.
 2. REFER TO SPECIFICATION SECTION 283100 FOR REQUIREMENTS REGARDING FIRE ALARM INSTALLATION WORK.
- KEYED NOTES**
- 1 INSTALL NEW FIRE ALARM PANEL AND COMMAND CENTER CENTRAL TERMINAL IN THIS LOCATION. PROVIDE UPS POWER AND REQUIRED COMMUNICATIONS TO NEW FIRE ALARM PANELS IN BUILDINGS #1, #3 AND #14.

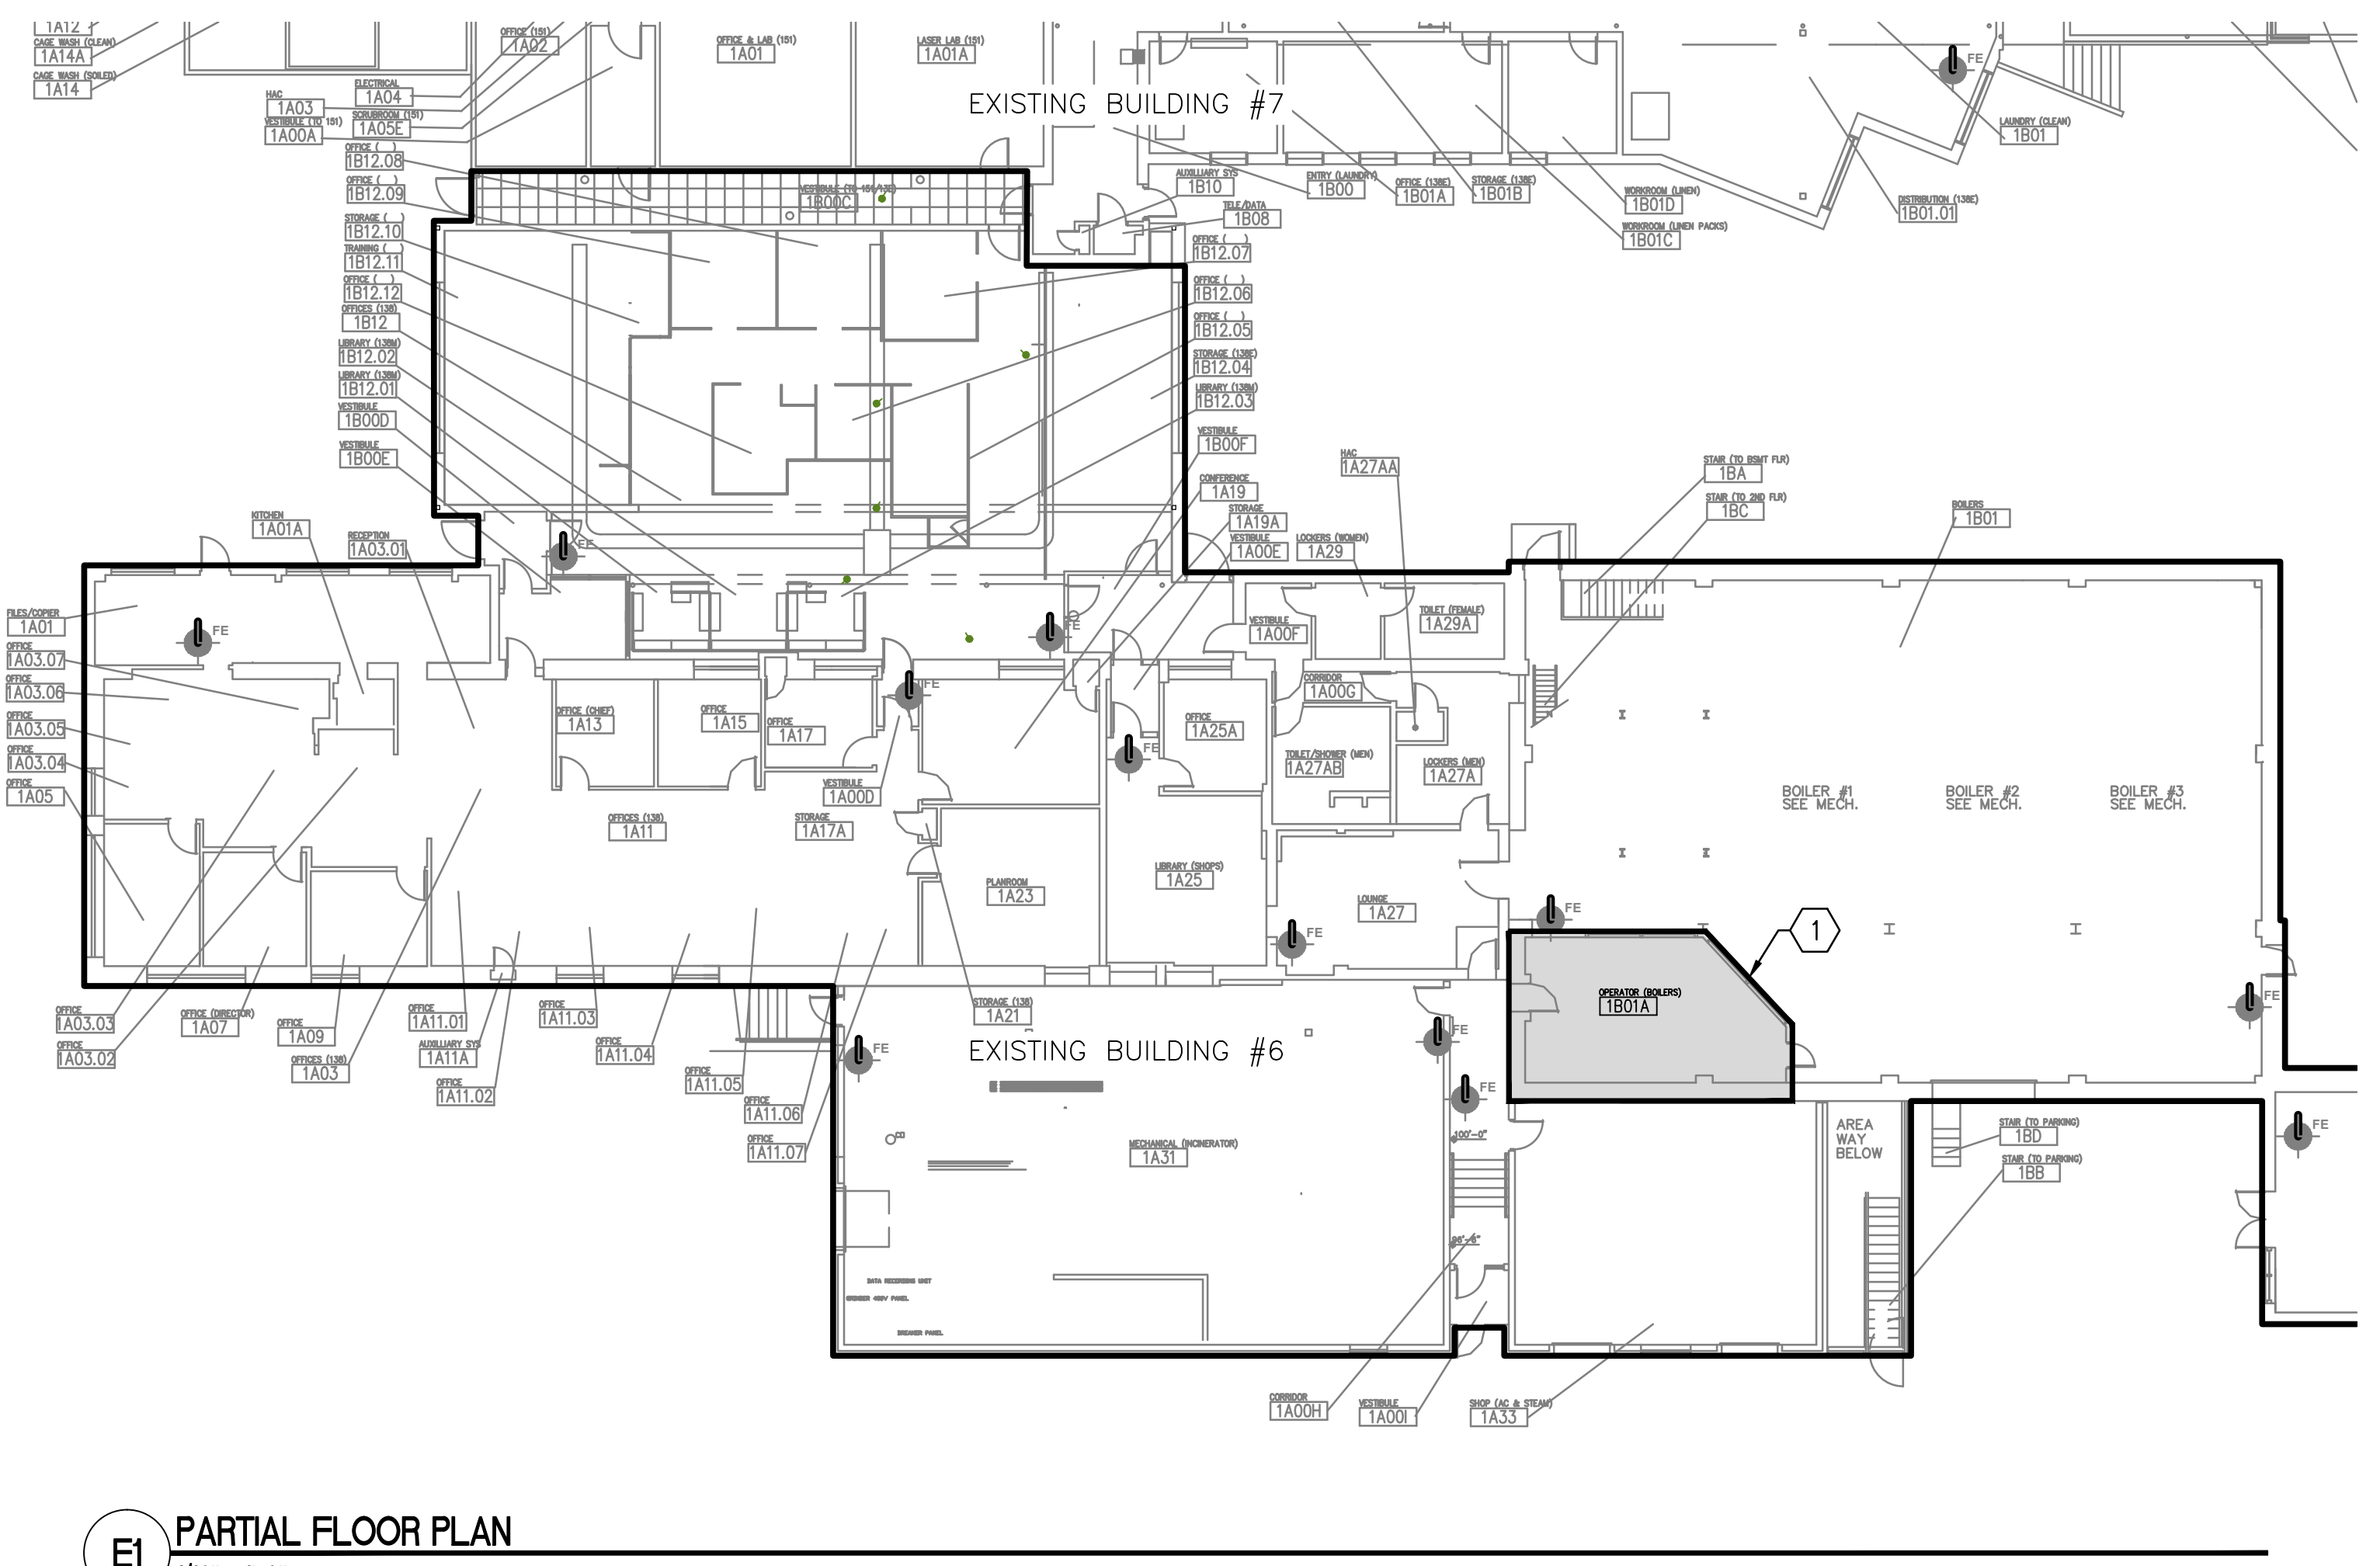

E1 PARTIAL FLOOR PLAN
1/16" = 1'-0"

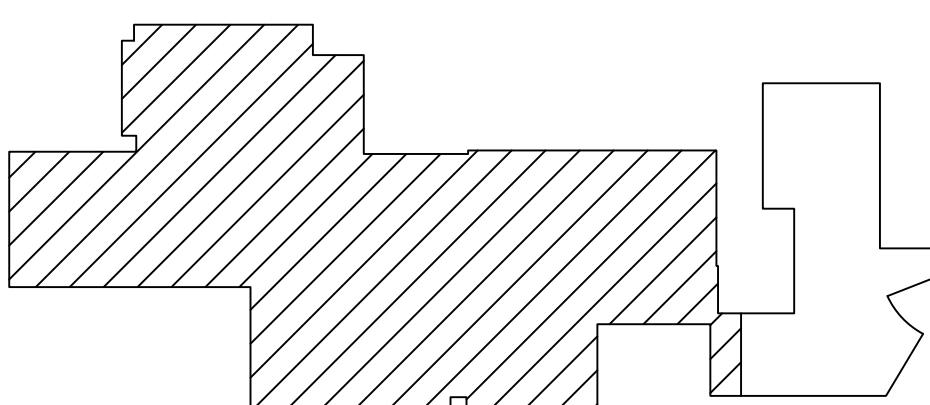

KEY PLAN - NOT TO SCALE

GENERAL NOTE:
ALL EXISTING PIPING, DUCTWORK, SPRINKLERS, CONDUIT, LIGHTING OR OTHER CONSTRUCTION SHALL BE RELOCATED AS NECESSARY FOR ALL DEMOLITION AND INSTALLATION WORK.

FULLY SPRINKLERED
BID DOCUMENTS
FOR CONSTRUCTION

AMENDMENT #3 Revisions		5/20/14 Date	ARCHITECT/ENGINEERS: PARADIGM ENGINEERS AND CONSTRUCTORS 200 Envoy Circle #201, Louisville KY 40299 - PH: 502.339.8511 - www.paradigmusa.com		Drawing Title: FIRE ALARM PLAN - FIRST FLOOR BUILDING 6		Project Title: FIRE SAFETY UPGRADES		Project Number: 660-14-104 Building Number: 6		Office of Construction and Facilities Management Department of Veterans Affairs	
					Approved Project Director		Location: GEORGE E WAHLEN VAMC 500 FOOTHILL DR. SALT LAKE CITY, UT		Drawing Number: 6.FA101			
							Date: 12-19-2013		Checked: KLP		Drawn: JDM	